



James R. Childers Architect, Inc.

45 South 4th Street Fort Smith, AR 72001 479-783-2480 www.childersarchitect.com

PROFESSIONAL SEAL

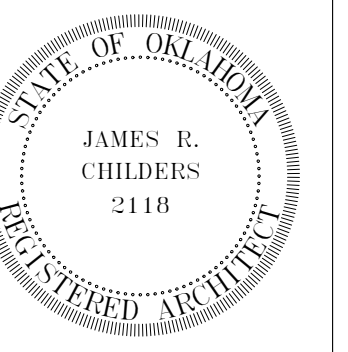

 CONSULTANT LOGO



CLIENT:



CHEROKEE NATION ENTERTAINMENT TAHLEQUAH CASINO TAHLEQUAH, OKLAHOMA

PROJECT PHASE:

BID PACKAGE 5

Table with 3 columns: #, DATE, DESCRIPTION. Includes a row for REVISIONS.

DATE: 05/03/18 JOB NUMBER: 17-06

SHEET NUMBER: ---

ABBREVIATIONS, SYMBOLS, & INDEX

SHEET INDEX

COVER ABBREVIATIONS, SYMBOLS, & INDEX

Table with 2 columns: LANDSCAPE and ELECTRICAL. Lists drawing titles and sheet numbers.

Table with 2 columns: ARCHITECTURE and FOODSERVICE. Lists drawing titles and sheet numbers.

Table with 2 columns: MECHANICAL and FIRE ALARM. Lists drawing titles and sheet numbers.

Table with 2 columns: PLUMBING and STRUCTURAL. Lists drawing titles and sheet numbers.

Table with 2 columns: MECHANICAL and FIRE ALARM. Lists drawing titles and sheet numbers.

Table with 2 columns: MECHANICAL and FIRE ALARM. Lists drawing titles and sheet numbers.

ANNOTATION SYMBOLS



WALL SECTION

 


BUILDING SECTION




ENLARGED AREA DETAIL


DRAWING TITLE




DOOR MARK

 

WINDOW MARK

 

ROOM MARK

 


EXTERIOR / INTERIOR ELEVATION



COLUMN GRID




 ELEVATION INDICATOR



ABBREVIATIONS

Large table of abbreviations and their corresponding full names, organized in columns.

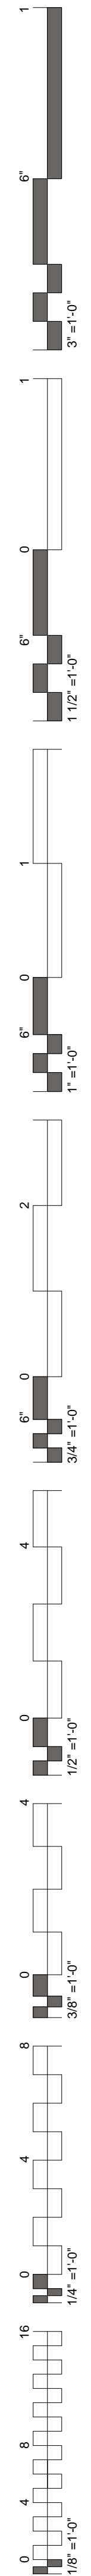




# CHEROKEE NATION ENTERTAINMENT TAHLEQUAH CASINO

## TAHLEQUAH, OKLAHOMA


### BID PACKAGE 5

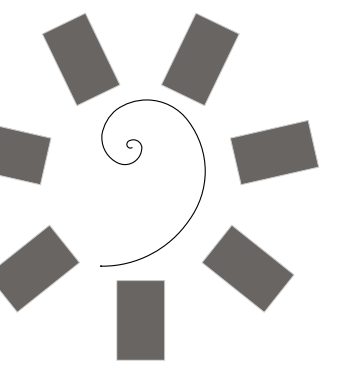

James R. Childers  
Architect, Inc.

45 South 4th Street  
Fort Smith, AR 72901  
479-783-2480  
www.childersarchitect.com

PROFESSIONAL SEAL:

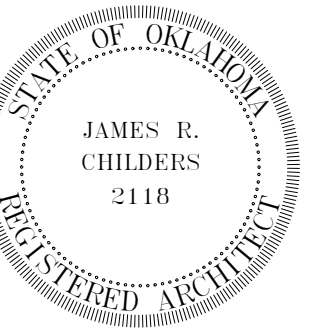

CONSULTANT LOGO:



CLIENT:



CHEROKEE NATION ENTERTAINMENT  
TAHLEQUAH CASINO  
TAHLEQUAH, OKLAHOMA

PROJECT PHASE:


BID PACKAGE 5

| REVISIONS |             |
|-----------|-------------|
| #         | DESCRIPTION |
|           |             |
|           |             |
DATE: 05/03/18 JOB NUMBER: 17-06

SHEET NUMBER: --

COVER

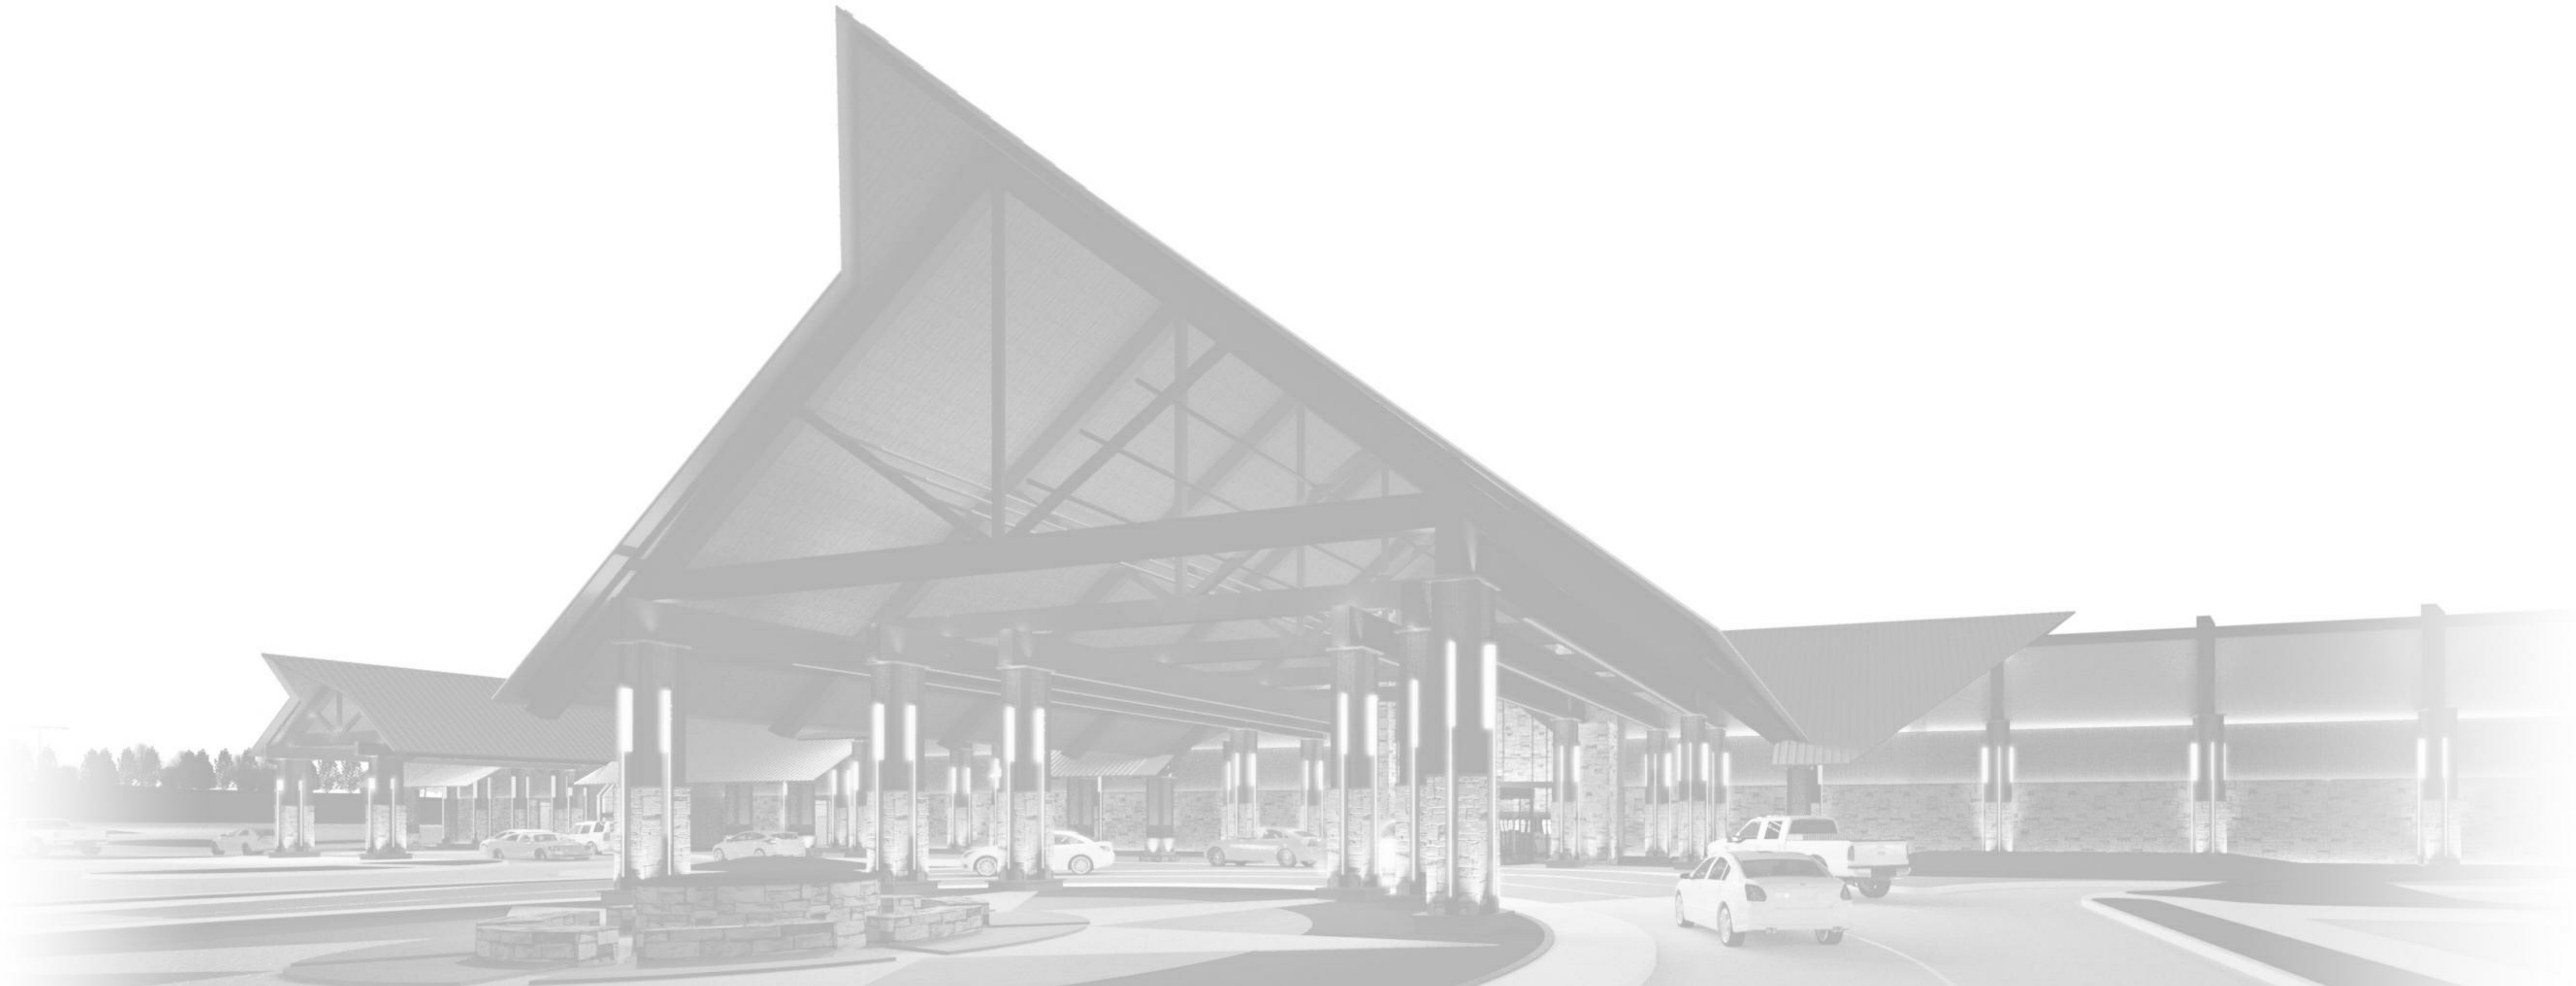

ADG, PC  
920 WEST MAIN  
OKLAHOMA CITY, OKLAHOMA 73106  
(405) 232-5700

CIVIL ENGINEER



GRAY ROCK CONSULTING, INC.  
5204 VILLAGE PARKWAY, SUITE 11  
ROGERS, ARKANSAS 72758  
(479) 268-6099

LANDSCAPE ARCHITECT



MSA ENGINEERING & CONSULTANTS  
370 E. WINDMILL LANE, SUITE 100  
LAS VEGAS, NEVADA 89123  
(702) 896-1100

MECHANICAL & ELECTRICAL ENGINEER




YORK ELECTRONIC SYSTEMS, INC.  
2900 WEST ALBANY  
BROKEN ARROW, OKLAHOMA 74012  
(918) 258-9675

LOW VOLTAGE SYSTEMS



TERP CONSULTING  
1604 SOUTH MARYLAND PARKWAY  
LAS VEGAS, NEVADA 89104  
(702) 953-9436

LIFE SAFETY

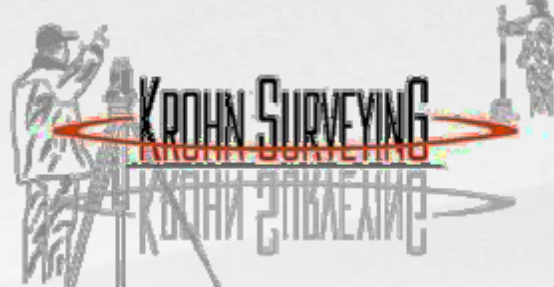

KROHN SURVEYING, INC.  
P.O. BOX 146  
LONE GROVE, OKLAHOMA 73443  
(580) 490-2422

SURVEYING



MYERS-BEATTY ENGINEERING, PLLC  
2411 FAYETTEVILLE ROAD, SUITE B  
VAN BUREN, ARKANSAS 72956  
(479) 474-4412

STRUCTURAL ENGINEER



HESMAN GROUP, LLC  
7645 EAST 83RD ST. SUITE 201  
TULSA, OKLAHOMA 74133-1256  
(918) 935-5036

FOOD SERVICE



BUILDING AND EARTH  
10828 E. NEWTON STREET, SUITE 111  
TULSA, OKLAHOMA 74116  
(918) 439-9005

GEOTECHNICAL ENGINEER



TEC TRAFFIC ENGINEERING CONSULTANT  
6931 SOUTH 66th EAST AVENUE  
TULSA, OKLAHOMA 74133  
(918) 481-8484

TRAFFIC ENGINEERING



CNF NATIVE AMERICAN SERVICES  
11810 SOUTH OSWEGO AVENUE  
TULSA, OKLAHOMA 74137  
(918) 645-5132

SIGNAGE

