


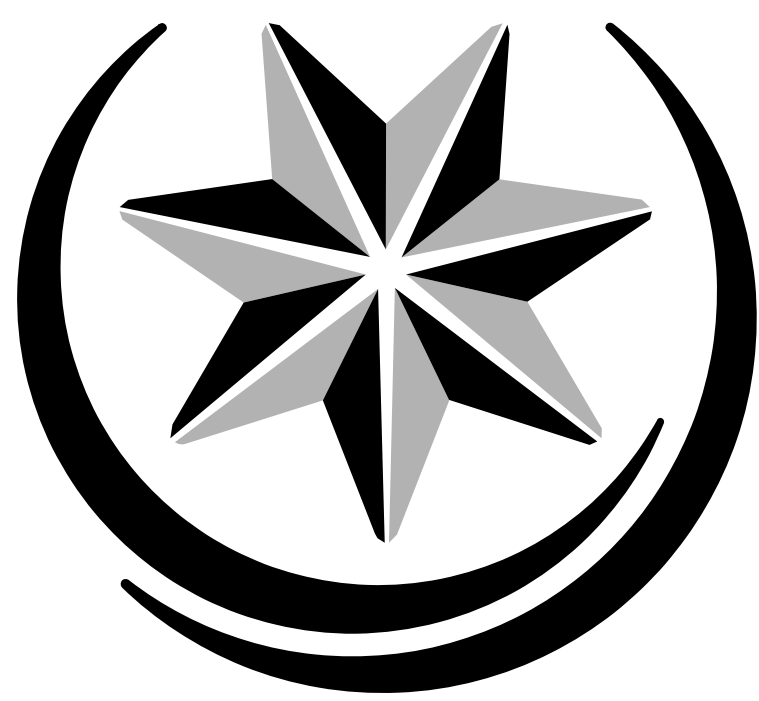

CHEROKEE NATION™
Entertainment

CNE - INTERCHANGE PARK TENANT IMPROVEMENT

10838 EAST MARSHALL STREET
TULSA, OKLAHOMA 74116

SHEET INDEX

SHEET NUMBER AND NAME
GENERAL

CS COVER SHEET
G001 GENERAL INFORMATION AND DEMOLITION PLAN

ARCHITECTURAL

ASP001 ARCHITECTURAL SPECIFICATIONS
ASP002 ARCHITECTURAL SPECIFICATIONS
A001 FRAME AND PARTITION TYPES, AND SCHEDULES
A101 OVERALL FLOOR PLAN AND FURNITURE PLAN
A102 FLOOR PLAN AND ENLARGED FLOOR PLANS
A103 FLOOR PLAN AND ENLARGED FLOOR PLANS
A120 REFLECTED CEILING PLAN AND DETAILS

SHEET NUMBER AND NAME
MECHANICAL


M101 OVERALL HVAC PLAN
M102 ENLARGED HVAC PLANS
M103 ENLARGED HVAC PLANS
M201 MECHANICAL DETAILS
M301 MECHANICAL SCHEDULES
MP600 MECHANICAL AND PLUMBING SPECIFICATIONS

SHEET NUMBER AND NAME
PLUMBING


P101 ENLARGED PLUMBING PLANS
P201 PLUMBING SCHEDULES

SHEET NUMBER AND NAME
ELECTRICAL

E100 GENERAL NOTES
E101 LIGHTING PLAN
E201 LIGHTING PLAN
E202 LIGHTING PLAN
E301 POWER PLAN
E302 POWER PLAN
E401 ONE LINE DIAGRAM & DETAILS
E501 PANEL BOARD SCHEDULES
E502 PANEL BOARD SCHEDULES
E601 DIVISION 26 SPECIFICATION

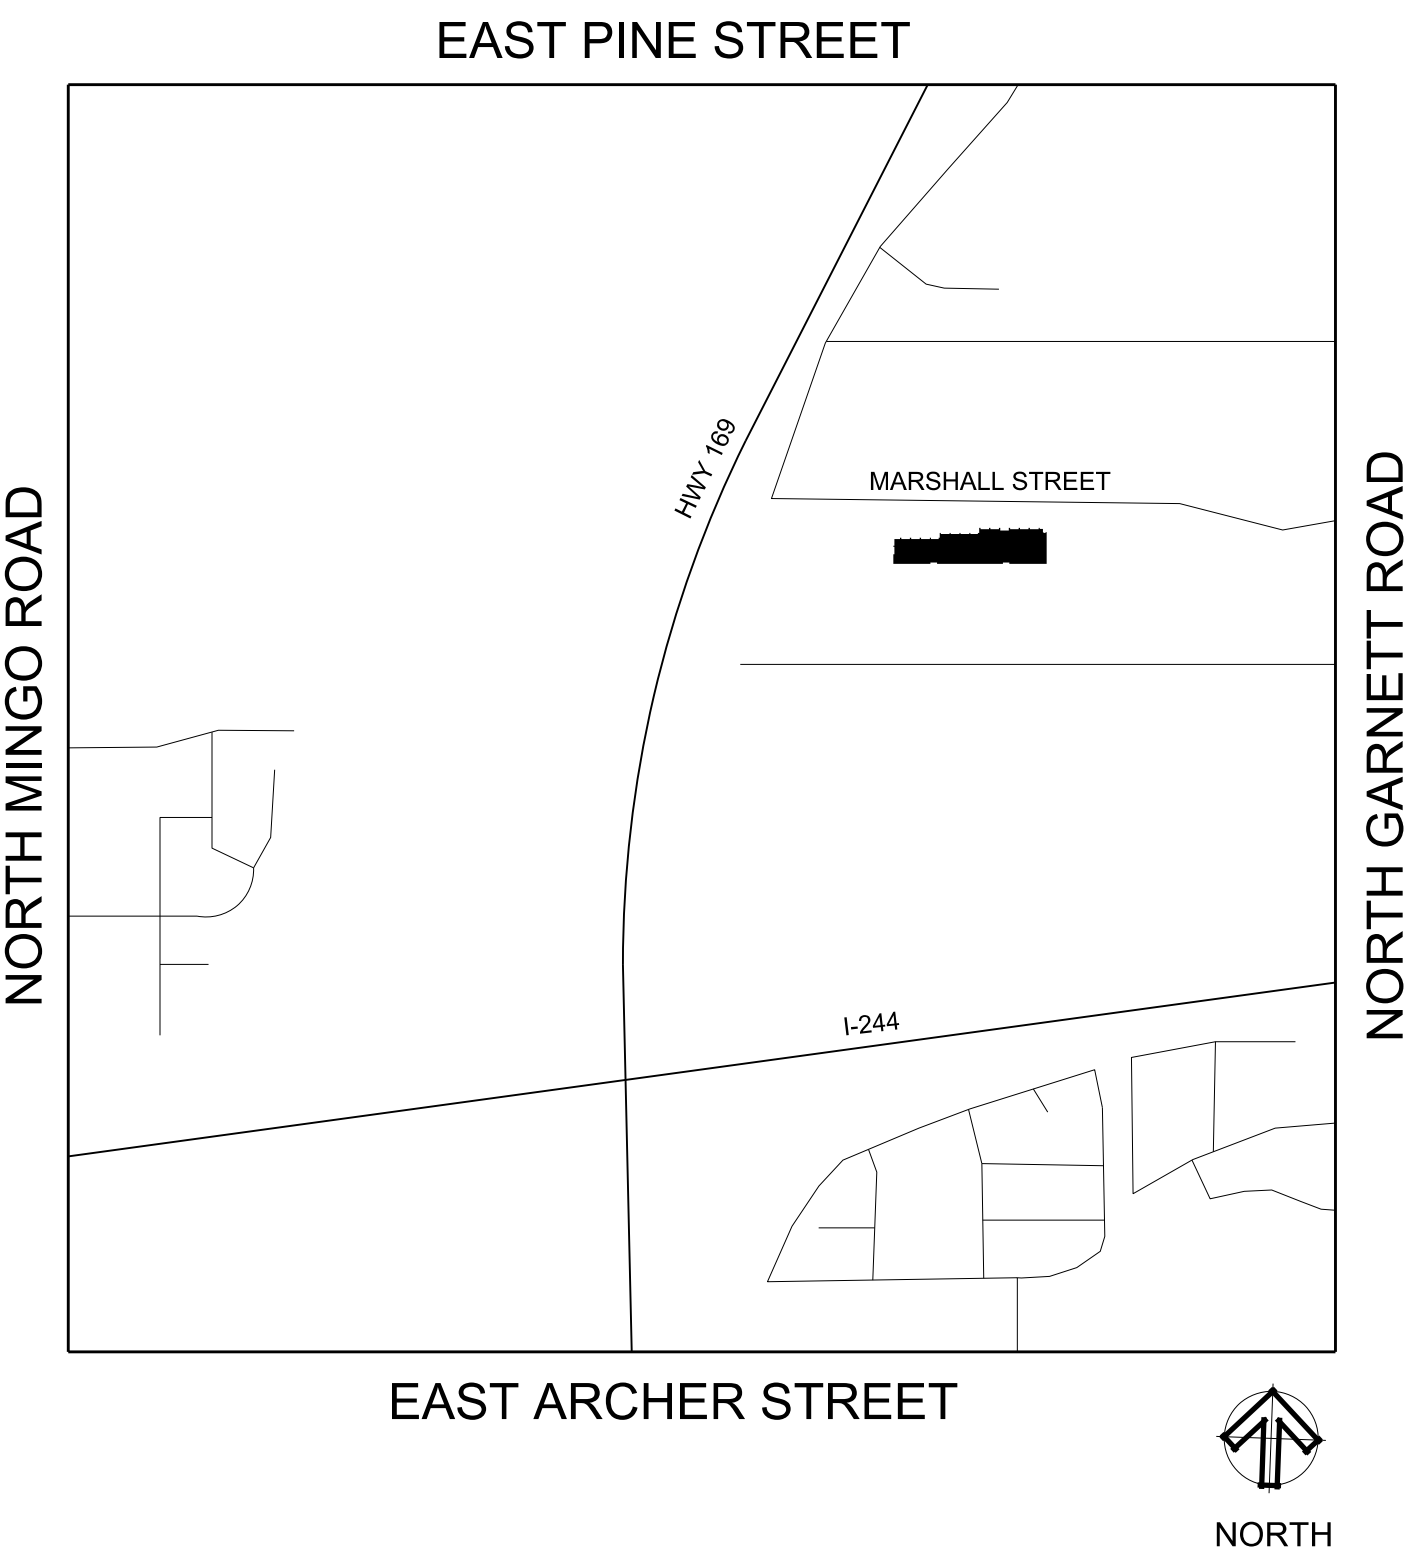

LOT ONE (1), BLOCK TWO (2), THE INTERCHANGE
BUSINESS PARK, AN ADDITION TO THE CITY OF
TULSA, TULSA COUNTY, STATE OF OKLAHOMA,
ACCORDING TO THE RECORDED PLAT THEREOF.

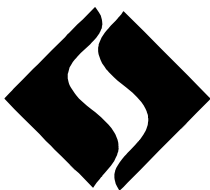

SELSERSCHAEFER
ARCHITECTS

1350 SOUTH BOULDER AVENUE SUITE 1100
TULSA, OKLAHOMA 74119-3295
918 587-2282 TELEFAX 918 587-2285
WEB PAGE: WWW.SELSERSCHAEFER.COM

MPW
ENGINEERING, LLC.
110 WEST 7TH STREET, SUITE 600
TULSA, OKLAHOMA 74119
918 582-4088 TELEFAX 918 582-4087



**CNE - INTERCHANGE PARK
TENANT IMPROVEMENT**

10838 EAST MARSHALL STREET
TULSA, OKLAHOMA 74116
R10063
01
11/05/10

SELSERSCHAEFER
ARCHITECTS
1350 SOUTH BOULDER AVENUE SUITE 1100
TULSA, OKLAHOMA 74119-3295
918 587-2282 TELEFAX 918 587-2285
WEB PAGE: WWW.SELSERSCHAEFER.COM