




SELSCHER SCHAEFER
ARCHITECTS & INC.
1336 S. BOULDER AVENUE
SUITE 1100
TULSA, OK 74119-5204
918.587.2282
FAX 918.587.2285
SELSCHERSCHAEFER.COM

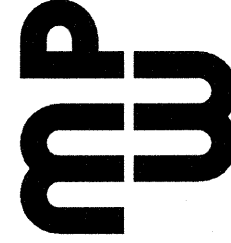


MPW
ENGINEERING, LLC
1336 S. BOULDER AVENUE
SUITE 1100
TULSA, OK 74119-5204
(918) 587-4668
FAX 918.587.2285
MPW@MPW-OK.COM
2010.0001



CNE INTERCHANGE
PARK TENANT
IMPROVEMENT
10388 EAST
ANADARKO AVENUE
TULSA, OK 74116

REVISION
01
DATE
11.05.10
PROJECT NO.
R10.053
DRAWN BY
VS/ODM
CHECKED BY
BRS
SHEET TITLE
ENLARGED POWER
PLAN

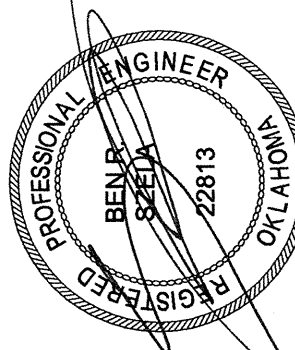

E302
11-4-10

© 2010 Selscher Schaefer Architects, Inc.

NO CONNECTION OF ANY KIND TO BE MADE BETWEEN MEMBERS OR JOIST BRIDGING

REF. MANUFACTURER'S "GENERAL INFORMATION" FOR DESIGN BOLT TORQUE

EXTEND POWER POLE 3" MIN ABOVE CL OF UNISTRUT

12" PVC SLEEVE

2-1/2" UNISTRUT STRAP FIRMLY CLAMPED TO CONDUIT

CONTRACTOR SHALL ATTACH POWER POLE PER MANUFACTURER RECOMMENDATIONS

PROVIDE 1/4" BOLT AND 1/4" FENDER WASHER TYP

UNISTRUT

PROVIDE UNISTRUT PLI026 ANGLE FITTING ON EQUAL

INSET: MOUNT UNISTRUT ABOVE BOTTOM CHORD OF BAR JOIST. UNISTRUT SHALL BE SECURED TO SPAN JOISTS. SECURE TO BOTTOM CHORD OF BAR JOIST.



INSET: CLAMP A 12" LENGTH OF PVC CONDUIT AND RUN THE POWER POLE THROUGH ITS CENTER

2-1/2" PVC CONDUIT

PROVIDE 1-1/4" LOCK WASHER AND NUT, TYP

INSET: BOTTOM CHORD OF BAR JOIST

EACH POWER POLE TO HAVE (3) 20 AMP CIRCUITS, DATA AND PHONE 16 FEET APART.

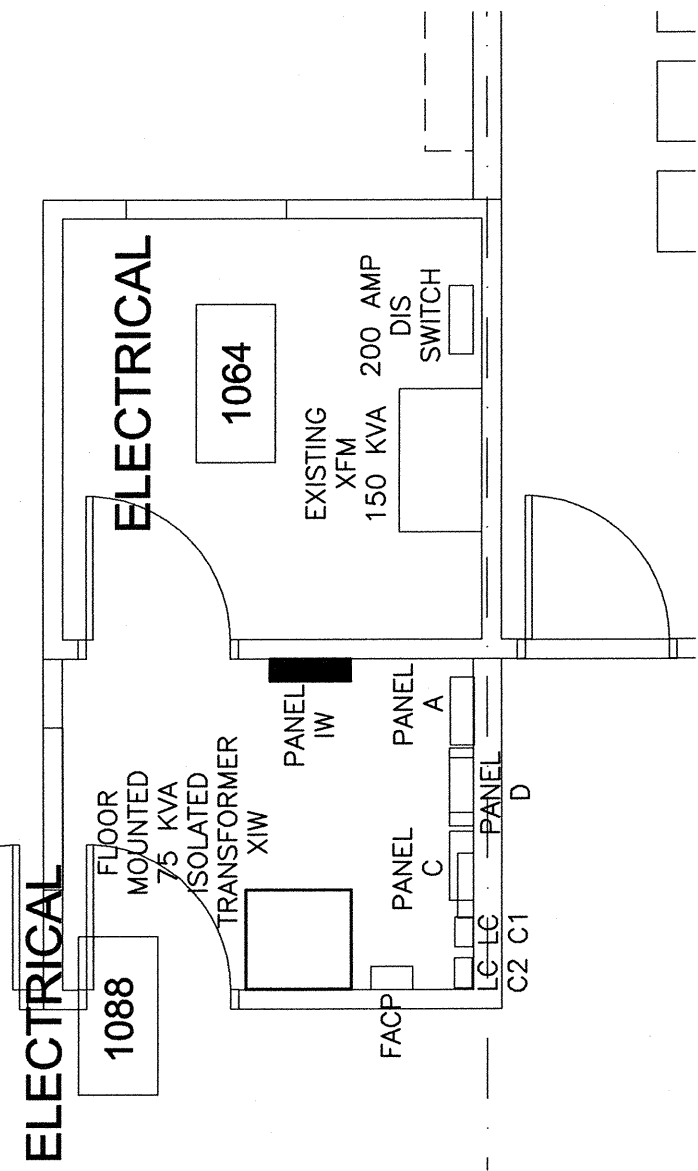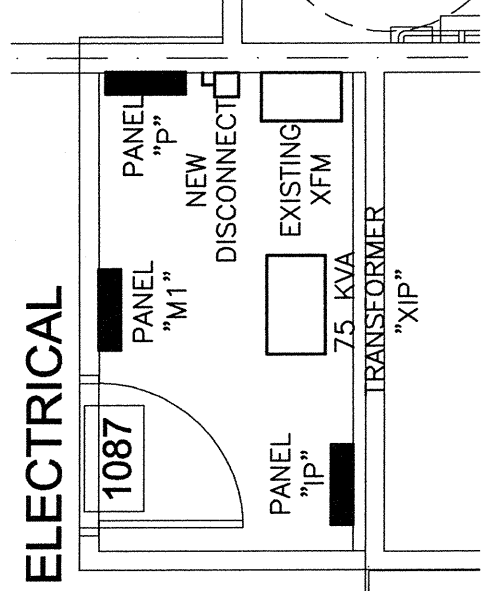

- (26.101)** ELECTRICAL CONTRACTOR TO PROVIDE POWER FOR SMOKE / FIRE DAMPER COORDINATE WITH MECHANICAL CONTRACTOR.
- (26.102)** ELECTRICAL CONTRACTOR SHALL REFER TO ENLARGE ELECTRICAL ROOM FOR ELECTRICAL EQUIPMENT DETAIL AND LOCATION.
- (26.103)** ELECTRICAL CONTRACTOR TO PROVIDE AND INSTALL THREE CHANNELS POWER POLE TO ACCOMMODATE (3)-20 AMP BRANCH CIRCUITS, (1) DATA AND (1) PHONE OUTLETS. REFER TO POWER POLE CONNECTION FOR MOUNTING DETAILS
- (26.104)** ELECTRICAL CONTRACTOR TO PROVIDE AND INSTALL FOR THE DATA RACKS THE FOLLOWING PLUGS - DATA ROOM 1064.
(4) - NEMA 20AMP QUAD OUTLETS
(8) - L5-30 TWIST LOCKS
(4) - L6-30 TWIST LOCKS
COORDINATE WITH OWNER FOR ADDITIONAL ELECTRICAL REQUIREMENTS.
- (26.105)** ELECTRICAL CONTRACTOR TO PROVIDE AND INSTALL FOR THE DATA RACKS THE FOLLOWING PLUGS - DATA ROOM 1084.
(2) - NEMA 20AMP QUAD OUTLETS.
(COORDINATE WITH OWNER FOR ADDITIONAL ELECTRICAL REQUIREMENTS.

D4 POWER POLE CONNECTION


D2 ENLARGE ELECTRICAL ROOM

D1 KEYNOTES

NTS

1/4"=1'-0"

NTS

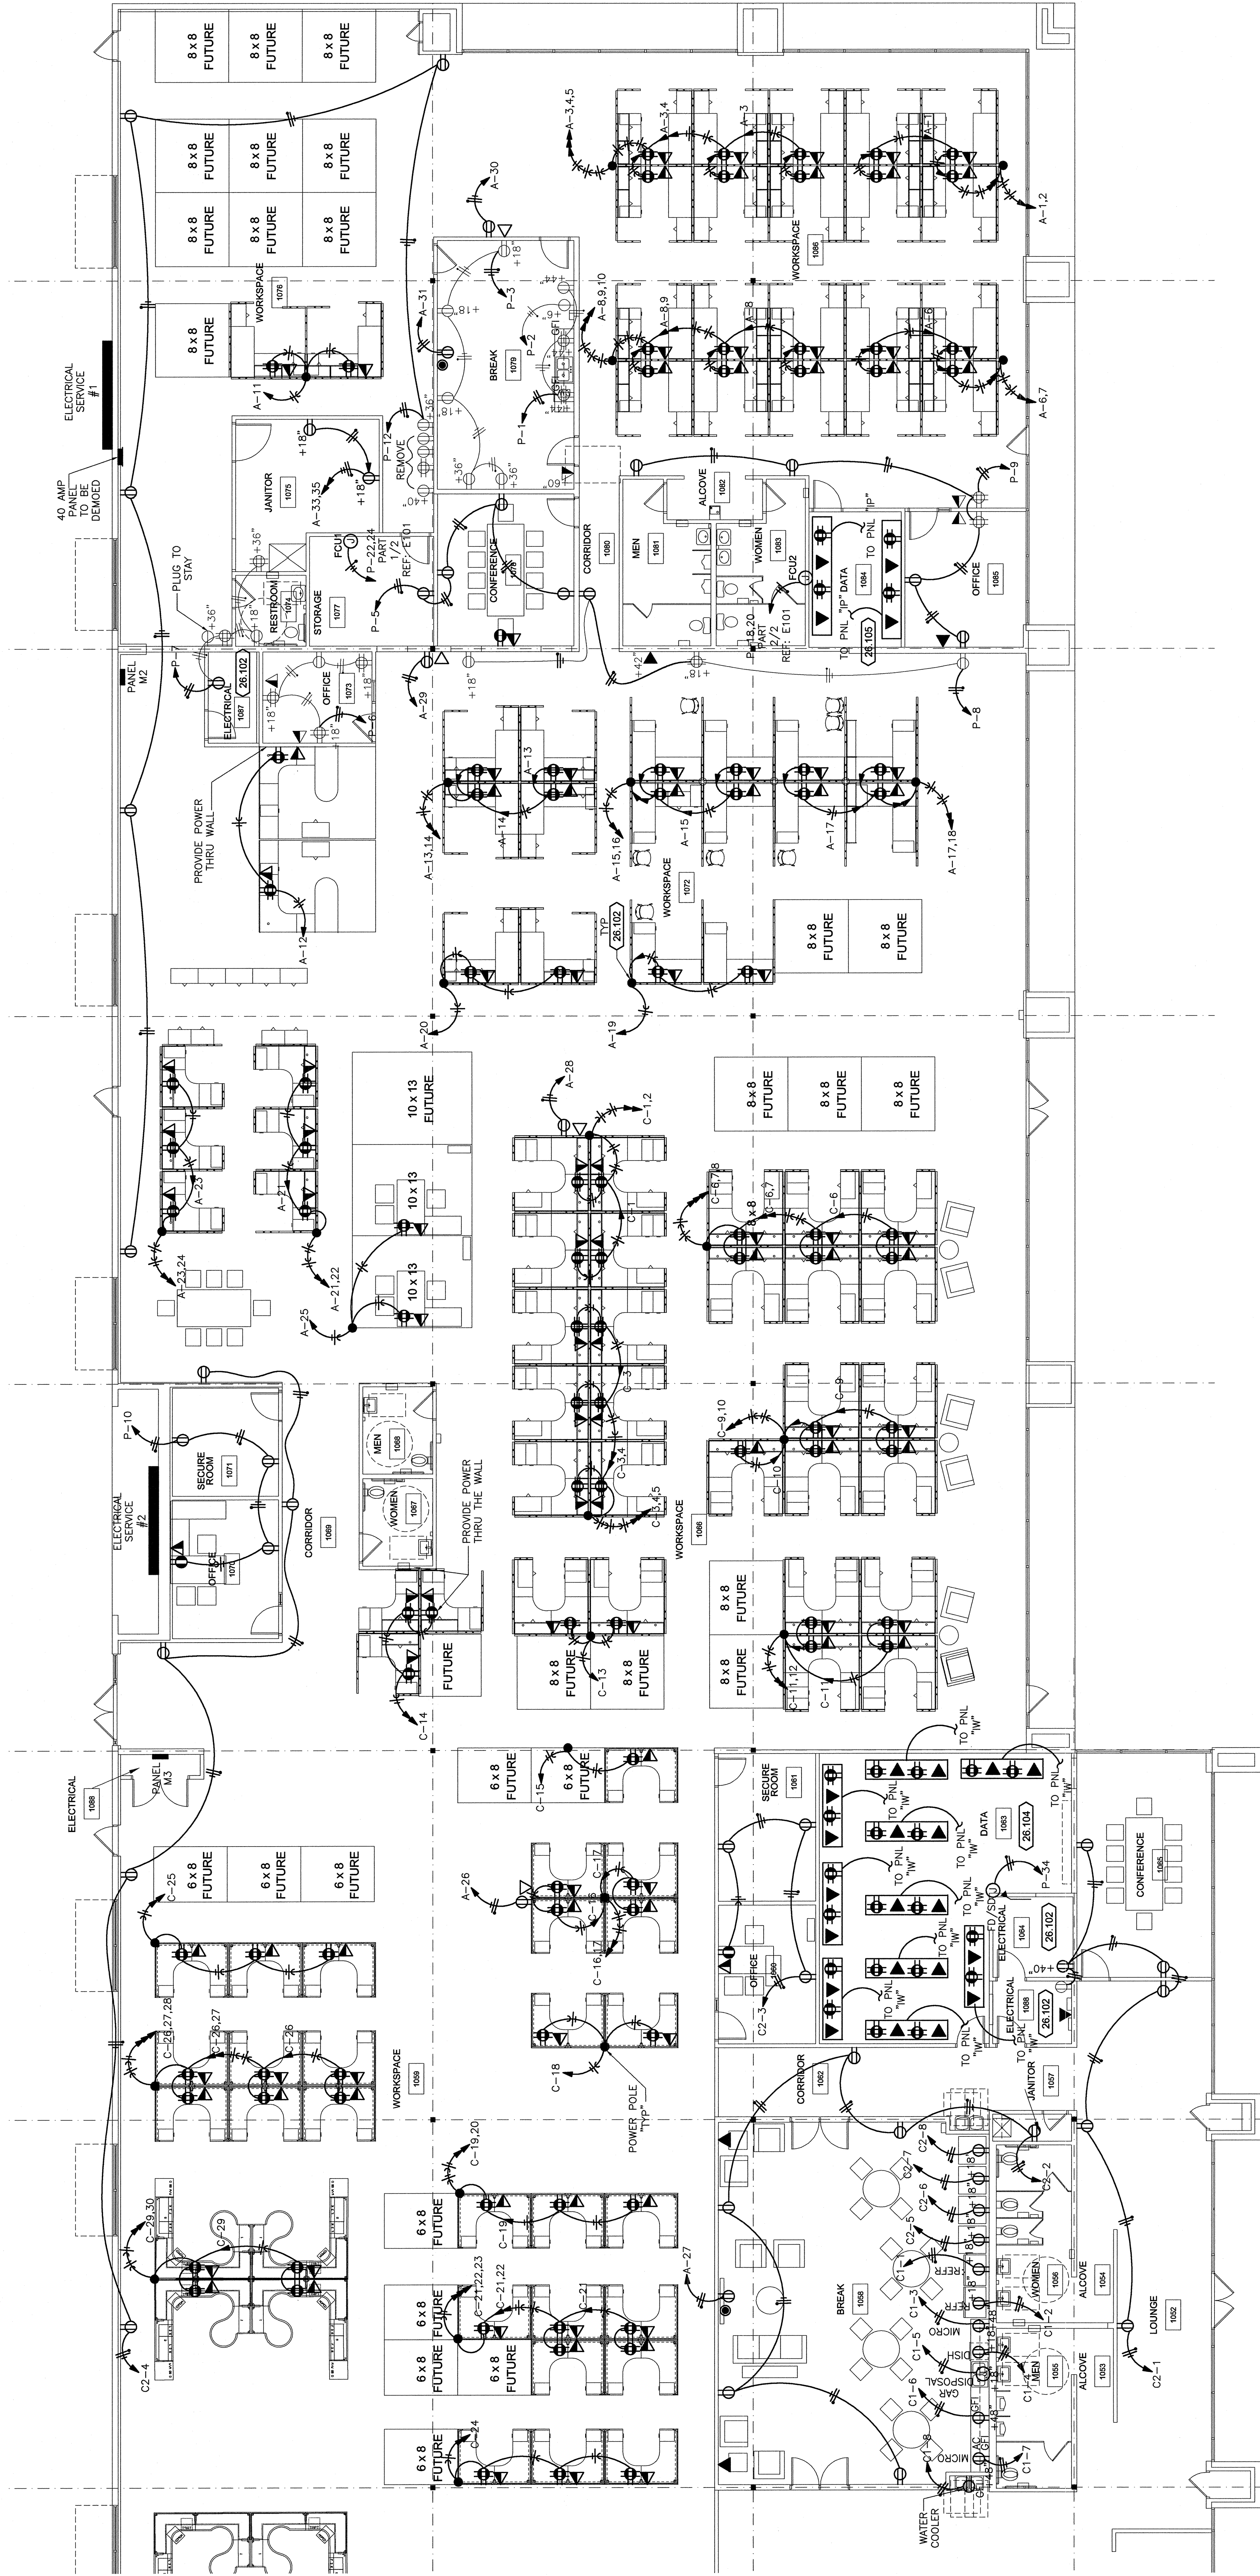

A1 WEST POWER PLAN

1/8"=1'-0"



NORTH