



9/26/2024 11:24:35 AM

A
B
C
D
E

CAMERA/ACCESS CONTROL PLAN

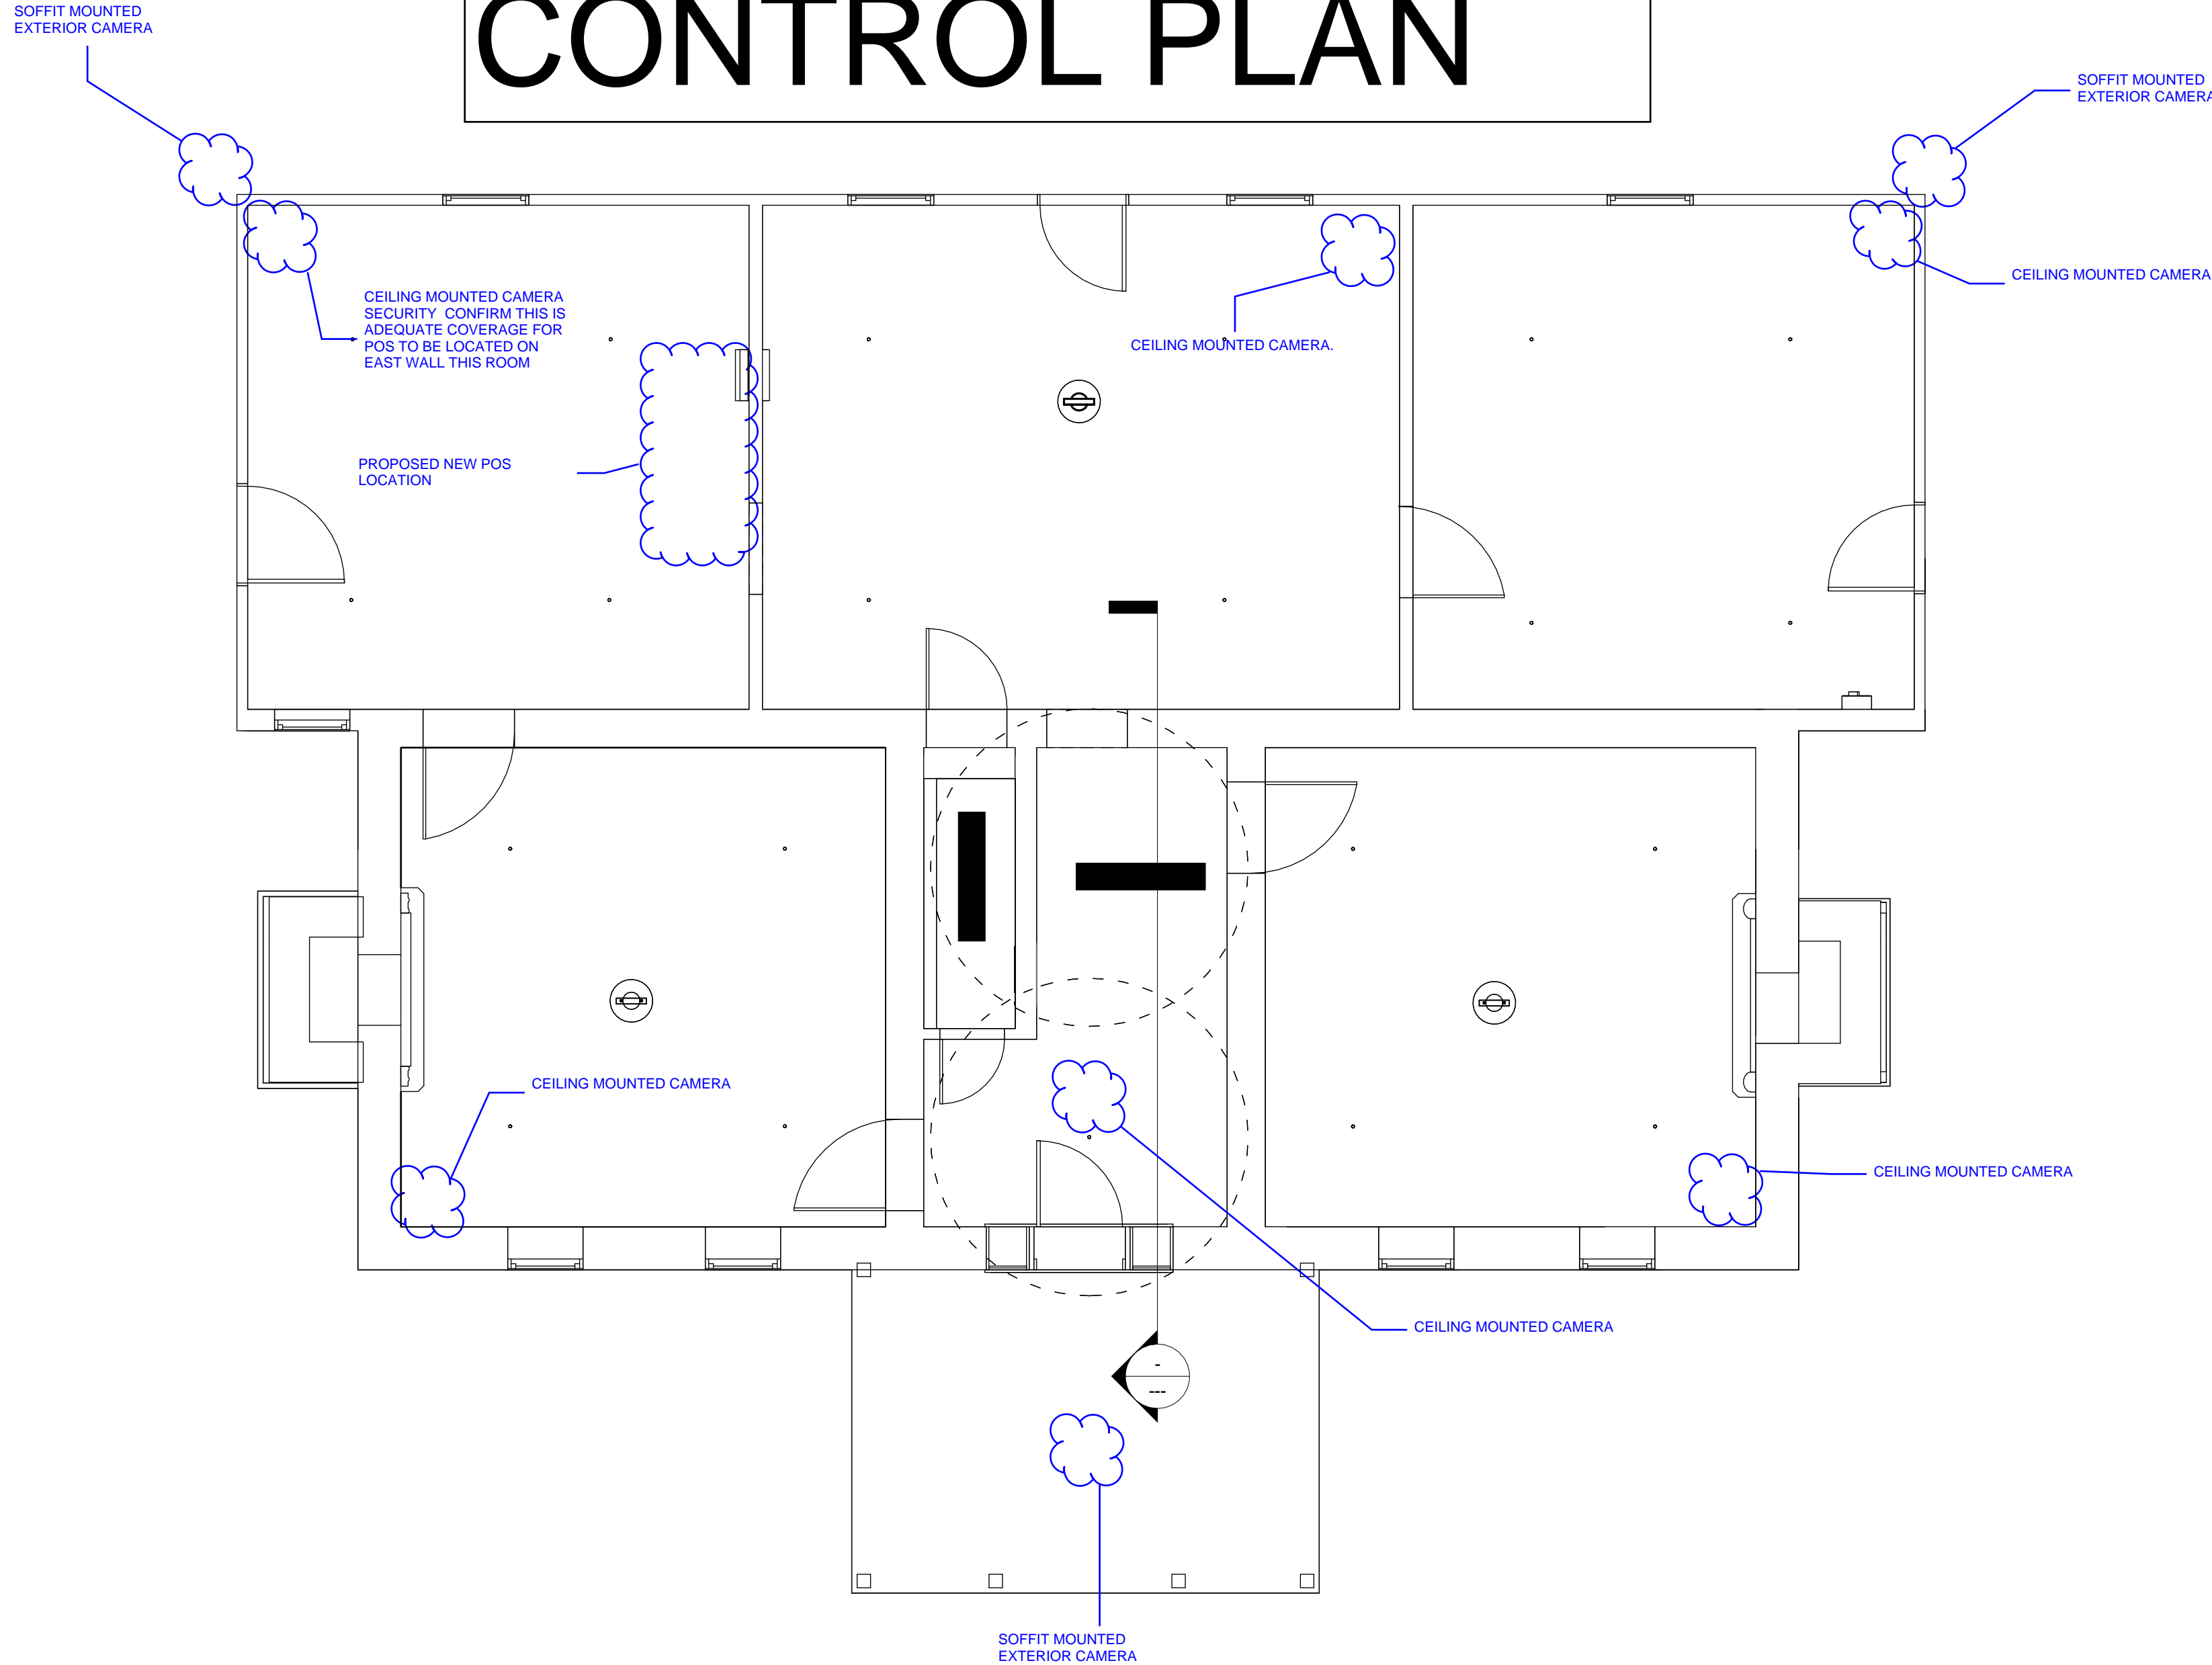

1 LEVEL 1 LIGHTING PLAN
SCALE: 1/4" = 1'-0"

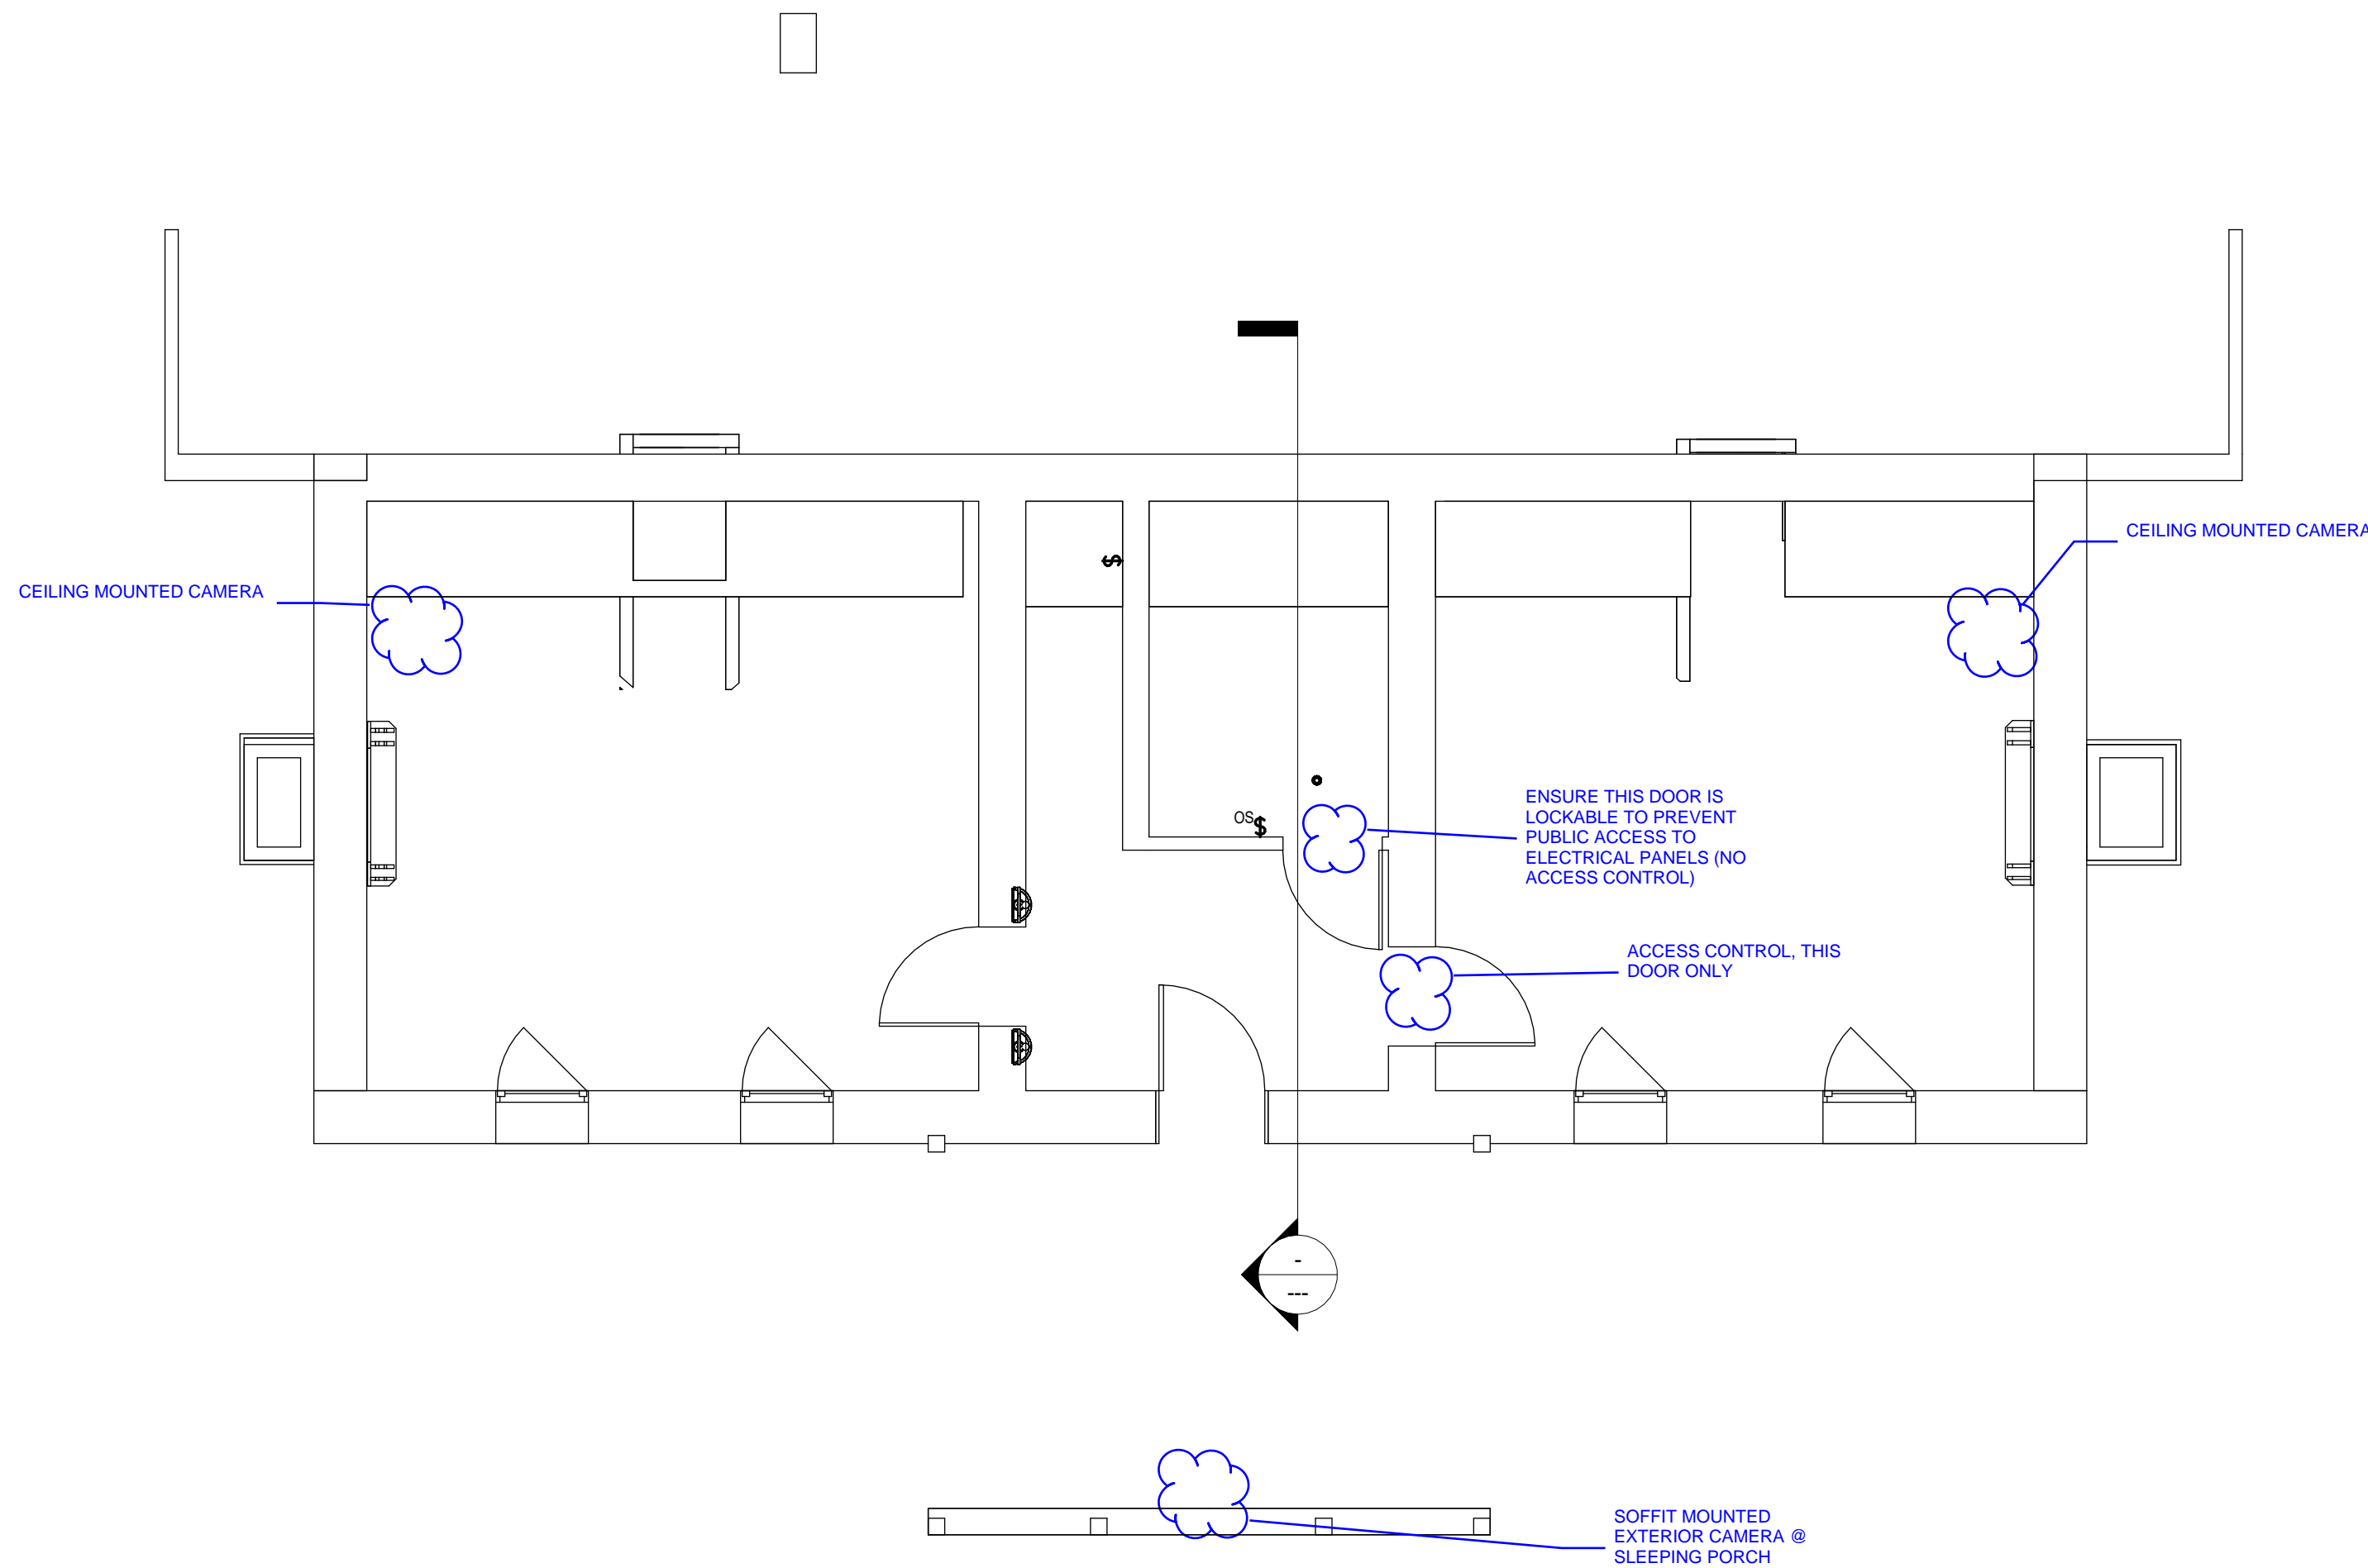

2 Lighting Ceiling Plan-02
SCALE: 1/4" = 1'-0"



EDMONDSON DESIGN GROUP, LLC.
5200 South Yale, Suite 406
Tulsa, Oklahoma 74135
Tele: 918-576-6700

This document, and the ideas and designs incorporated herein, as an instrument of professional service, is the property of EDMONSON DESIGN GROUP, LLC, and is not to be used, in whole or in part, for any other project, without the written authorization of EDMONSON DESIGN GROUP, LLC.

CLIENT
**CHEROKEE NATION
CULTURAL AND
ECONOMIC
DEVELOPMENT LLC.**

PROJECT
**WILL ROGERS
BIRTHPLACE
RESTORATION**

CONSULTANTS

ARCHITECTURE & INTERIOR DESIGN
Edmondson Design Group LLC
5200 South Yale Avenue, Suite 406
Tulsa, Oklahoma 74135
T: (918) 576-6700

STRUCTURAL ENGINEER
Snowden Engineering Inc.
8128 South 63rd Street
Tulsa, Oklahoma 74133
T: (918) 252-4557

MECHANICAL, ELECTRICAL, PLUMBING ENGINEER.
Phillips + Gomez
15 West 6th Street, Suite 2510
Tulsa, Oklahoma 74119
T: (918) 564-0102

FIRE PROTECTION DESIGN
Western Fire Protection Inc.
8320 South 89th West Ave.
Tulsa, Oklahoma 74131
T: (918) 227-3893

KEY PLAN

SHEET TITLE
LIGHTING PLAN

ISSUE FOR BIDDING AND OWNERS USE

PROJECT NO: 111-056.23
DESIGNED BY: Author
CHECKED BY: Checker
DATE: 9/26/2024

E201
SCALE: 1/4" = 1'-0"

