


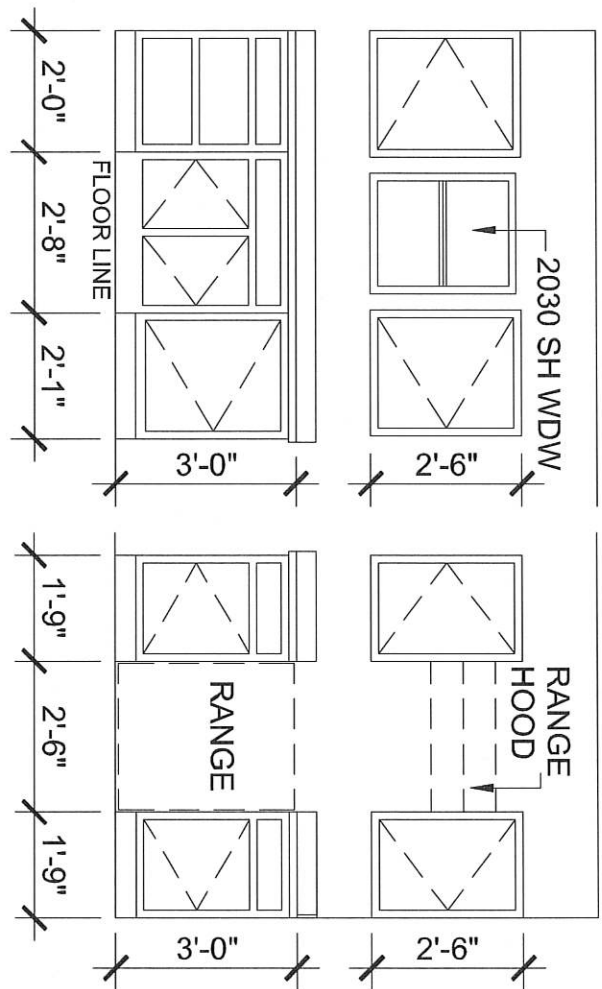

HVAC CLOSET FRAMING
SCALE 1"=1/2"=1'

CABINET ELEVATION
SCALE 1"=1/2"=1'



ENGINEER
KAS Gales Company
Consulting Engineers
18772 Harmon Road
Fayetteville, AR 72704
Wk. 479.361.9977 Cell 479.422.0763
Email: carl.d.gales@gmail.com


Cherokee Nation
2 Bedroom ADA Left Garage
Cabinet Elev/HVAC
1486 Square Feet

CLIENT: Cherokee Nation
Housing Authority

DESIGNED BY: .	APPROVED BY: C/DG
DRAWN BY: MDD	DATE PREPARED: June 2022

A103
SHEET NO.

SHEET NO.

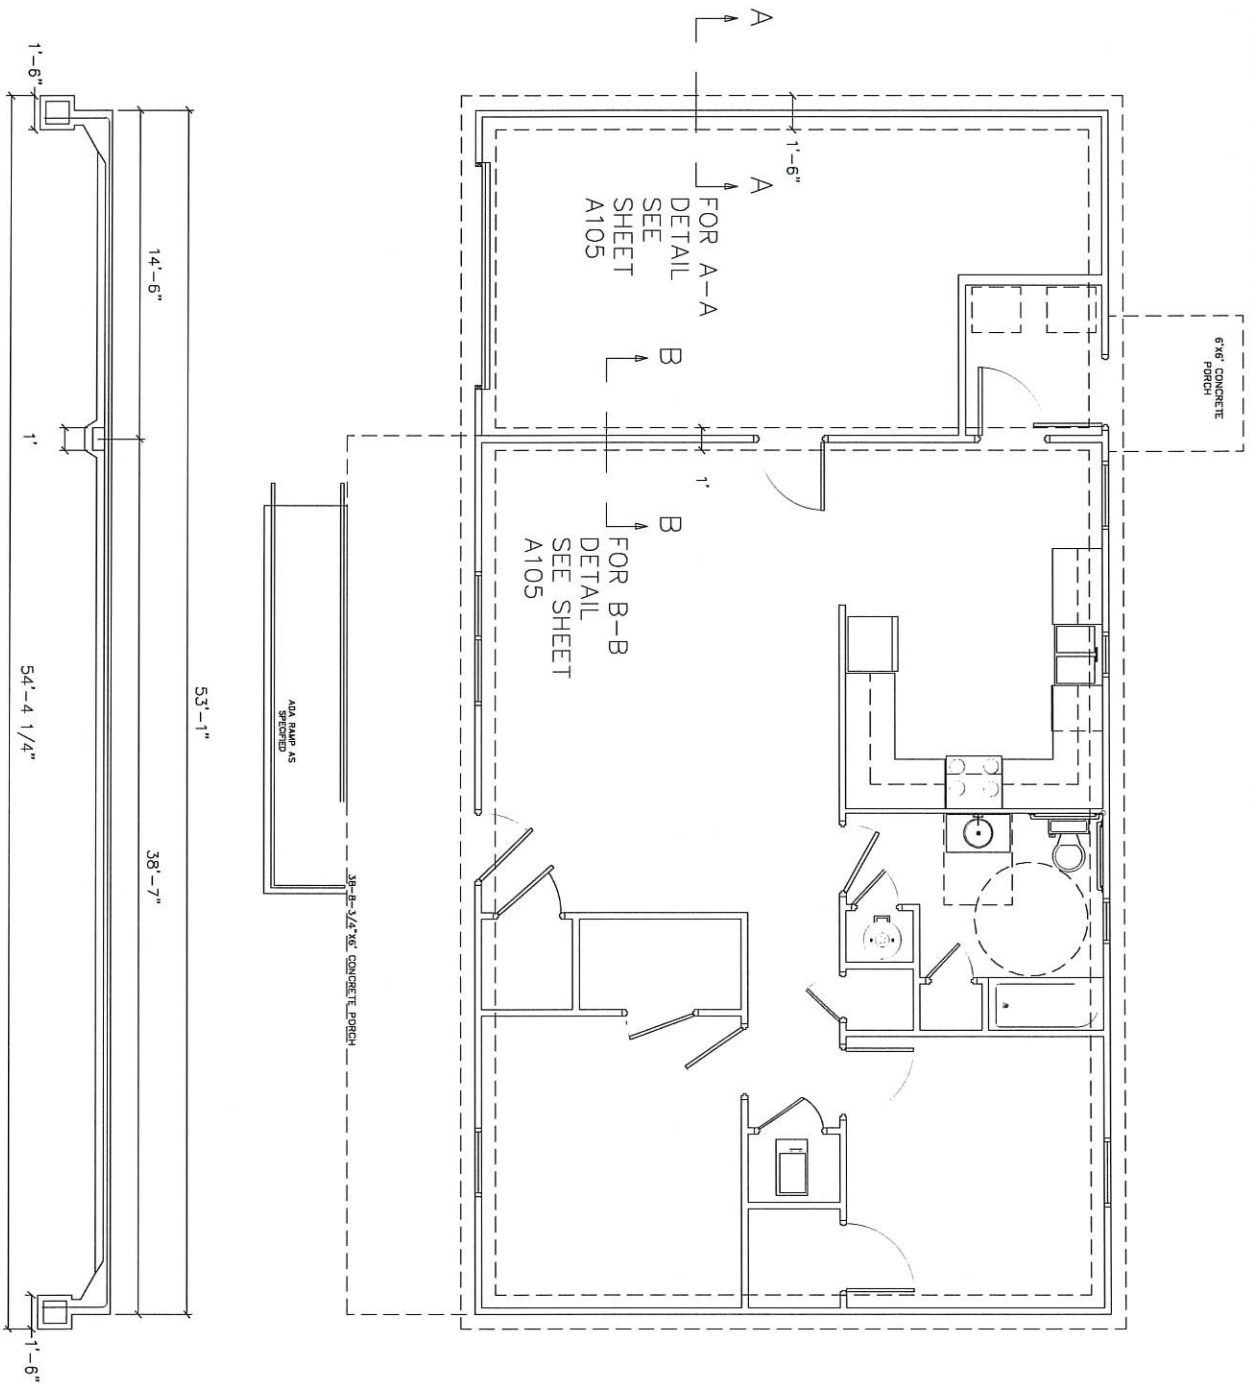

SCALE
3/8" = 1'

A104
SHEET NO.

NO. REVISION

DATE

BY

DESIGNED BY:
DRAWN BY:
MDH

 

APPROVED BY:
COK
DATE PREPARED:
June 2022


Cherokee Nation
2 Bedroom ADA Left Garage
Foundation Plan
1486 Square Feet

CLIENT: Cherokee Nation
Housing Authority



ENGINEER
KAS Gales Company
Consulting Engineers
18772 Harmon Road
Fayetteville, AR 72704
WK. 479.361.9977 Cell 479.422.0763
Email: carl.d.gales@gmail.com

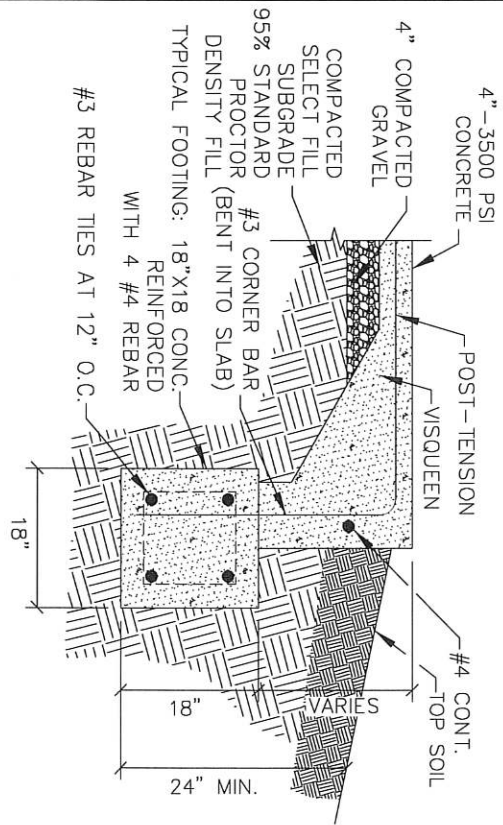


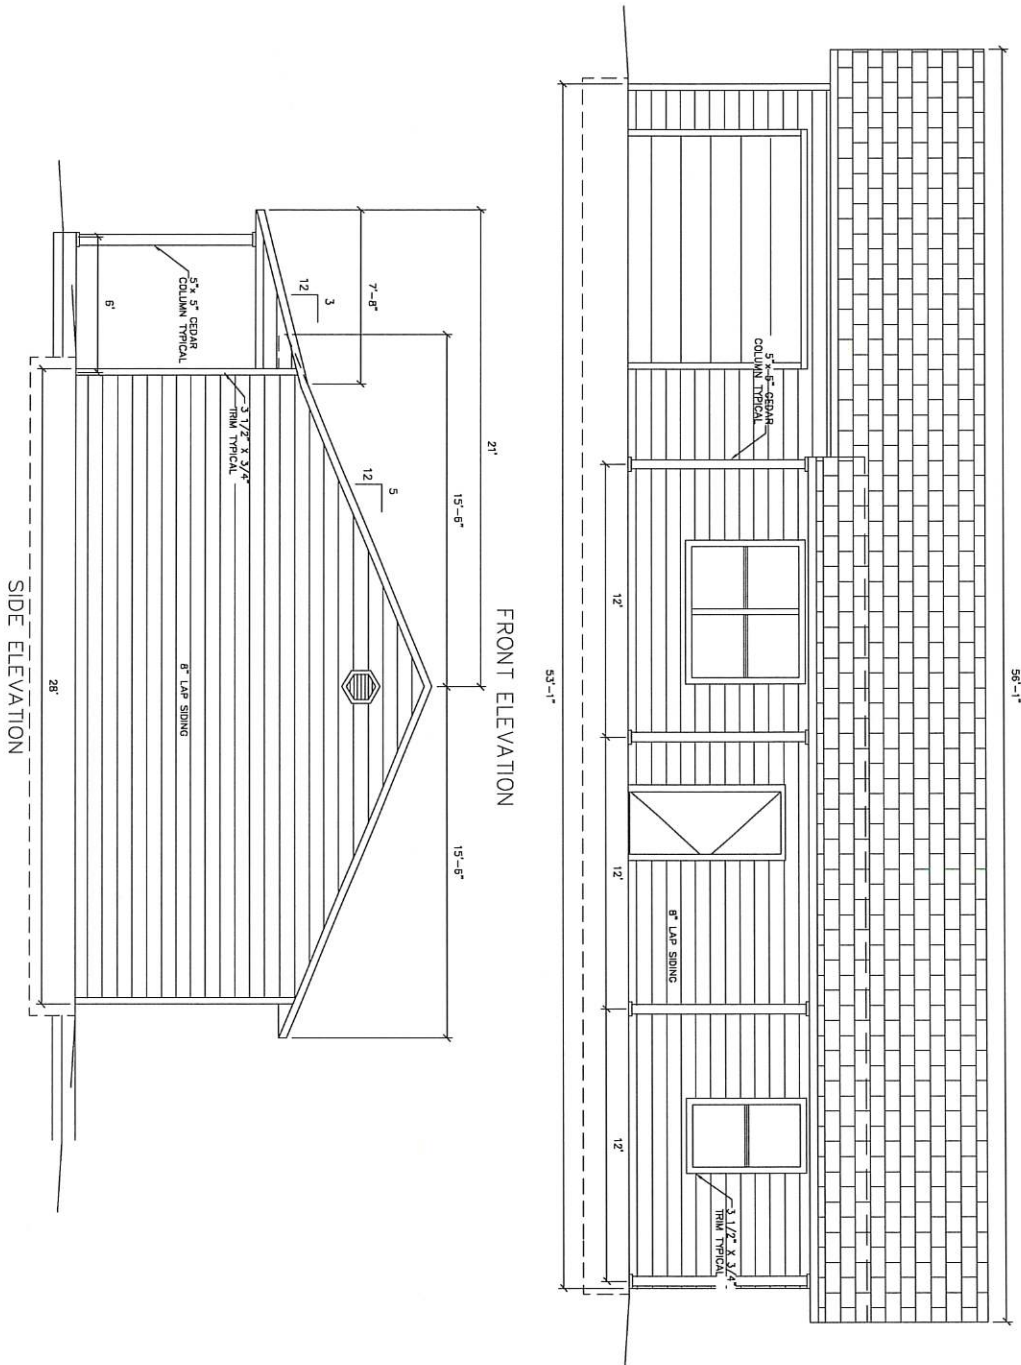

SCALE
3/8" = 1'


Cherokee Nation 2 Bedroom ADA Left Garage Gable Elevation Plan 1486 Square Feet				ENGINEER KAS Gales Company Consulting Engineers 18772 Harmon Road Fayetteville, AR 72704 Wk. 479.361.9977 Cell 479.422.0763 Email: carl.d.gales@gmail.com	
CLIENT: Cherokee Nation Housing Authority				DESIGNED BY: CJW	APPROVED BY: CJW
NO. REVISION				DRAWN BY: MJD	DATE PREPARED: June 2022
DATE BY					

A106
SHEET NO.

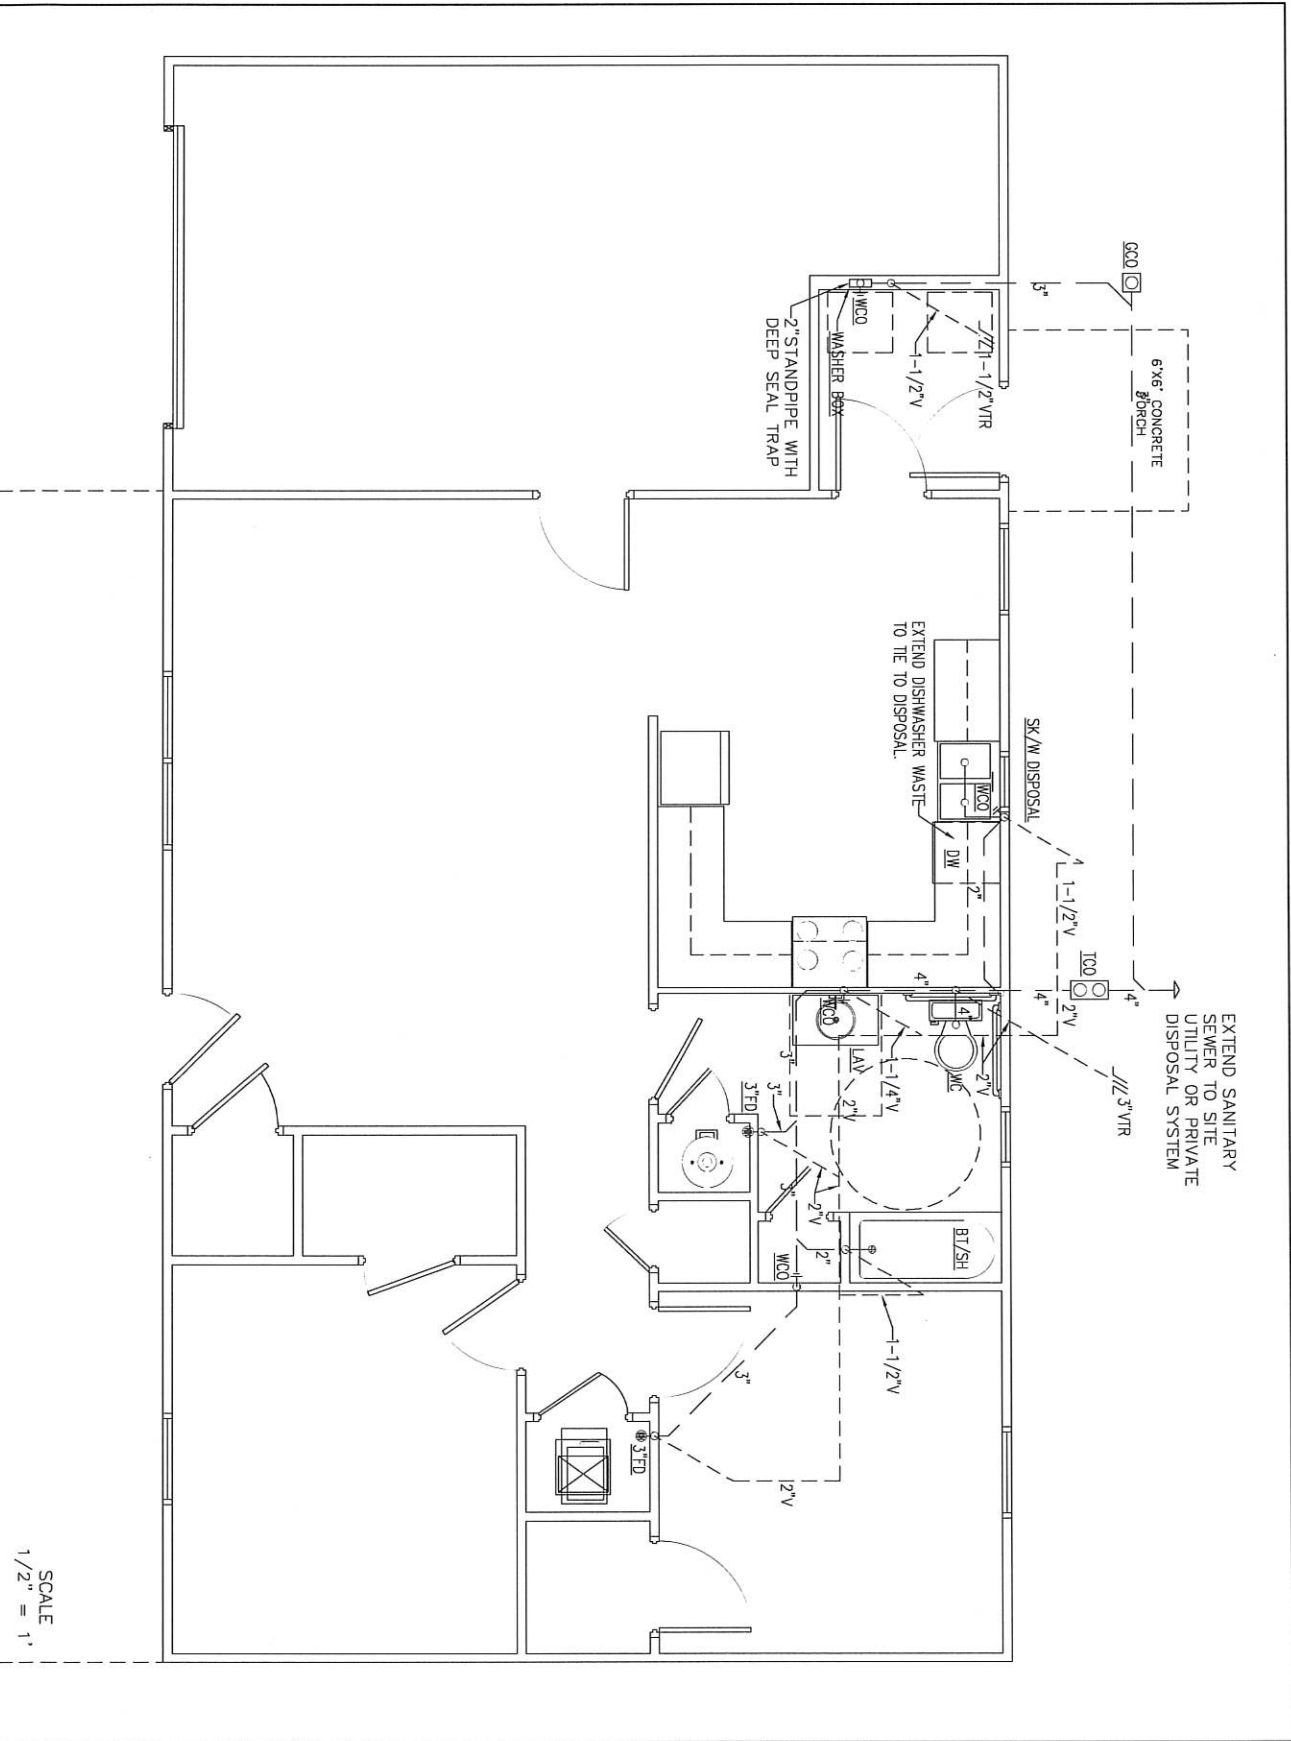

SCALE
1/2" = 1'

Cherokee Nation 2 Bedroom ADA Left Garage Waste and Vent Plumbing Plan 1486 Square Feet				ENGINEER KAS Gales Company Consulting Engineers 18772 Harmon Road Fayetteville, AR 72704 Wk. 479.361.9977 Cell 479.422.0763 Email: carl.d.gales@gmail.com	
CLIENT: Cherokee Nation Housing Authority				DESIGNED BY: CJM	APPROVED BY: [Signature]
NO. REVISION				DATE PREPARED: June 2022	
DATE BY					
P101 SHEET NO.					

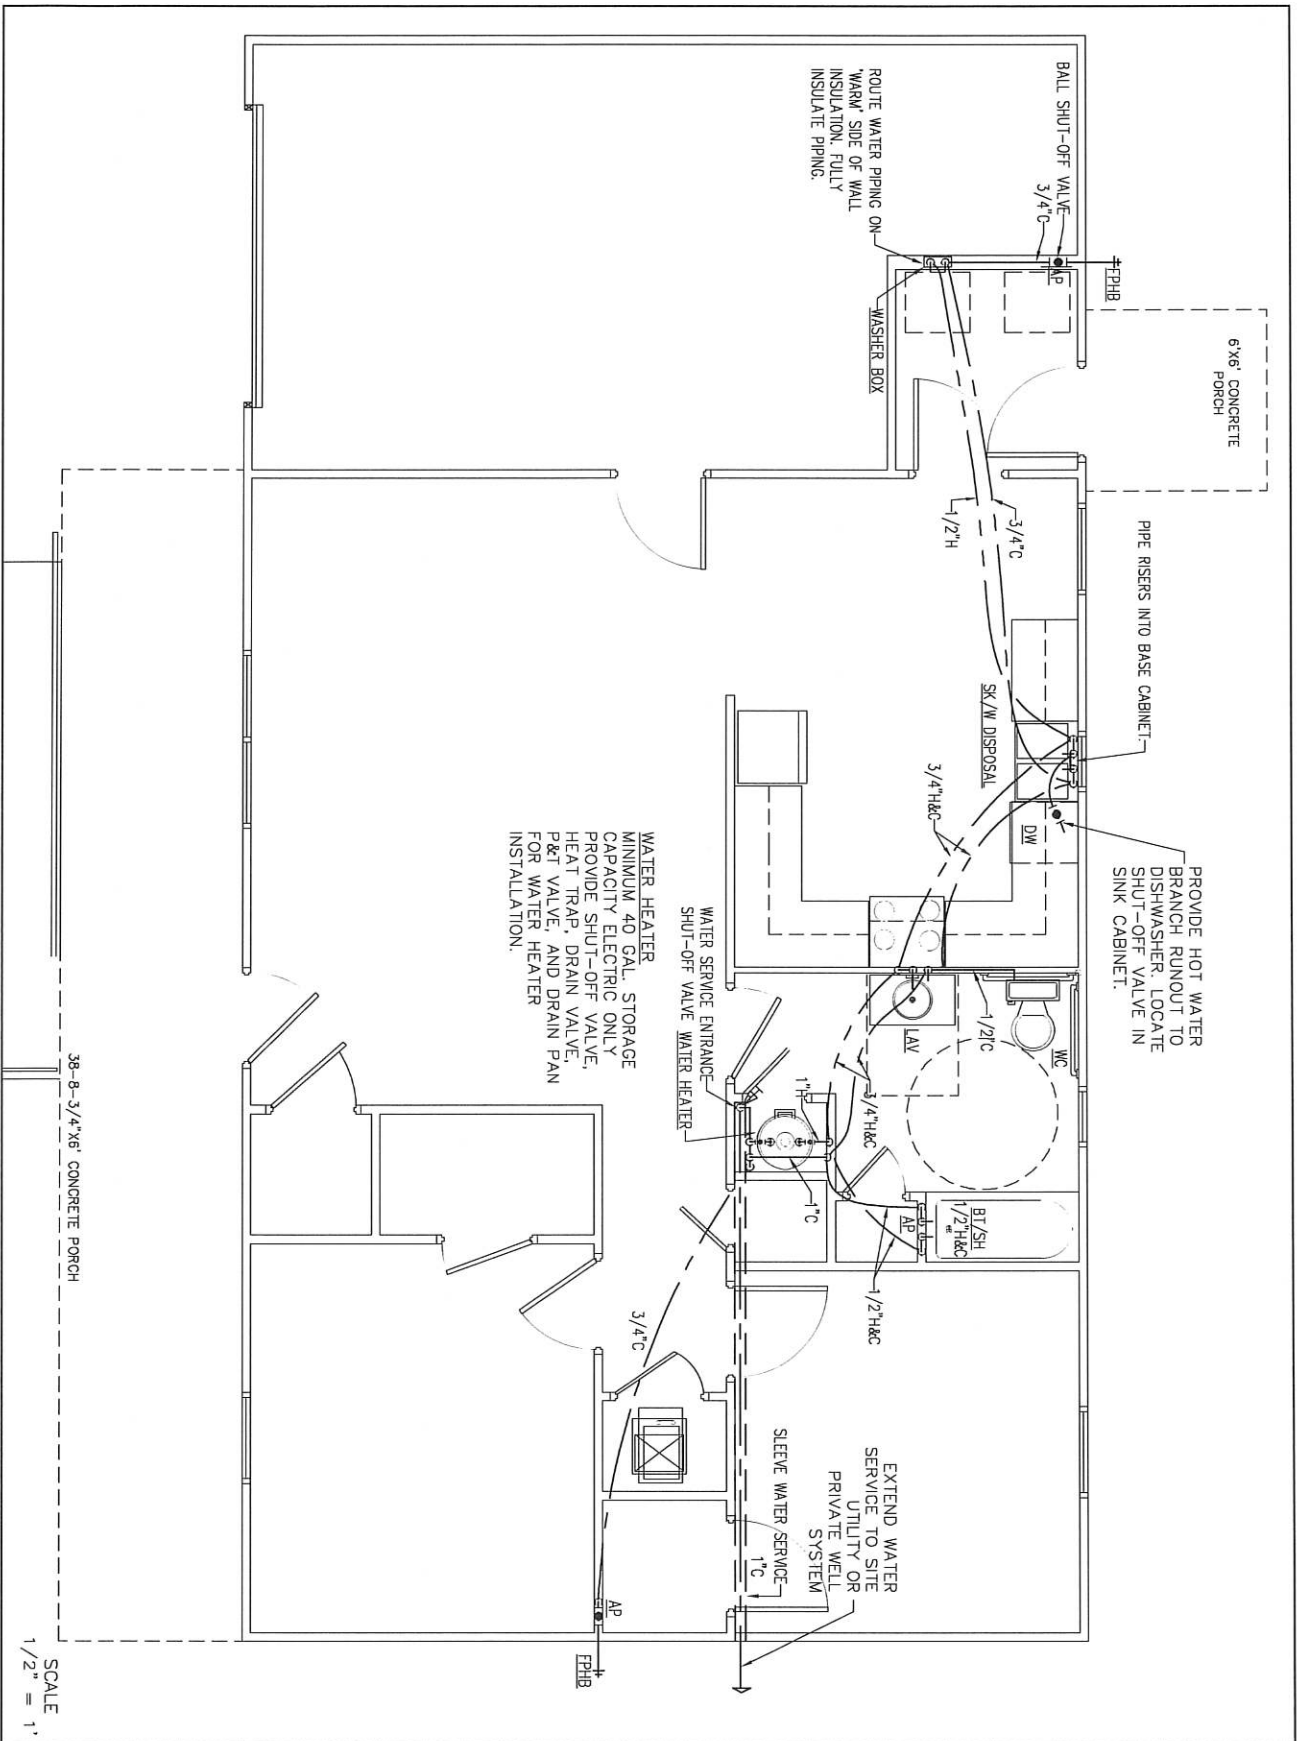

ENGINEER
KAS Gales Company
 Consulting Engineers
 18772 Harmon Road
 Fayetteville, AR 72704
 Wk. 479.361.9977 Cell 479.422.0763
 Email: carl.d.gales@gmail.com


Cherokee Nation
 2 Bedroom ADA Left Garage
 Domestic Water Plan
 1486 Square Feet

CLIENT: Cherokee Nation
 Housing Authority

DESIGNED BY: _____
 DRAWN BY: MND
 APPROVED BY: CLK
 DATE PREPARED: June 2022

NO. REVISION DATE BY

P102
 SHEET NO.

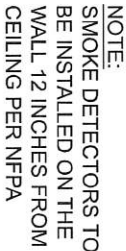

ENGINEER
KAS Gales Company
Consulting Engineers
18772 Harmon Road
Fayetteville, AR 72704
Wk. 479.361.9977 Cell 479.422.0763
Email: carl.d.gales@gmail.com

CLIENT: Cherokee Nation
Housing Authority

NO.	REVISION	DATE	BY
-----	----------	------	----

E101
SHEET NO.