




PLANS FOR
2 BEDROOM SHOTGUN STYLE
ADA WITH RIGHT GARAGE
AND SIDING
1510 SQUARE FOOT

SHEET INDEX

SHEET NO.	DESCRIPTION
A101	TITLE SHEET
A102	FLOOR PLAN
A103	CABINET ELEV./HVAC CLOSET FRAMING
A104	FOUNDATION PLAN
A105	FOUNDATION PLAN DETAILS/WALL SECTION DETAIL
A106	ELEVATIONS - GABLE
M101	HVAC PLANS
P101	WASTE AND VENT PLUMBING PLANS
P102	DOMESTIC WATER PLANS
P103	ISOMETRIC PLUMBING PLAN
E101	ELECTRICAL PLAN

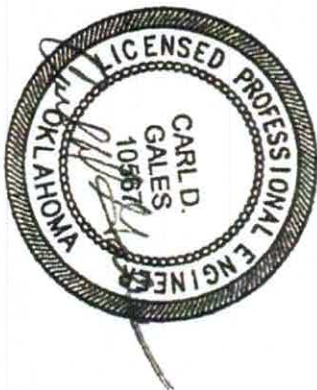

ISSUED FOR CONSTRUCTION
JUNE 20, 2022



ENGINEER
KAS Gales Company
Consulting Engineers
18772 Harmon Road
Fayetteville, AR 72704
Wk. 479.361.5977 Cell 479.422.0763
Email: carl.d.gales@gmail.com

Cherokee Nation
2 Bedroom Shotgun ADA
Right Garage Title Sheet
1510 Square Feet

CLIENT: Cherokee Nation
Housing Authority

DESIGNED BY:	APPROVED BY:
DRAWN BY:	DATE PREPARED:
MD	June 2022


A101
SHEET NO.

NO. REVISION

DATE BY

NOTE:
SAFE ROOM PREFABRICATED WITH FEMA
RATING

1510 SQUARE FEET

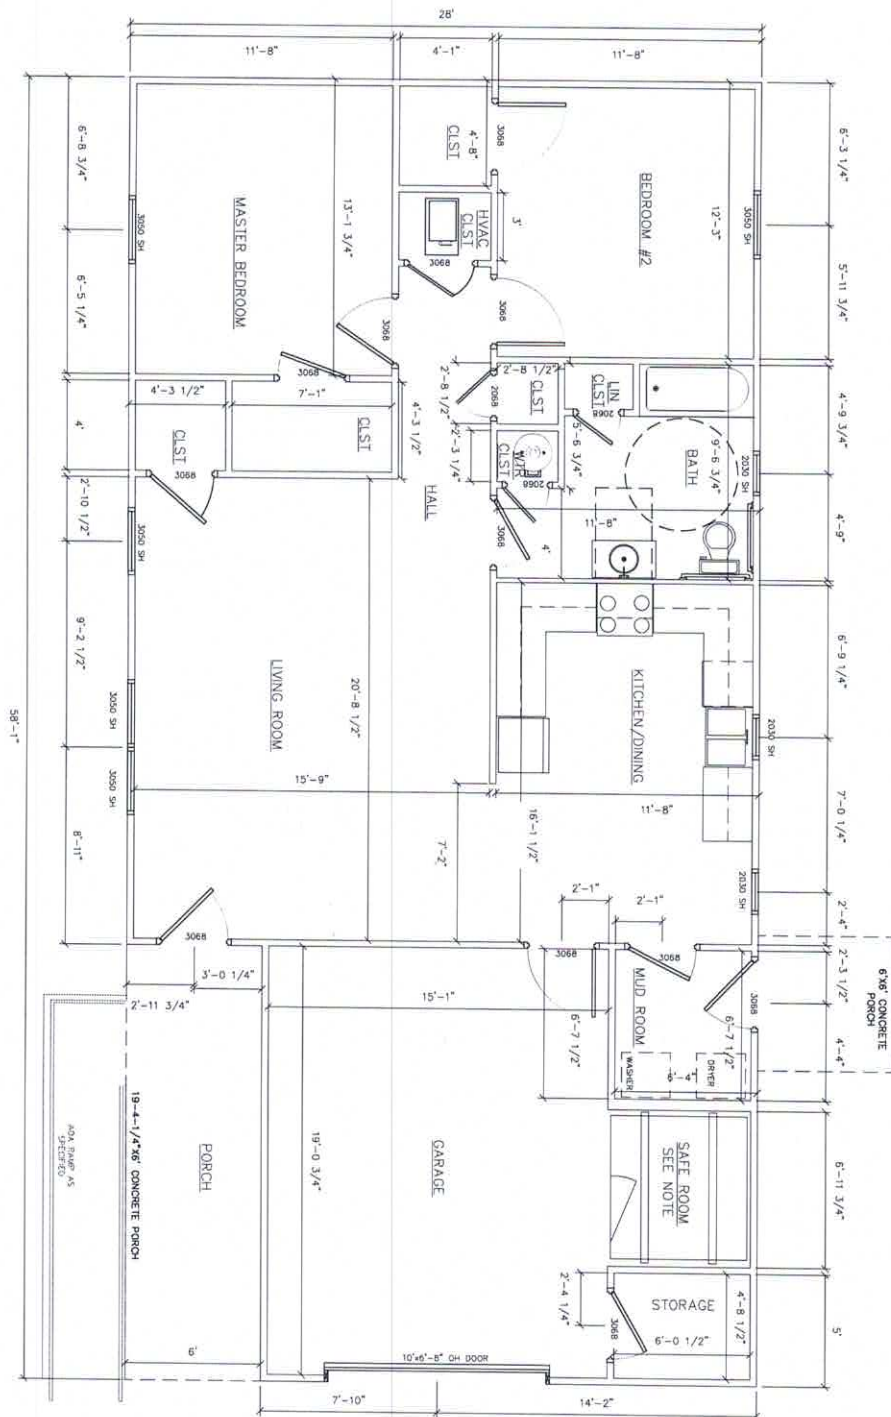

12-10-2024

0	REVISIONS PER CITY OF TULSA REQUIREMENTS	9/2022	MDD
NO.	REVISION	DATE	BY

Cherokee Nation
2 Bedroom Shotgun ADA
Right Garage Floor Plan
1510 Square Feet

CLIENT: Cherokee Nation
Housing Authority



DESIGNED BY:	
DRAWN BY:	NHD

APPROVED BY:	CDG
DATE PREPARED:	June 7/02



ENGINEER
KAS Gales Company
Consulting Engineers
18772 Harmon Road
Fayetteville, AR 72704
Wk. 479.361.9977 Cell 479.422.0763
Email: carl.d.gales@gmail.com

HVAC CLOSET FRAMING SCALE 1"=1/2"=1'

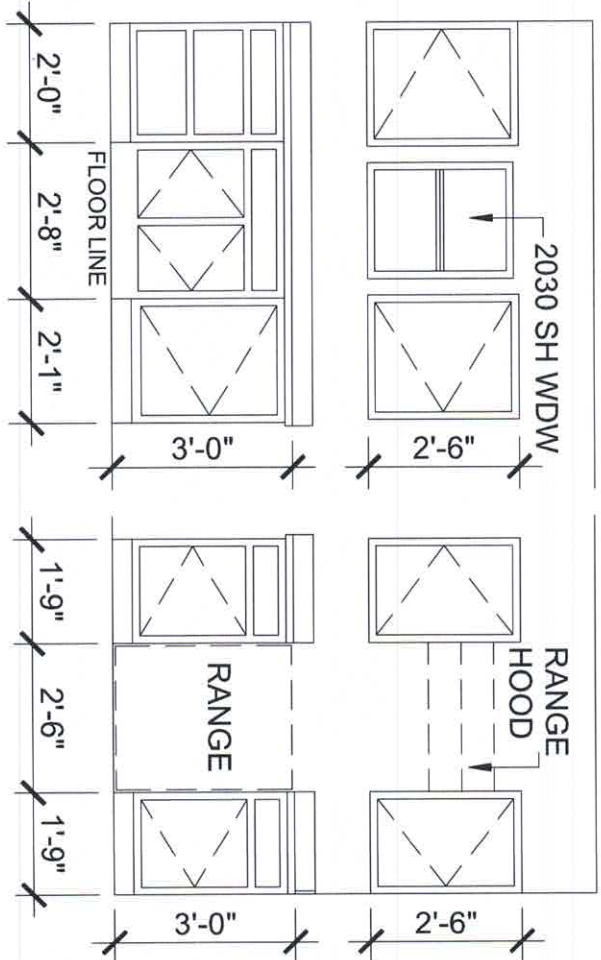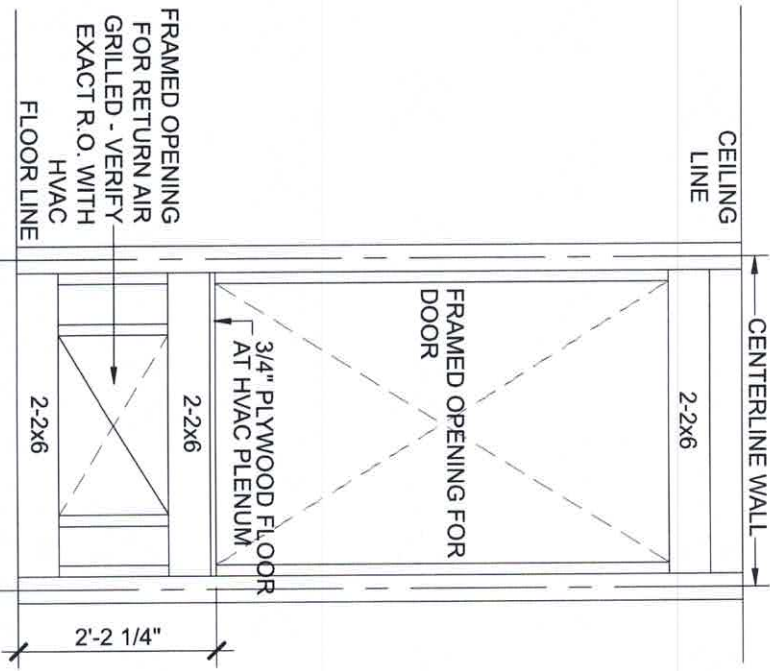

CABINET ELEVATION SCALE 1"=1/2"=1'



ENGINEER
KAS Gales Company
Consulting Engineers
18772 Harmon Road
Fayetteville, AR 72704
Wk. 479.361.9977 Cell 479.422.0763
Email: carl.d.gales@gmail.com

Cherokee Nation
2 Bedroom Shotgun ADA
Right Garage Cabinet
Elev/HVAC
1510 Square Feet

CLIENT: Cherokee Nation
Housing Authority

DESIGNED BY: CDO
APPROVED BY:
DRAWN BY: MDO
DATE PREPARED: June 2022

NO. REVISION

DATE BY

A103
SHEET NO.



ENGINEER
KAS Gales Company
Consulting Engineers
18772 Harmon Road
Fayetteville, AR 72704
Wk. 479.361.9977 Cell 479.422.0763
Email: carl.d.gales@gmail.com

CLIENT: Cherokee Nation
Housing Authority

DESIGNED BY: MDD	APPROVED BY: CDG
DRAWN BY: MDD	DATE PREPARED: June 2022

A104
SHEET NO.


NO.	REVISION
-----	----------

DATE	BY
------	----

DRAWN BY:
MDD

DATE PREPARED
June 2022

Scale: MTS

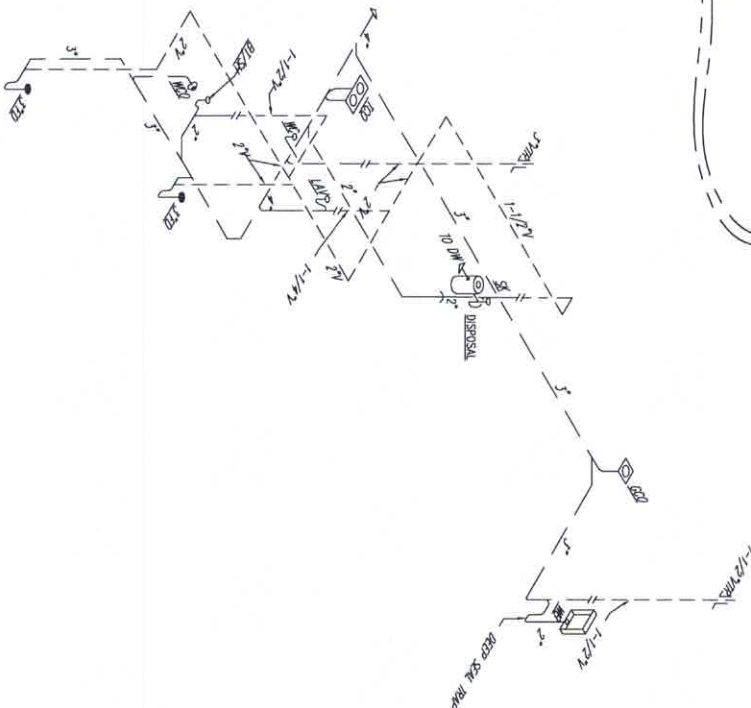

—

Cherokee Nation
2 Bedroom Shotgun ADA Right
Garage Isometric Plumbing Plan
1510 Square Feet

CLIENT: Cherokee Nation
Housing Authority

DESIGNED BY: DRAWN BY: MNU	APPROVED BY: CDG DATE PREPARED: 12/20/2017
----------------------------------	---

CLIENT: Cherokee Nation
Housing Authority

DESIGNED BY:	APPROVED BY:
DRAWN BY:	DATE PREPARED:



[illegible]

CDG
DATE PR

