


ABBREVIATIONS

@	AT	GA	GAGE, (GAUGE)	QT	QUARRY TILE
A/C	AIR CONDITIONING	GALV	GALVANIZED	QTR	QUARTER
AB	ANCHOR BOLT	GC	GENERAL CONTRACTOR	QTY	QUANTITY
ABC	AGGREGATE BASE COURSE	GD	GRADE		
AC	ACOUSTICAL CEILING	GL	GLASS, GLAZING	(R)	RECESSED
ADJ	ADJACENT	GW	GYP SUM WALLBOARD	RA	RADIUS, RISER ROUND
AFF	ABOVE FINISH FLOOR	GYP	GYP SUM	RA	RETURN AIR
AGG	AGGREGATE	H(T)	HEIGHT	RB	RESILIENT BASE
ALT	ALTERNATE	HB	HOLLOW CORE	RD	REINFORCED CONCRETE PIPE, REFLECTED CEILING PLAN
ALUM	ALUMINUM	HC	HOLLOW CORE	RO	ROUGH OPENING
ANCH	ANCHOR, ANCHORAGE	HDBD	HARDBOARD	RELO	RELOCATION
ANOD	ANODIZED	HD	HEAVY DUTY	REPL	REPLACE
AP	ACCESS PANEL	HID	HARDWOOD	RES	RESILIENT
		HDWR	HARDWARE	REV	REVISION(S), REVISED
BD	BOARD	HORIZ	HORIZONTAL	RF	RIGID FIBERGLASS
BFF	BELOW FINISH FLOOR	HP	HIGH POINT	RFG	ROOFING
BLDG	BUILDING	HR	HOUR	RH	RIGHT HAND
BLK(G)	BLOCK(ING)	HVAC	HEATING/ VENTILATING/ AIR CONDITIONING	RM	ROOM
BM	BENCH MARK	HW	HOT WATER	RO	ROUGH OPENING
BO	BOTTOM OF	ID	INSIDE DIAMETER	ROW	RIGHT OF WAY
BOT	BOTTOM	IN	INCH(ES)	RQD	REQUIRED
BRG	BEARING	INCL	INCLUDING	RWL	RAINWATER LEADER
BRK	BRICK	IE	INVERT ELEVATION		
BSMT	BASEMENT	INS	INSULATION	S	SEALED, SOUTH
BU	BUILT UP	INT	INTERIOR	(S)	SURFACE MOUNTED
		INSUL	INSULATION	SC	SOLID CORE, SEALED CONCRETE
CMWP	COMPOSITE METAL WALL PANEL SYSTEM	INT	INTERIOR	SCHED	SCHEDULE
C	CHANNEL	JC	JANITORS CLOSET	SECT	SECTION
C/C	CENTER TO CENTER	JST	JOIST	SD	STORM DRAIN
CAB	CABINET	JT	JOINT	SDG	SIDING
CB	CHALK BOARD, CATCH BASIN	KD	KNOCKED DOWN	SQ	SQUARE FEET
CEM	CEMENT	KIT	KITCHEN	SFT	SHOWER
CG	CORNER GUARD	KO	KNOCK OUT	SHWR	SHOWER
CI	CAST IRON	KP	KICK PLATE	SIM	SIMILAR
CIP	CAST IN PLACE	L	LENGTH, LONG	SL	SHEET LINOLEUM
CJ	CONTROL JOINT	LAB	LABORATORY	SM	SHEET METAL
CLG	CEILING	LAM	LAMINATE	SP	SOUNDPROOF
CLR	CLEAR FLOOR SPACE	LAV	LAVATORY	SPECS	SPECIFICATIONS
CMP	CORRUGATED METAL PIPE	LF	LINEAL FEET	SPKR	SPEAKER
CMTS	COMMENTS	LH	LEFT HAND	SPL	SPECIAL
CMU	CONCRETE MASONRY UNIT	LL	LINE LOAD	SQ	SQUARE
CO	CASED OPENING	LLH	LONG LEG HORIZONTAL	SS	SERVICE SINK
COL	COLUMN	LLV	LONG LEG VERTICAL	SST	STAINLESS STEEL
COMB	COMBINATION	LP	LOW POINT	ST	STEEL, STREET
CONC	CONCRETE	LT	LIGHT	STD	STANDARD
CONN	CONNECTION	LTWT	LIGHTWEIGHT	STOR	STORAGE
CONST	CONSTRUCTION	LVR	LOUVER	STRUC	STRUCTURAL
CONT	CONTINUOUS OR CONTINUE	MAS	MASONRY	SUSP	SUSPENDED
CORR	CORRIDOR, CORRUGATED	MAY	MAXIMUM	SV	SEAMLESS VINYL
CT	CARPET TILE	MATL	MATERIAL	SW	SWITCH
CR	CARD READER	MED	MEDIUM	SWR	SEWER
CSK	COUNTERSINK	MECH	MECHANICAL	SYM	SYMMETRY(CAL)
CTB	CERAMIC TILE - BASE	MET	METAL	T	THICKNESS, TEE
CTF	CERAMIC TILE - FLOOR	MEZZ	MEZZANINE	TD	TRENCH DRAIN
CTW	CERAMIC TILE - WALL	MFR	MANUFACTURER	T&G	TONGUE & GROOVE
CU	CUBIC	MH	MANHOLE	TB	TACKBOARD
CU FT	CUBIC FOOT (FEET)	MIR	MIRRORED	TEL	TELEPHONE
CW	COLD WATER	MM	MILLIMETER	TEMP	TEMPERATURE, TEMPORARY
		MIN	MINIMUM	TERR	TERRAZZO
D	DEPTH	MISC	MISCELLANEOUS	THK	THICKNESS
DEMO	DEMOLISH, DEMOLITION	MO	MASONRY OPENING	TO	TOP OF
DF	DRINKING FOUNTAIN	MOD	MODULAR	TOC	TOP OF CONCRETE
DIA	DIAMETER	MOV	MOVABLE	TOILET	TOILET
DIAG	DIAGONAL	MTD	MOUNTED	TOP	TOP OF PARAPET
DIM	DIMENSION	MWP	METAL WALL PANEL SYSTEM (SYSTEM)	TOS	TOP OF STEEL
DISP	DISPENSER	N	NORTH	TOW	TOP OF WALL
DN	DOWN	NA	NOT APPLICABLE	TPD	TOILET PAPER DISPENSER
DO	DITTO	NIC	NOT IN CONTRACT	TV	TELEVISION
DP	DAMP PROOFING	NIC	NOT IN CONTRACT	TYP	TYPICAL
DR	DOOR	NOM	NOMINAL	U	URINAL
DS	DOWNSPOUT	NRC	NOISE REDUCTION COEFFICIENTS	UG	UNDERGROUND
DTL	DETAIL	NTS	NOT TO SCALE	UL	UNDERWRITERS LABORATORY
DWG	DRAWING	NO	NUMBER	UNF	UNFINISHED
DWC	DRYWALL CHANNELS (HAT)	OA	OVERALL	UNO	UNLESS NOTED OTHERWISE
		OC	ON CENTER(S)		
E	EAST	OD	OUTSIDE DIAMETER	VB	VAPOR BARRIER
EA	EACH	OFF	OFFICE	VCT	VINYL COMPOSITION TILE
EA	EACH FACE	OH	OVERHEAD, OPPOSITE HAND	VERT	VERTICAL
EG	END GUARD	OPG	OPENING	VIF	VERIFY IN FIELD
EJ	EXPANSION JOINT	OPP	OPPOSITE	VNR	VENEER
ELEC	ELECTRICAL	ORD	OVERFLOW ROOF DRAIN	VPL	VENEER PLASTER
ELEV	ELEVATION, ELEVATOR			VWC	VINYL WALL COVERING
EMER	EMERGENCY	P(%)	PARTITION TYPE		
EP	EPOXY PAINT	P	PAINT(ED)	W	WIDTH, WIDE, WEST
EQ	EQUAL	PAR	PARALLEL	W/O	WITHOUT
EQUIP	EQUIPMENT	PART	PARTITION	W/W	WALL TO WALL
ES	EXPOSED STRUCTURE	PART BD	PARTICLE BOARD	WC	WATER CLOSET
EST	ESTIMATE	PC	PIECE	WD	WOOD
EW	EACH WAY	PCC	PRECAST CONCRETE	WDW	WINDOW
EWC	ELECTRIC WATER COOLER	PCF	POUNDS PER CUBIC FOOT	WH	WALL HUNG, WATER HEATER
EXC	EXCAVAT(ION)	PERIM	PERIMETER	WI	WROUGHT IRON
EXH	EXHAUST	PERP	PERPENDICULAR	WM	WIRE MESH
EXIST	EXISTING	PF	PERFORATED(D)	WP	WATERPROOFING
EXP	EXPANSION, EXPOSED	PJ	PANEL JOINT	WR	WATER REPELLENT
EXT	EXTERIOR	PL	PLASTER, PLATE, PROPERTY LINE	WS	WEATHER-STRIP
EIFS	EXT. INSULATION FINISH SYSTEM	PLB	PLUMBING	WSCOT	WAINSCOT
		PLAM	PLASTIC LAMINATE	WT	WEIGHT
F	FAHRENHEIT	PLF	POUNDS PER LINEAL FOOT	WWF	WELDED WIRE FABRIC
FA	FIRE ALARM	PNL	PANEL	YD	YARD
FAB	FABRICATE	PO	POWER OPERATED		
FD	FURR-DOWN	PR	PAIR		
FDN	FOUNDATION	PREFAB	PREFABRICATED		
FE(C)	FIRE EXTINGUISHER (CABINET)	PSF	POUNDS PER SQUARE FOOT		
FF	FINISH FLOOR	PSI	POUNDS PER SQUARE INCH		
FHC	FIRE HOSE CABINET	PT	POINT		
FHR	FIRE HOSE RACK	PTD	PAPER TOWEL DISPENSER		
FIN	FINISH(ED)	PTR	PAPER TOWEL RECEPTOR		
FL	FLOOR	PVC	POLYVINYL CHLORIDE		
FLA	FLASHING	PVMT	PAVEMENT		
FLEX	FLEXIBLE	PWD	PLYWOOD		
FLUOR	FLUORESCENT				
FO	FACE OF				
FP	FIRE PROOF				
FRP	FIBER REINFORCED PLASTIC				
FT	FOOT, FEET				
FTG	FOOTING				
FUR	FURRED(ING)				
FUT	FUTURE				

INDEX OF DRAWINGS


NUMBERING SYSTEM:

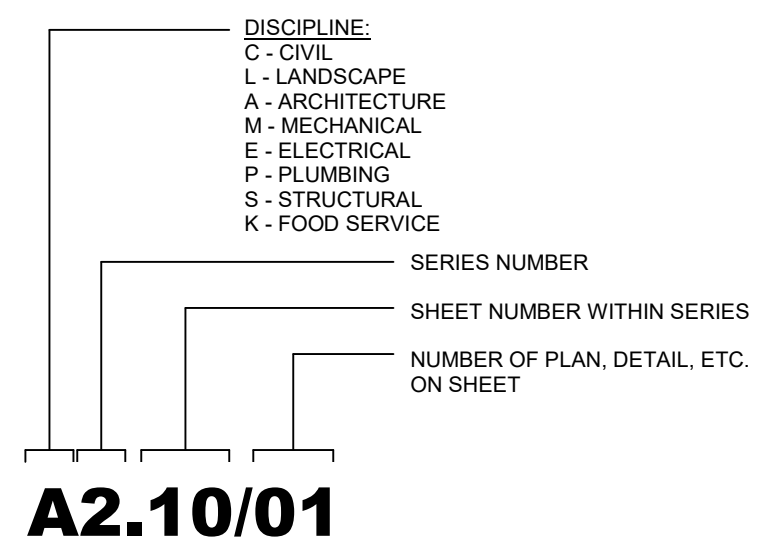



LEGEND

MATERIALS	
	CONCRETE/ PRECAST CONCRETE
	SOIL
	SAND, EIFS FINISH COAT, OR CEMENT PLASTER
	BRICK
	CMU
	STONE
	GLASS MINERAL FIBER BATT INSULATION
	GLASS MINERAL FIBER SEM RIGID INSULATION
	EXPANDED POLYSTYRENE RIGID INSULATION
	EXTRUDED POLYSTYRENE RIGID INSULATION
	POLYISOCYANURATE RIGID INSULATION
	GYP SUM BOARD
	EXTERIOR GYP SUM SHEATHING
	EXTERIOR CEMENT BOARD
	COATED GLASS MAT WATER RESISTANT GYP BD
	PLYWOOD
	COVER BOARD

DRAWING SYMBOLS	
	ROOM NAME
	ROOM NAME/NUMBER
	EXISTING COLUMN CENTERLINE
	COLUMN CENTERLINE
	HOLLOW METAL FRAMES/ INTERIOR STOREFRONT
	BUILDING WALL SECTION
	ELEVATION
	SECTION DETAIL
	PLAN, BLOW-UP DETAIL
	CEILING HEIGHT
	MEDICAL GAS
	CORNER GUARDS
	WALL PROTECTION
	CUBICLE CURTAIN TRACK
	PARTITION TYPE
	BUILDING EXPANSION JOINT
	CMU WALL
	NEW WALL
	EXISTING WALL
	DEMO WALL

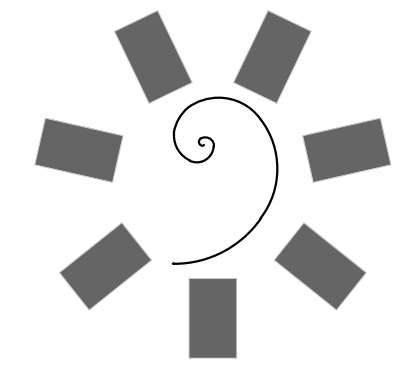

James R. Childers
 Architect, Inc.
 45 South 4th Street
 Fort Smith, AR 72901
 479-783-2460
 www.childersarchitect.com

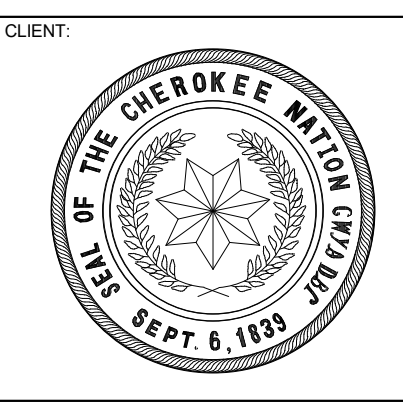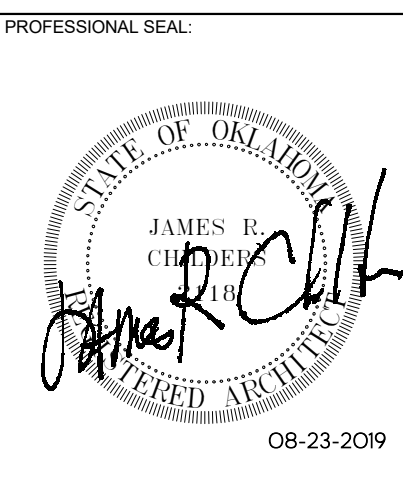

COLLEGE OF
Osteopathic Medicine
 AT THE CHEROKEE NATION
 TAHLEQUAH, OKLAHOMA

KEY PLAN

PROJECT PHASE

CONSTRUCTION DOCUMENTS


#	DATE	REVISIONS DESCRIPTION

DATE: 08-23-19 JOB NUMBER: 17-13


SHEET NUMBER:

API


PROJECT INFORMATION

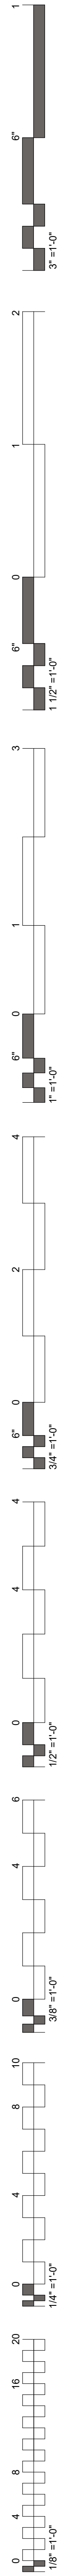

CONSTRUCTION DOCUMENTS

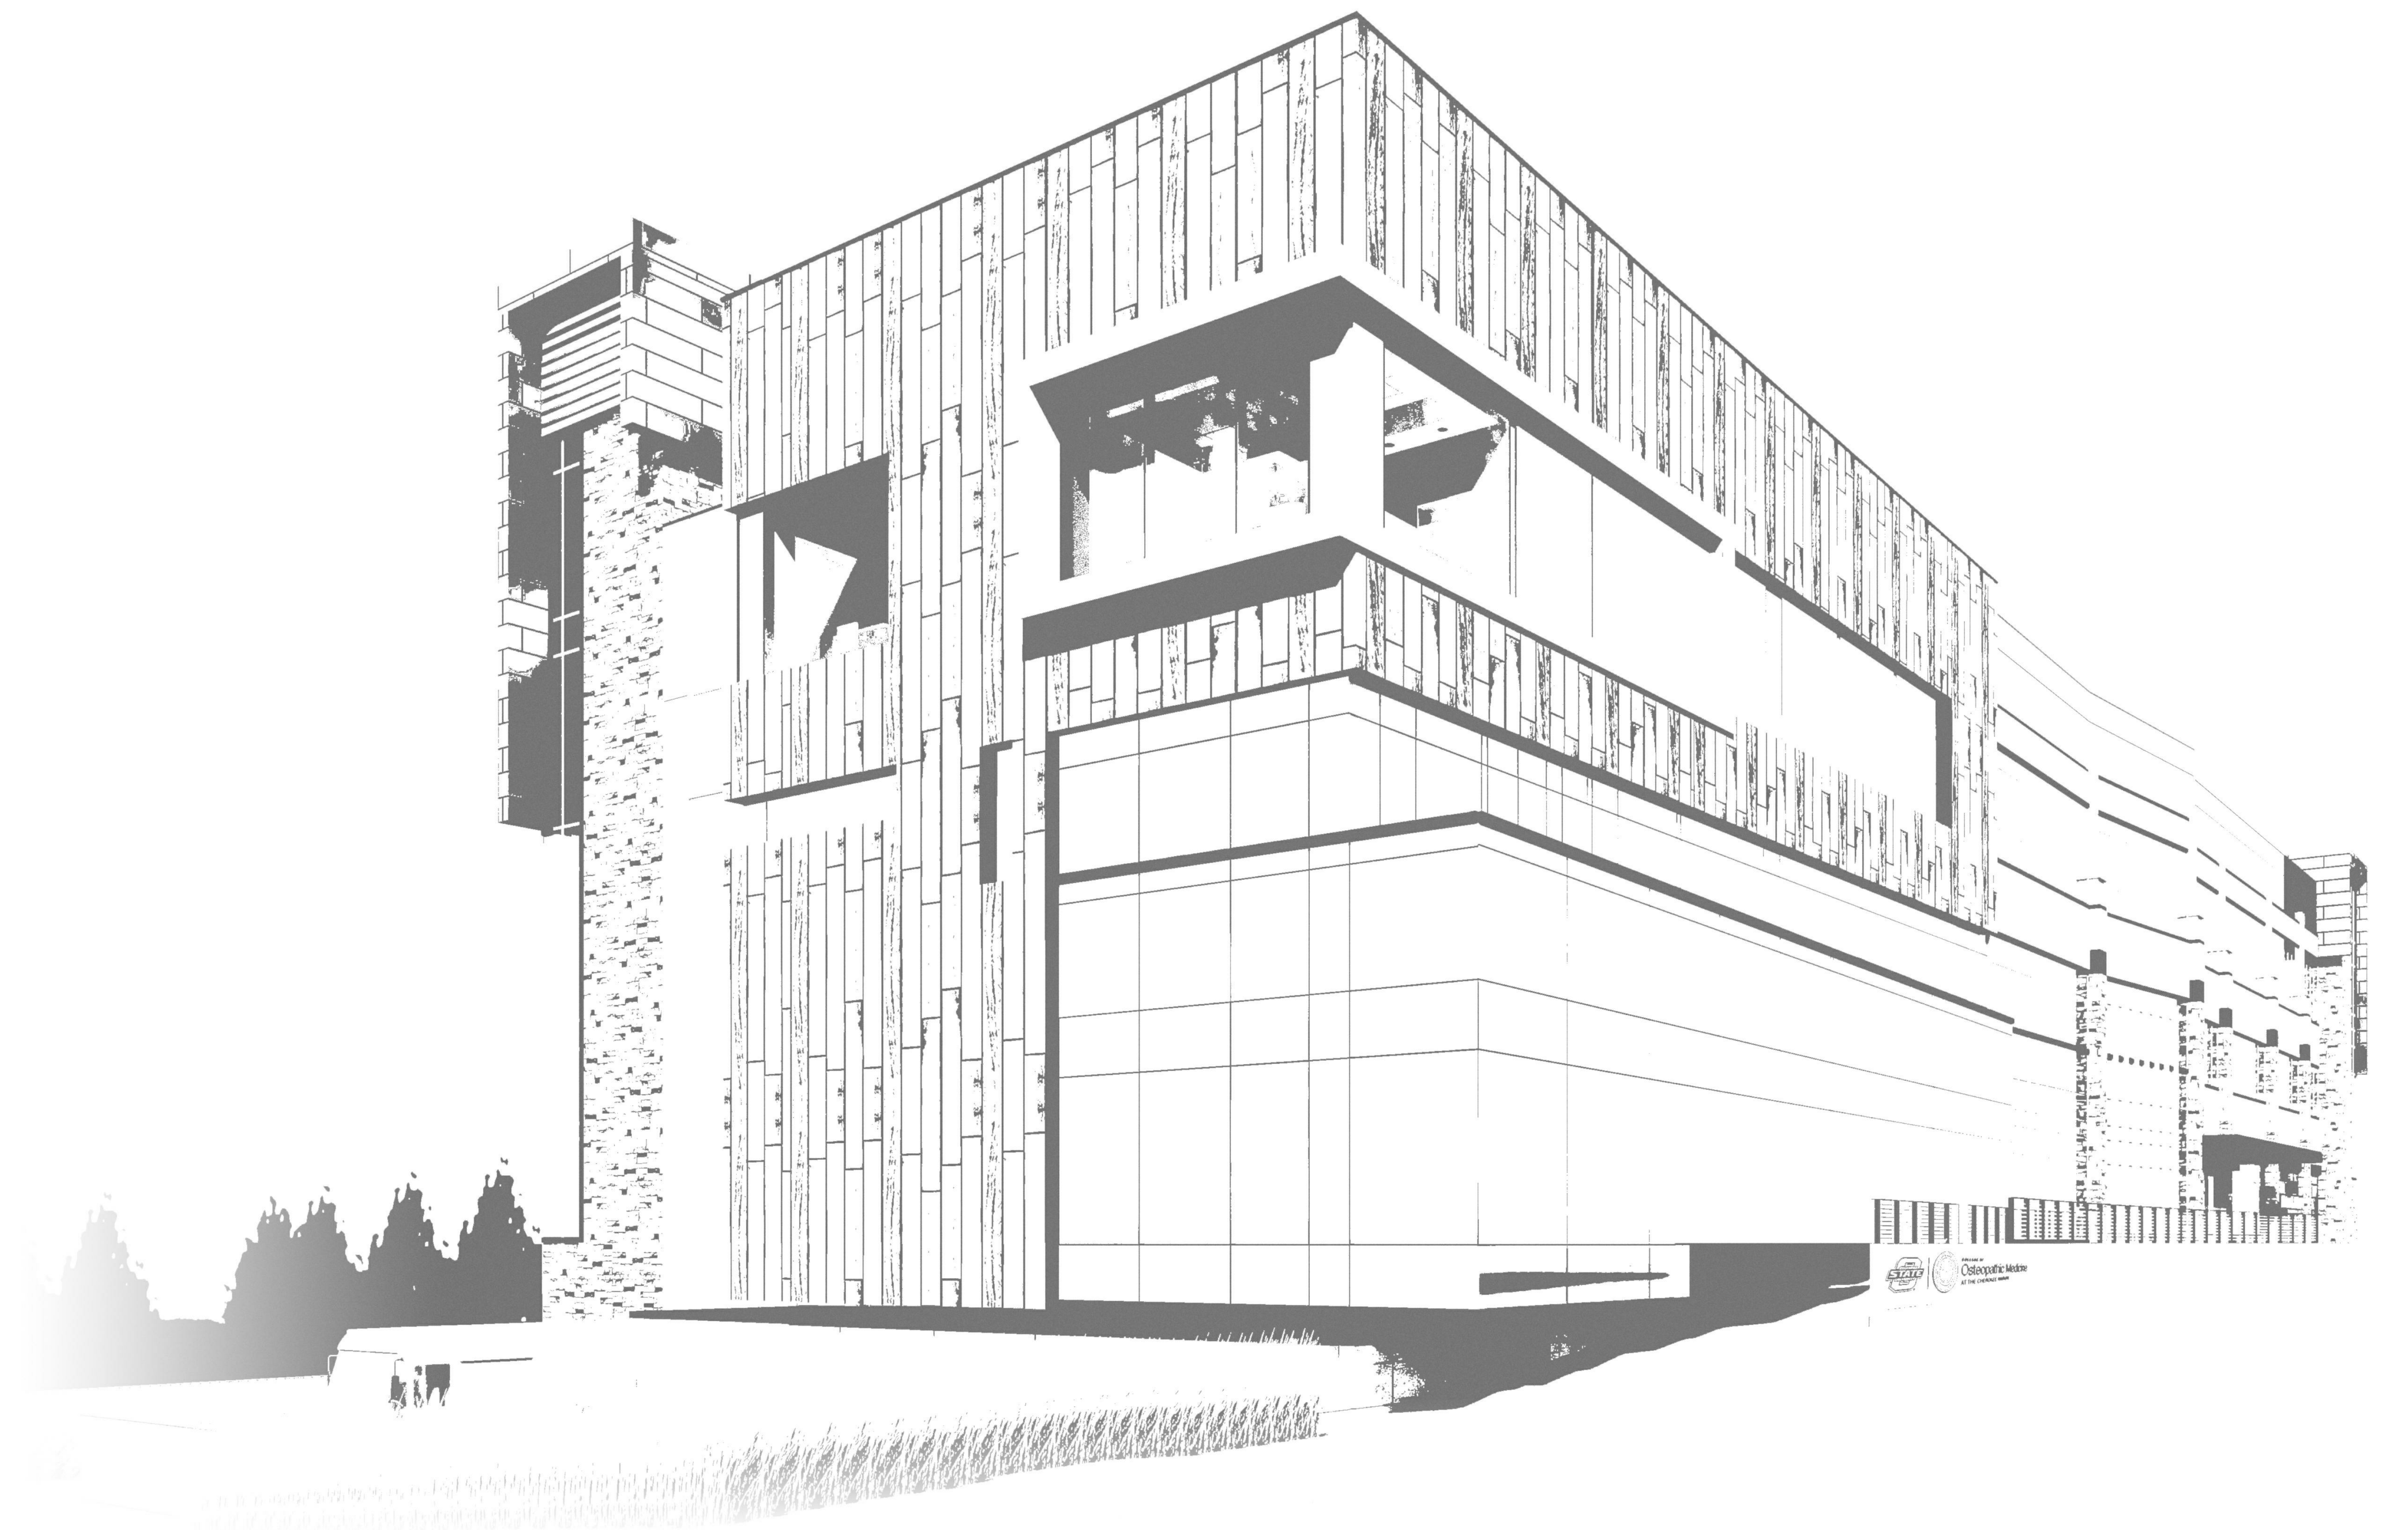


 CARDINAL ENGINEERING <small>525 CENTRAL PARK DRIVE, SUITE 402 OKLAHOMA CITY, OK 73105 (405) 842-1096</small> CIVIL ENGINEERING	 Chavez-Grievos consulting engineers, Inc. <small>4700 LINCOLN ROAD NE, SUITE 102 ALBUQUERQUE, NM 87109 (505) 344-4080</small> STRUCTURAL ENGINEER	 HP ENGINEERING <small>1836 SOUTH BALTIMORE AVE. TULSA, OK 74119 (539) 664-4618</small> MECHANICAL & ELECTRICAL ENGINEER	 Interior Logistics <small>1316 E 35TH PLACE, SUITE 100 TULSA, OK 74105 (918) 382-9120</small> EQUIPMENT PLANNER	 HKS <small>1000 MACON ST, SUITE 150 FORT WORTH, TX 76102 (817) 348-0330</small> ARCHITECTURAL HEALTHCARE PLANNING	 WSP <small>808 TRAVIS STREET, SUITE 200 HOUSTON, TX 77002 (281) 589-5900</small> FIRE PROTECTION / LIFE SAFETY
--	--	--	--	--	---

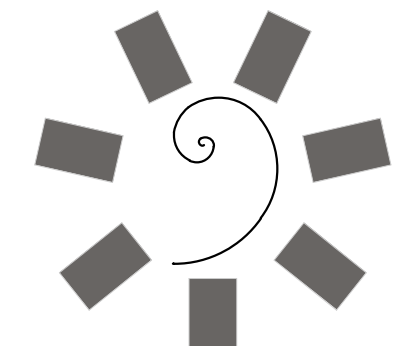


James R. Childers
Architect, Inc.
45 South 4th Street
Fort Smith, AR 72901
479-783-2450
www.childersarchitect.com

PROFESSIONAL SEAL:



CONSULTANT LOGO:

CLIENT:

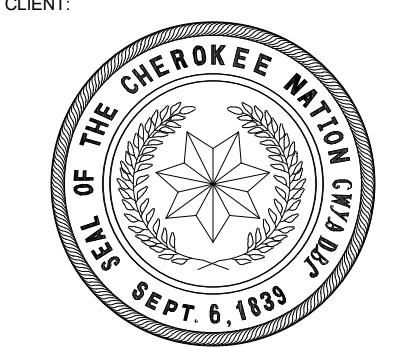

COLLEGE OF
Osteopathic Medicine
AT THE CHEROKEE NATION
TAHLEQUAH, OKLAHOMA




KEY PLAN:


PROJECT PHASE:
CONSTRUCTION DOCUMENTS

#	DATE	REVISIONS DESCRIPTION

DATE: 08-23-19 JOB NUMBER: 17-13

SHEET NUMBER:
G0.00

COVER SHEET

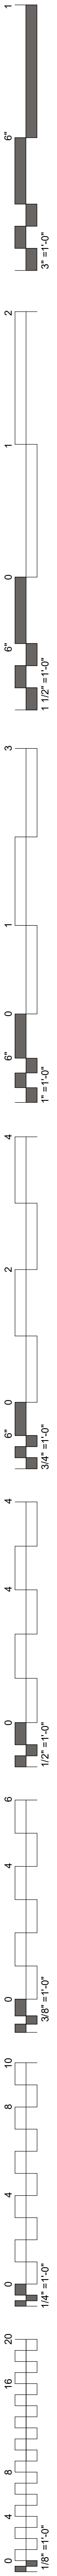

COLLEGE OF
Osteopathic Medicine
AT THE CHEROKEE NATION

**BID PACKAGE 01
(DEMOLITION)**

Sheet Number	SHEET NAME	Scale
INDEX OF DRAWINGS - BID PACKAGE 01		
GENERAL		
G0.01	COVER / INDEX	1" = 1'-0"
CIVIL		
C1-101	EXISTING CONDITIONS AND SURVEY CONTROL	1" = 1'-0"
C5-701	EROSION CONTROL PLAN	1" = 1'-0"
C5-702	EROSION CONTROL DETAILS AND NOTES	1" = 1'-0"
C7-001	WATER TITLE SHEET	1" = 1'-0"
C7-201	WATER PLAN AND PROFILE	1" = 1'-0"
C7-202	WATER PLAN AND PROFILE	1" = 1'-0"
C7-203	WATER PLAN AND PROFILE	1" = 1'-0"
C7-501	WATER DETAILS	1" = 1'-0"
C24-101	DEMOLITION PLAN	1" = 1'-0"

**CARDINAL
ENGINEERING**
525 CENTRAL PARK DRIVE, SUITE 402
OKLAHOMA CITY, OK 73105
(405) 842-1096
CIVIL ENGINEERING


Chavez-Grievos
consulting engineers, Inc.
4700 LINCOLN ROAD NE, SUITE 102
ALBUQUERQUE, NM 87109
(505) 344-4080
STRUCTURAL ENGINEER

HP ENGINEERING, INC.
1836 SOUTH BALTIMORE AVE.
TULSA, OK 74119
(539) 664-4618
MECHANICAL & ELECTRICAL ENGINEER


Interior Logistics
1316 E 35TH PLACE, SUITE 100
TULSA, OK 74105
(918) 382-9120
EQUIPMENT PLANNER

HKS
1000 MACON ST., SUITE 150
FORT WORTH, TX 76102
(817) 348-0330
ARCHITECTURAL HEALTHCARE PLANNING


WSP
808 TRAVIS STREET, SUITE 200
HOUSTON, TX 77002
(281) 589-5900
FIRE PROTECTION / LIFE SAFETY

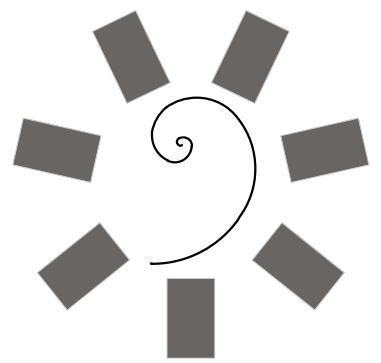

**James R. Childers
Architect, Inc.**
45 South 4th Street
Fort Smith, AR 72901
479-783-2450
www.childersarchitect.com

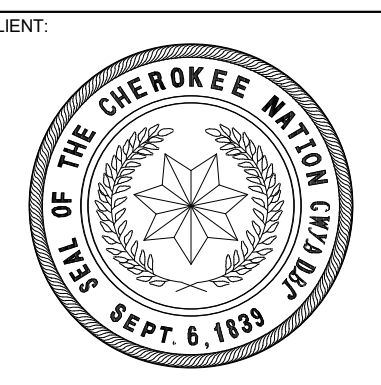

COLLEGE OF
Osteopathic Medicine
AT THE CHEROKEE NATION
TAHLEQUAH, OKLAHOMA

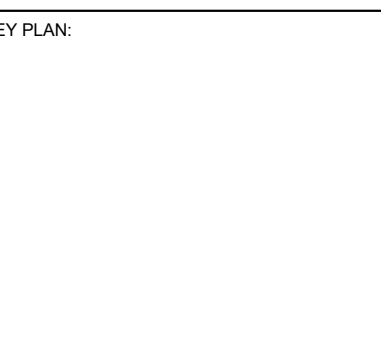


PROJECT PHASE:
BID PACKAGE 01

#	DATE	REVISIONS / DESCRIPTION
1	04/16/19	BID PACKAGE 01 ABI 01
2	04/30/19	BID PACKAGE 01 ABI 02

DATE: 01-25-19
JOB NUMBER: 17-13

SHEET NUMBER:
G0.01

COVER / INDEX

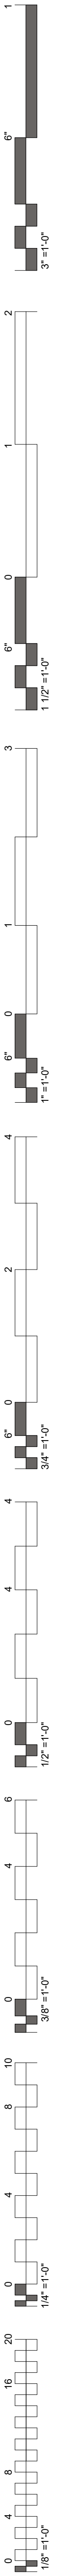

COLLEGE OF
Osteopathic Medicine
AT THE CHEROKEE NATION

**BID PACKAGE 02
(ROUGH GRADING)**

INDEX OF DRAWINGS - BID PACKAGE 02

Sheet Number	SHEET NAME	Scale
00-02	COVER / INDEX	1" = 1'-0"
CS-101	GRADING PLAN	1/2" = 1'-0"
CS-102	GRADING PLAN	1/2" = 1'-0"
CS-103	EARTHWORK VOLUMES STUDY	1/2" = 1'-0"
CS-104	GRADING PLAN	1/2" = 1'-0"
CS-105	GRADING PLAN	1/2" = 1'-0"

**CARDINAL
ENGINEERING**
525 CENTRAL PARK DRIVE, SUITE 402
OKLAHOMA CITY, OK 73105
(405) 842-1096
CIVIL ENGINEERING


Chavez-Grievos
consulting engineers, Inc.
4700 LINCOLN ROAD NE, SUITE 102
ALBUQUERQUE, NM 87109
(505) 344-4080
STRUCTURAL ENGINEER

HP ENGINEERING, INC.
1836 SOUTH BALTIMORE AVE.
TULSA, OK 74119
(539) 664-4618
MECHANICAL & ELECTRICAL ENGINEER



Interior Logistics
1316 E 35TH PLACE, SUITE 100
TULSA, OK 74105
(918) 382-9120
EQUIPMENT PLANNER

HKS
1000 MACON ST., SUITE 150
FORT WORTH, TX 76102
(817) 348-0330
ARCHITECTURAL HEALTHCARE PLANNING


WSP
808 TRAVIS STREET, SUITE 200
HOUSTON, TX 77002
(281) 589-5900
FIRE PROTECTION / LIFE SAFETY

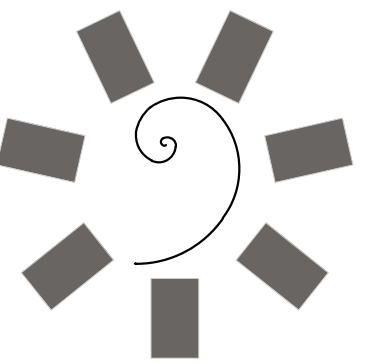

**James R. Childers
Architect, Inc.**
45 South 4th Street
Fort Smith, AR 72901
479-783-2450
www.childersarchitect.com

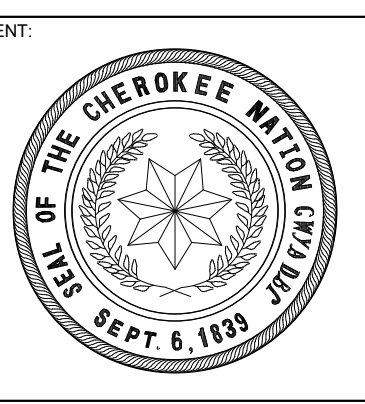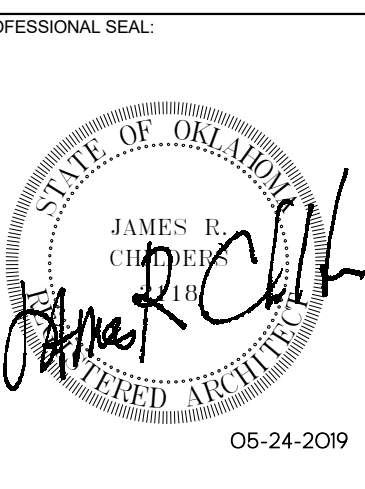

COLLEGE OF
Osteopathic Medicine
AT THE CHEROKEE NATION
TAHLEQUAH, OKLAHOMA

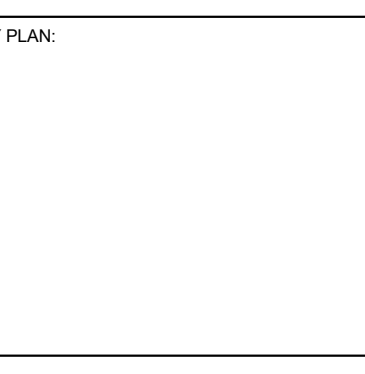


PROJECT PHASE:
BID PACKAGE 02

#	DATE	REVISIONS / DESCRIPTION
1	4/18/19	BID PACKAGE 02 ABI 01
2	05/24/19	BID PACKAGE 02 ABI 02

DATE: 02-08-19 JOB NUMBER: 17-13

SHEET NUMBER:
G0.02

COVER / INDEX

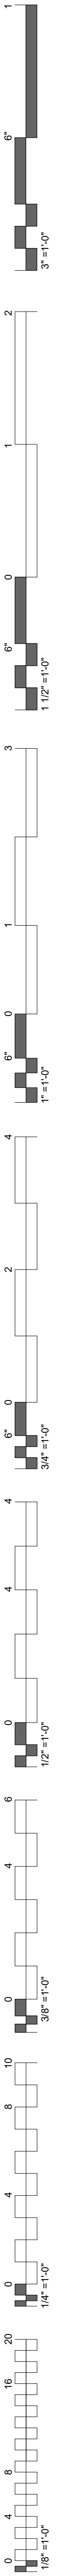

COLLEGE OF
Osteopathic Medicine
AT THE CHEROKEE NATION

**BID PACKAGE 03
(FOUNDATION)**

Sheet Number	SHEET NAME	03-20-19 - BID PACKAGE 03	03-22-19 - BID PACKAGE 03 - ABI 01	03-23-19 - BID PACKAGE 03 - ABI 02	03-25-19 - BID PACKAGE 03 - ABI 03	03-26-19 - BID PACKAGE 03 - ABI 04
GENERAL						
G0.03	COVER / INDEX					
STRUCTURAL						
S0.01	ABBREVIATIONS AND LEGEND					
S0.02	GENERAL STRUCTURAL NOTES					
S0.03	GENERAL STRUCTURAL NOTES AND SPECIAL INSPECTION TABLES					
S1.02	BASEMENT FOUNDATION PLAN - SECTOR 2					
S1.10	FIRST FLOOR FRAMING PLAN - OVERALL PLAN					
S1.11	FIRST FLOOR FOUNDATION AND FRAMING PLAN - SECTOR 1					
S1.12	FIRST FLOOR FRAMING PLAN - SECTOR 2					
S1.13	FIRST FLOOR SLAB REINFORCEMENT PLAN - SECTOR 2					
S2.01	MOMENT FRAME ELEVATIONS					
S2.02	MOMENT FRAME AND BRACED FRAME ELEVATIONS					
S2.03	FOUNDATION PILASTER ELEVATIONS					
S3.01	BUILDING SECTIONS					
S3.02	BUILDING SECTIONS					
S3.11	FOUNDATION SECTIONS					
S3.12	FOUNDATION SECTIONS					
S4.01	ENLARGED STAIR PLANS					
S4.02	ENLARGED PLANS					
S5.11	CONCRETE DETAILS					
S6.01	TYPICAL VERTICAL CIRCULATION FOUNDATION DETAILS					
S6.01	SCHEDULES					
S7.11	TYPICAL CONCRETE DETAILS					
Grand total: 22						

CARDINAL
ENGINEERING
525 CENTRAL PARK DRIVE, SUITE 402
OKLAHOMA CITY, OK 73105
(405) 842-1096
CIVIL ENGINEERING


Chavez-Grievos
consulting engineers, Inc.
4700 LINCOLN ROAD NE, SUITE 102
ALBUQUERQUE, NM 87109
(505) 344-4080
STRUCTURAL ENGINEER

HP ENGINEERING, INC.
1836 SOUTH BALTIMORE AVE.
TULSA, OK 74119
(539) 664-4618
MECHANICAL & ELECTRICAL ENGINEER



Interior Logistics
1316 E 35TH PLACE, SUITE 100
TULSA, OK 74105
(918) 382-9120
EQUIPMENT PLANNER

HKS
1000 MACON ST., SUITE 150
FORT WORTH, TX 76102
(817) 348-0330
ARCHITECTURAL HEALTHCARE PLANNING


WSP
808 TRAVIS STREET, SUITE 200
HOUSTON, TX 77002
(281) 589-5900
FIRE PROTECTION / LIFE SAFETY

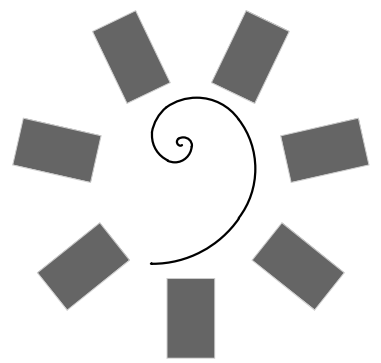

James R. Childers
Architect, Inc.
45 South 4th Street
Fort Smith, AR 72901
479-783-2450
www.childersarchitect.com

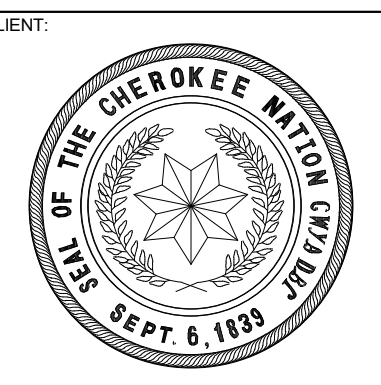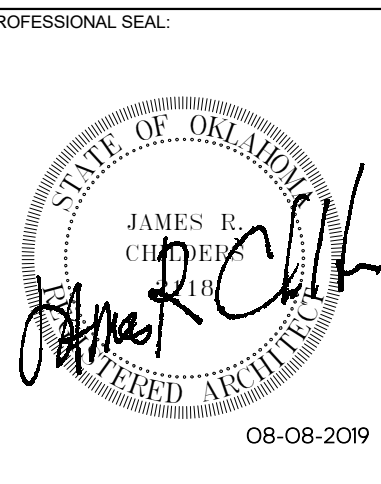

COLLEGE OF
Osteopathic Medicine
AT THE CHEROKEE NATION
TAHLEQUAH, OKLAHOMA

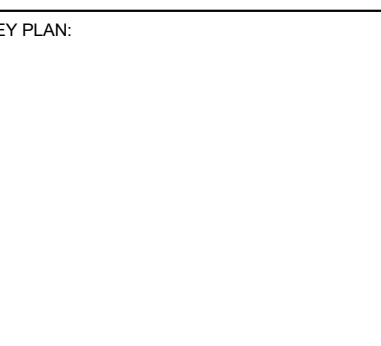





PROJECT PHASE:
BID PACKAGE 03

#	DATE	REVISIONS	DESCRIPTION
1	4/23/19	BID PACKAGE 03 ABI 01	
2	5/24/19	BID PACKAGE 03 ABI 02	
3	07/12/19	BID PACKAGE 03 ABI 03	
4	08/08/19	BID PACKAGE 03 ABI 04	

DATE: 03/20/19
JOB NUMBER: 17-13

SHEET NUMBER:
G0.03

COVER / INDEX

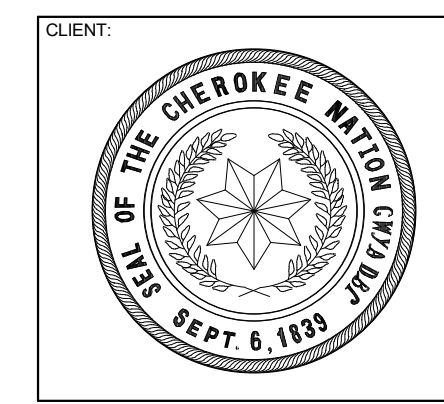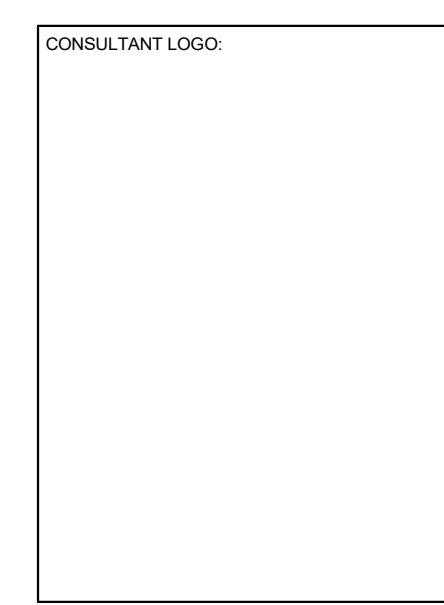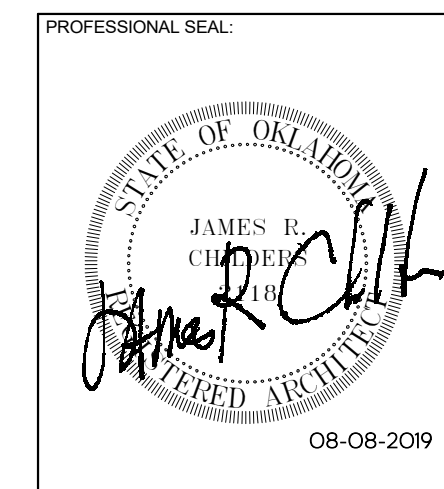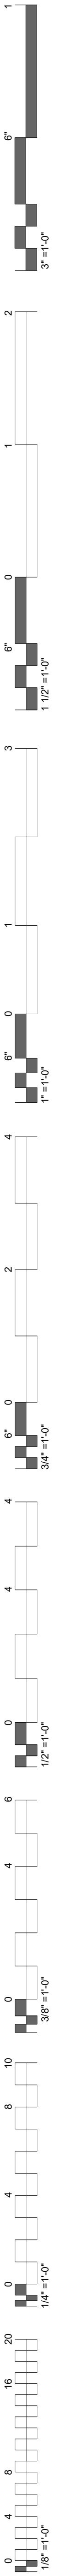

BID PACKAGE 04
(UNDERGROUND UTILITIES / STEEL)

Sheet Number	SHEET NAME	05-10-19 - BID PACKAGE 04	05-24-19 - BID PACKAGE 04 - AS-BUILT	07-17-19 - BID PACKAGE 04 - AS-BUILT	07-25-19 - BID PACKAGE 04 - AS-BUILT	08-07-19 - BID PACKAGE 04 - AS-BUILT
GENERAL						
G0.04	COVER / INDEX					
CIVIL						
C4-101	UTILITY PLAN					
C6-201	STORM SEWER PLAN AND PROFILE					
C6-202	STORM SEWER PLAN AND PROFILE					
C6-203	STORM SEWER PLAN AND PROFILE					
C6-204	FOOTER DRAIN PLAN AND PROFILE					
C6-205	FOOTER DRAIN PLAN AND PROFILE					
C6-501	STORM SEWER DETAILS					
C6-502	STORM SEWER DETAILS					
C6-503	STORM SEWER DETAILS					
C6-504	STORM SEWER DETAILS					
C6-505	STORM SEWER DETAILS					
C6-801	EXISTING HYDROLOGY					
C6-802	PROPOSED HYDROLOGY					
C6-901	SEWER PLAN AND PROFILE					
C6-901	LIFT STATION DETAILS					
STRUCTURAL						
S1-20	SECOND FLOOR FRAMING PLAN - OVERALL PLAN					
S1-21	SECOND FLOOR FRAMING PLAN - SECTOR 1					
S1-22	SECOND FLOOR FRAMING PLAN - SECTOR 2					
S1-30	THIRD FLOOR FRAMING PLAN - OVERALL PLAN					
S1-31	THIRD FLOOR FRAMING PLAN - SECTOR 1					
S1-32	THIRD FLOOR FRAMING PLAN - SECTOR 2					
S1-40	ROOF FRAMING PLAN - OVERALL PLAN					
S1-41	ROOF FRAMING PLAN - SECTOR 1					
S1-42	ROOF FRAMING PLAN - SECTOR 2					
S1-50	HIGH ROOF FRAMING PLAN - OVERALL PLAN					
S1-51	HIGH ROOF FRAMING PLAN - SECTOR 1					
S1-52	HIGH ROOF FRAMING PLAN - SECTOR 2					
S3-21	FRAMING SECTIONS					
S3-22	FRAMING SECTIONS					
S3-23	FRAMING SECTIONS					
S5-51	STEEL DETAILS					
S5-52	STEEL DETAILS					
S5-53	STEEL DETAILS					
S5-54	STEEL DETAILS					
S5-62	TYPICAL VERTICAL CIRCULATION FRAMING DETAILS					
S7-31	TYPICAL COLD-FORMED DETAILS					
S7-41	TYPICAL STEEL DETAILS					
S8-01	SIDEPLATE GENERAL NOTES AND CONSTRUCTION GUIDELINES					
S8-02	SIDEPLATE COLUMN DETAILS, A TYPE NO PLATE D					
S8-03	SIDEPLATE COLUMN DETAILS, B TYPE NO PLATE D					
S8-04	SIDEPLATE COLUMN DETAILS, A TYPE					
S8-05	SIDEPLATE BEAM DETAILS					
S8-06	SIDEPLATE BEAM DETAILS, NARROW					
S8-07	SIDEPLATE FIELD ERECTION DETAILS					
S8-08	SIDEPLATE MISC DETAILS AND COORDINATION ITEMS					
PLUMBING						
P0-00	PLUMBING DETAILS, LEGENDS, NOTES AND SCHEDULES					
P0-01	UNDERGROUND PLUMBING NOTES					
P0-02	UNDERGROUND FOOTING COORDINATION					
P0-03	UNDERGROUND BASEMENT PLUMBING PLAN					
P0-04	UNDERGROUND PLUMBING VENT/DRAIN ISOMETRIC BASEMENT					
P0-05	UNDERGROUND LEVEL 01 - OVERALL PLAN					
P0-06	UNDERGROUND LEVEL 01 PLUMBING PLAN					
P0-07	UNDERGROUND PLUMBING VENT/DRAIN ISOMETRIC LEVEL 01					
MECHANICAL						
M0-00	UNDERGROUND MECHANICAL PLAN					
M0-01	UNDERGROUND MECHANICAL NOTES					
ELECTRICAL						
E0-00	ELECTRICAL NOTES AND LEGEND					
E0-01	UNDERGROUND ELECTRICAL PLAN					
E0-02	UNDERGROUND ELECTRICAL FEEDER PLAN					
E0-03	UNDERGROUND BRANCH CIRCUIT PLAN BASEMENT LEVEL SECTOR 02					
E0-04	ELECTRICAL UNDERGROUND BRANCH CIRCUIT LEVEL 01 SECTOR 01					
FIRE PROTECTION						
FP2-01	FIRE PROTECTION - UNDERGROUND PLAN					

CARDINAL ENGINEERING
525 CENTRAL PARK DRIVE, SUITE 402
OKLAHOMA CITY, OK 73105
(405) 842-1096

CIVIL ENGINEERING

Chavez-Grievos
consulting engineers, Inc.
4700 LINCOLN ROAD NE, SUITE 102
ALBUQUERQUE, NM 87109
(505) 344-4080

STRUCTURAL ENGINEER

HP ENGINEERING, INC.
1836 SOUTH BALTIMORE AVE.
TULSA, OK 74119
(539) 664-4618

MECHANICAL & ELECTRICAL ENGINEER

Interior Logistics
1316 E 35TH PLACE, SUITE 100
TULSA, OK 74105
(918) 382-9120

EQUIPMENT PLANNER

HKS
1000 MACON ST., SUITE 150
FORT WORTH, TX 76102
(817) 348-0330

ARCHITECTURAL HEALTHCARE PLANNING

WSP
808 TRAVIS STREET, SUITE 200
HOUSTON, TX 77002
(281) 589-5900

FIRE PROTECTION / LIFE SAFETY

COLLEGE OF
Osteopathic Medicine
AT THE CHEROKEE NATION
TAHLEQUAH, OKLAHOMA

KEY PLAN:

PROJECT PHASE:
BID PACKAGE 04

#	DATE	REVISIONS	DESCRIPTION
1	05/24/19	BID PACKAGE 04 A01 01	
2	06/11/19	BID PACKAGE 04 A01 02	
3	07/22/19	BID PACKAGE 04 A01 03	
4	07/29/19	BID PACKAGE 04 A01 04	
5	08/08/19	BID PACKAGE 04 A01 05	

DATE: **05-10-19** JOB NUMBER: **17-13**

SHEET NUMBER:
G0.04

COVER / INDEX