

CHEROKEE NATION REPLACEMENT HOSPITAL

VOLUME 03 OF 11 (LIFE SAFETY / ARCHITECTURE)



Parkhill
4101 WIRELESS WAY, SUITE 350
OKLAHOMA CITY, OK 73134
(405) 832-9900



PALMERTON & PARRISH, INC.
4168 W. KEARNY ST.
SPRINGFIELD, MO 65803
(417) 864-6000




FEC HELIPORTS
5228 RIVER ROAD
CINCINNATI, OH 45233
(877) HELIPAD



hfsd
landscape architecture
HOWARD-FAIRBAIRN SITE DESIGN
3100 NW 149TH ST
OKLAHOMA CITY, OK 73134
(405) 752-8018



HKS
999 18th St, #225N
DENVER, CO 80202
(303) 293-2903

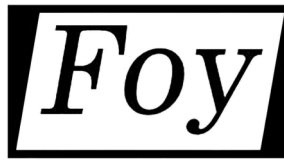

Foy
Consulting &
Engineering, LLC
FOY CONSULTING & ENGINEERING, LLC
6900 COLLEGE BLVD #600
OVERLAND, KS 66211
(913) 312-0075



HP ENGINEERING
HP ENGINEERING, INC.
5504 PINNACLE POINTE DRIVE, SUITE 200
ROGERS, AR 72758
(479) 898-6370



Interior Logistics
INTERIOR LOGISTICS
1316 E 35TH PLACE, SUITE 100
TULSA, OK 74105
(918) 382-9120



MOBLEY FIRE PROTECTION
6242 LLANO AVE.
DALLAS, TX 75214
(817) 614-2361



FDP
2655 VILLA CREEK DR. #233
DALLAS, TX 75234
(972) 245-5300



ECOWORKS STUDIO
659 AUBURN AVE. NE, SUITE 135
ATLANTA, GA 30312
(404) 480-4499



CRUX
CRUX TECHNOLOGY + SECURITY SOLUTIONS
401 SOUTH BOSTON AVE, SUITE 500-15
TULSA, OK 74103
(800) 685-6440



D 2 C
DIRECT 2 COMPLETION
7134 S. YALE AVE #400
TULSA, OK 74136
(918) 457-6905



FOREMAN | MANHATTAN
Construction Team
FOREMAN MANHATTAN CONSTRUCTION TEAM
5601 S 122nd E AVE
TULSA, OK 74146
(918) 878-3492

CIVIL ENGINEERING

GEOTECHNICAL ENGINEERING

HELIPAD DESIGN

LANDSCAPE ARCHITECTURE

INTERIOR ARCHITECTURE | INTERIOR DESIGN

STRUCTURAL ENGINEER

MECHANICAL | ELECTRICAL | PLUMBING

EQUIPMENT | FURNITURE PLANING

FIRE PROTECTION | LIFE SAFETY

FOOD SERVICE

LEED CONSULTING


LOW-VOLTAGE | IT | SECURITY

OWNERS REPRESENTATIVE

CONSTRUCTION MANAGER

PROFESSIONAL SEAL:

CONSULTANT LOGO:

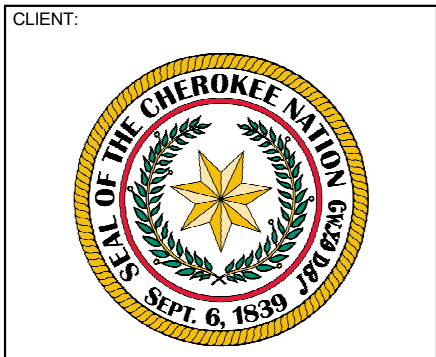


**CHEROKEE NATION
REPLACEMENT HOSPITAL**
TAHLEQUAH, OKLAHOMA

KEY PLAN:


PROJECT PHASE:
BID PACKAGE 03
(ELEVATORS)

#	DATE	REVISIONS DESCRIPTION

JOB NUMBER: 21-08.21
DATE: 10-07-2022
SHEET NUMBER:
VOL 03
SHEET TITLE:
COVER SHEET

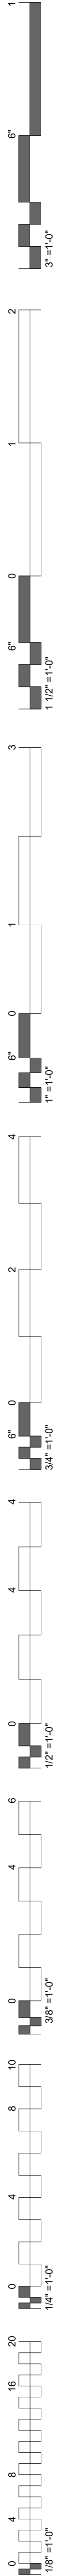

INDEX OF DRAWINGS - VOLUME 01 - CIVIL		
SHEET NUMBER	SHEET NAME	BID PACKAGE 01 - 07-26-2022 ADDENDUM 01 - 08-17-2022 BID PACKAGE 03 - 10-07-2022
GENERAL		
VOL 01	COVER SHEET	
G0.01	DRAWING INDEX	
CIVIL		
G0-102	GENERAL CIVIL NOTES - BP1	
C1-103	EXISTING CONDITIONS	
C1-104	EXISTING CONDITIONS	
C1-105	EXISTING CONDITIONS	
C2-108	NP DEMOLITION OVERVIEW	
C2-109	NP 1 DEMOLITION PLAN	
C2-110	NP2 DEMOLITION PLAN	
C2-111	NP3 DEMOLITION PLAN	
C2-112	NP4 DEMOLITION PLAN	
C2-113	NP5 DEMOLITION PLAN	
C2-702	NP EROSION CONTROL PLAN	
C2-750	EROSION CONTROL DETAILS	
C3-108	NP SITE PLAN OVERVIEW	
C3-109	NP1 SITE PLAN	
C3-110	NP2 SITE PLAN	
C3-111	NP3 SITE PLAN	
C3-112	NP4 SITE PLAN	
C3-113	NP5 SITE PLAN	
C3-501	SITE DETAILS	
C3-502	SITE DETAILS	
C3-503	CONCRETE PAVING JOINT DETAILS	
C5-113	NP GRADING OVERVIEW	
C5-114	NP1 GRADING PLAN	
C5-115	NP2 GRADING PLAN	
C5-116	NP3 GRADING PLAN	
C5-117	NP4 GRADING PLAN	
C5-118	NP5 GRADING PLAN	
C5-210	NP COORDINATES AND ELEVATIONS TABLE	
C6-201	NP STORM PLAN & PROFILE	
C6-202	NP STORM PLAN & PROFILE	
C6-501	STORM DRAIN DETAILS	
C6-502	STORM DRAIN DETAILS	
C6-503	STORM DRAIN DETAILS	
C6-504	STORM DRAIN DETAILS	
C6-505	STORM DRAIN DETAILS	
C6-802	NP EXISTING HYDROLOGY	
C6-803	NP DEVELOPMENT HYDROLOGY	
C8-201	FORCE MAIN PLAN & PROFILE	
C8-501	FORCE MAIN DETAILS	
C9-201	DOWNING DRIVEWAY PLAN AND PROFILE	
C9-501	DOWNING DRIVEWAY DETAILS	
Grand total: 43		
INDEX OF DRAWINGS - VOLUME 03 - ARCHITECTURE		
SHEET NUMBER	SHEET NAME	BID PACKAGE 01 - 07-26-2022 ADDENDUM 01 - 08-17-2022 BID PACKAGE 03 - 10-07-2022
GENERAL		
VOL 03	COVER SHEET	
G0.01	DRAWING INDEX	
ARCHITECTURE		
A1.10A	FLOOR PLAN - LEVEL 01 - OVERALL	
A1.20A	FLOOR PLAN - LEVEL 02 - OVERALL	
A1.30A	FLOOR PLAN - LEVEL 03 - OVERALL	
A1.40A	FLOOR PLAN - LEVEL 04 - OVERALL	
A1.50A	FLOOR PLAN - LEVEL 05 - OVERALL	
A1.60A	FLOOR PLAN - LEVEL 06 - OVERALL	
A1.70	FLOOR PLAN - HIGH ROOF	
A1.71	FLOOR PLAN - HELIPAD	
A4.20	PUBLIC ELEVATOR PLANS AND SECTIONS	
A4.21	PATIENT TRANSFER ELEVATOR PLANS AND SECTIONS	
A4.22	STAFF / LOADING DOCK ELEVATOR PLANS AND SECTIONS	
A4.23	ELEVATOR DETAILS	
Grand total: 14		
INDEX OF DRAWINGS - VOLUME 07 - ELECTRICAL		
SHEET NUMBER	SHEET NAME	BID PACKAGE 01 - 07-26-2022 ADDENDUM 01 - 08-17-2022 BID PACKAGE 03 - 10-07-2022
GENERAL		
VOL 07	COVER SHEET	
G0.01	DRAWING INDEX	
ELECTRICAL		
ENL 00	ELECTRICAL LEGEND	
ENL 01	ELECTRICAL SITE PLAN - NORTH LOT	
Grand total: 4		
INDEX OF DRAWINGS - VOLUME 09 - TECHNOLOGY / DAS		
SHEET NUMBER	SHEET NAME	BID PACKAGE 01 - 07-26-2022 ADDENDUM 01 - 08-17-2022 BID PACKAGE 03 - 10-07-2022
GENERAL		
VOL 09	COVER SHEET	
G0.01	DRAWING INDEX	
TECHNOLOGY		
TNS 1.02	NETWORK SITE PLAN - NORTH PARKING & ACCESS	
Grand total: 3		

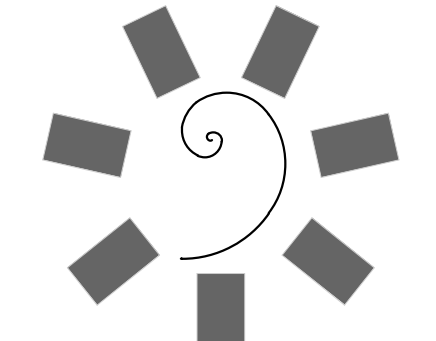

James R. Childers
Architect, Inc.
45 South 4th Street
Fort Smith, AR 72901
479-783-2450
www.childersarchitect.com

PROFESSIONAL SEAL:

CONSULTANT LOGO

CLIENT:




CHEROKEE NATION
REPLACEMENT HOSPITAL
TAHLEQUAH, OKLAHOMA

KEY PLAN:

PROJECT PHASE:
BID PACKAGE 03
(ELEVATORS)


#	DATE	REVISIONS
1	08-17-22	ADDENDUM 01
2	10-07-22	BID PACKAGE 03

JOB NUMBER: 21-08.21
DATE: 10-07-2022
SHEET NUMBER: **G0.01**
SHEET TITLE: DRAWING INDEX


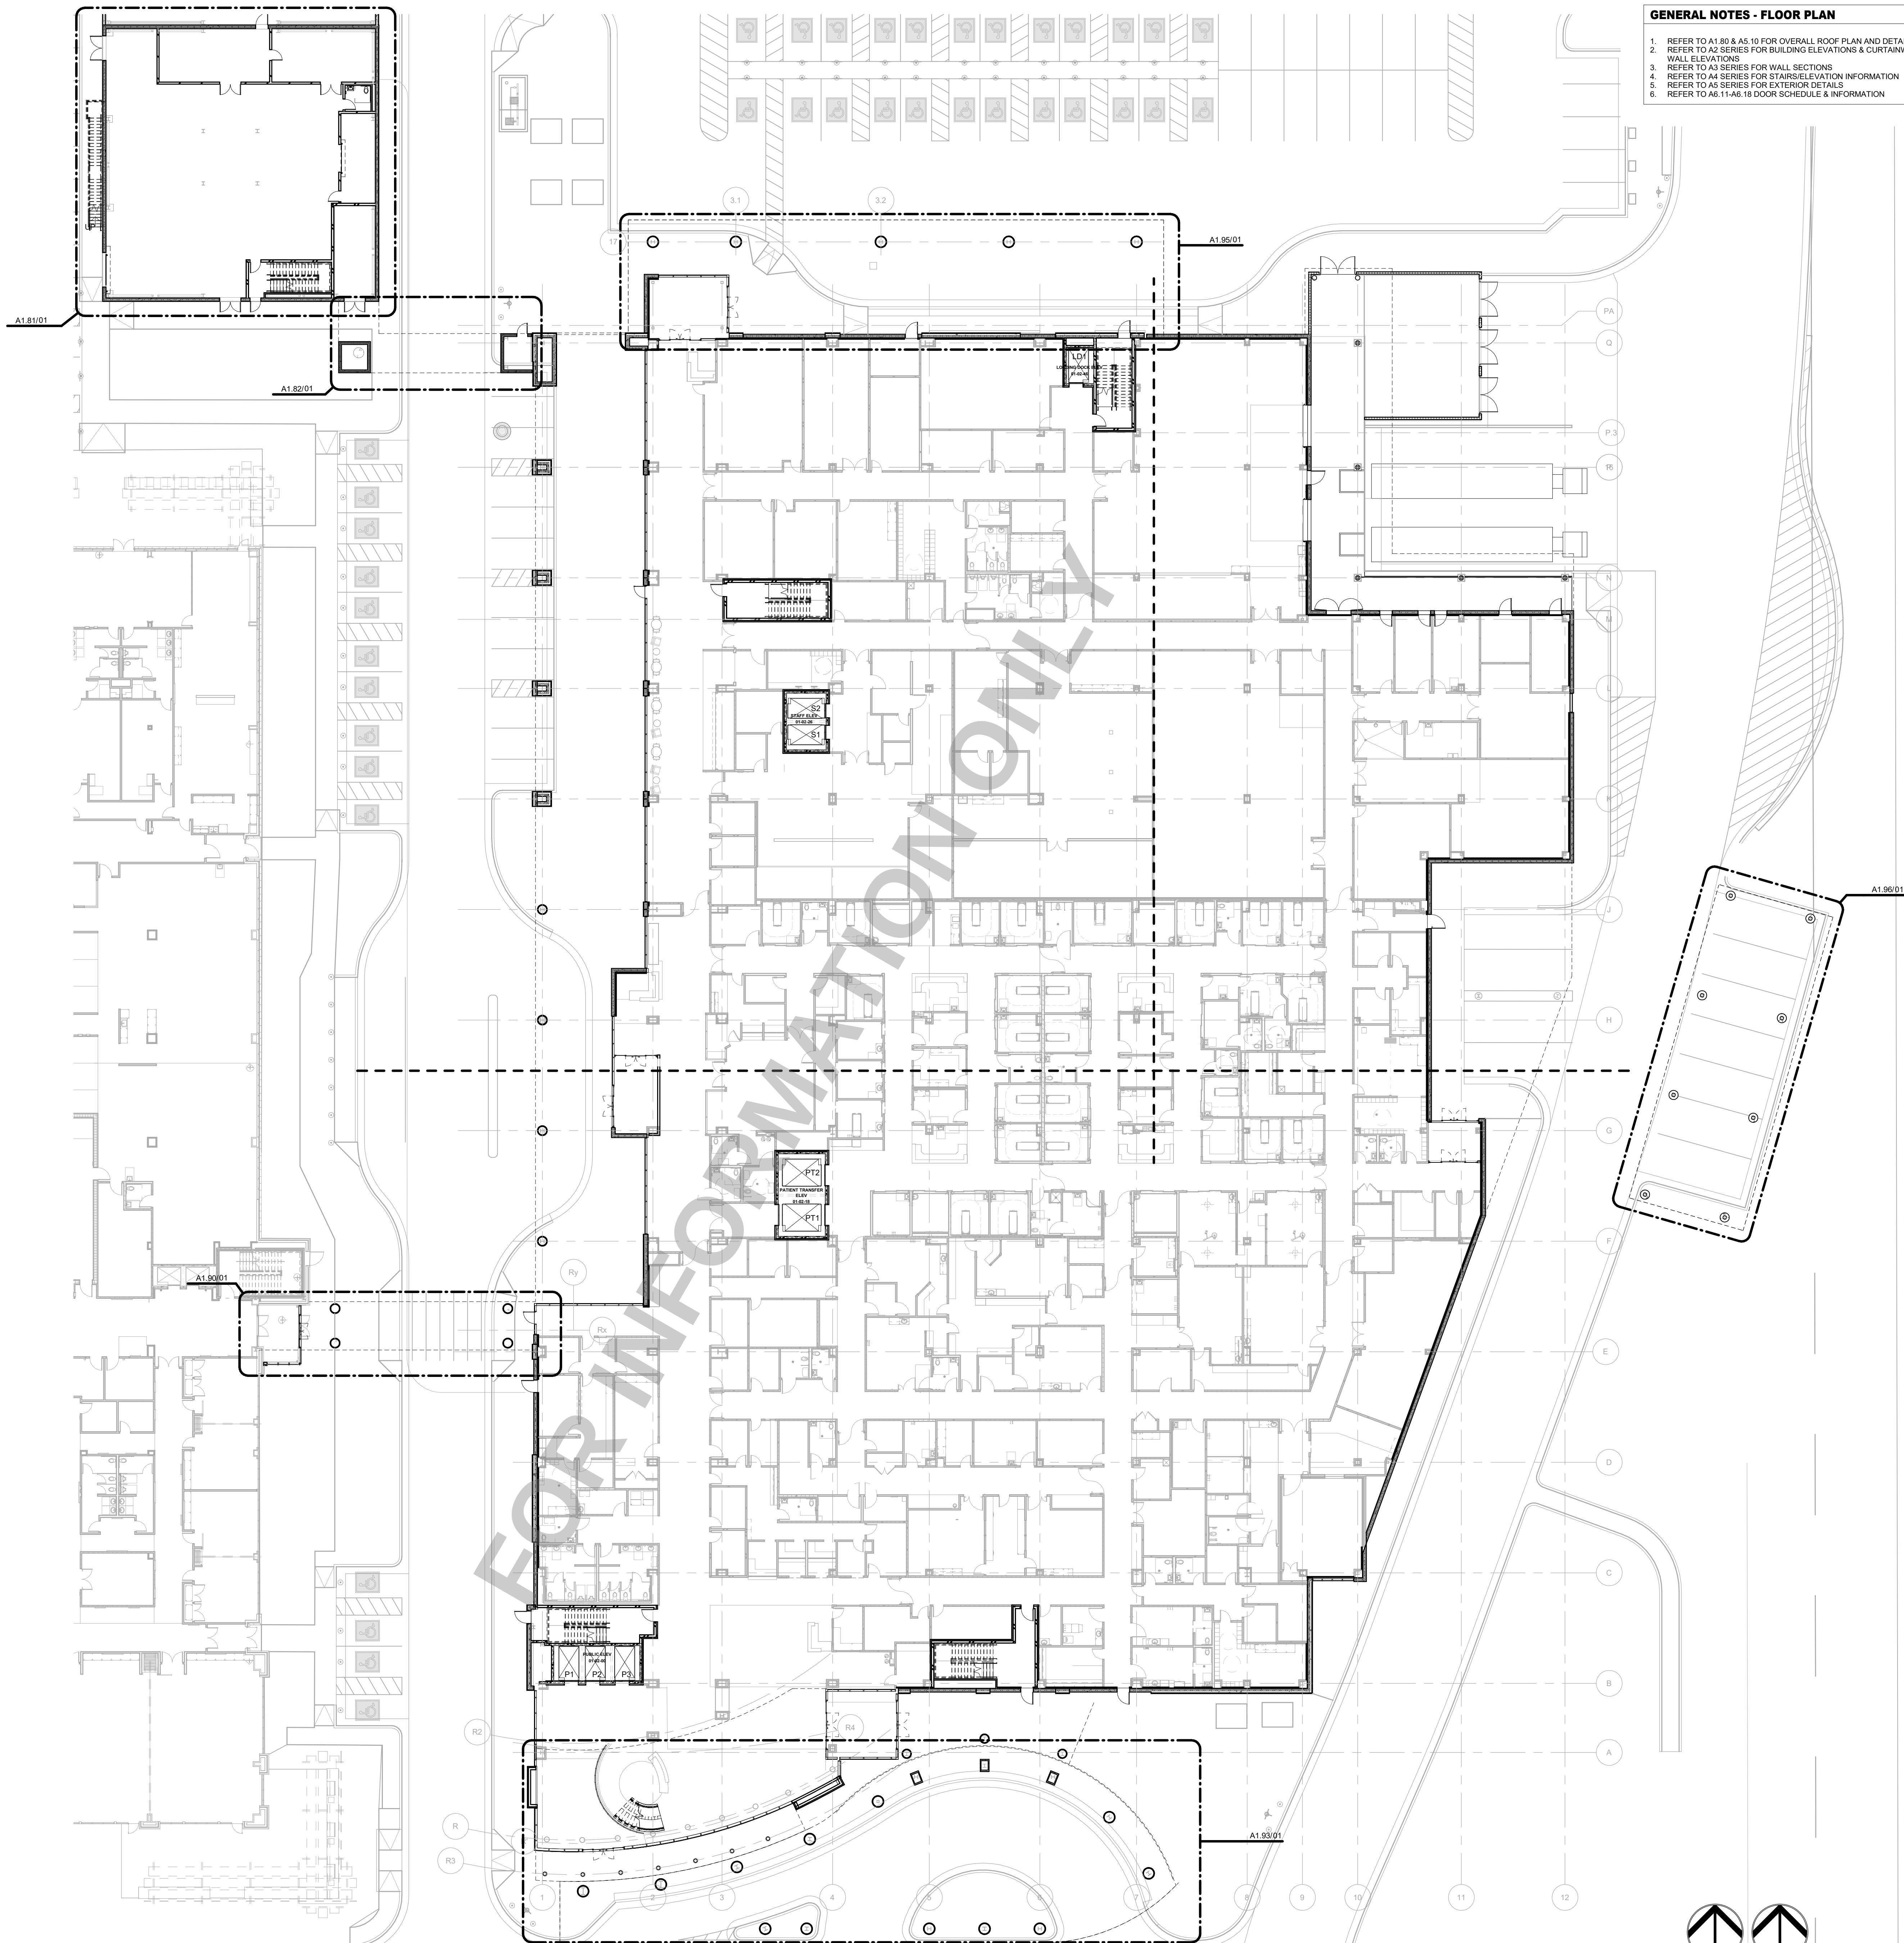
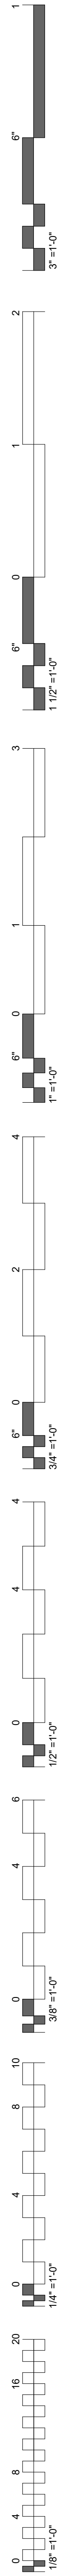


- GENERAL NOTES - FLOOR PLAN**
1. REFER TO A1.80 & A5.10 FOR OVERALL ROOF PLAN AND DETAILS
 2. REFER TO A2 SERIES FOR BUILDING ELEVATIONS & CURTAINWALL/WINDOW WALL ELEVATIONS
 3. REFER TO A4 SERIES FOR WALL SECTIONS
 4. REFER TO A4 SERIES FOR STAIRS/ELEVATION INFORMATION
 5. REFER TO A4 SERIES FOR EXTERIOR DETAILS
 6. REFER TO A6.11-A6.18 DOOR SCHEDULE & INFORMATION


01 FLOOR PLAN - LEVEL 01 - OVERALL
1" = 20'-0"

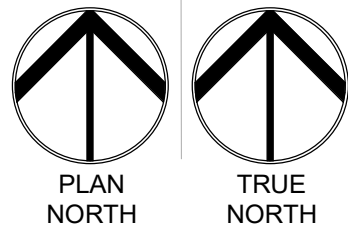

**James R. Childers
Architect, Inc.**
45 South 4th Street
Fort Smith, AR 72901
479-783-2480
www.childersarchitect.com

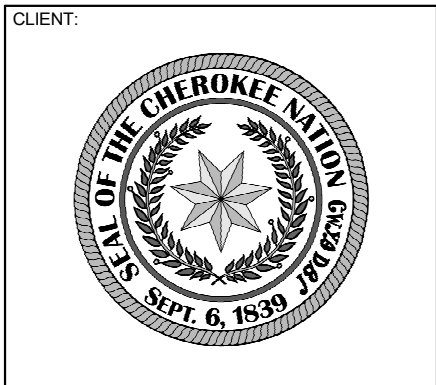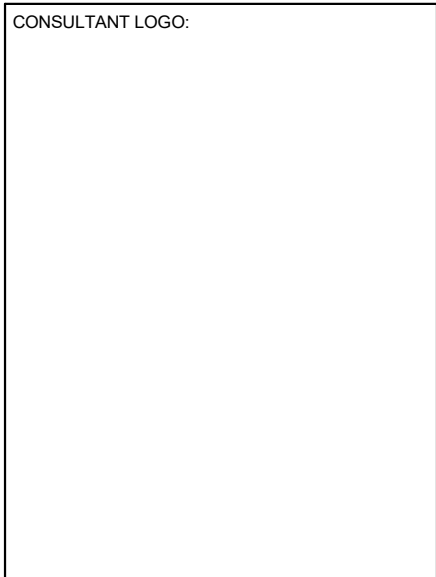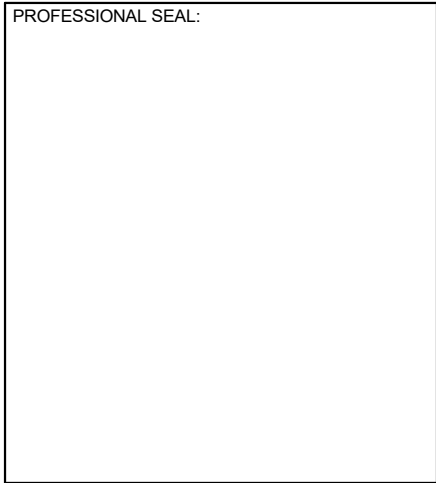



**CHEROKEE NATION
REPLACEMENT HOSPITAL**
TAHLEQUAH, OKLAHOMA

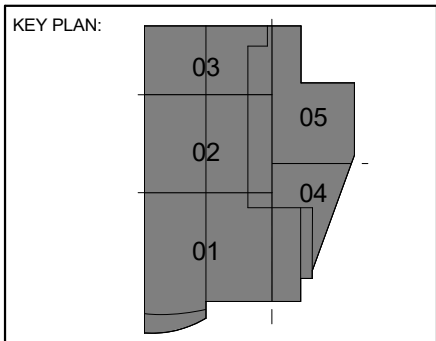

PROJECT PHASE:
BID PACKAGE 03
(ELEVATORS)

#	DATE	REVISIONS DESCRIPTION

JOB NUMBER: 21-08.21
DATE: 10-07-2022
SHEET NUMBER:
A1.10A
SHEET TITLE:
FLOOR PLAN - LEVEL 01
- OVERALL

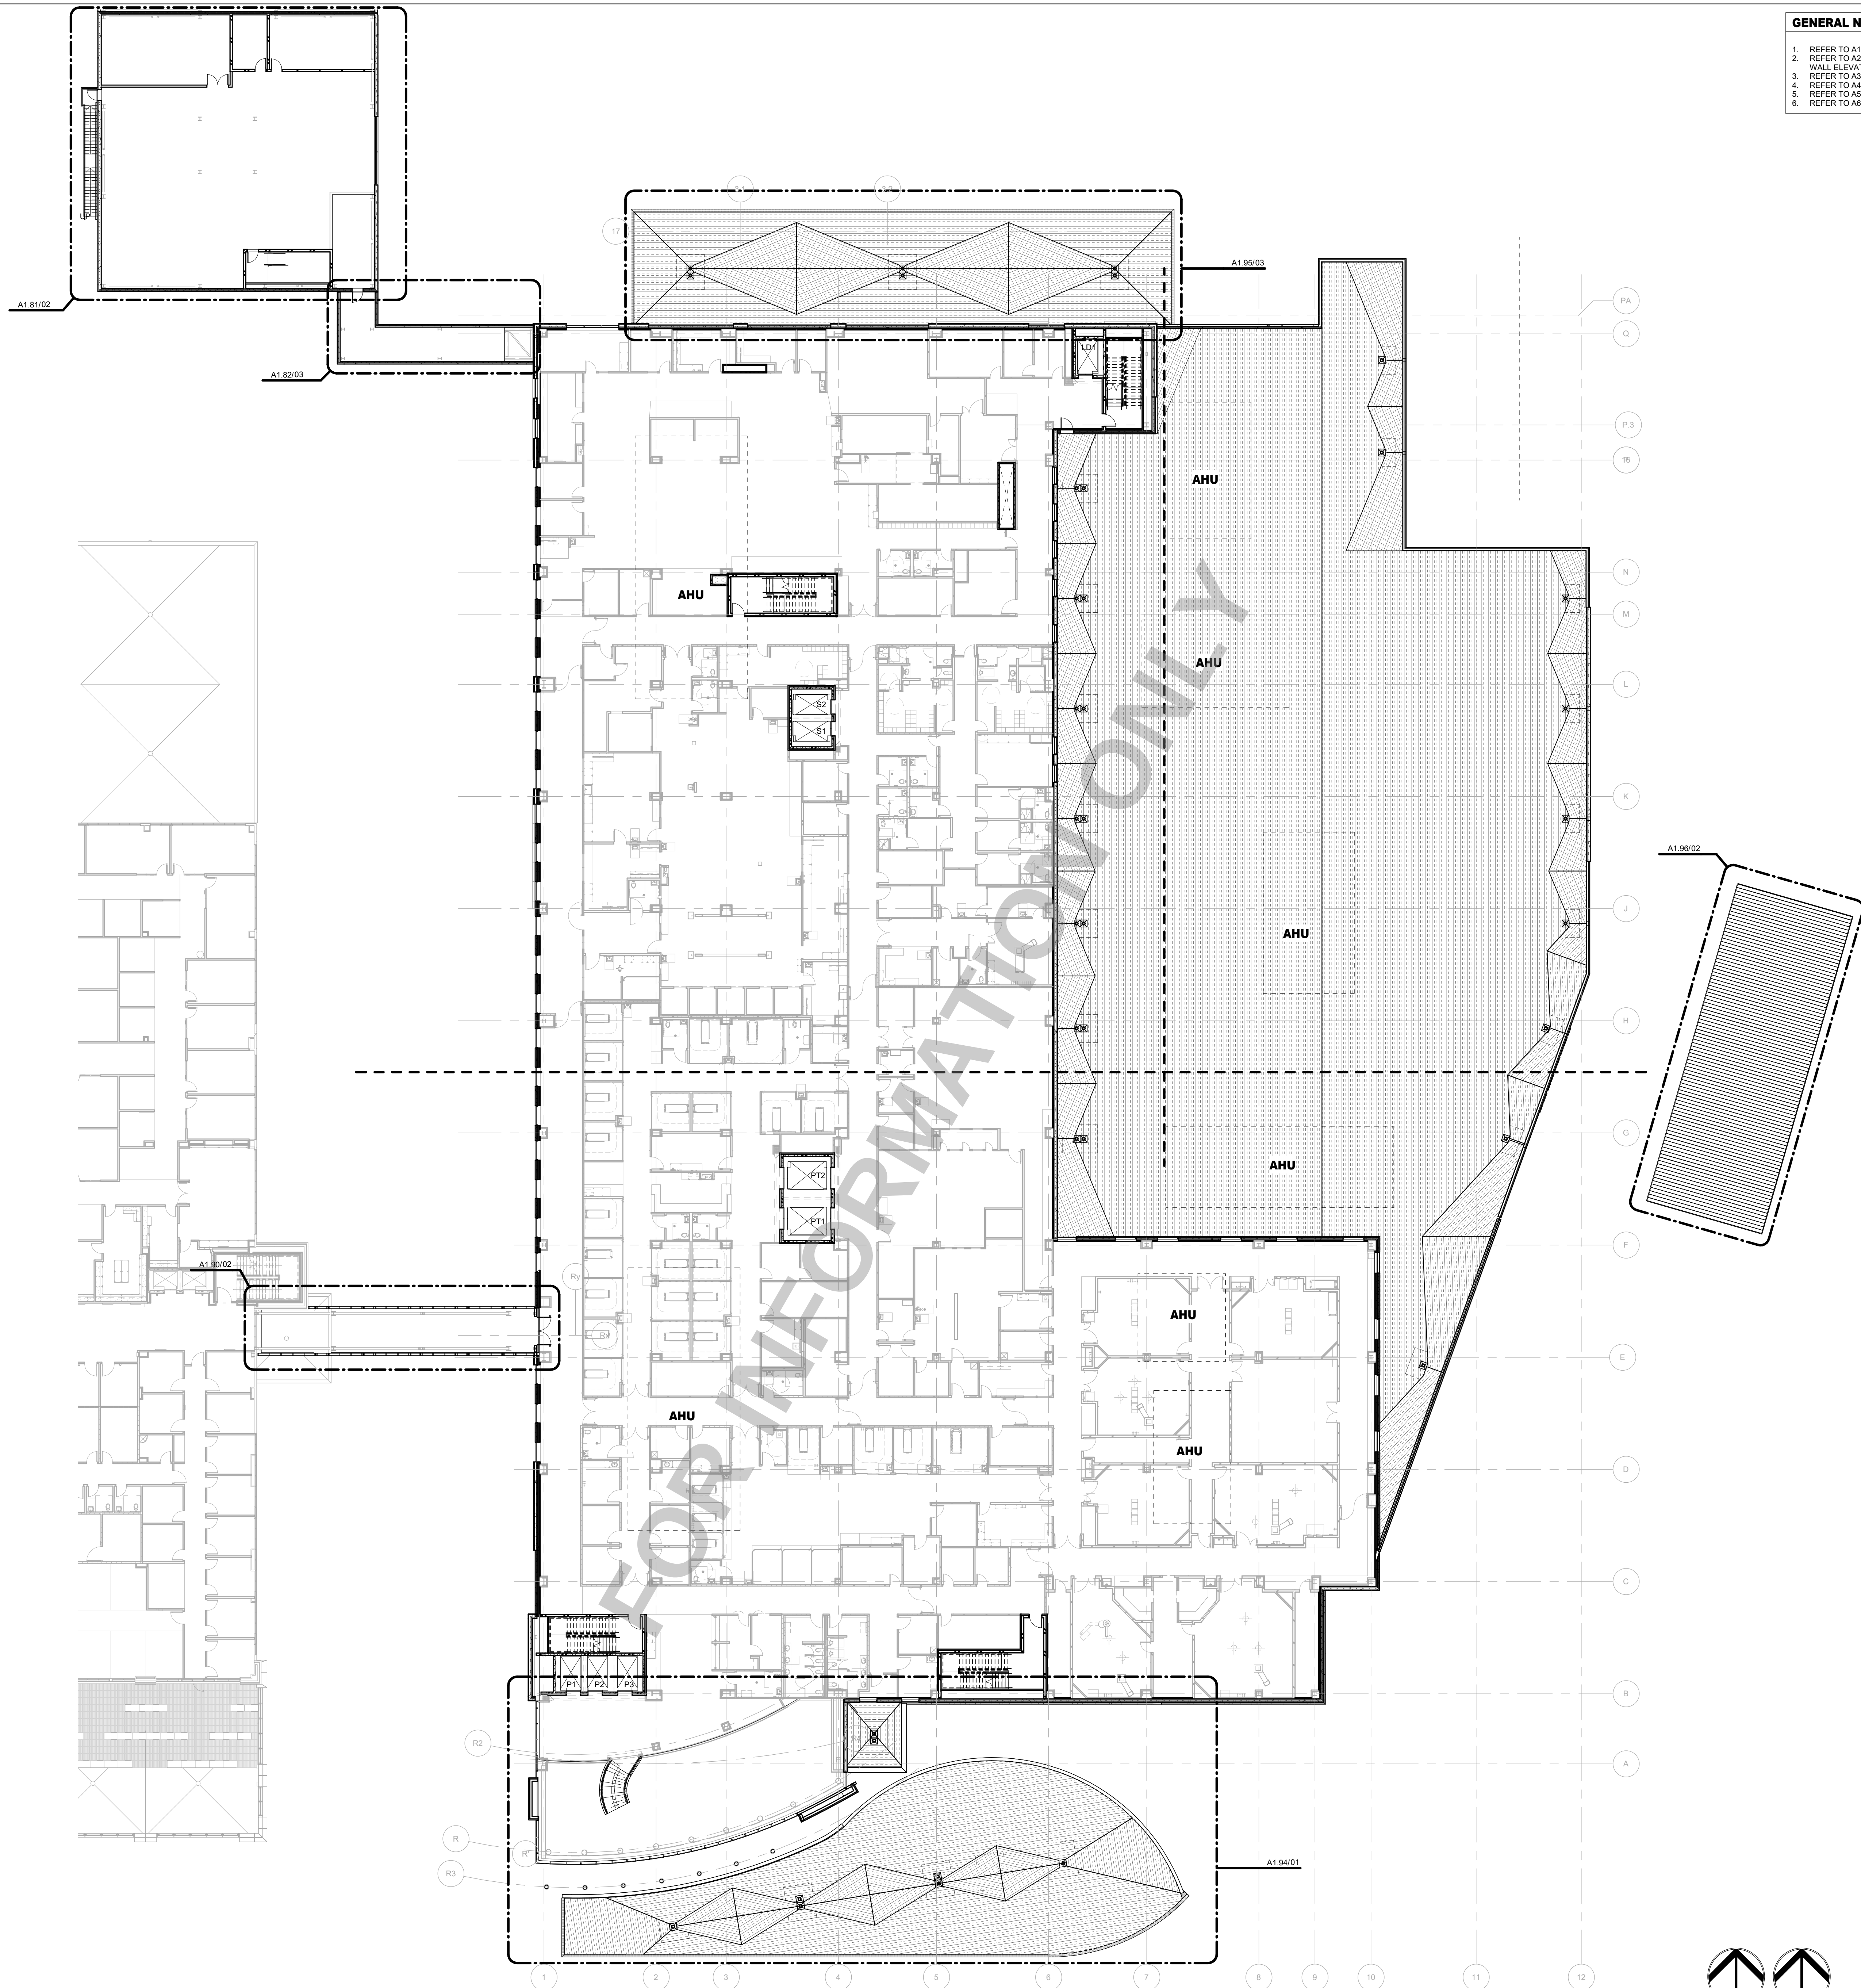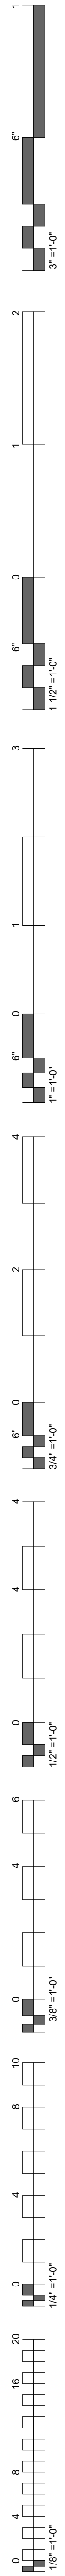


- GENERAL NOTES - FLOOR PLAN**
1. REFER TO A1.80 & A5.10 FOR OVERALL ROOF PLAN AND DETAILS
 2. REFER TO A2 SERIES FOR BUILDING ELEVATIONS & CURTAINWALL/WINDOW WALL ELEVATIONS
 3. REFER TO A4 SERIES FOR WALL SECTIONS
 4. REFER TO A4 SERIES FOR STAIRS/ELEVATION INFORMATION
 5. REFER TO A6 SERIES FOR EXTERIOR DETAILS
 6. REFER TO A6.11-A6.18 DOOR SCHEDULE & INFORMATION


James R. Childers Architect, Inc.
45 South 4th Street
Fort Smith, AR 72901
479-783-2480
www.childersarchitect.com

PROFESSIONAL SEAL:

CONSULTANT LOGO:

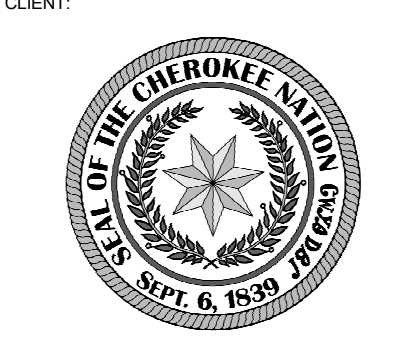

**CHEROKEE NATION
REPLACEMENT HOSPITAL**
TAHLEQUAH, OKLAHOMA

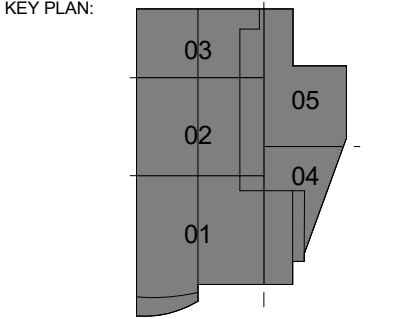




PROJECT PHASE:
BID PACKAGE 03
(ELEVATORS)

#	DATE	REVISIONS	DESCRIPTION


JOB NUMBER: 21-08.21
DATE: 10-07-2022
SHEET NUMBER:
A1.20A
SHEET TITLE:
FLOOR PLAN - LEVEL 02
- OVERALL

01 FLOOR PLAN - LEVEL 02 - OVERALL
1" = 20'-0"

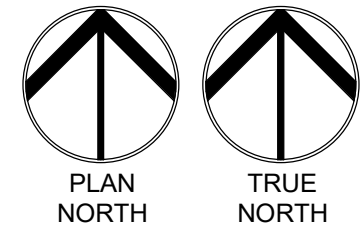


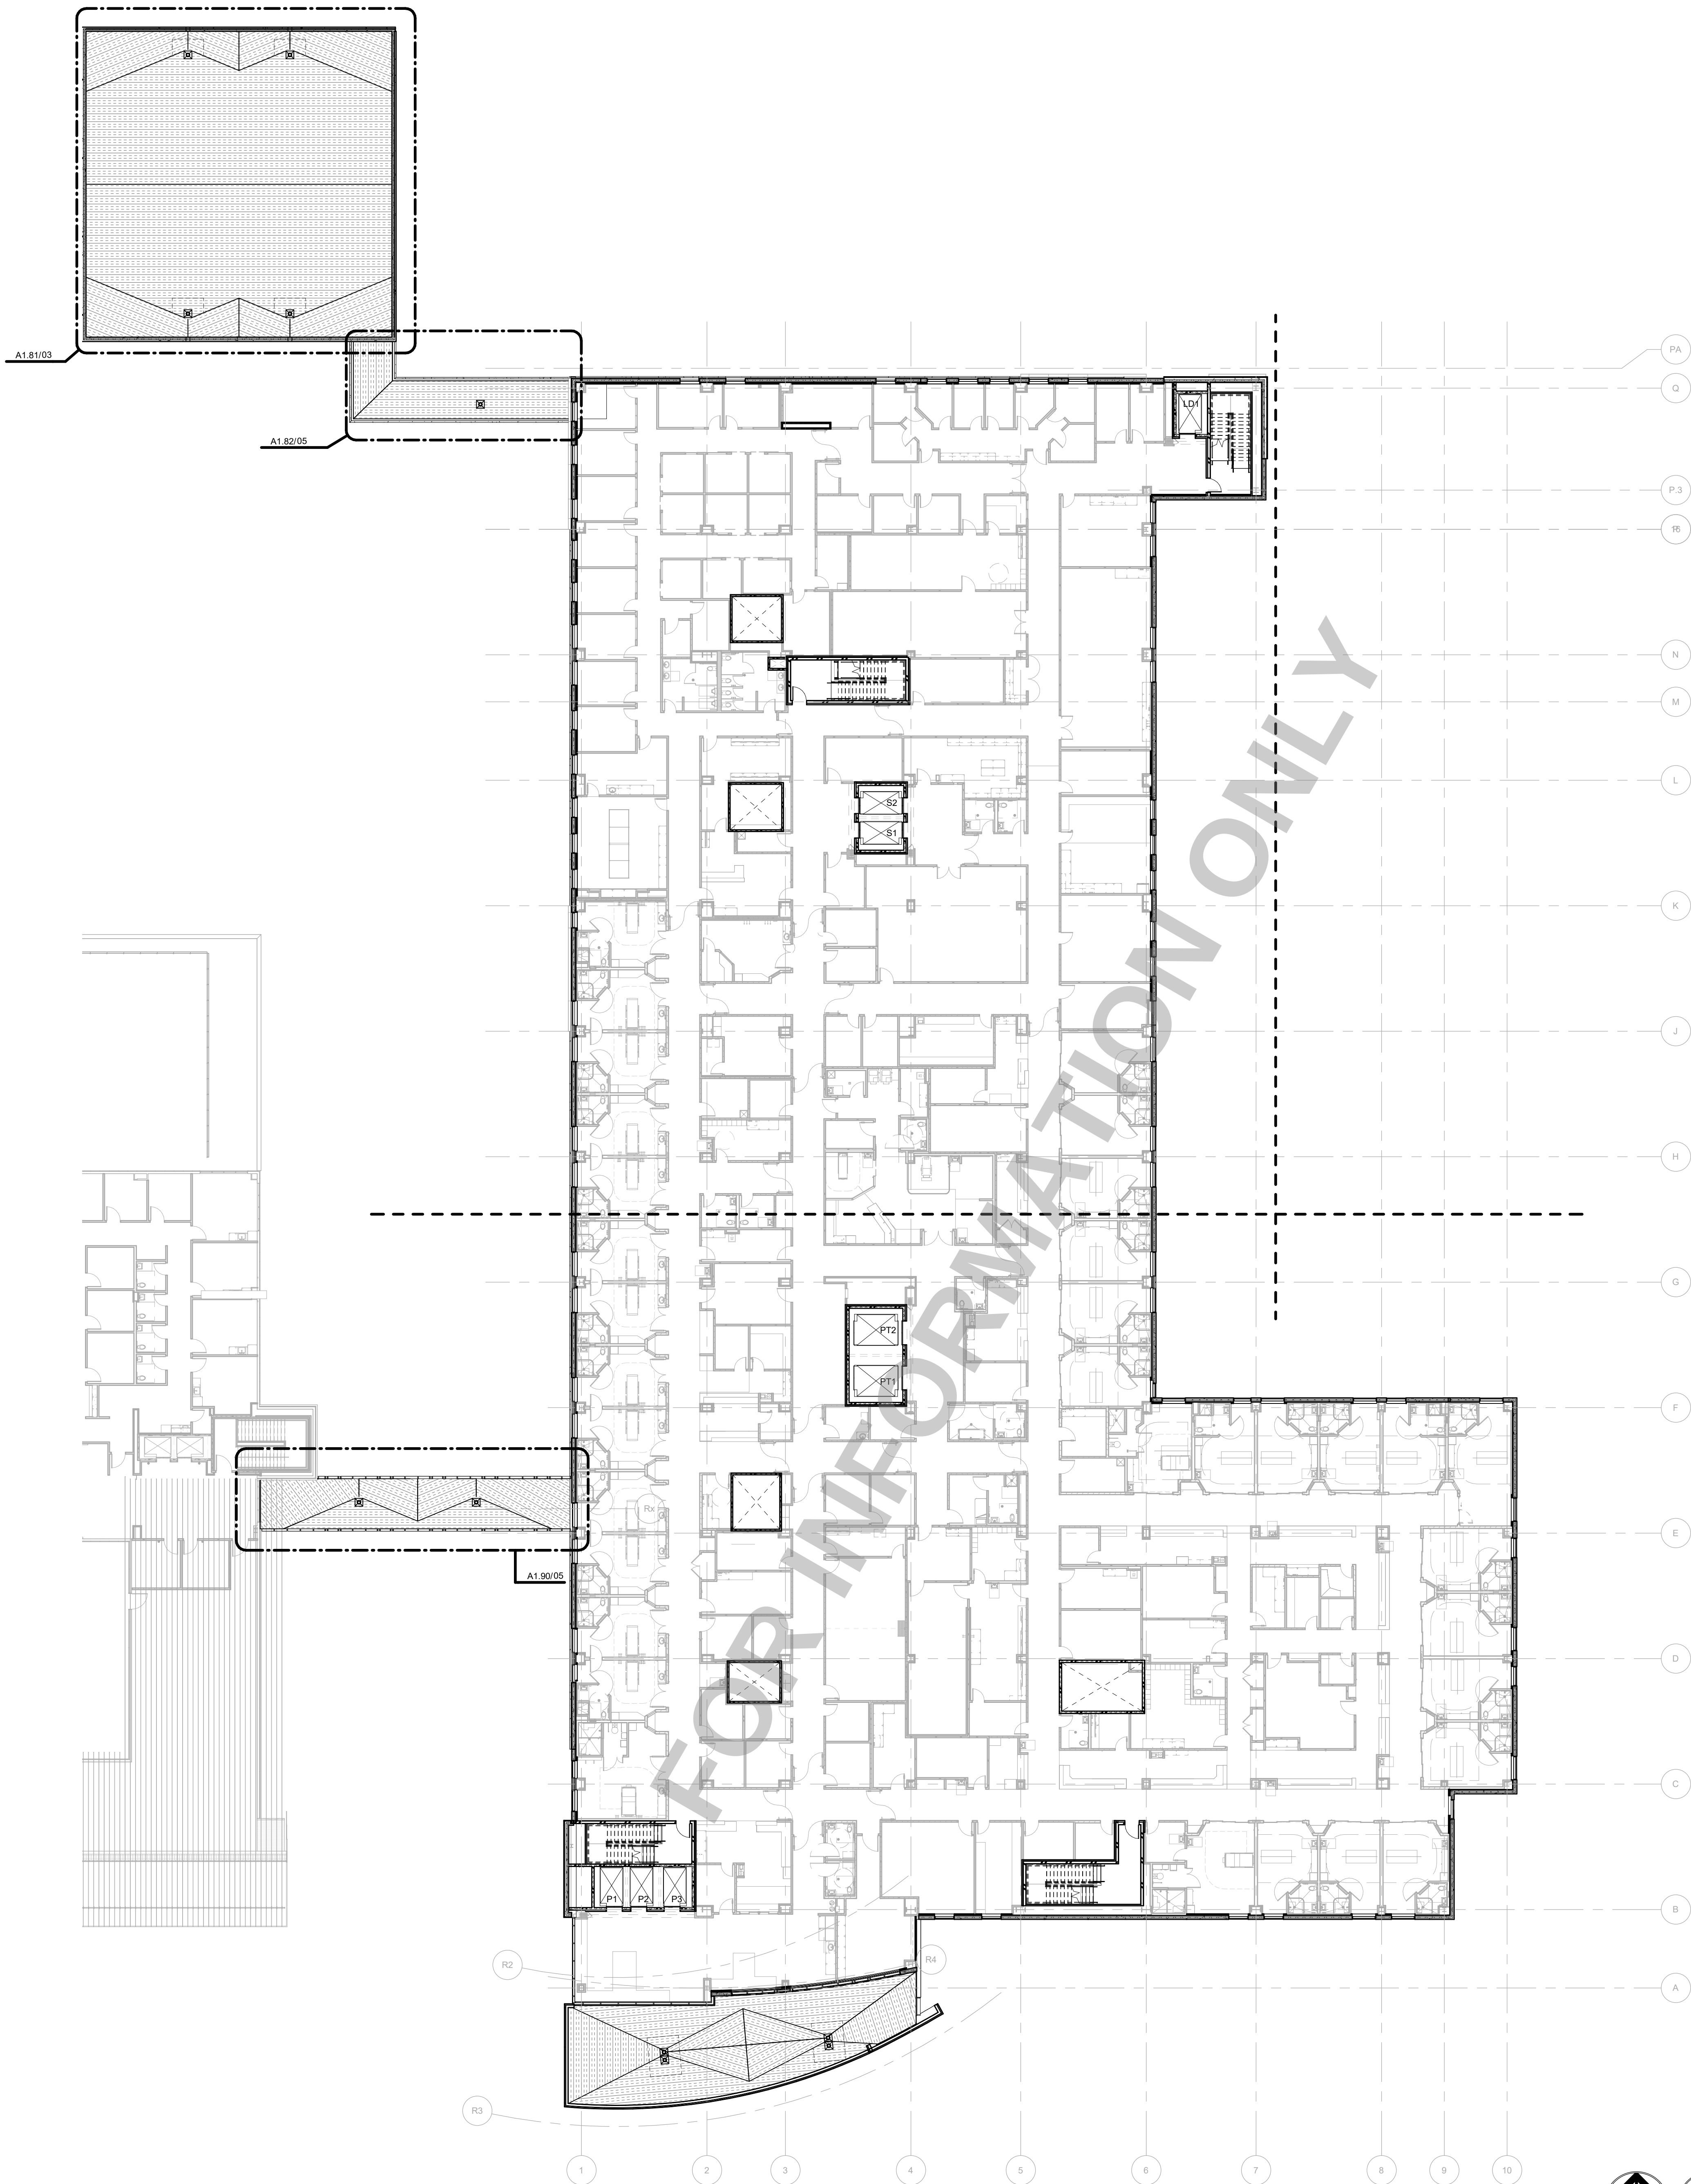
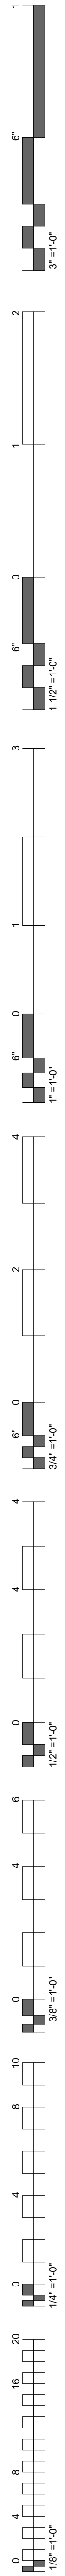


01 FLOOR PLAN - LEVEL 03 - OVERALL
1" = 20'-0"

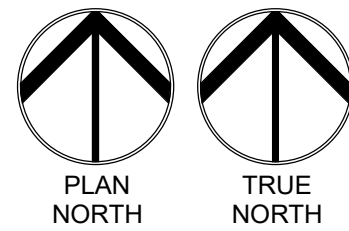


- GENERAL NOTES - FLOOR PLAN**
1. REFER TO A1.80 & A5.10 FOR OVERALL ROOF PLAN AND DETAILS
 2. REFER TO A2 SERIES FOR BUILDING ELEVATIONS & CURTAINWALL/WINDOW WALL ELEVATIONS
 3. REFER TO A4 SERIES FOR WALL SECTIONS
 4. REFER TO A4 SERIES FOR STAIRS/ELEVATION INFORMATION
 5. REFER TO A5 SERIES FOR EXTERIOR DETAILS
 6. REFER TO A6.11-A6.18 DOOR SCHEDULE & INFORMATION

James R. Childers Architect, Inc.
45 South 4th Street
Fort Smith, AR 72901
479-783-2460
www.childersarchitect.com

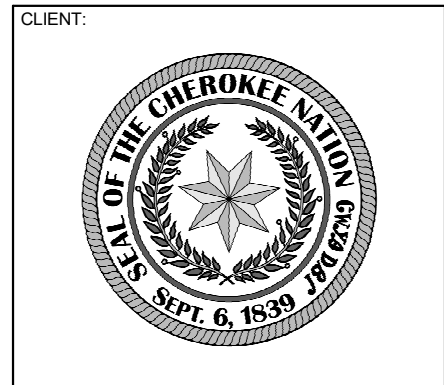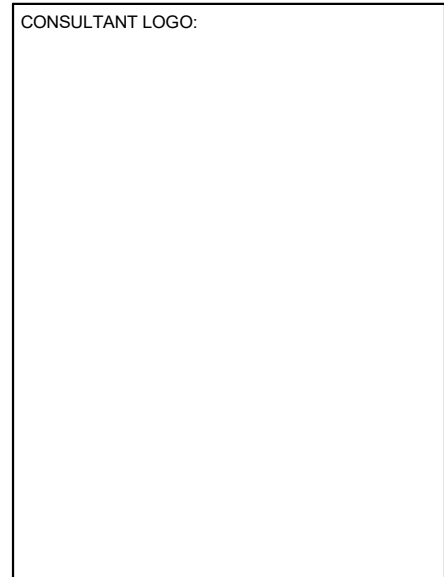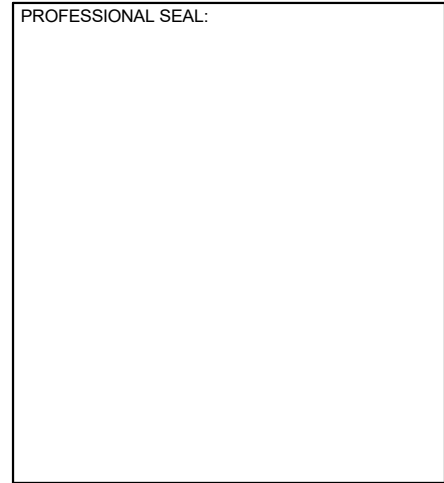



**CHEROKEE NATION
REPLACEMENT HOSPITAL**
TAHLEQUAH, OKLAHOMA

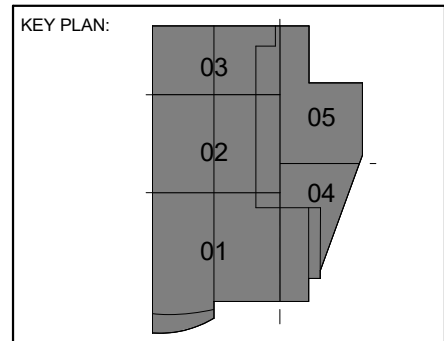


PROJECT PHASE:
BID PACKAGE 03
(ELEVATORS)

#	DATE	REVISIONS DESCRIPTION

JOB NUMBER: 21-08.21
DATE: 10-07-2022
SHEET NUMBER:
A1.30A
SHEET TITLE:
FLOOR PLAN - LEVEL 03
- OVERALL


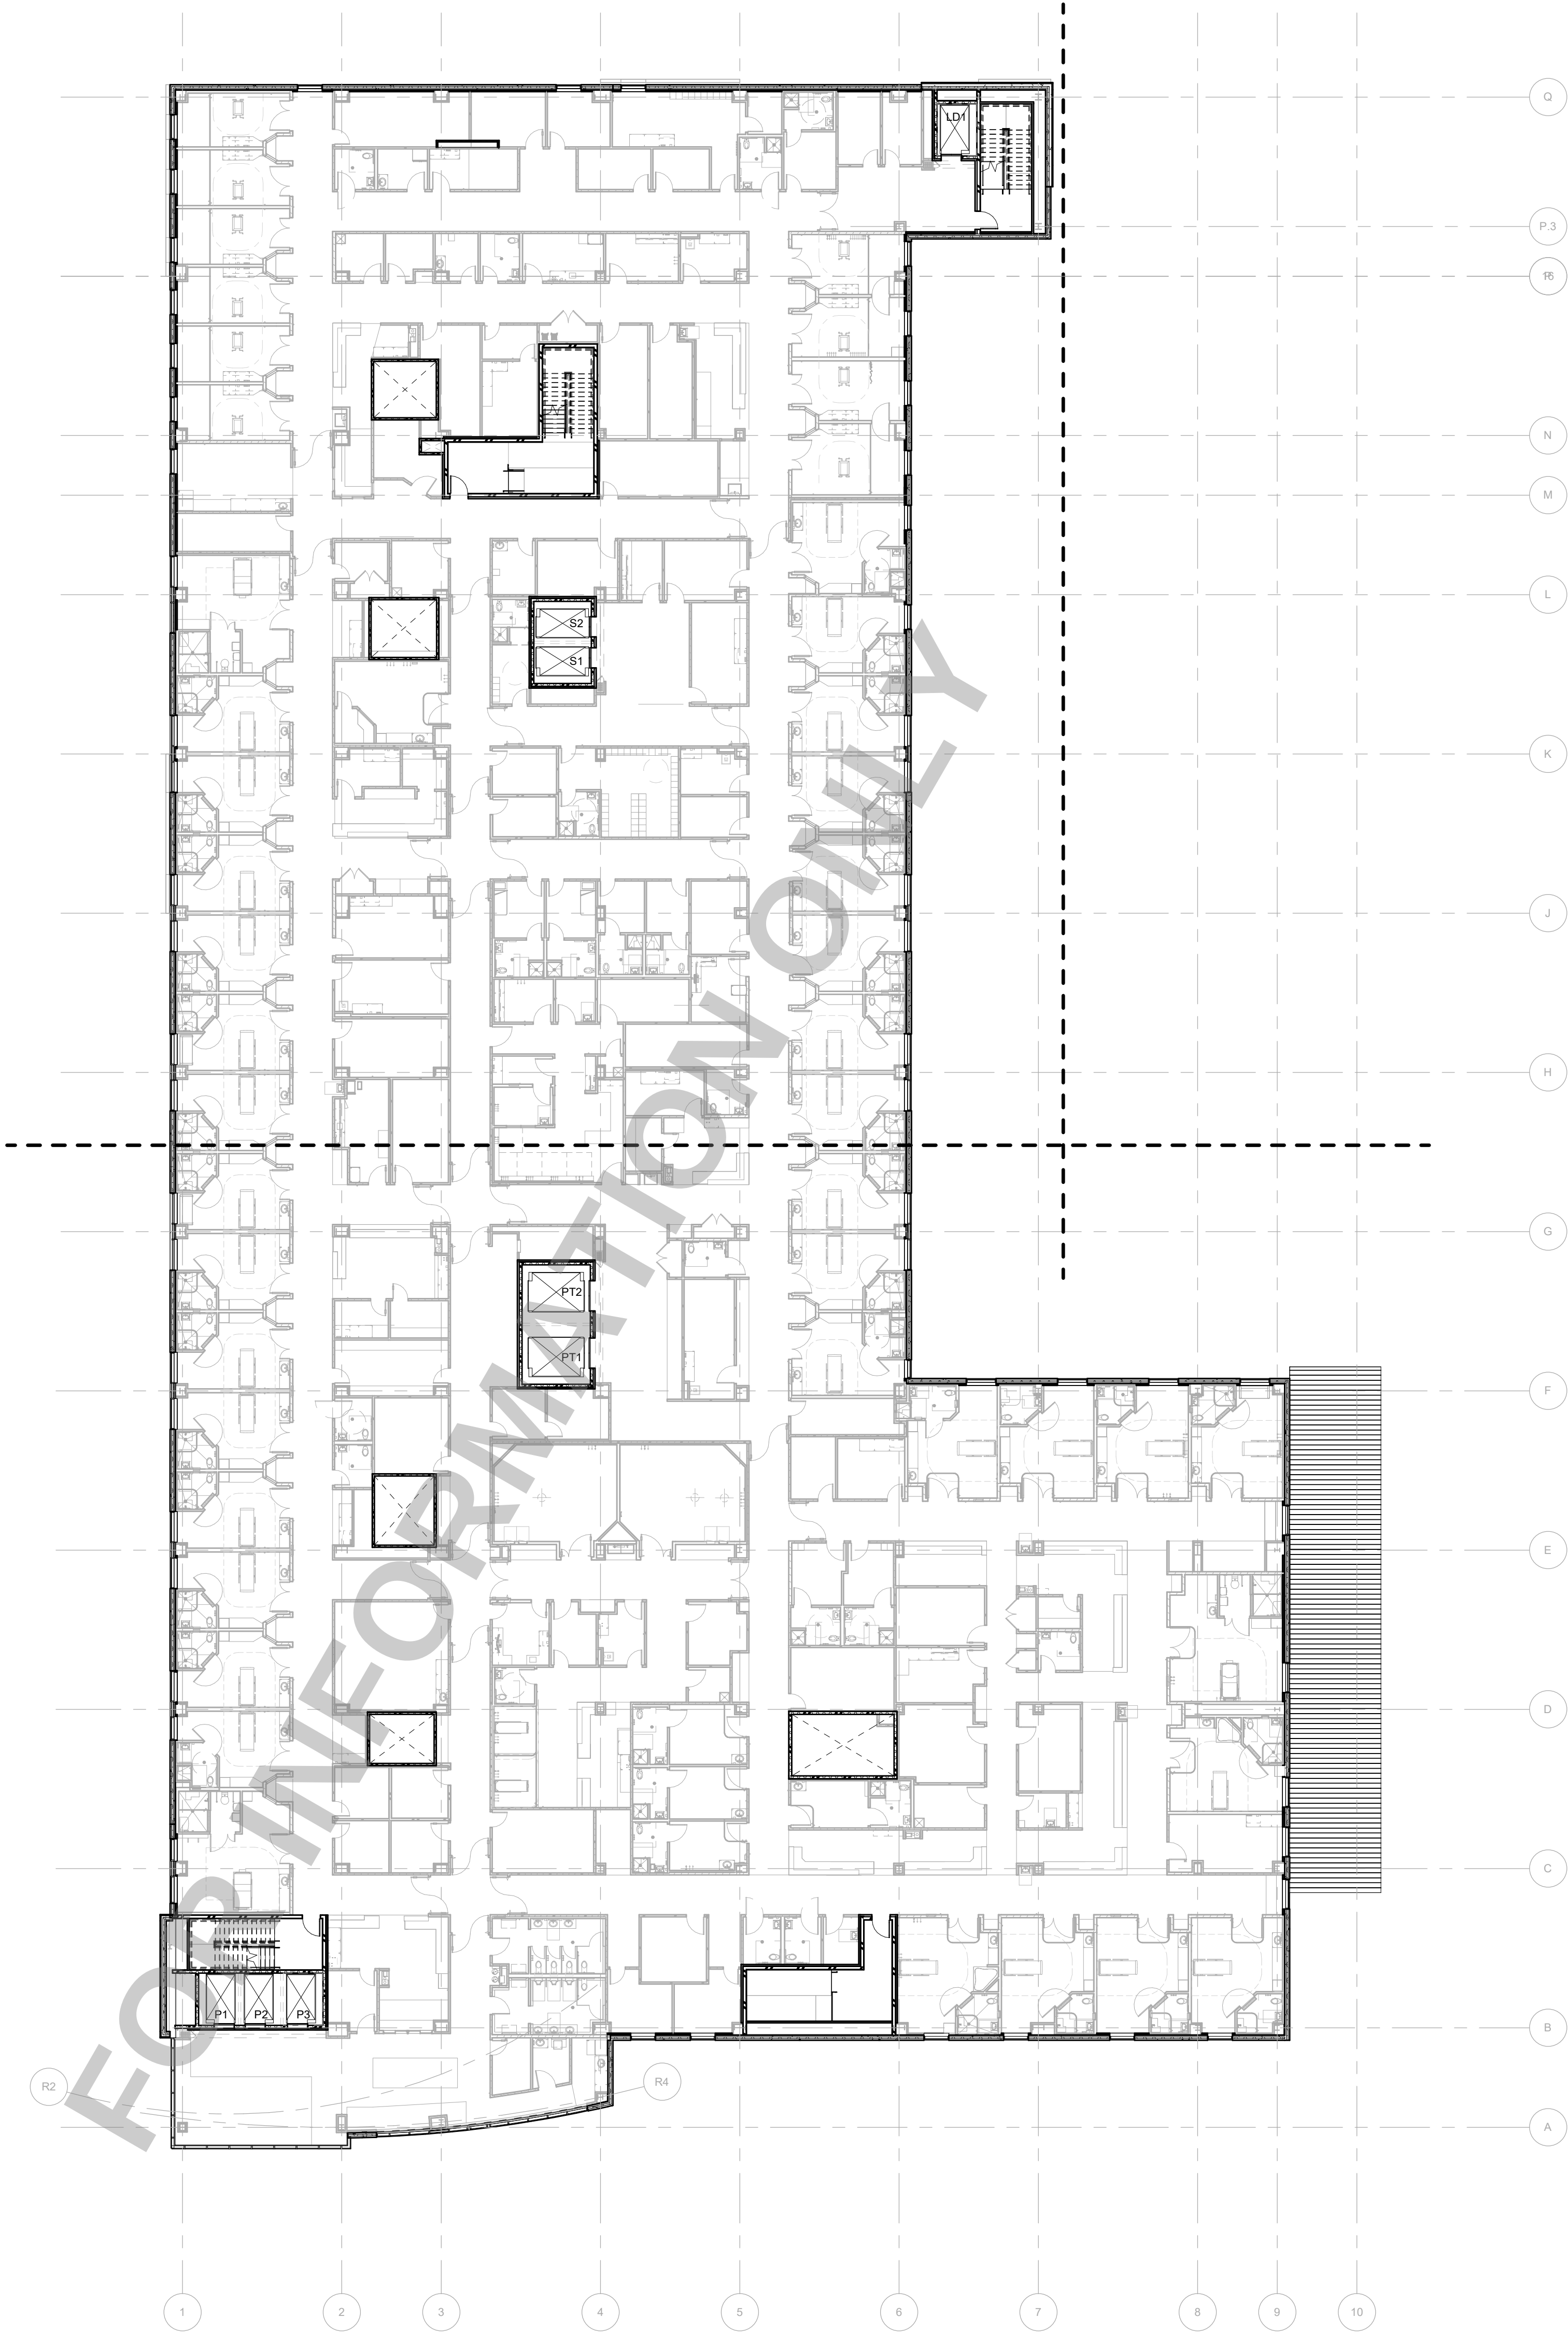
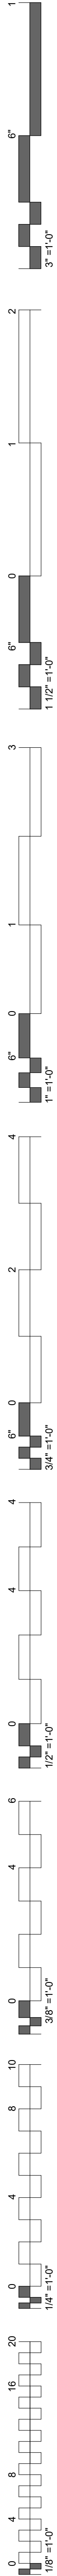


01 FLOOR PLAN - LEVEL 04 - OVERALL
1" = 20'-0"

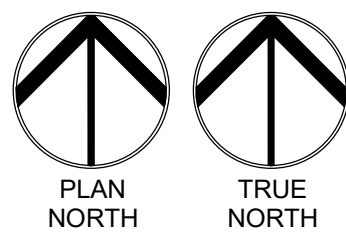


- GENERAL NOTES - FLOOR PLAN**
1. REFER TO A1.80 & A5.10 FOR OVERALL ROOF PLAN AND DETAILS
 2. REFER TO A2 SERIES FOR BUILDING ELEVATIONS & CURTAINWALL/WINDOW WALL ELEVATIONS
 3. REFER TO A4 SERIES FOR WALL SECTIONS
 4. REFER TO A4 SERIES FOR STAIRS/ELEVATION INFORMATION
 5. REFER TO A5 SERIES FOR EXTERIOR DETAILS
 6. REFER TO A6.11-A6.18 DOOR SCHEDULE & INFORMATION

James R. Childers Architect, Inc.
45 South 4th Street
Fort Smith, AR 72901
479-783-2450
www.childersarchitect.com

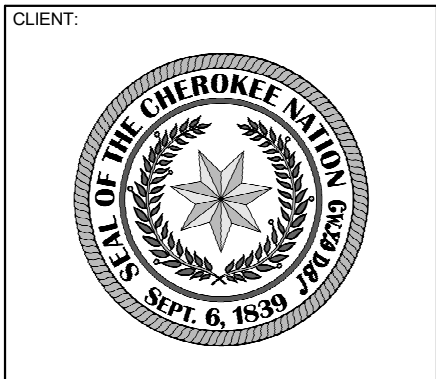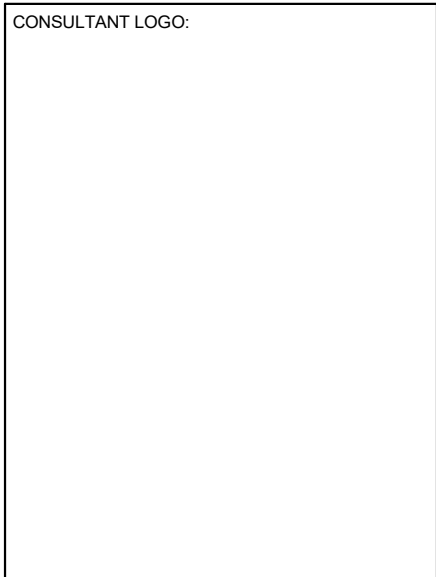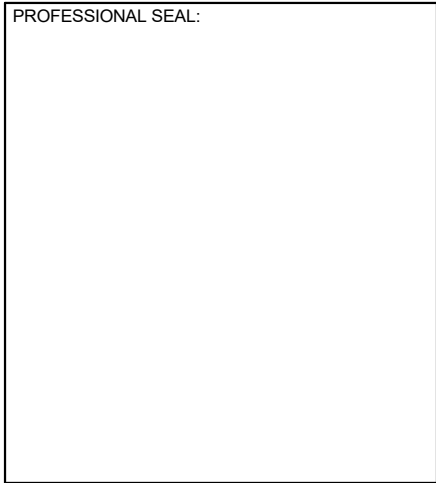


**CHEROKEE NATION
REPLACEMENT HOSPITAL**
TAHLEQUAH, OKLAHOMA

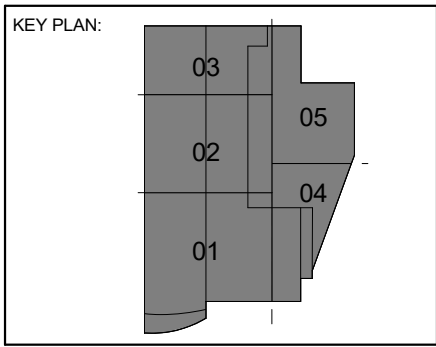


PROJECT PHASE:
BID PACKAGE 03
(ELEVATORS)

#	DATE	REVISIONS DESCRIPTION

JOB NUMBER: 21-08.21
DATE: 10-07-2022
SHEET NUMBER:
A1.40A
SHEET TITLE:
FLOOR PLAN - LEVEL 04
- OVERALL

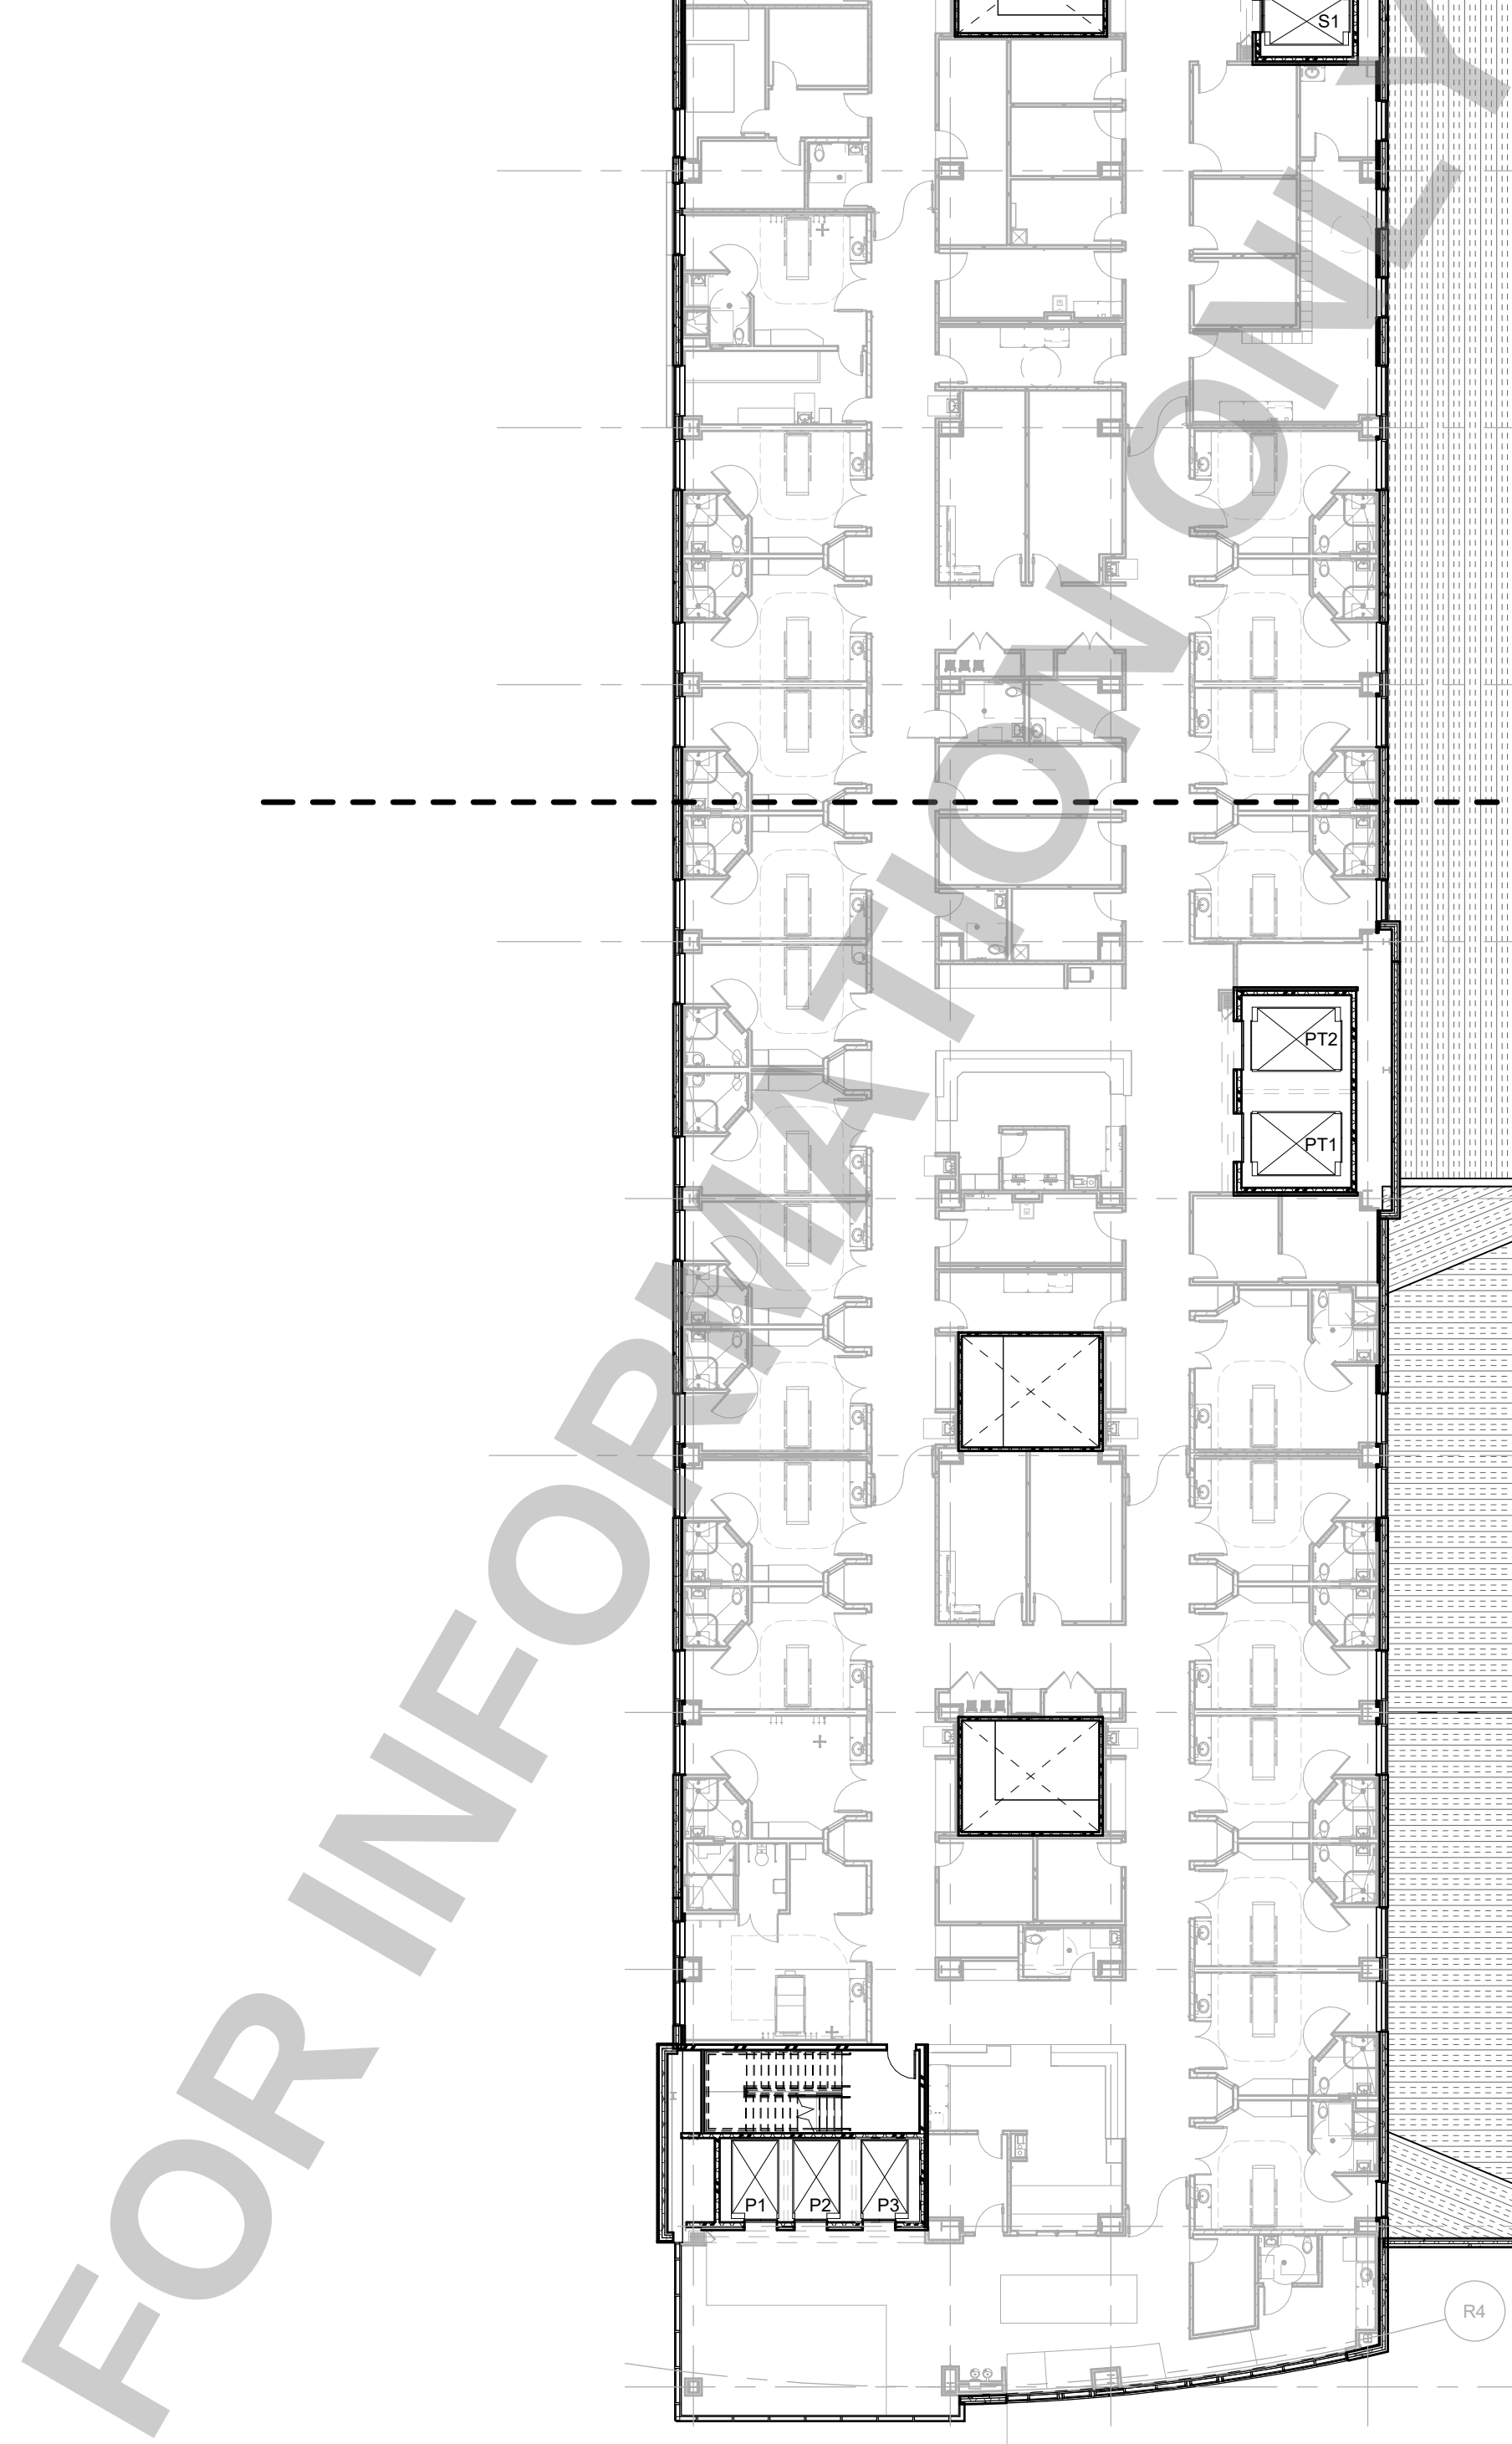

- ### GENERAL NOTES - FLOOR PLAN
1. REFER TO A1.80 & A5.10 FOR OVERALL ROOF PLAN AND DETAILS
 2. REFER TO A2 SERIES FOR BUILDING ELEVATIONS & CURTAINWALL/WINDOW WALL ELEVATIONS
 3. REFER TO A3 SERIES FOR WALL SECTIONS
 4. REFER TO A4 SERIES FOR STAIRS/ELEVATION INFORMATION
 5. REFER TO A5 SERIES FOR EXTERIOR DETAILS
 6. REFER TO A6.11-A6.18 DOOR SCHEDULE & INFORMATION

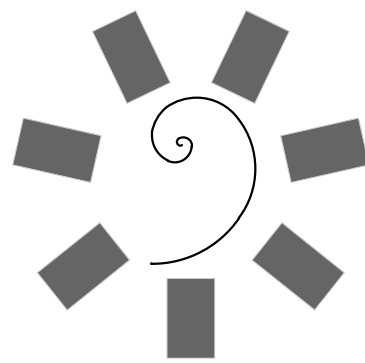

James R. Childers
Architect, Inc.
45 South 4th Street
Fort Smith, AR 72901
479-783-2480
www.childersarchitect.com

PROFESSIONAL SEAL

CONSULTANT LOGO:




CLIENT

**CHEROKEE NATION
REPLACEMENT HOSPITAL**

TAHLEQUAH, OKLAHOMA

TAHLEQUAH, OKLAHOMA

KEY PLAN:

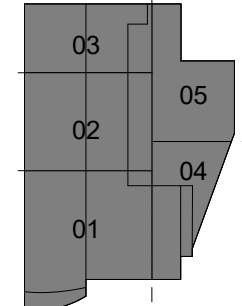

PROJECT PHASE:

BID PACKAGE 03
(ELEVATORS)

[illegible]

JOB NUMBER: 21-08 21


DATE: 10-07-2022

SHEET NUMBER:

A1.50A

SHEET TITLE:

FLOOR PLAN - LEVEL 05
- OVERALL

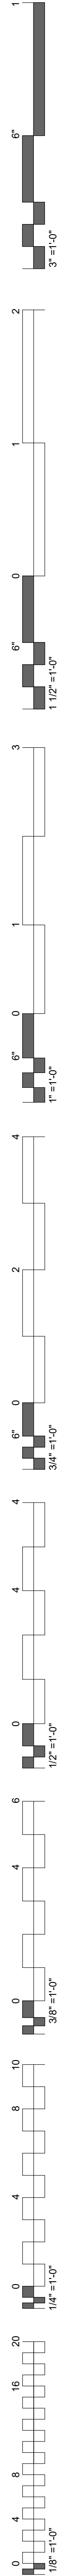


- GENERAL NOTES - FLOOR PLAN**
1. REFER TO A1.00 & A5.10 FOR OVERALL ROOF PLAN AND DETAILS
 2. REFER TO A2 SERIES FOR BUILDING ELEVATIONS & CURTAINWALL WINDOW WALL ELEVATIONS
 3. REFER TO A4 SERIES FOR WALL SECTIONS
 4. REFER TO A4 SERIES FOR STAIRS/ELEVATION INFORMATION
 5. REFER TO A6 SERIES FOR EXTERIOR DETAILS
 6. REFER TO A6.11-A6.18 DOOR SCHEDULE & INFORMATION

James R. Childers
Architect, Inc.

45 South 4th Street
Fort Smith, AR 72901
479-783-2450
www.childersarchitect.com


PROFESSIONAL SEAL:

CONSULTANT LOGO

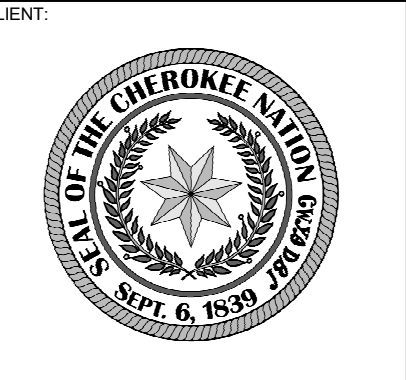

**CHEROKEE NATION
REPLACEMENT HOSPITAL**


TAHLEQUAH, OKLAHOMA

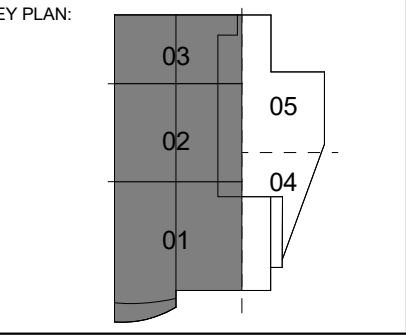

PROJECT PHASE:
BID PACKAGE 03
(ELEVATORS)


#	DATE	REVISIONS DESCRIPTION


JOB NUMBER: 21-08.21
DATE: 10-07-2022
SHEET NUMBER:
A1.60A
SHEET TITLE:
FLOOR PLAN - LEVEL 06 - OVERALL

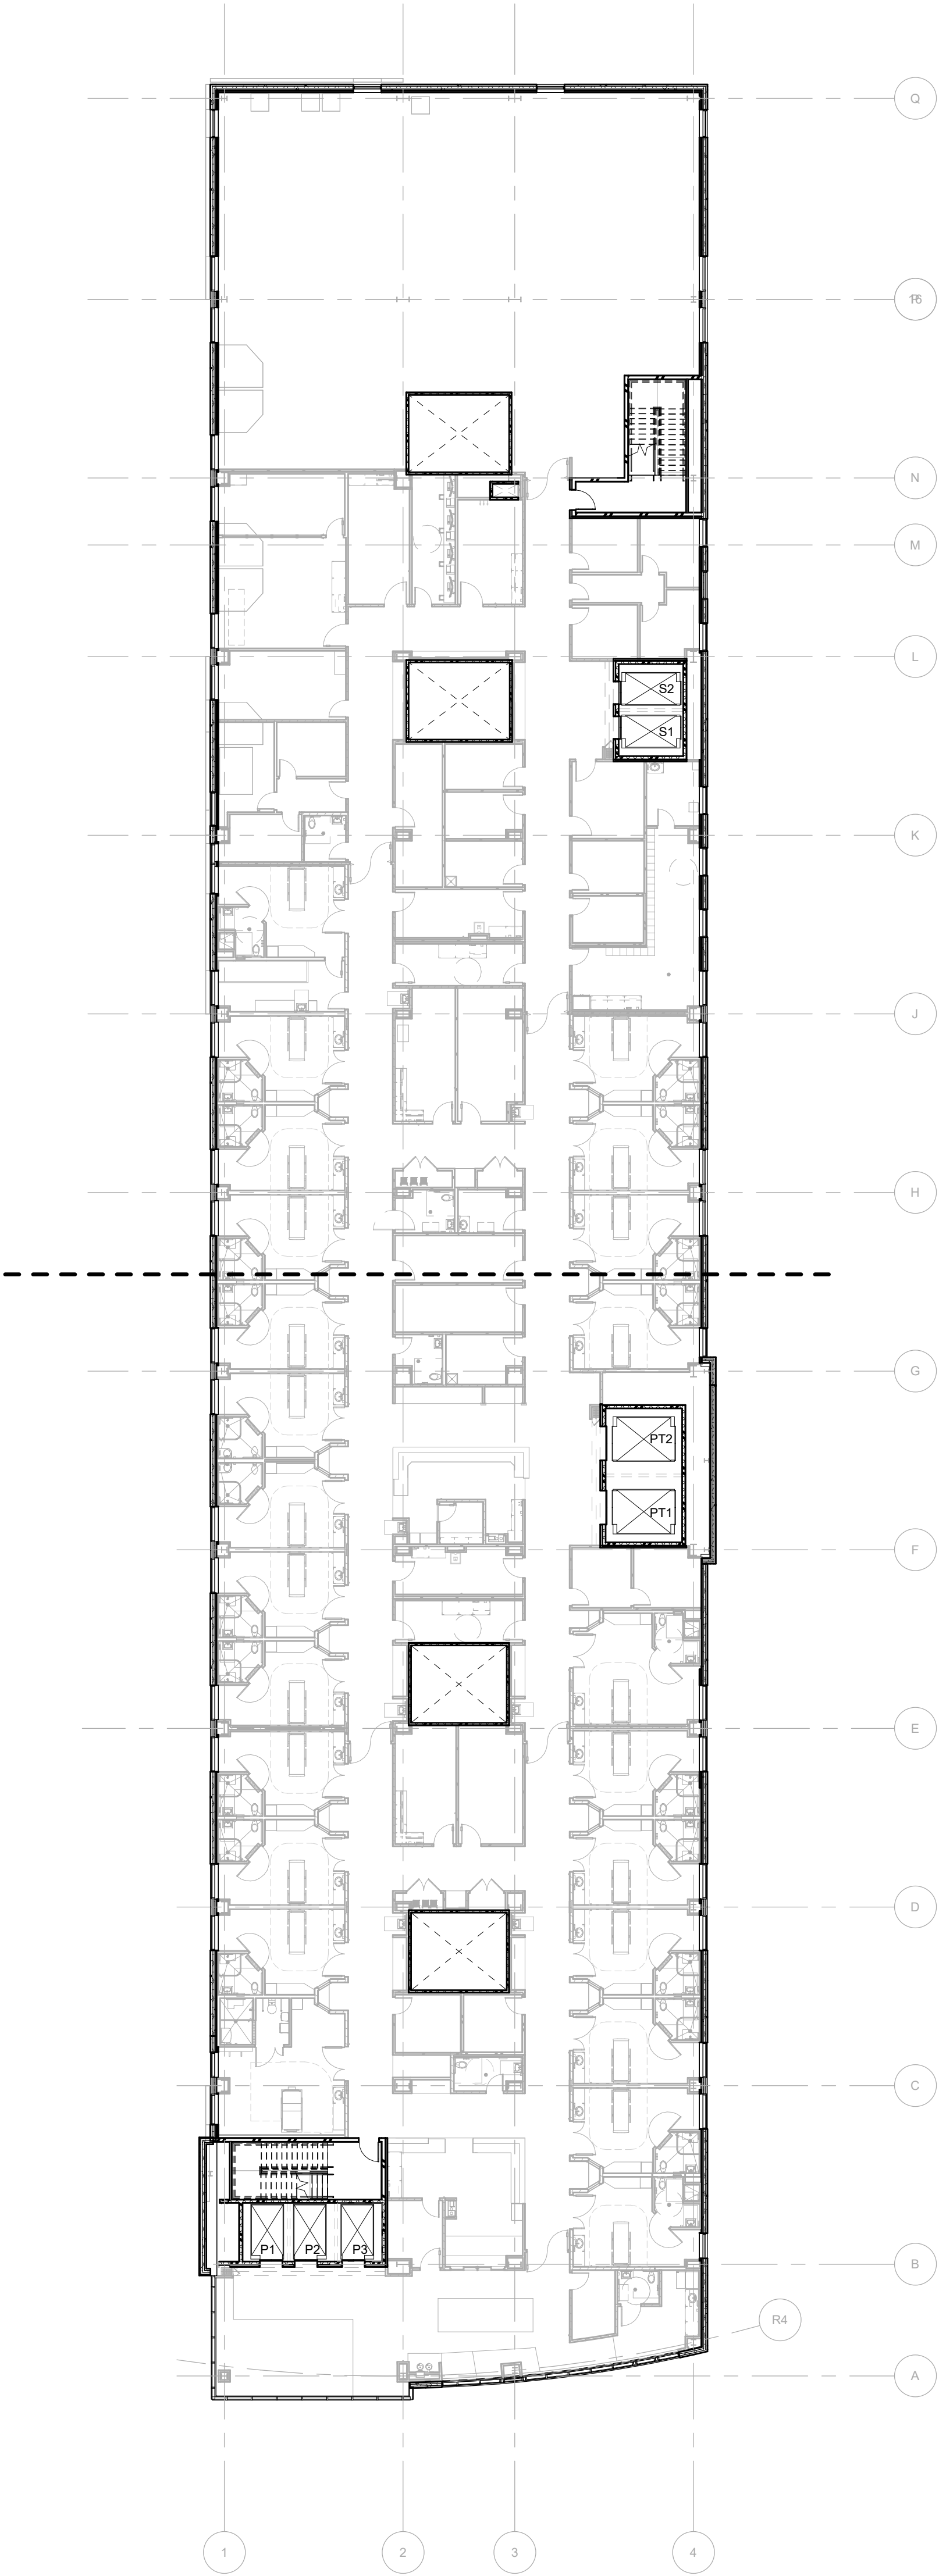

FOR INFORMATION ONLY

01 FLOOR PLAN - LEVEL 06 - OVERALL
1" = 20'-0"

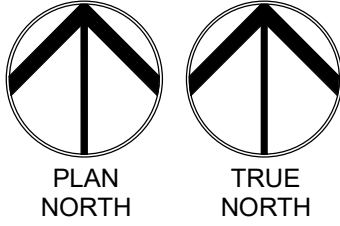

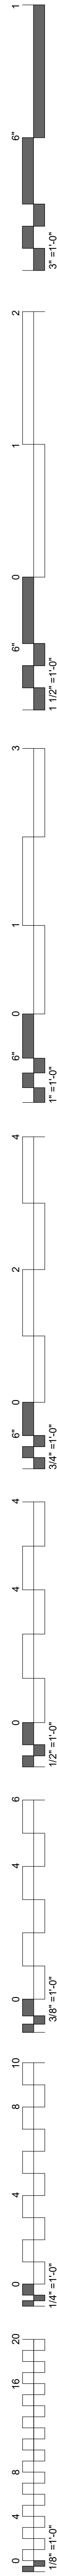


- GENERAL NOTES - FLOOR PLAN**
1. REFER TO A1.80 & A5.10 FOR OVERALL ROOF PLAN AND DETAILS
 2. REFER TO A2 SERIES FOR BUILDING ELEVATIONS & CURTAINWALL/WINDOW WALL ELEVATIONS
 3. REFER TO A3 SERIES FOR WALL SECTIONS
 4. REFER TO A4 SERIES FOR STAIRS/ELEVATION INFORMATION
 5. REFER TO A5 SERIES FOR EXTERIOR DETAILS
 6. REFER TO A6.11-A6.18 DOOR SCHEDULE & INFORMATION

James R. Childers
Architect, Inc.

45 South 4th Street
Fort Smith, AR 72901
479-783-2460
www.childersarchitect.com


PROFESSIONAL SEAL:

CONSULTANT LOGO

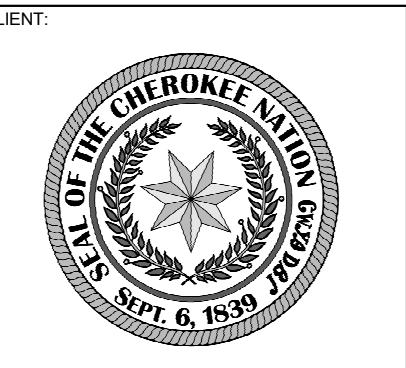

**CHEROKEE NATION
REPLACEMENT HOSPITAL**


TAHLEQUAH, OKLAHOMA

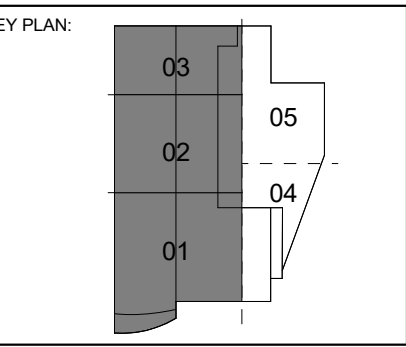


PROJECT PHASE:
BID PACKAGE 03
(ELEVATORS)



#	DATE	REVISIONS DESCRIPTION

JOB NUMBER: 21-08.21
DATE: 10-07-2022
SHEET NUMBER:
A1.70
SHEET TITLE:
FLOOR PLAN - HIGH ROOF

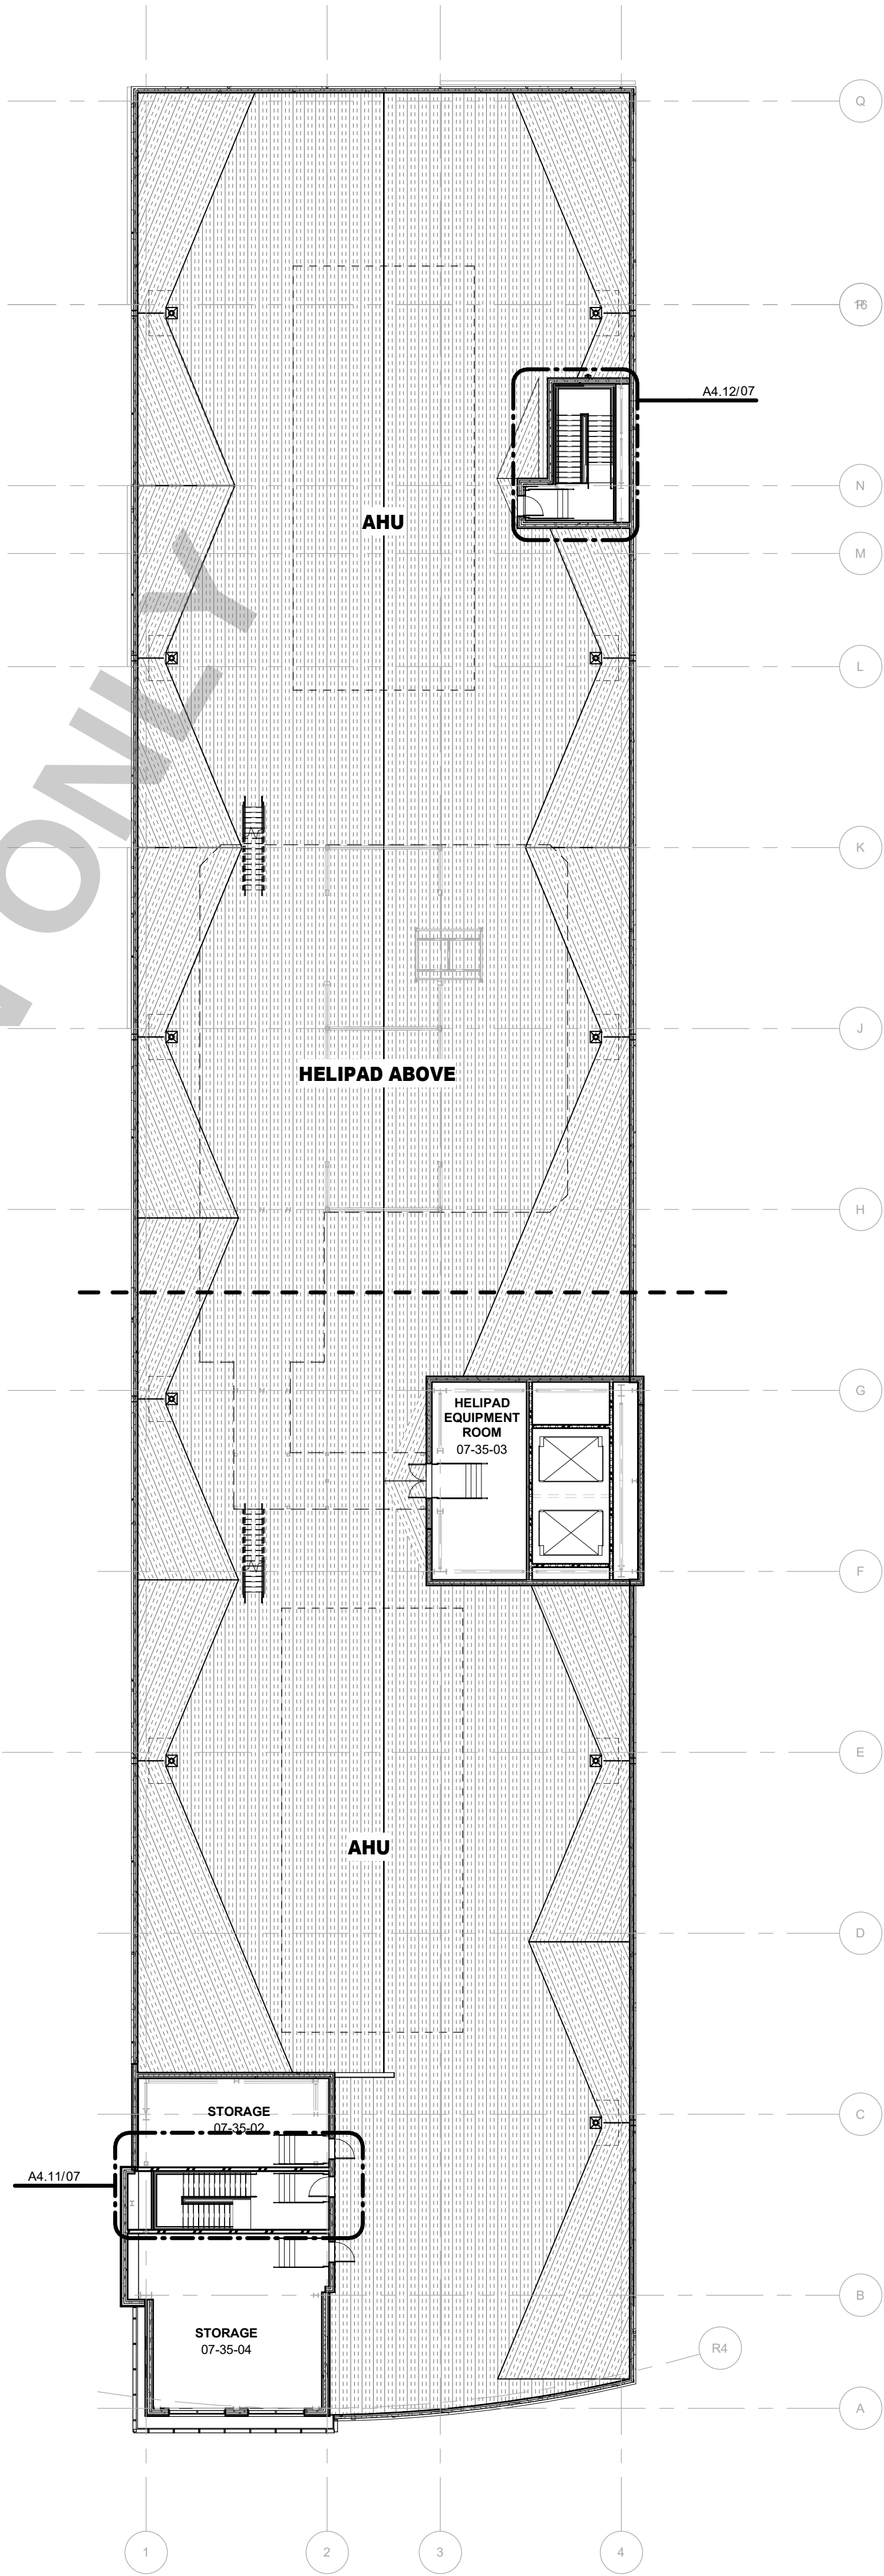



01 ROOF PLAN - HIGH ROOF
1" = 20'-0"

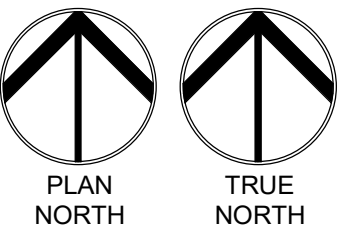

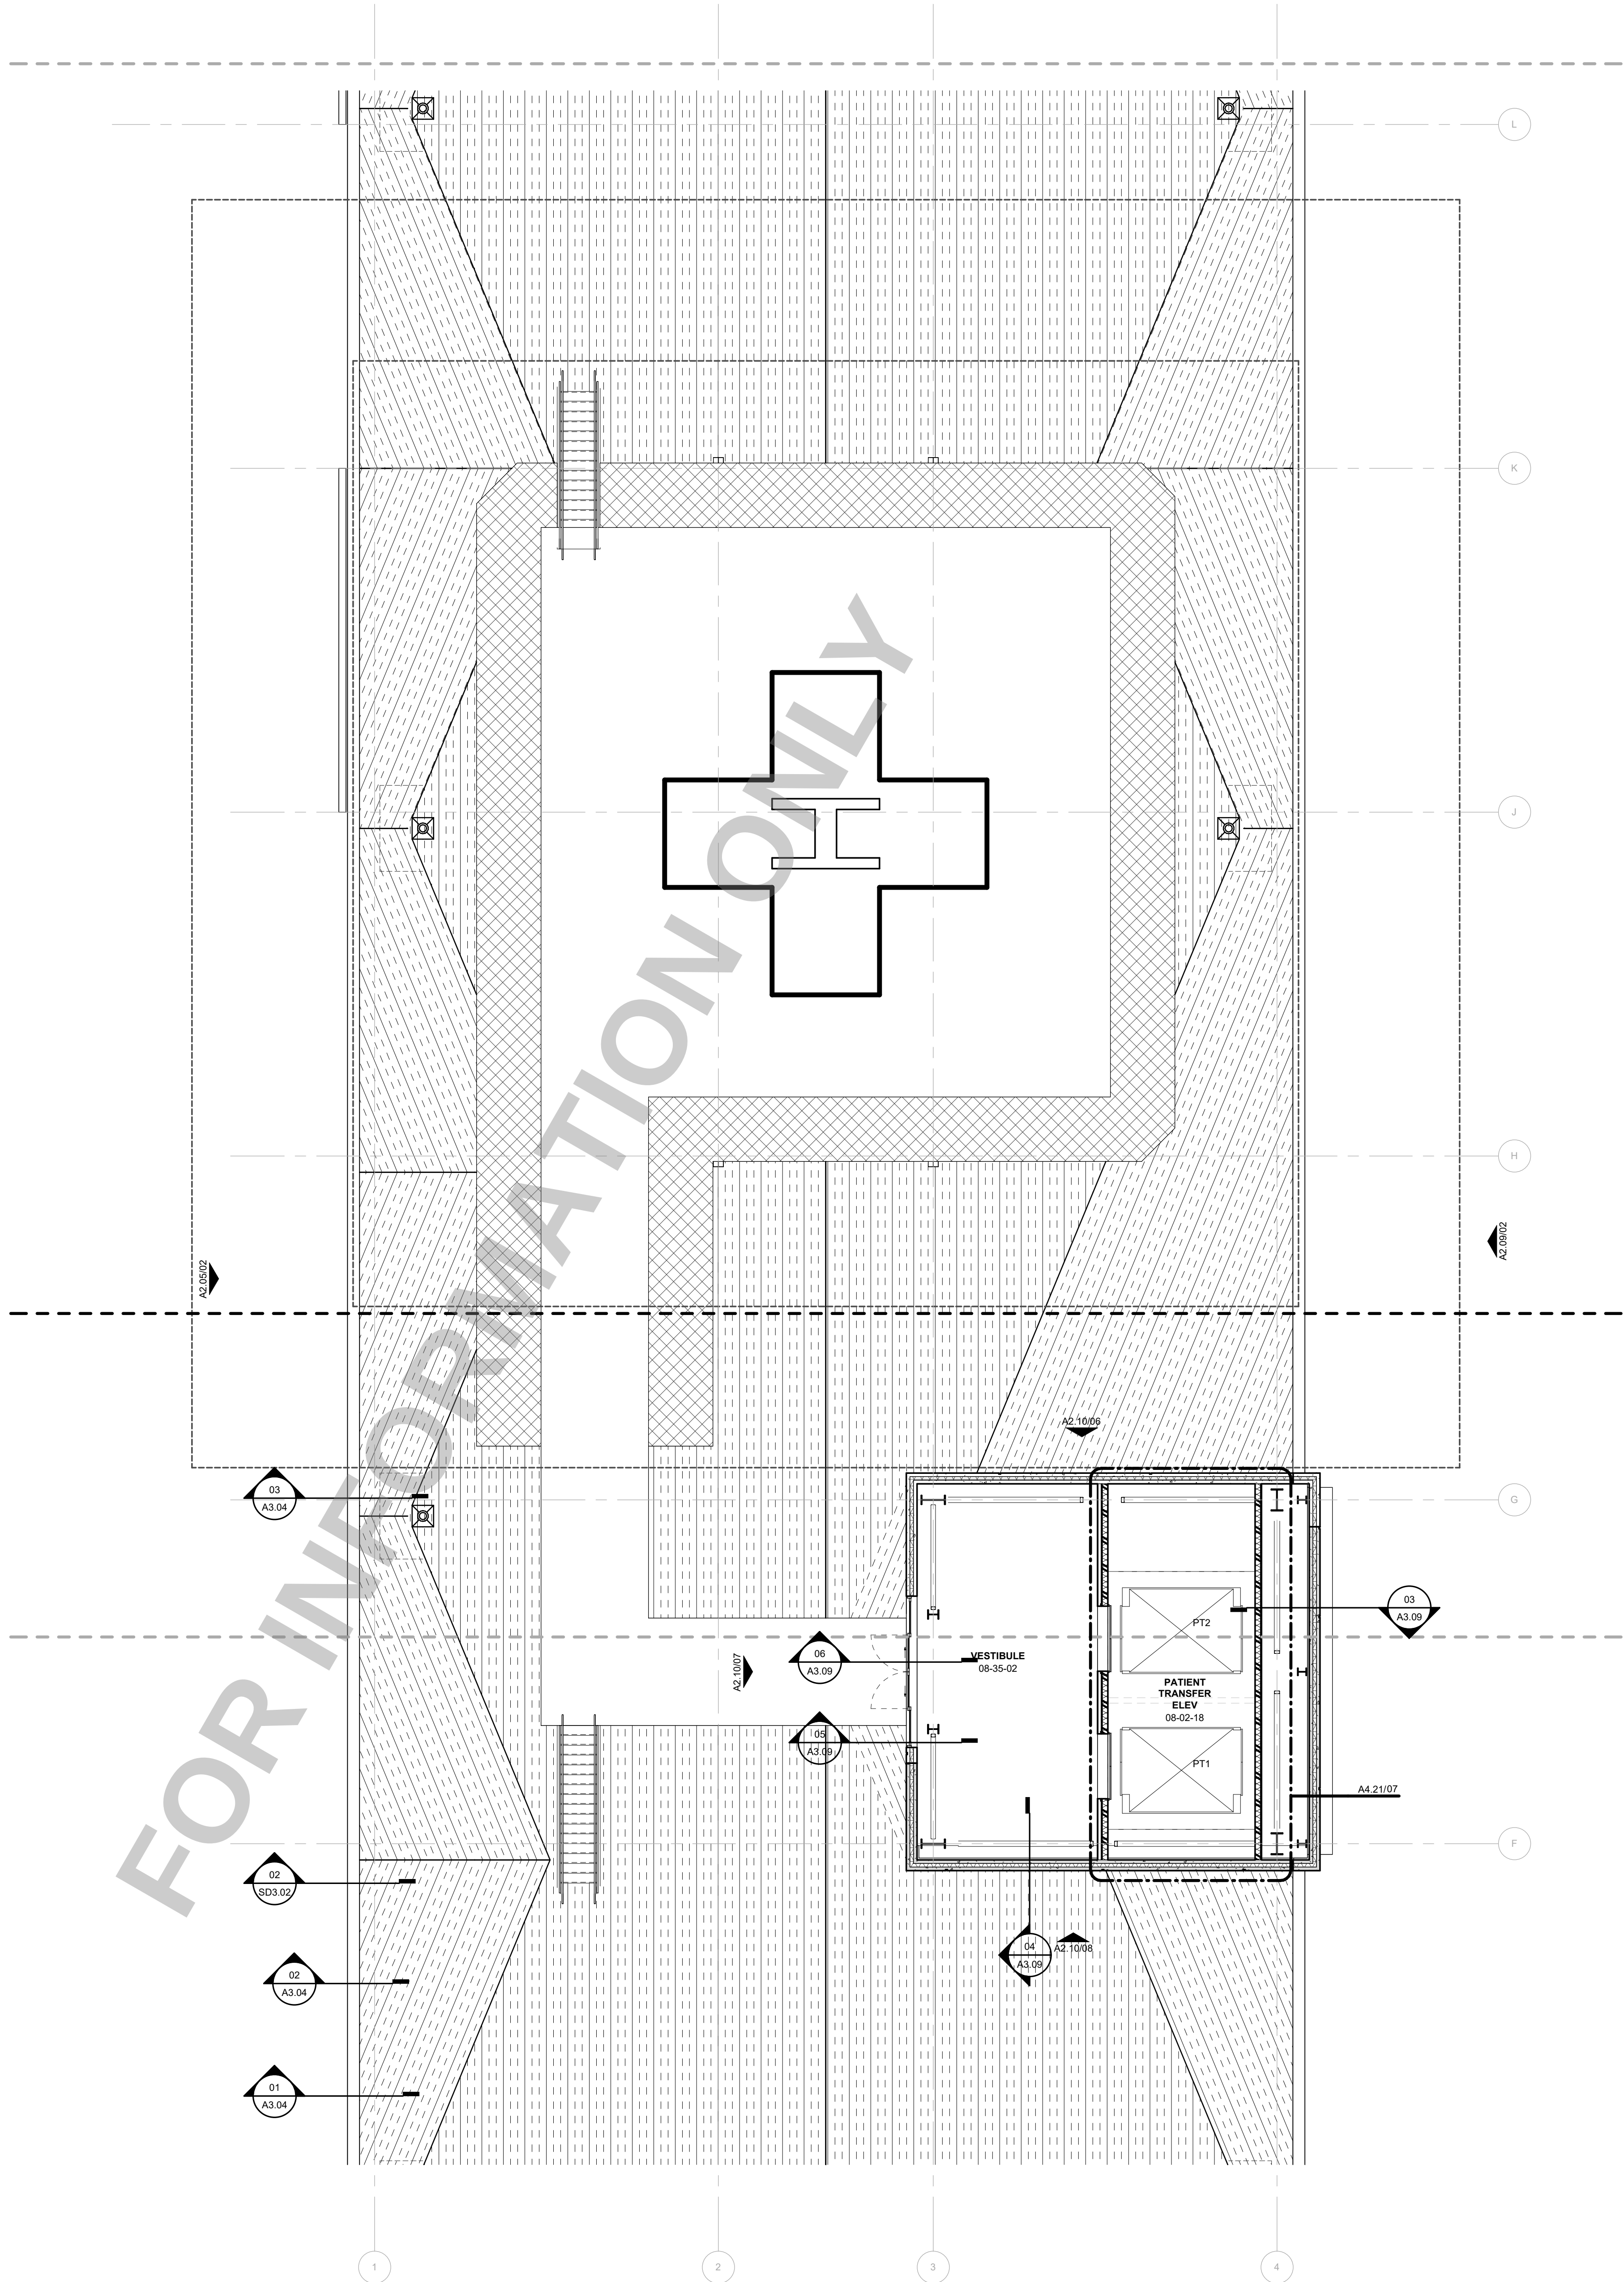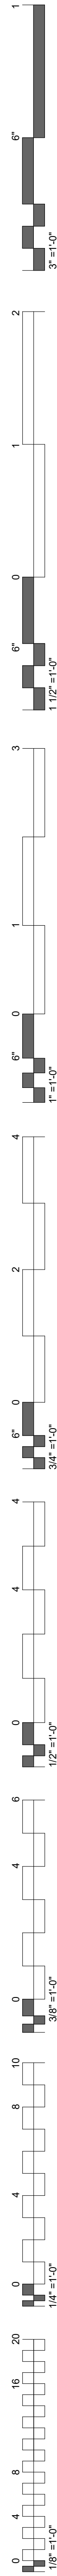

01 ROOF PLAN - HELIPAD


1/8" = 1'-0"

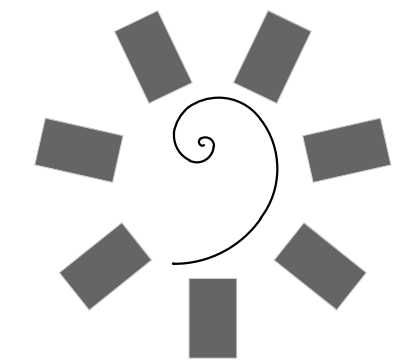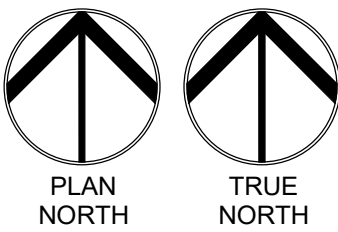


James R. Childers
Architect, Inc.
45 South 4th Street
Fort Smith, AR 72901
479-783-2480
www.childersarchitect.com

PROFESSIONAL SEAL:

CONSULTANT LOGO:

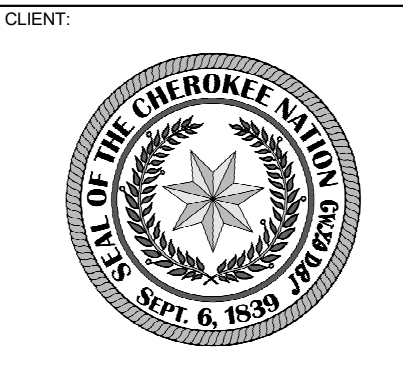

CHEROKEE NATION
REPLACEMENT HOSPITAL
TAHLEQUAH, OKLAHOMA

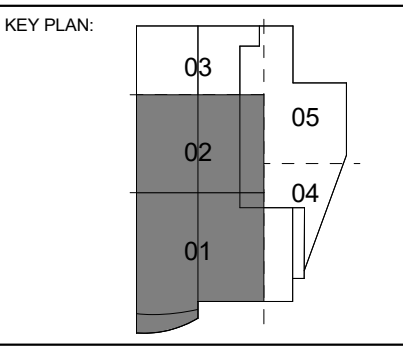

PROJECT PHASE:
BID PACKAGE 03
(ELEVATORS)

#	DATE	REVISIONS DESCRIPTION

JOB NUMBER: 21-08.21



DATE: 10-07-2022

SHEET NUMBER:


A1.71

SHEET TITLE:


FLOOR PLAN - HELIPAD

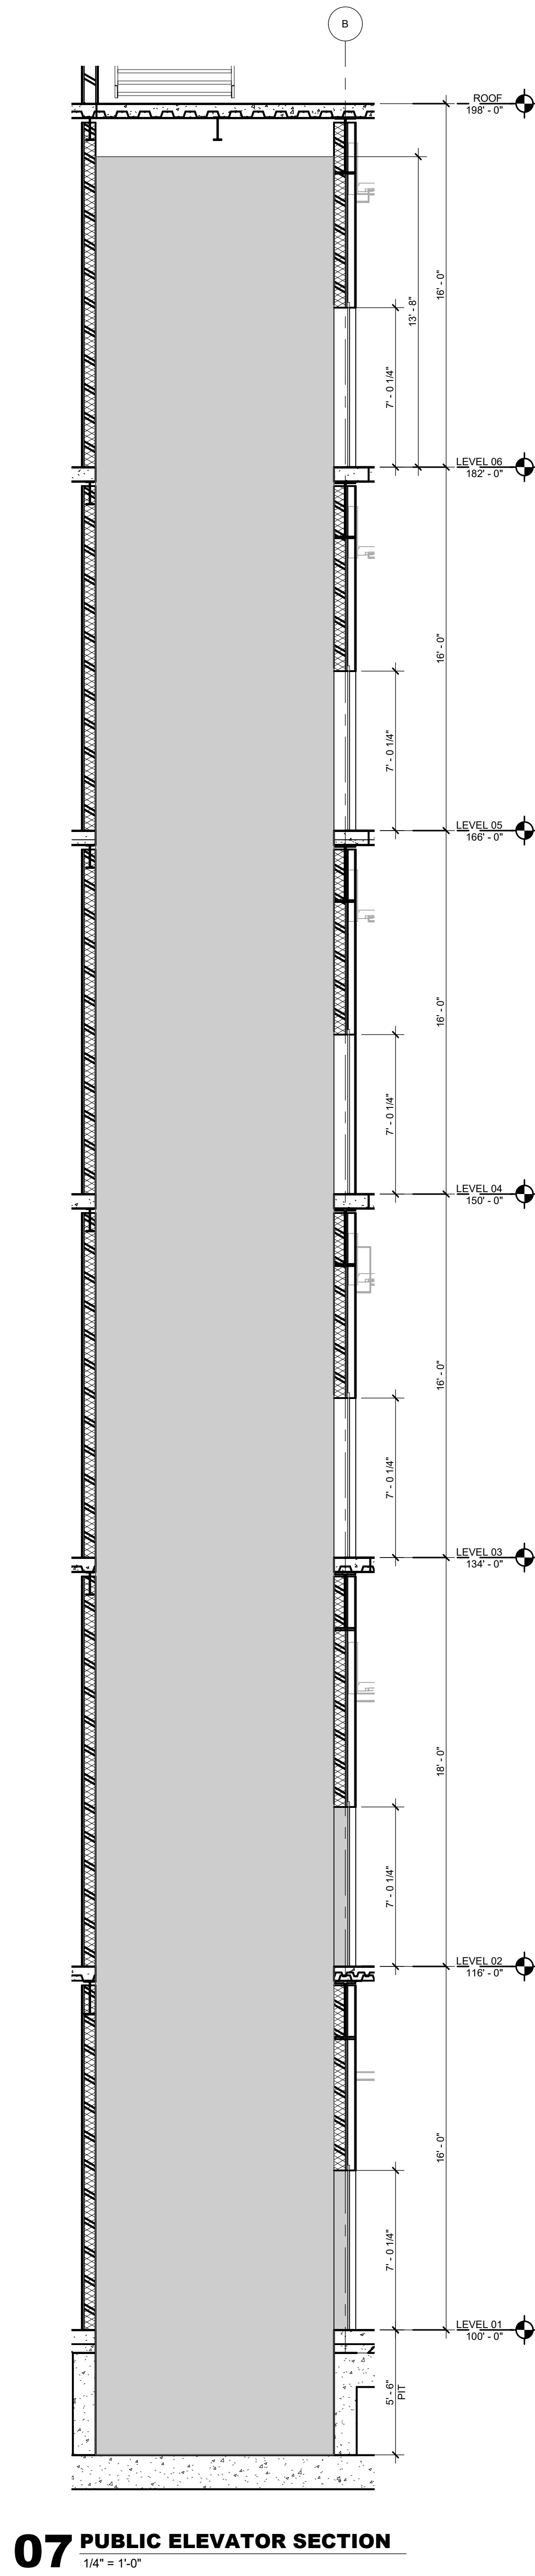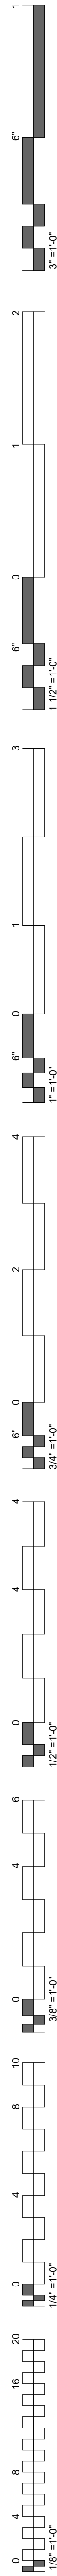


07 PUBLIC ELEVATOR SECTION
1/4" = 1'-0"

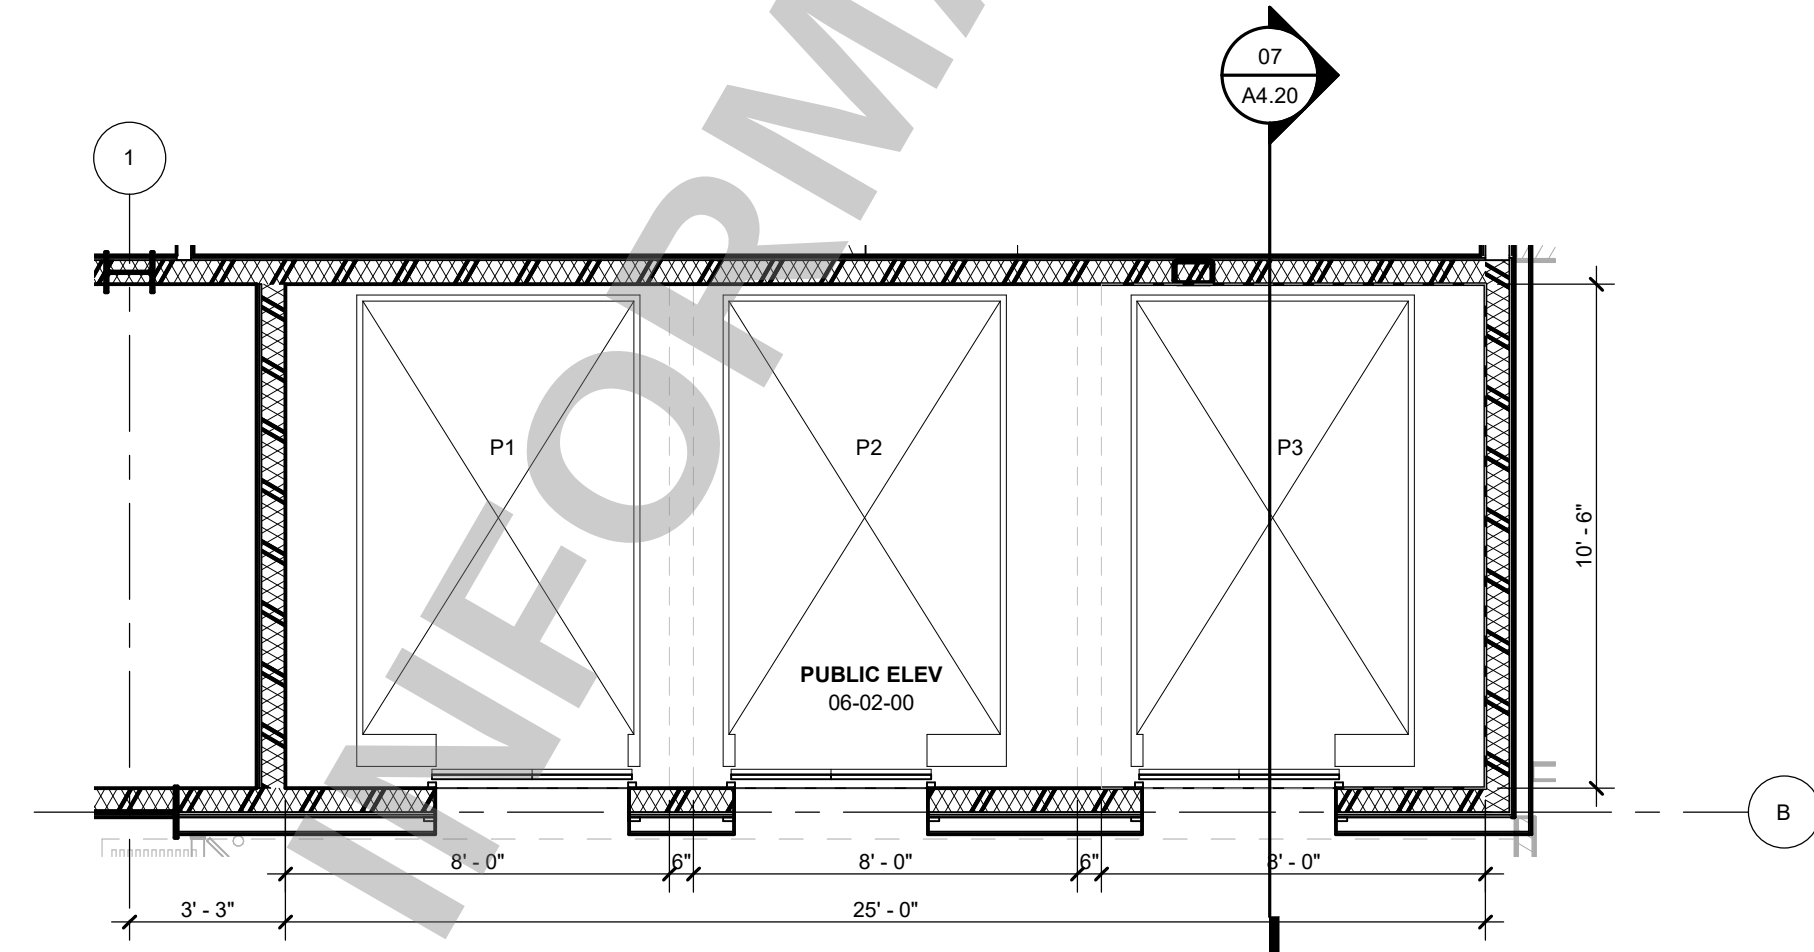


06 PUBLIC ELEVATOR LEVEL 06 SECTOR 01
1/4" = 1'-0"

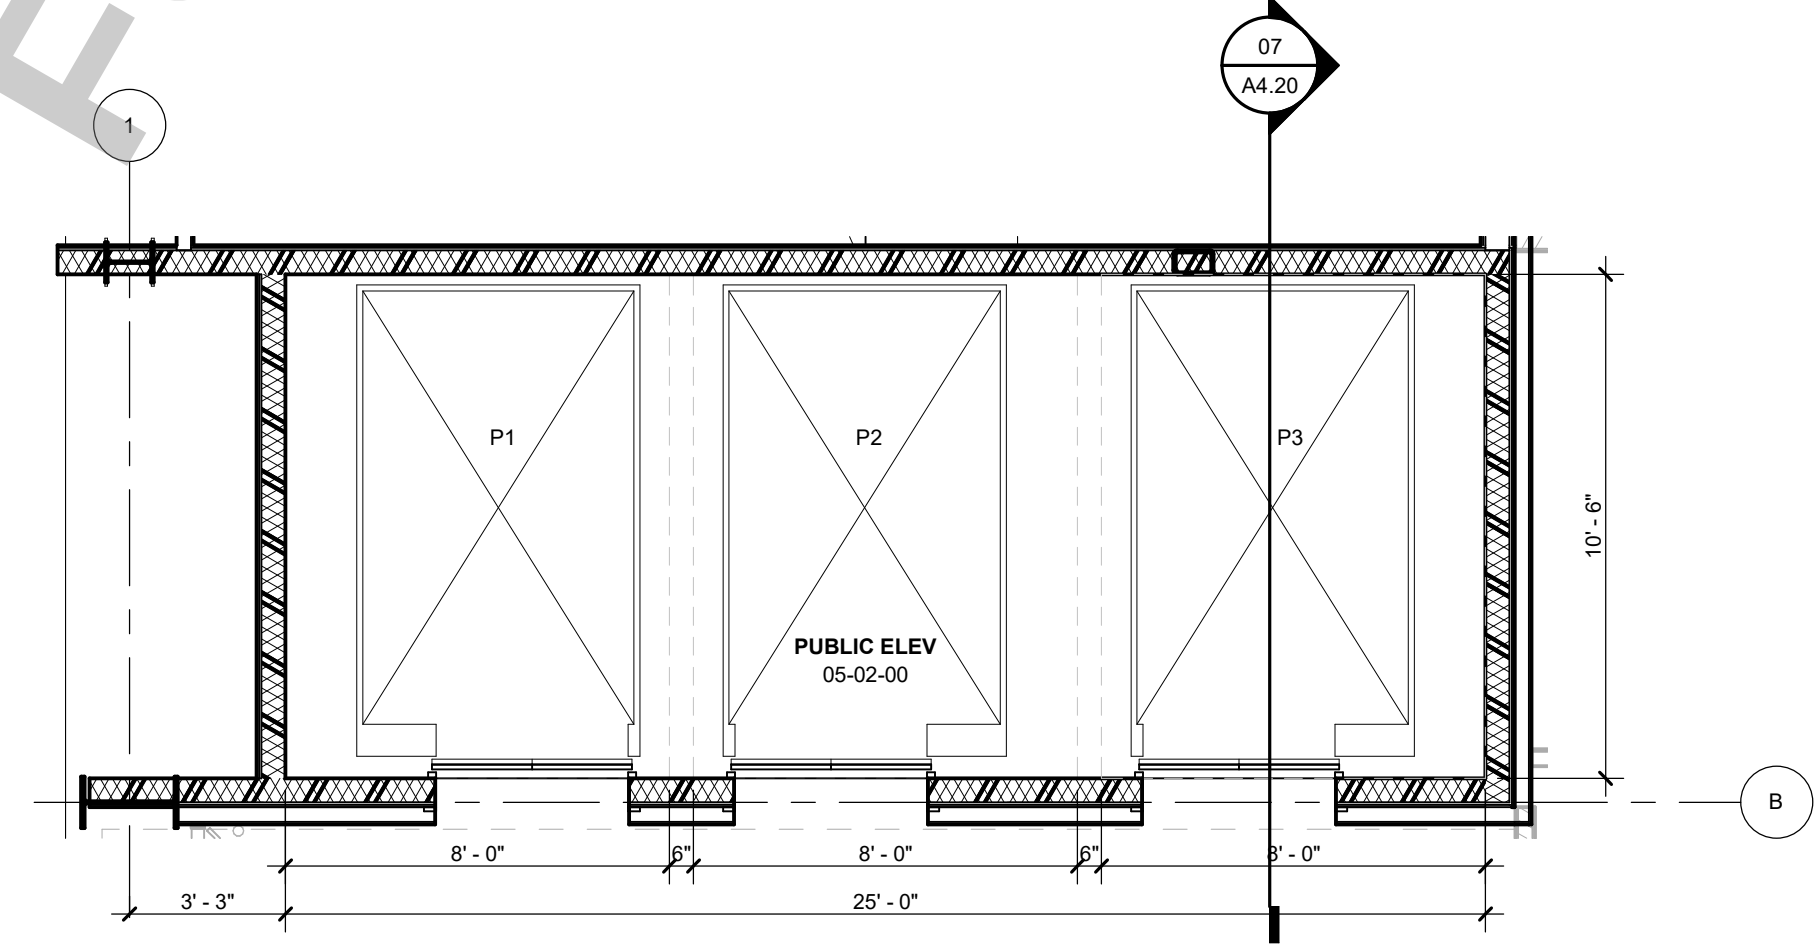


05 PUBLIC ELEVATOR LEVEL 05 SECTOR 01
1/4" = 1'-0"

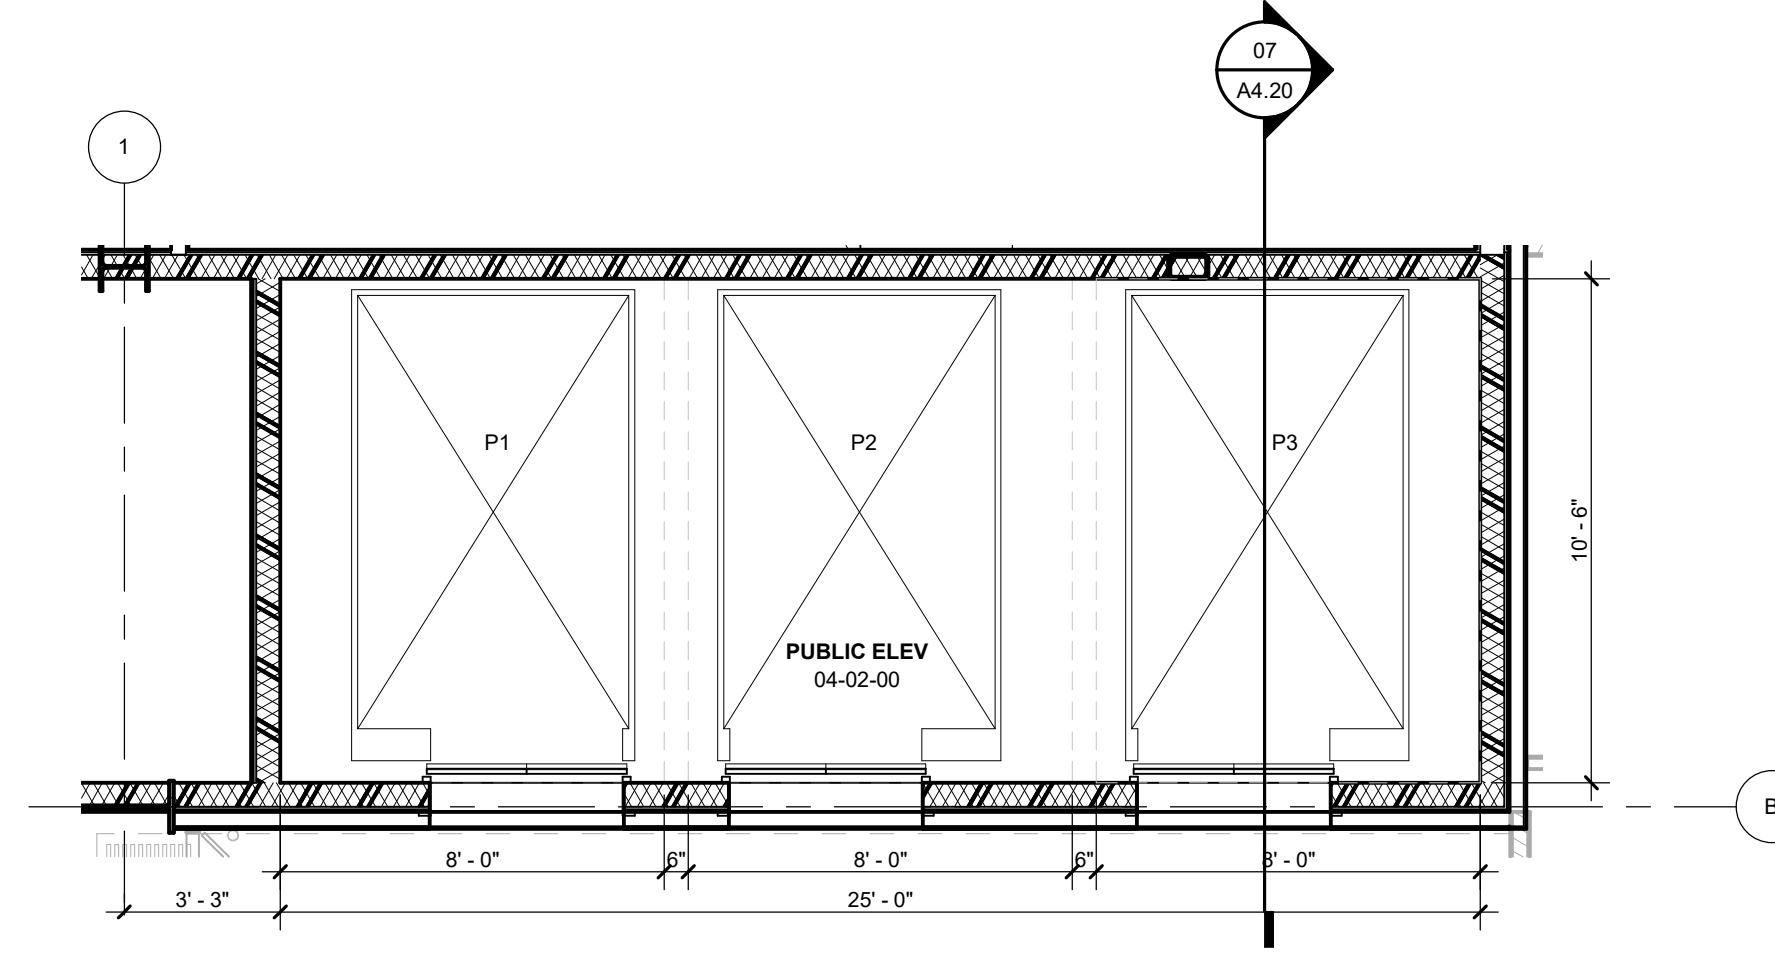


04 PUBLIC ELEVATOR LEVEL 04 SECTOR 01
1/4" = 1'-0"

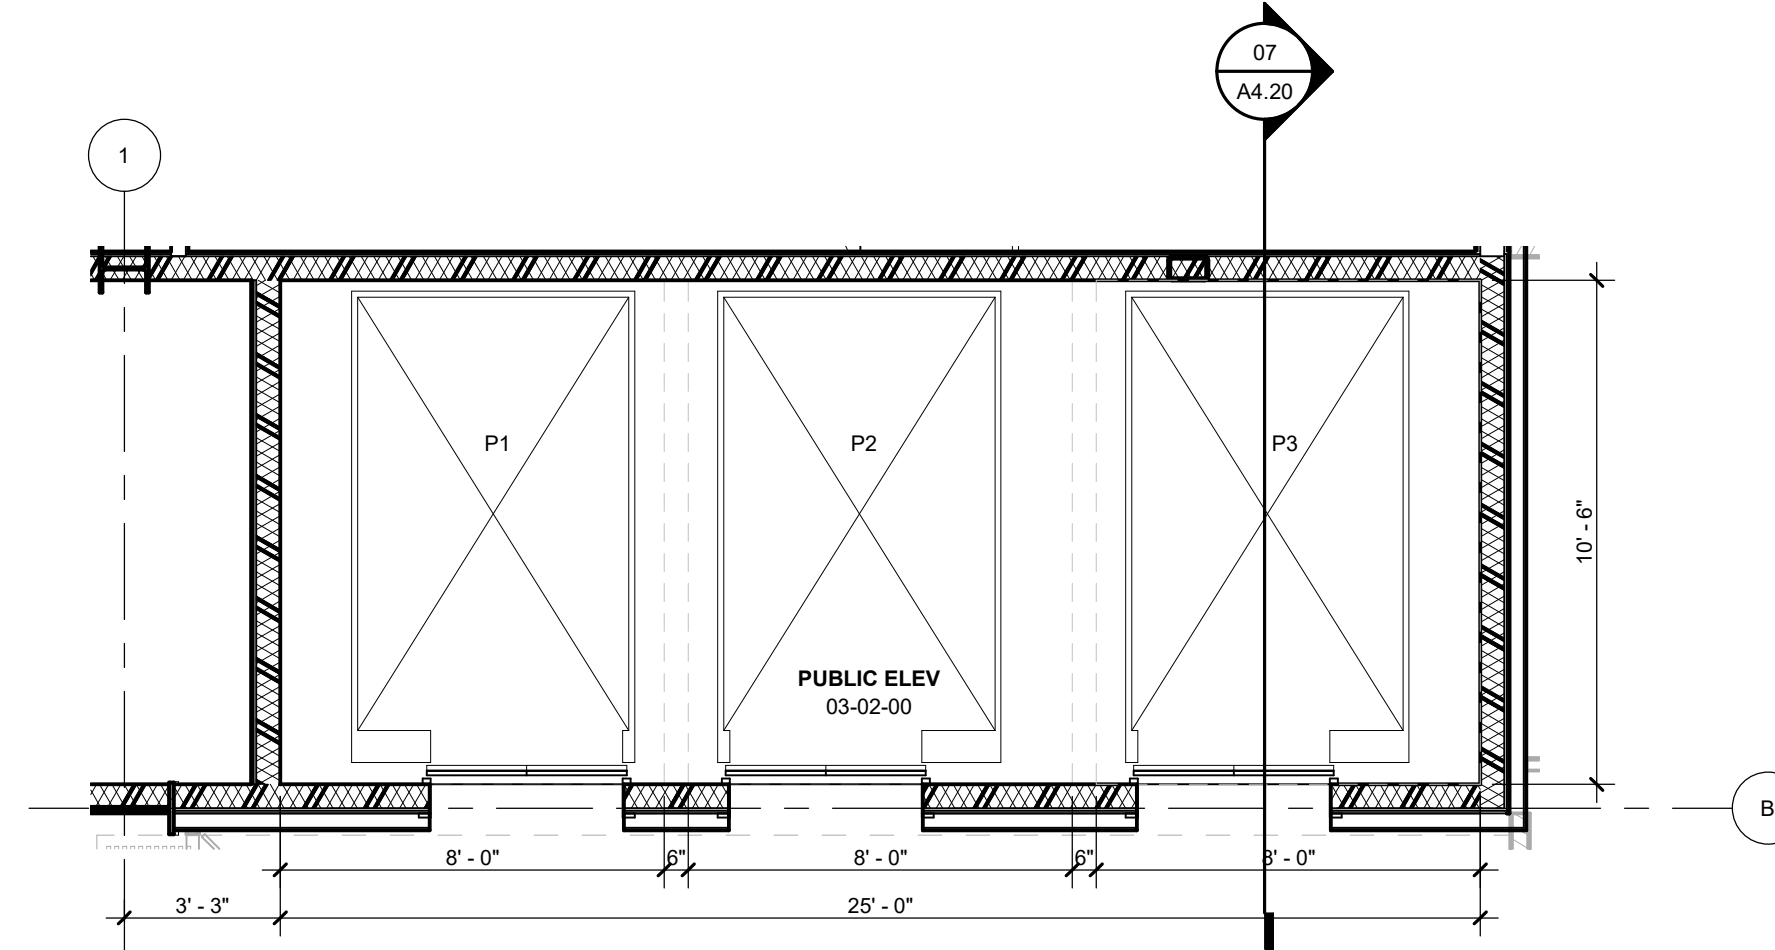

03 PUBLIC ELEVATOR LEVEL 03 SECTOR 01
1/4" = 1'-0"

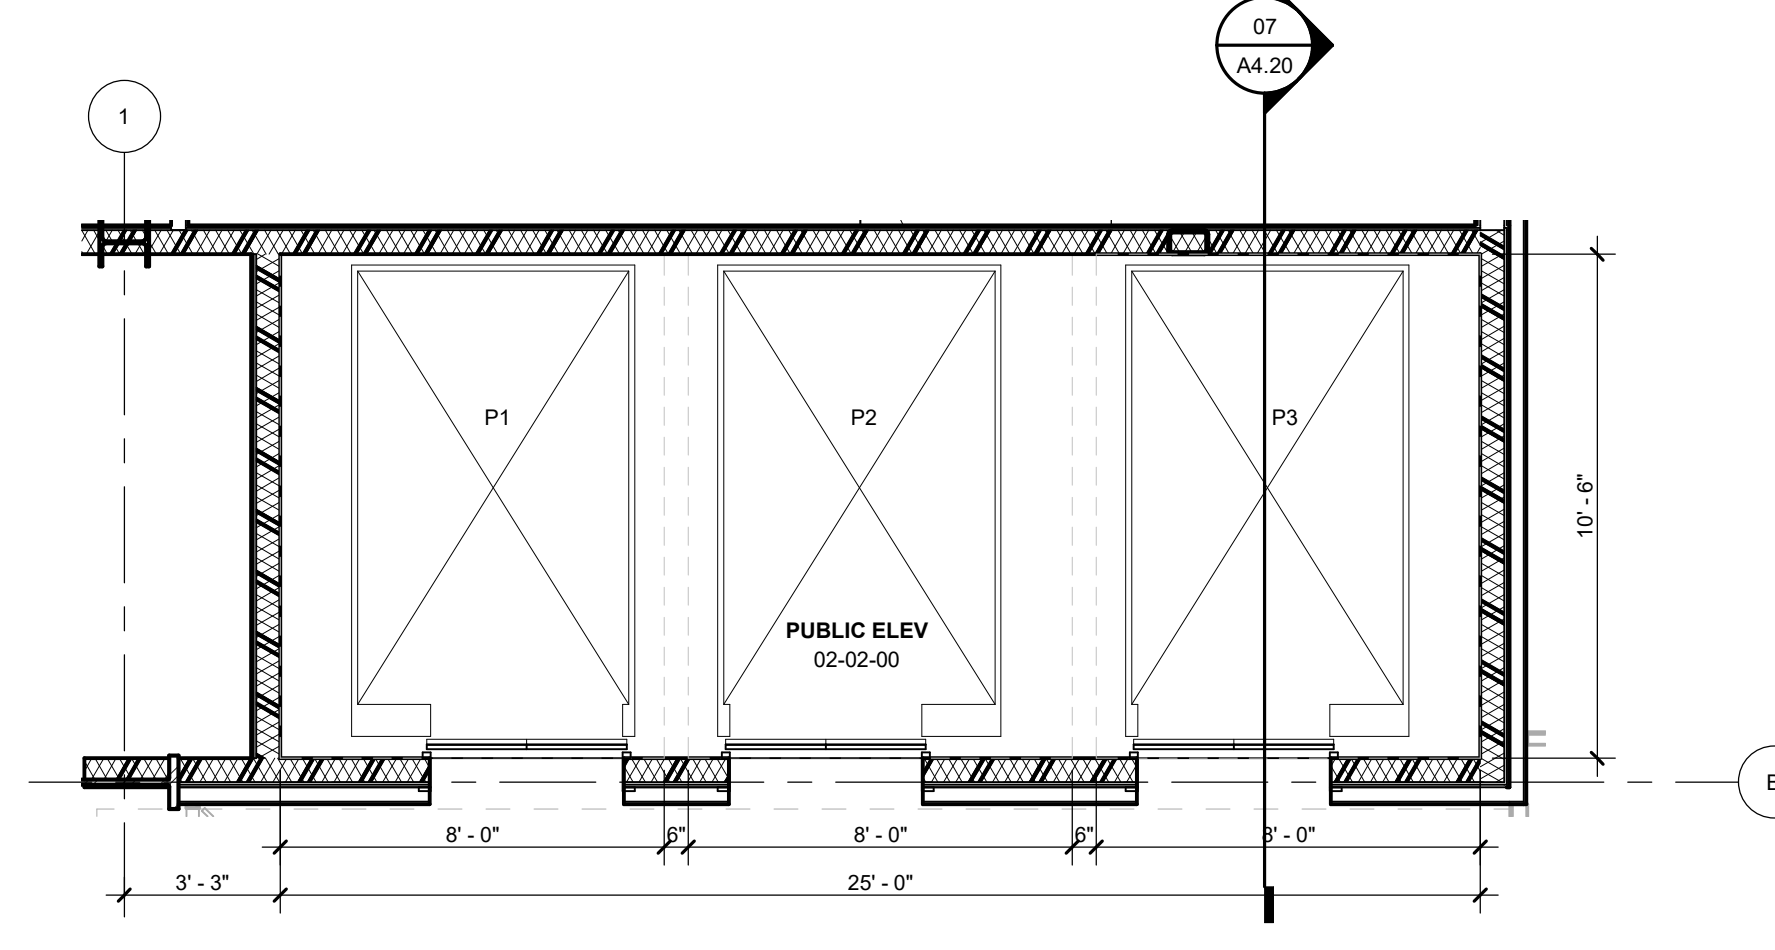


02 PUBLIC ELEVATOR LEVEL 02 SECTOR 01
1/4" = 1'-0"

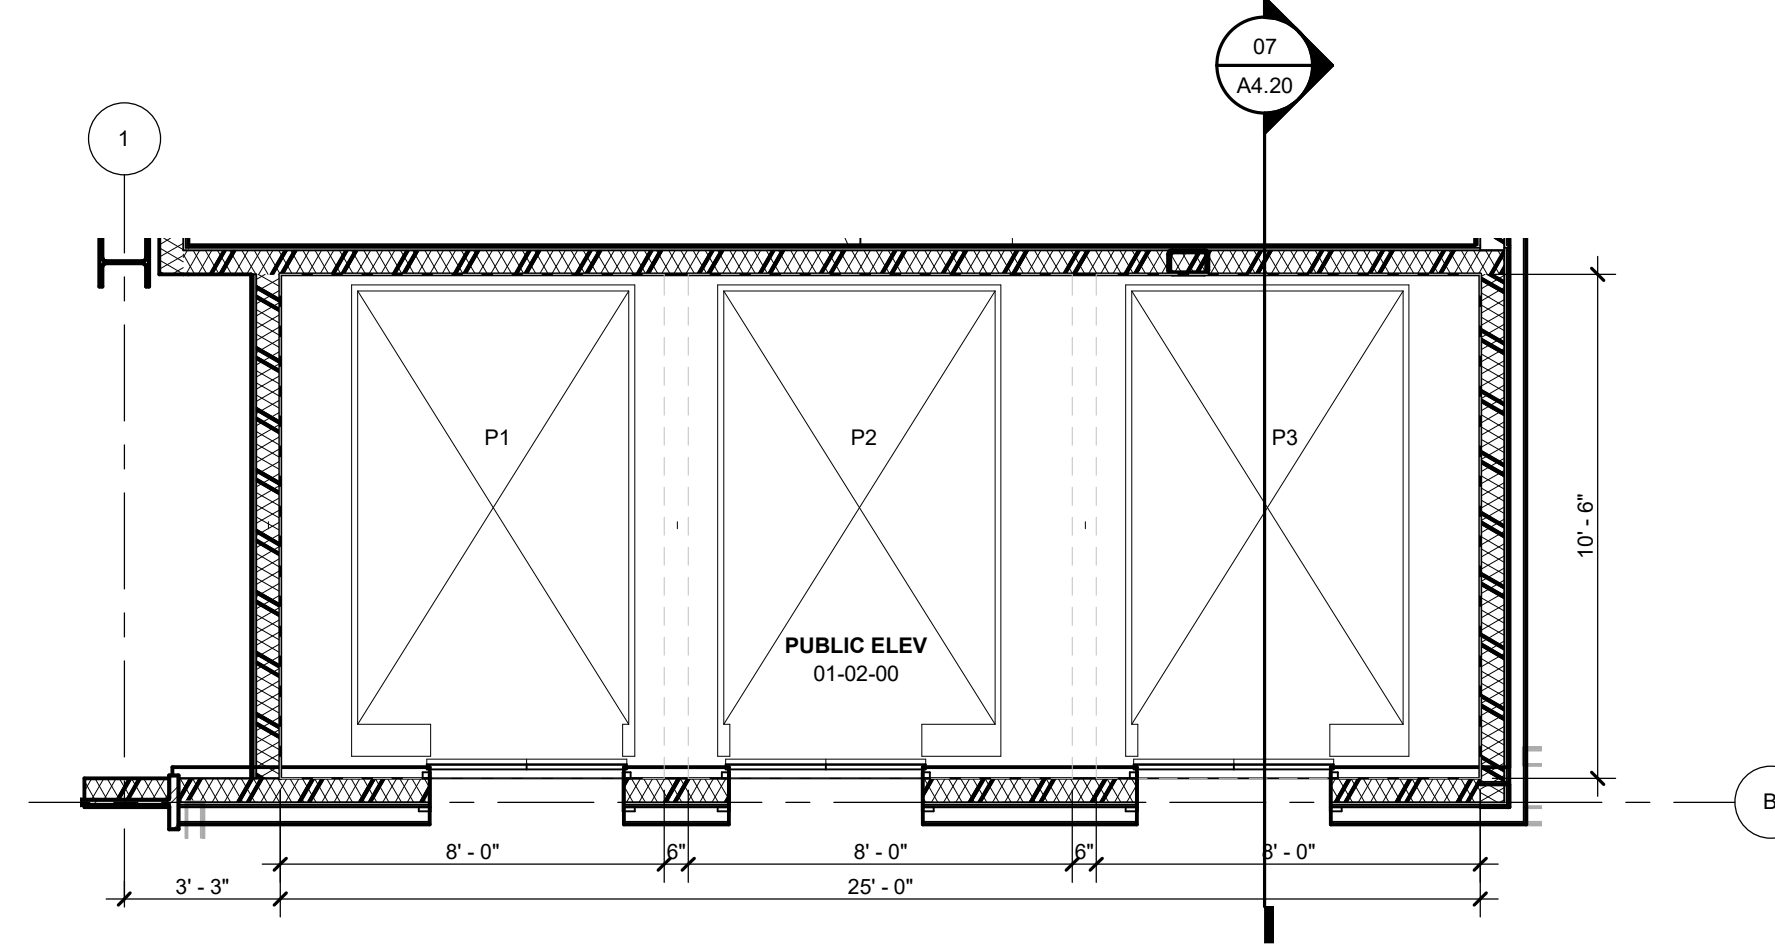


01 PUBLIC ELEVATOR LEVEL 01 SECTOR 01
1/4" = 1'-0"


#	DATE	REVISIONS DESCRIPTION

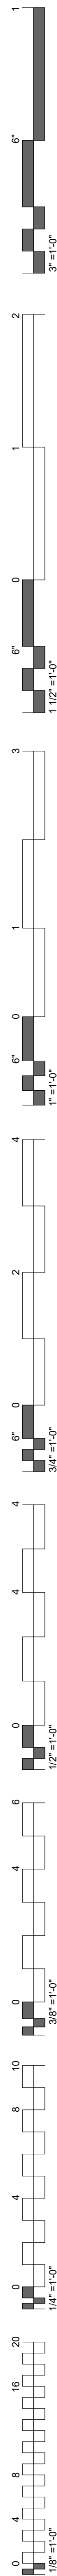


09 PATIENT TRANSFER ELEVATOR SECTION 02
1/4" = 1'-0"

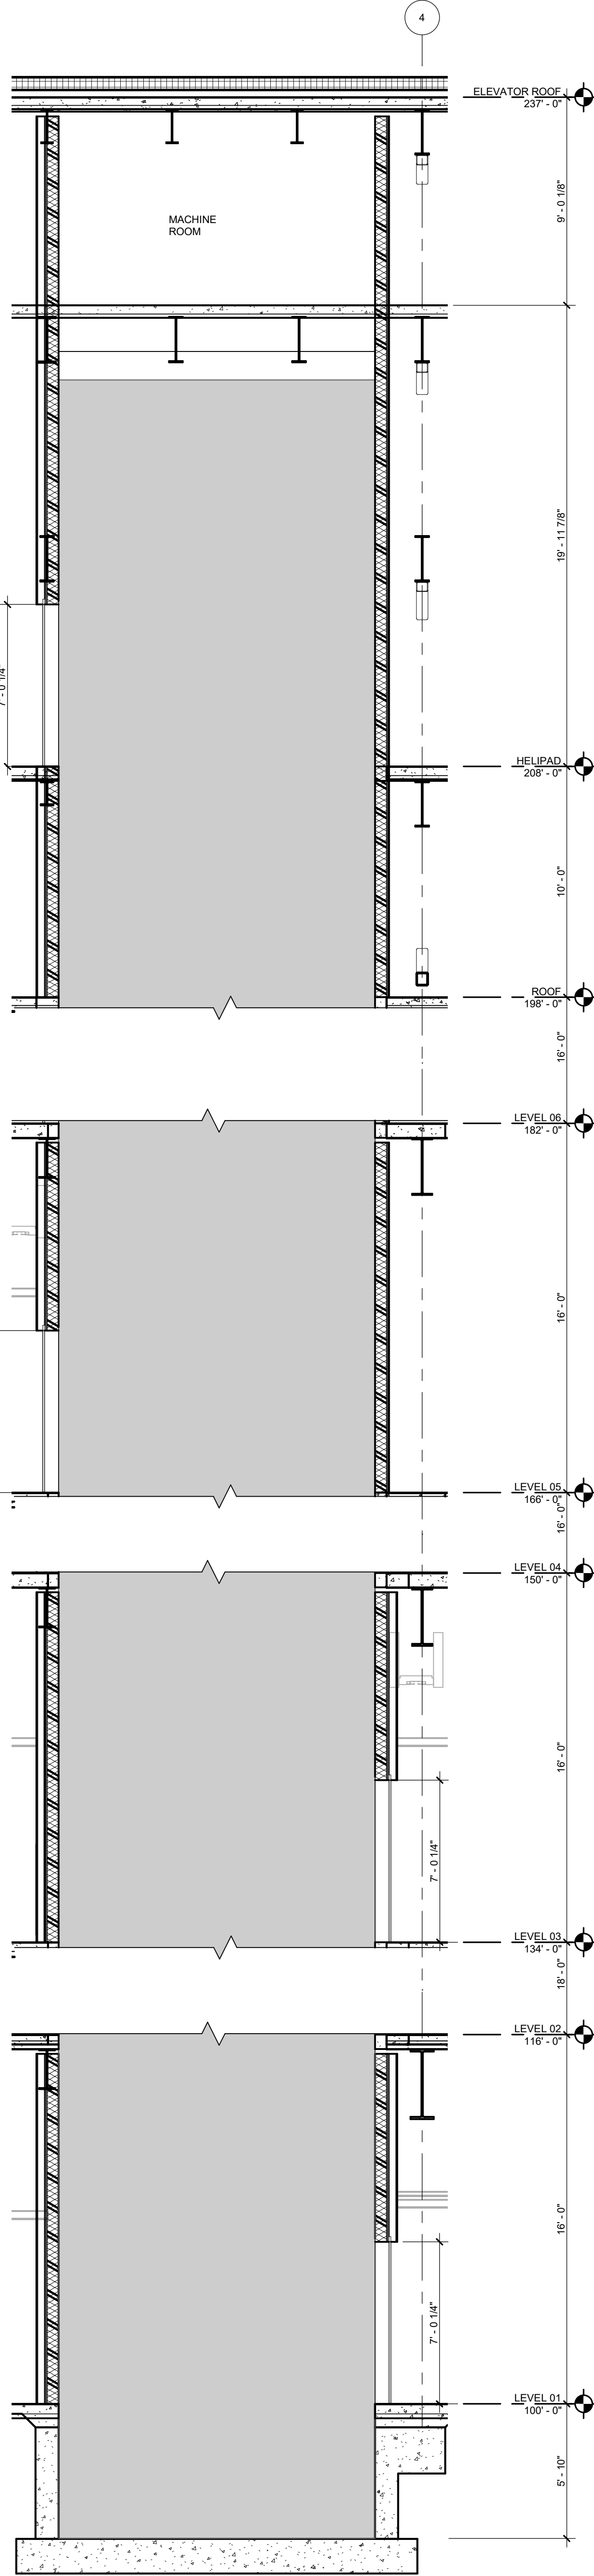


08 PATIENT TRANSFER ELEVATOR SECTION 01
1/4" = 1'-0"

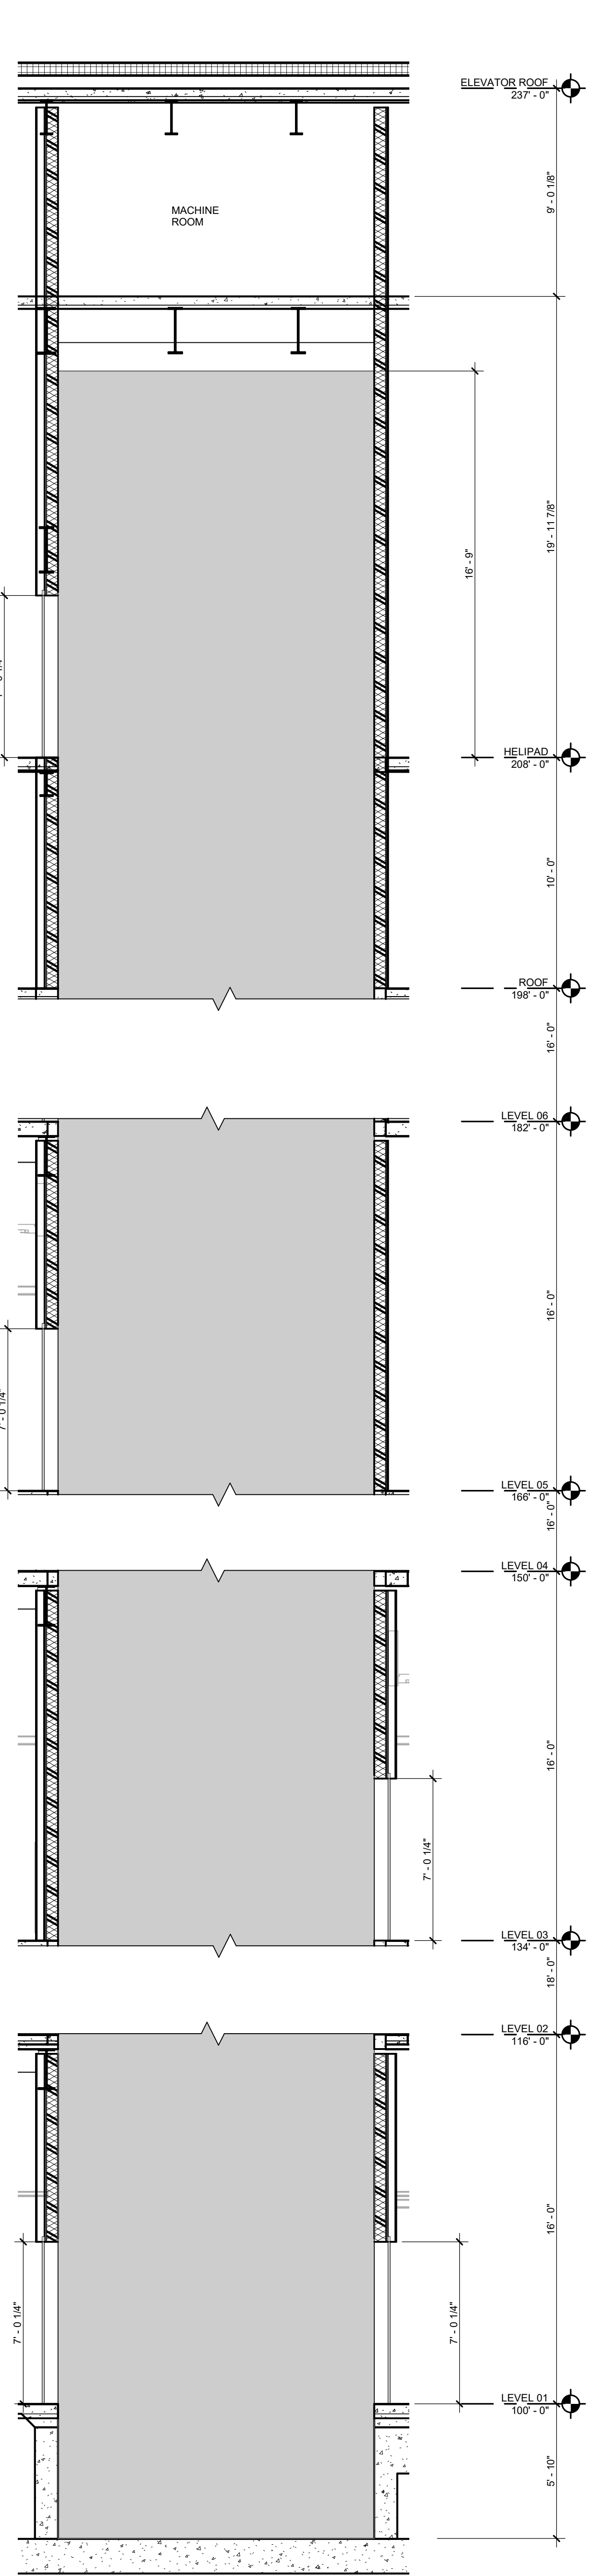


07 PATIENT TRANSFER ELEVATOR HELIPAD
1/4" = 1'-0"

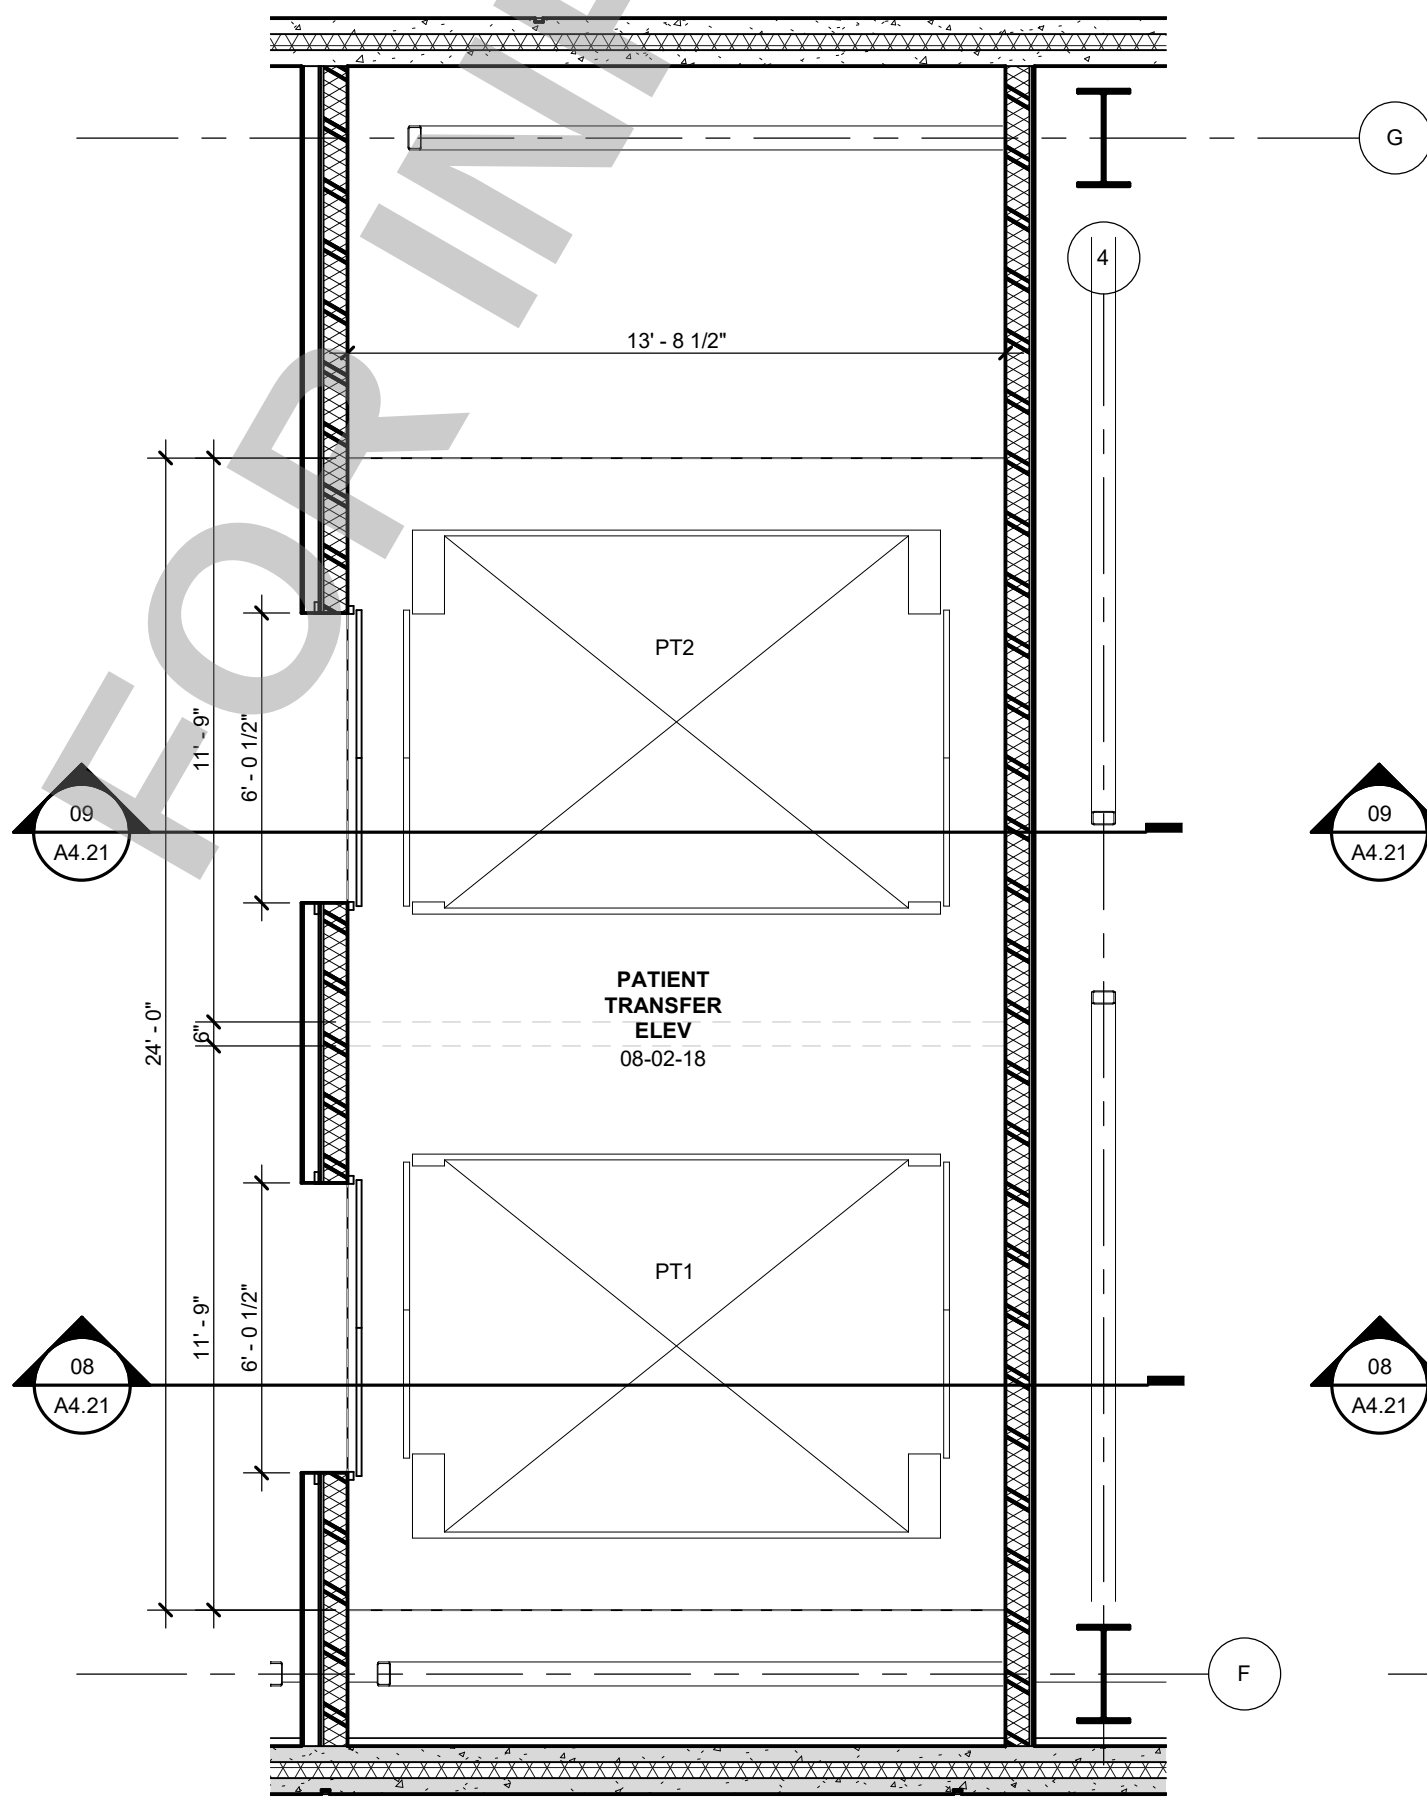


04 PATIENT TRANSFER ELEVATOR LEVEL 04
1/4" = 1'-0"

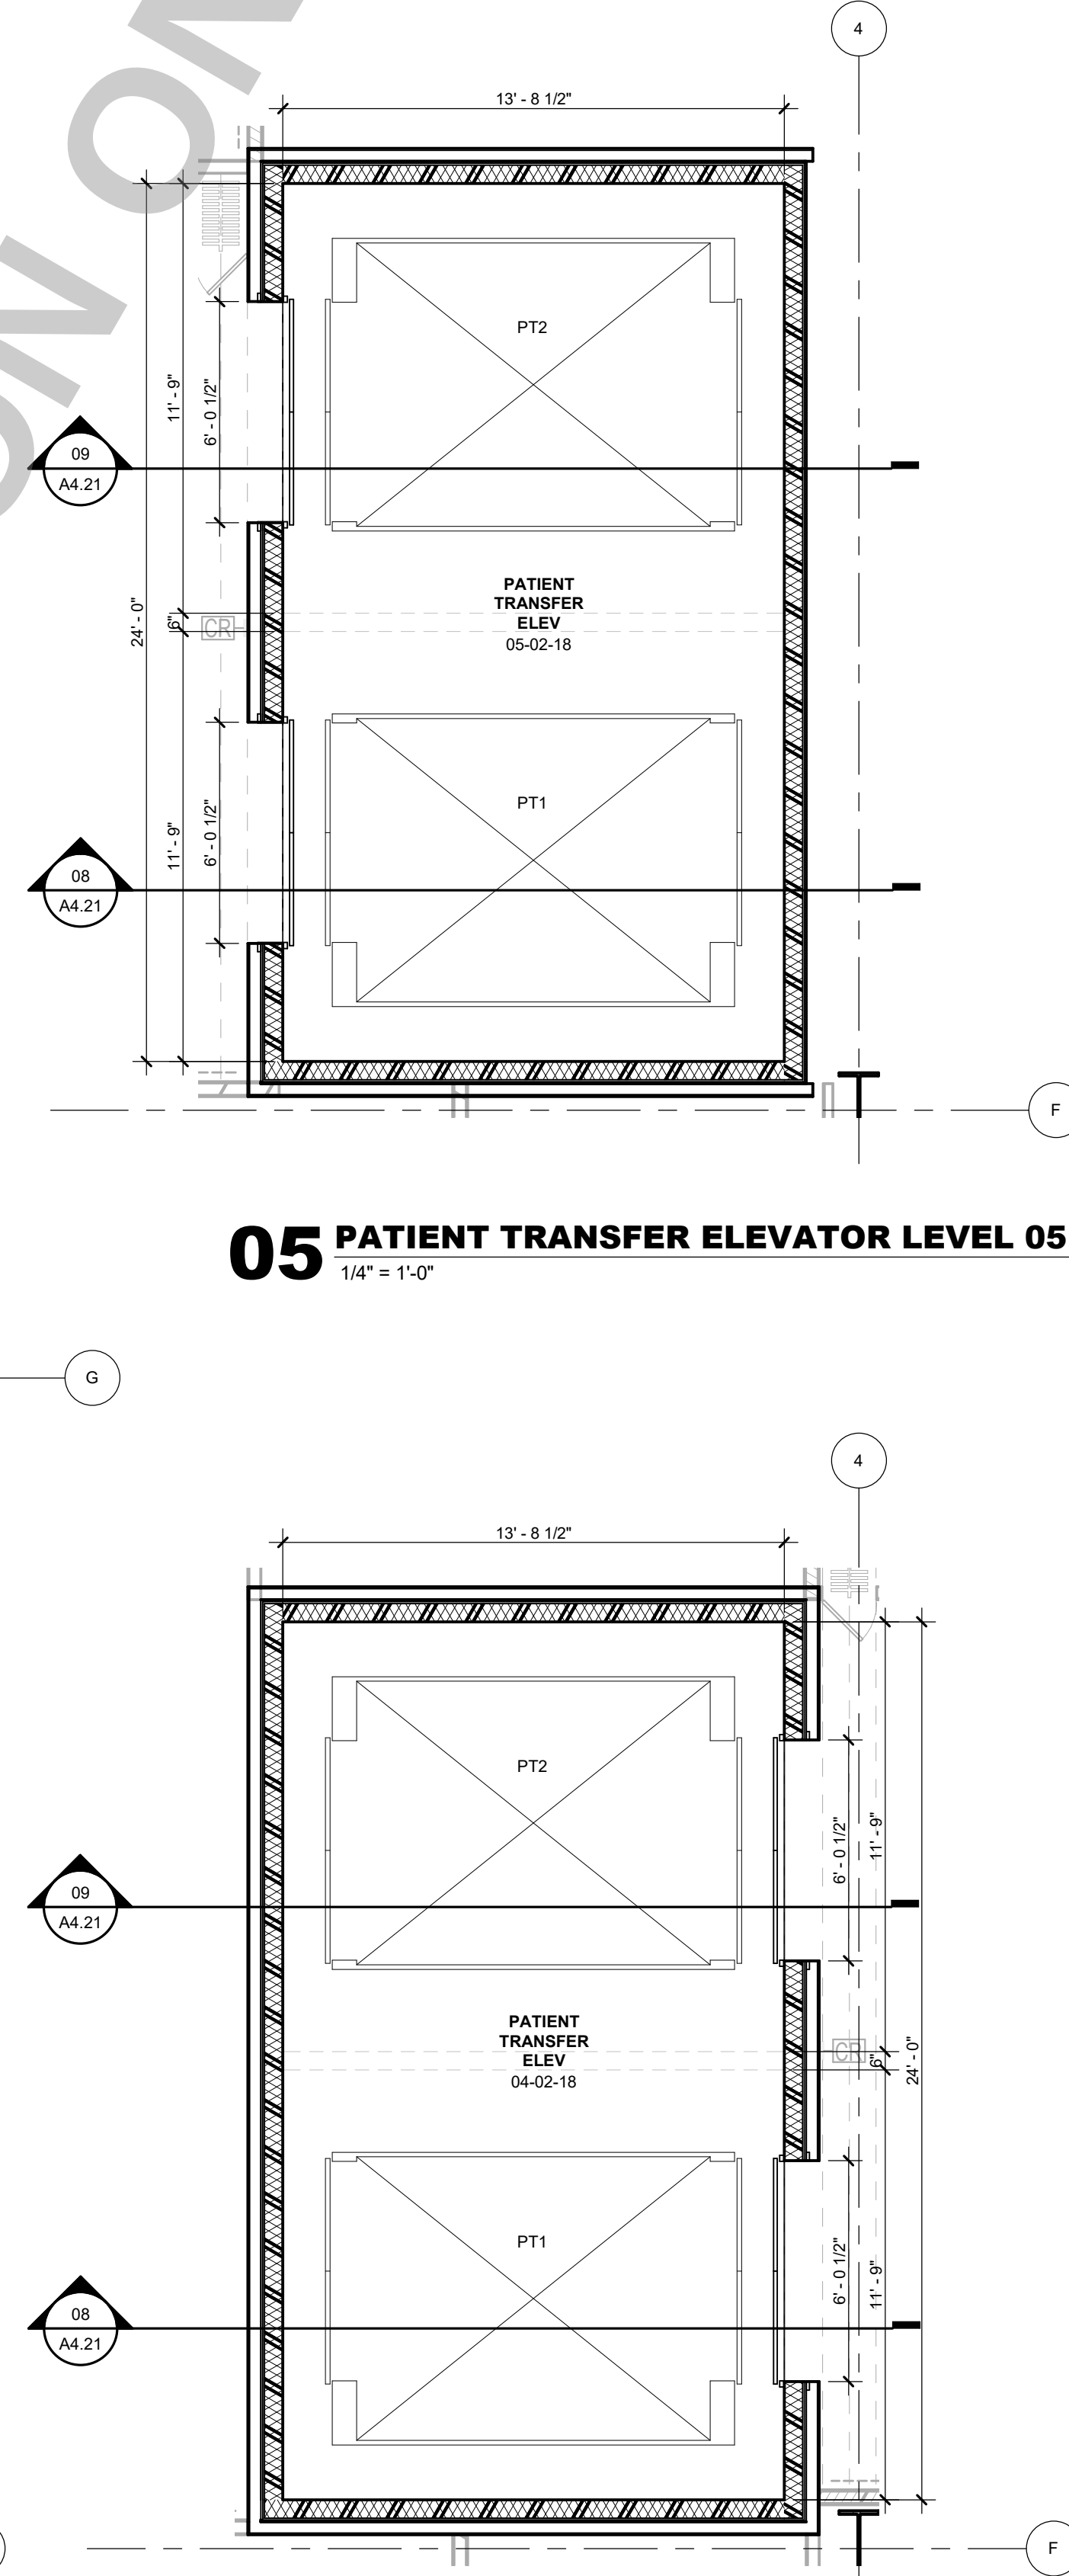


05 PATIENT TRANSFER ELEVATOR LEVEL 05
1/4" = 1'-0"

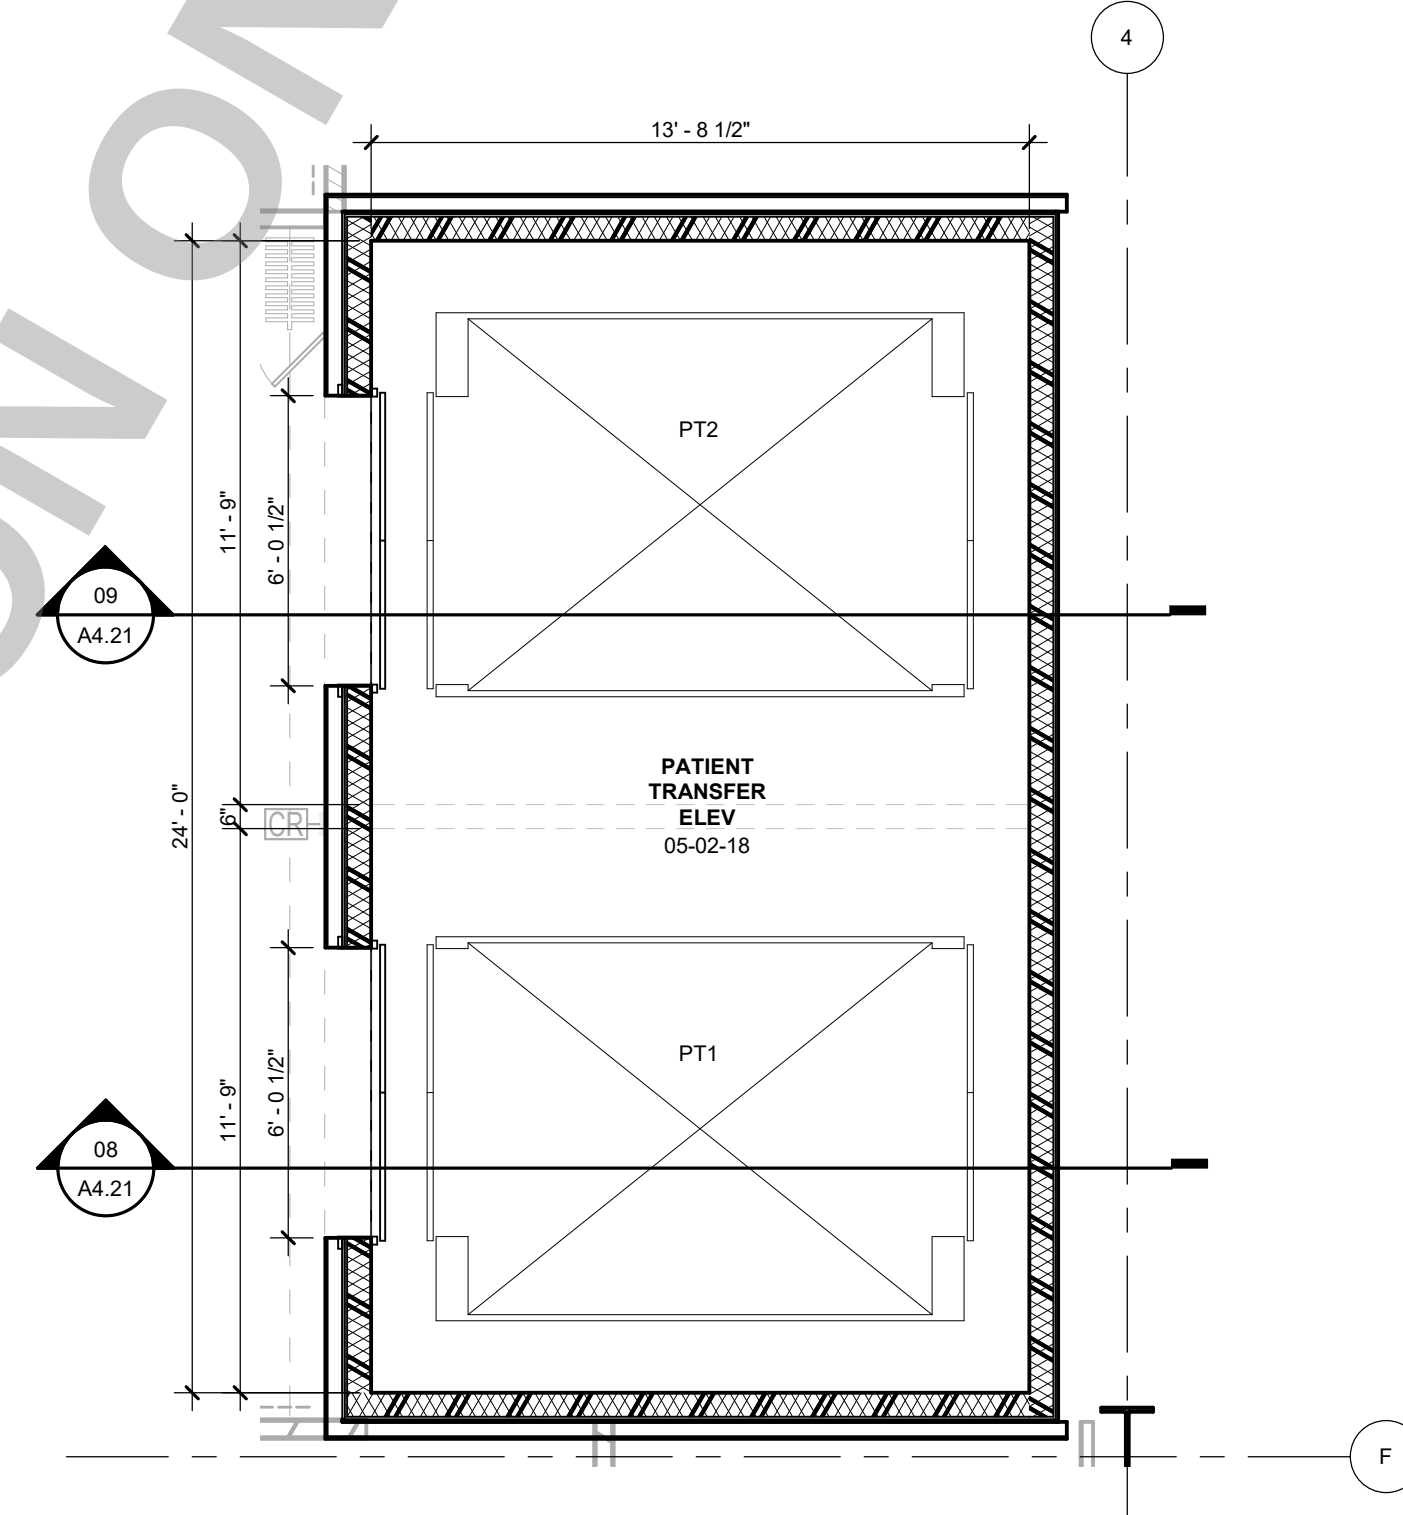


06 PATIENT TRANSFER ELEVATOR LEVEL 06
1/4" = 1'-0"

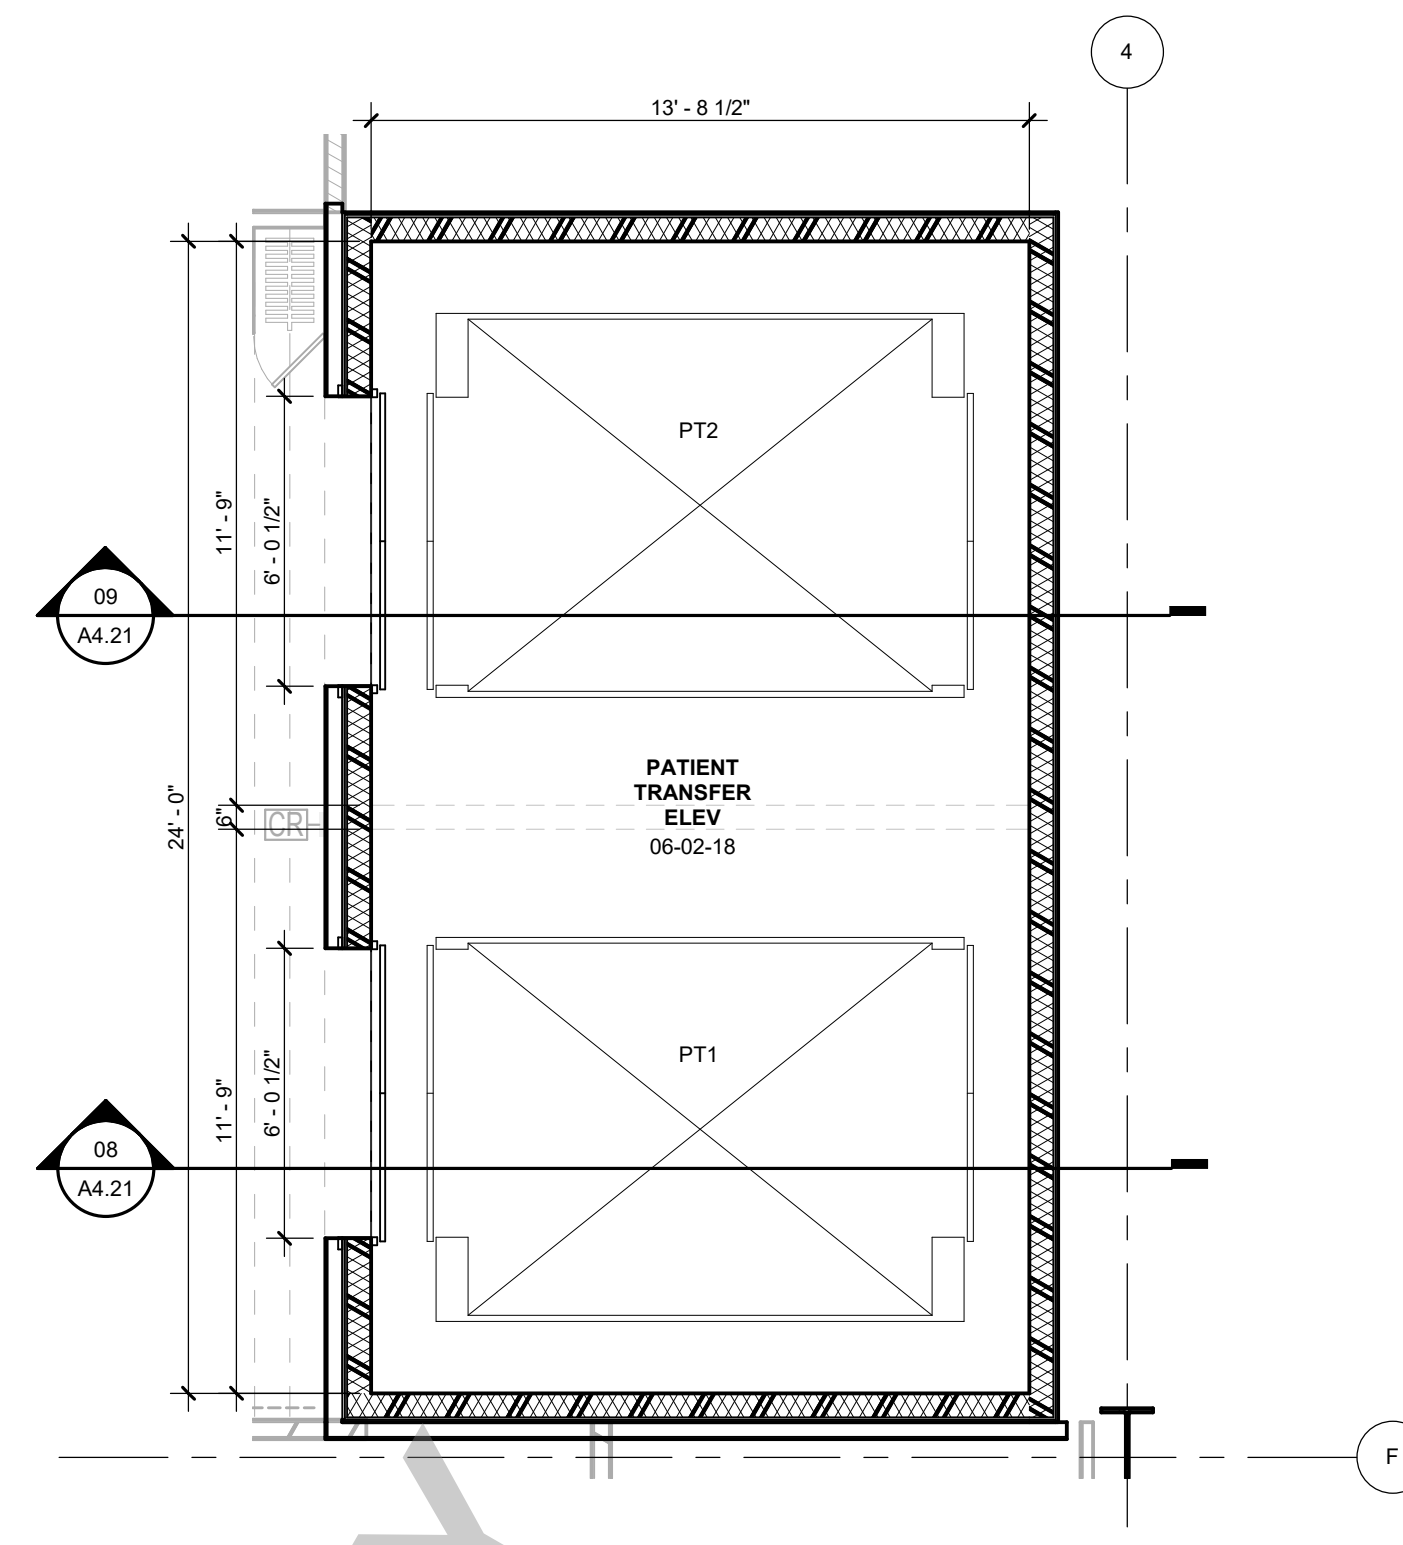


01 PATIENT TRANSFER ELEVATOR LEVEL 01
1/4" = 1'-0"






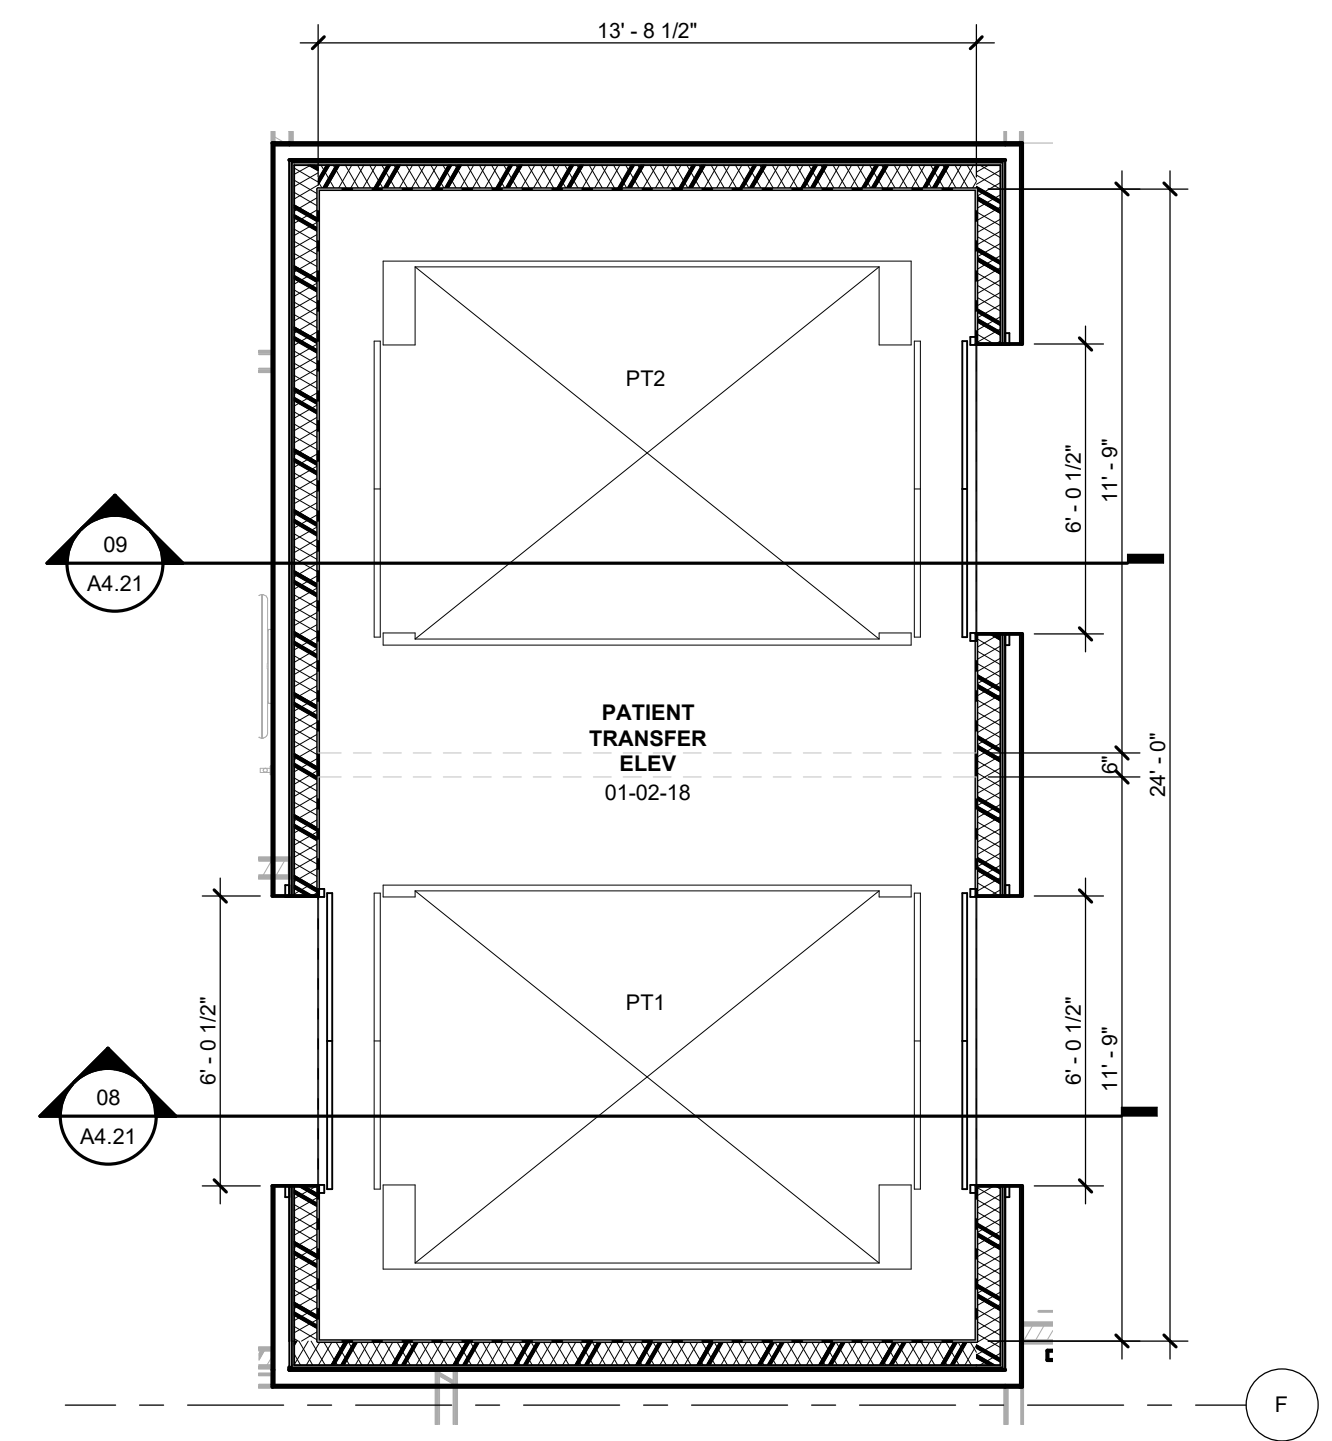


02 PATIENT TRANSFER ELEVATOR LEVEL 02
1/4" = 1'-0"


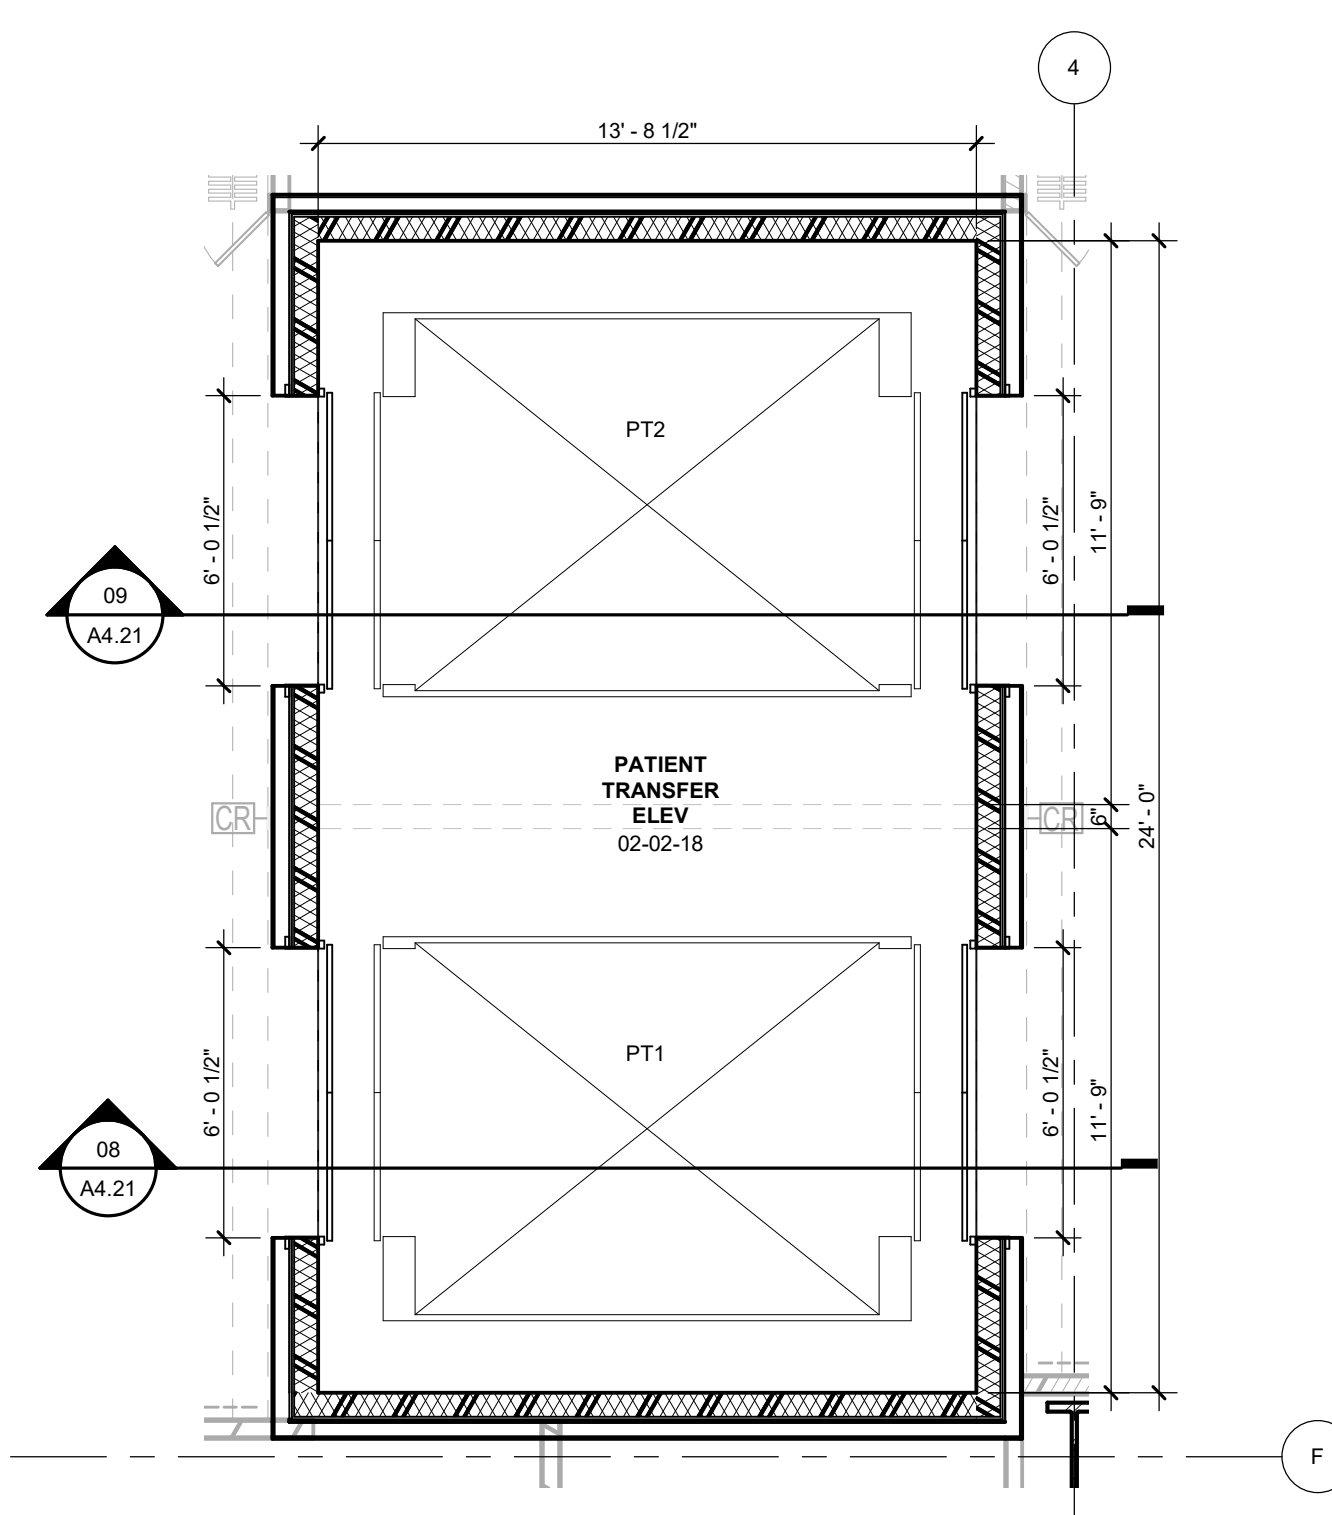


03 PATIENT TRANSFER ELEVATOR LEVEL 03
1/4" = 1'-0"

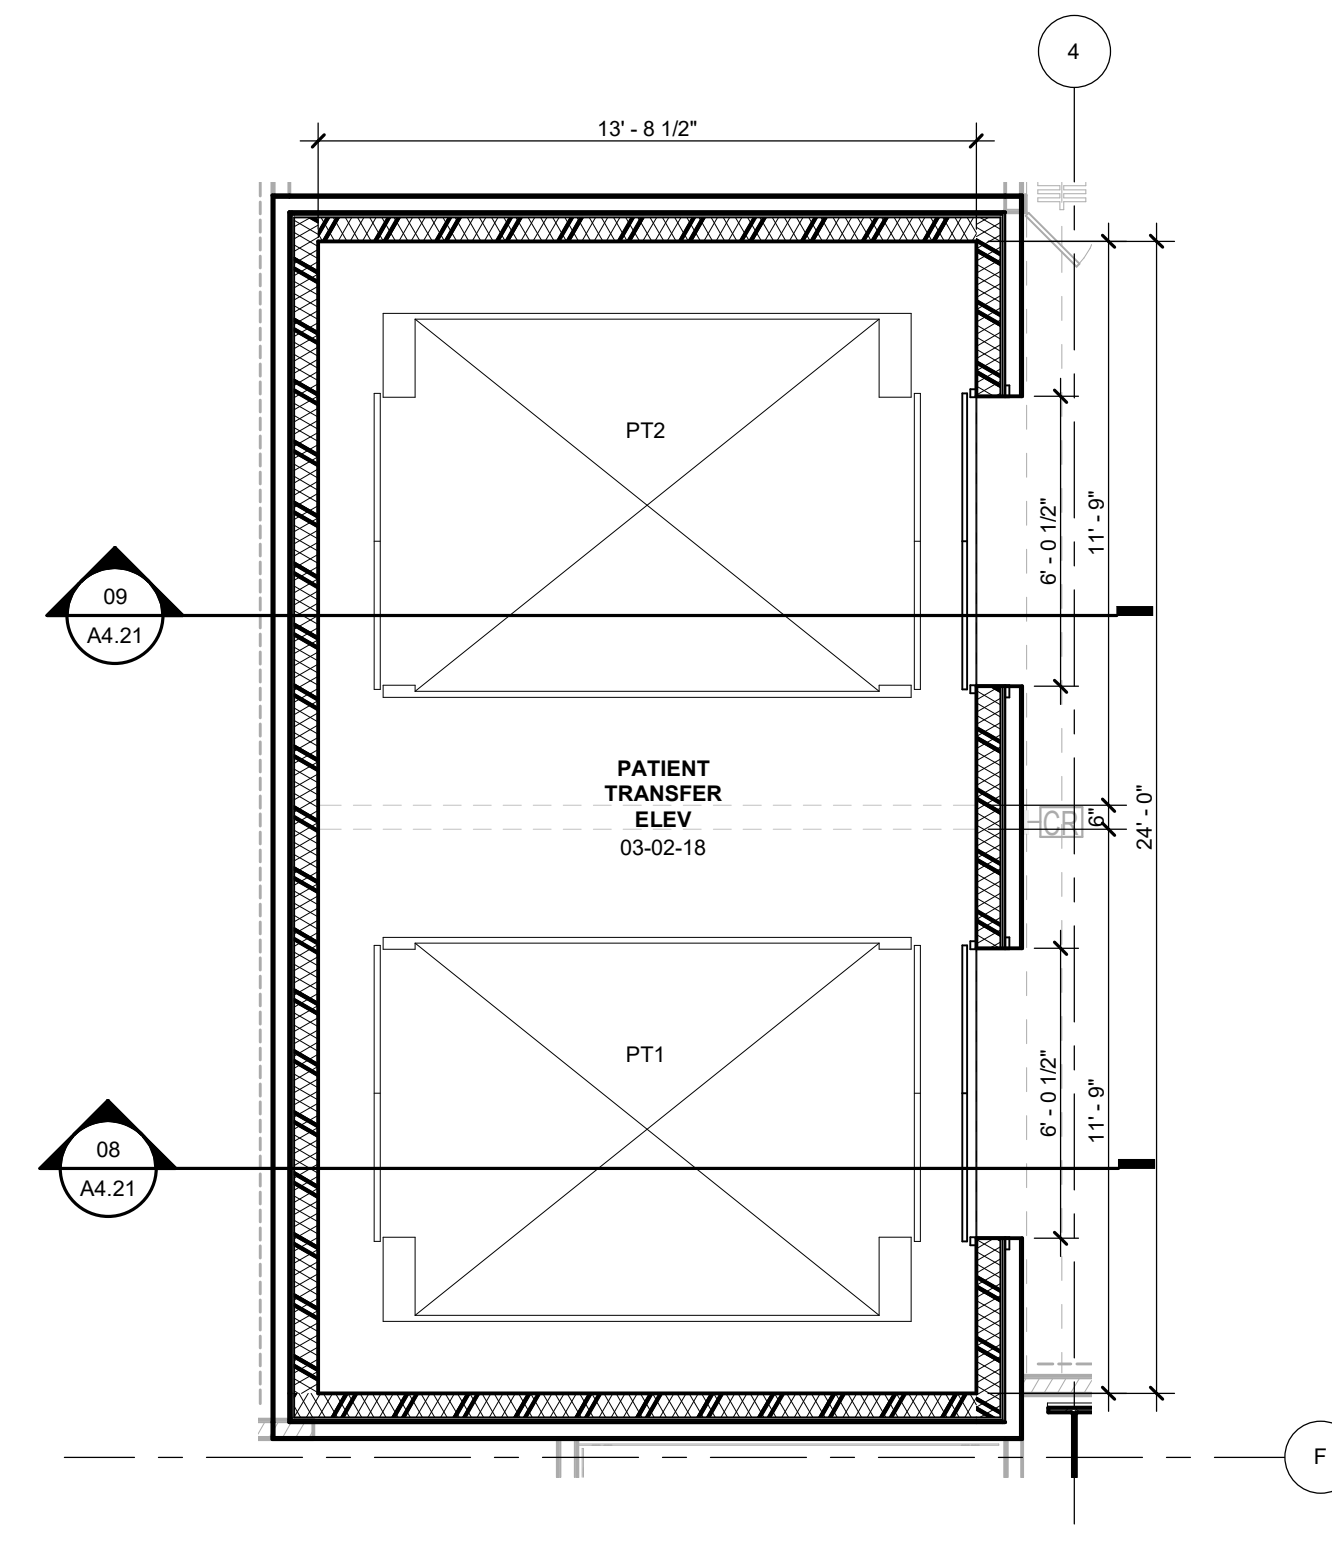


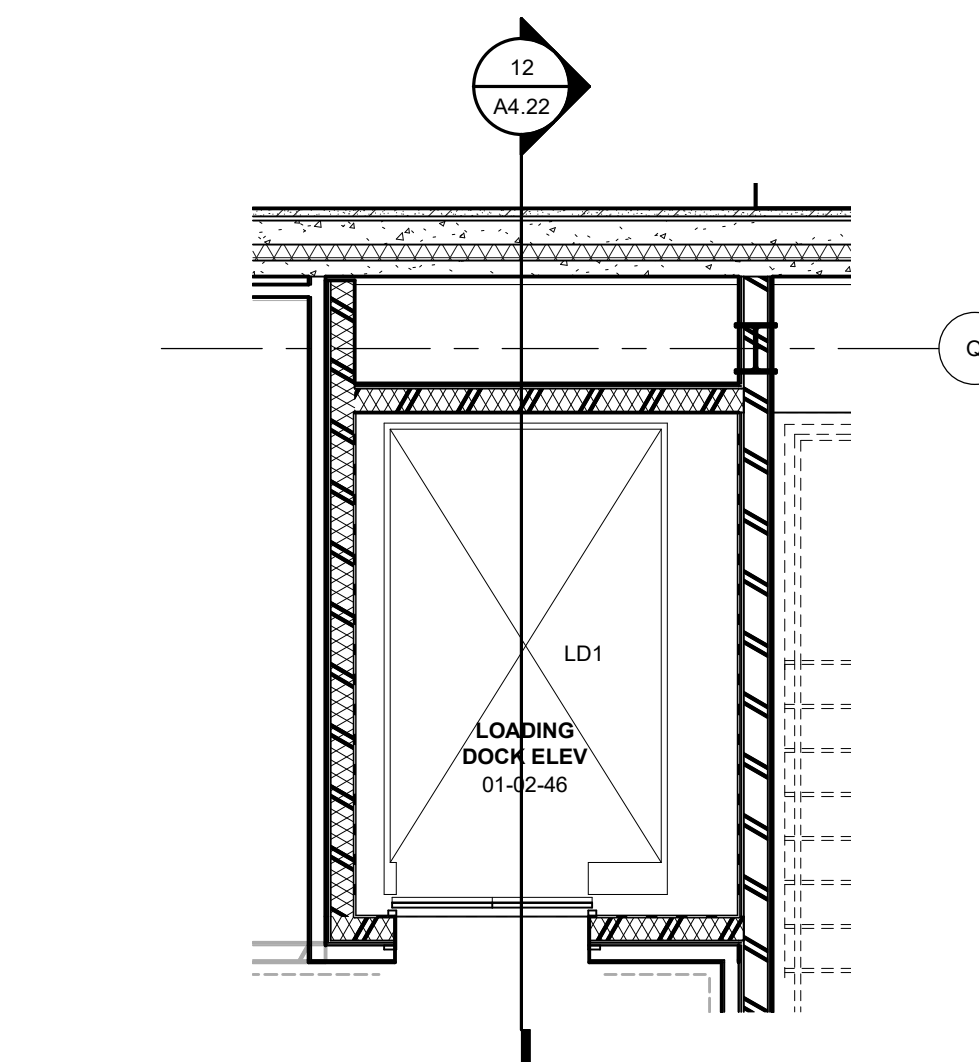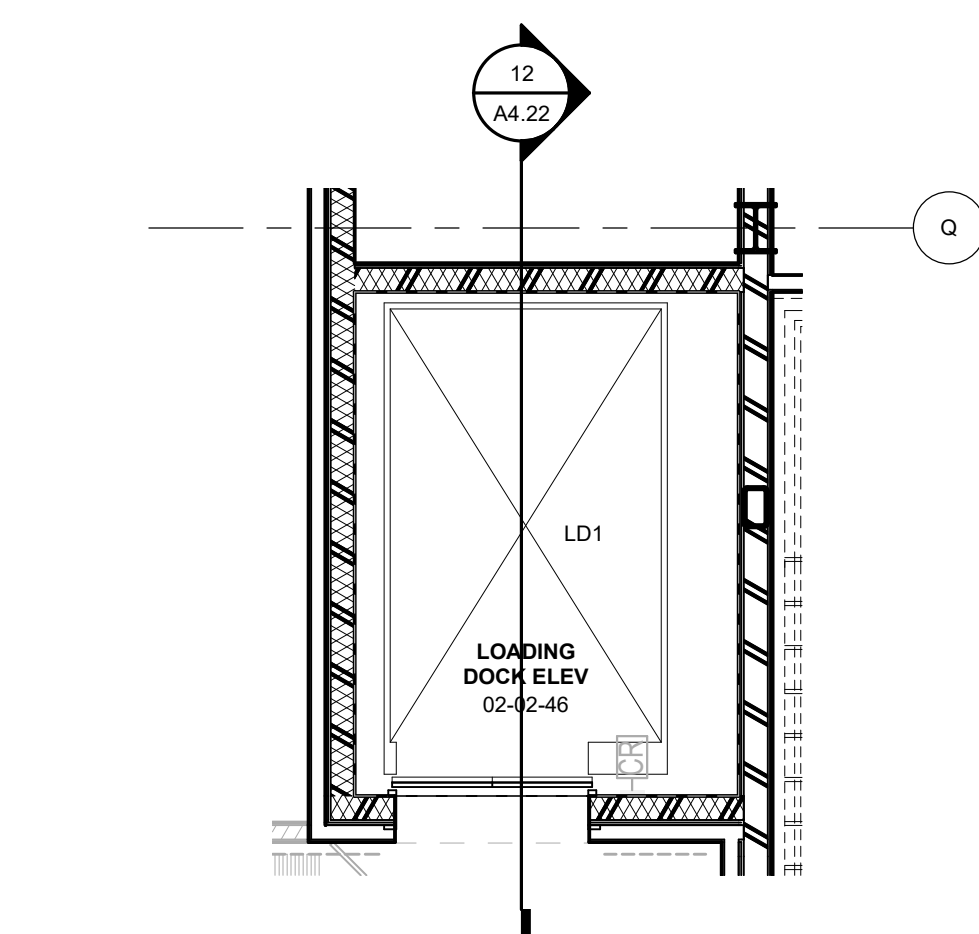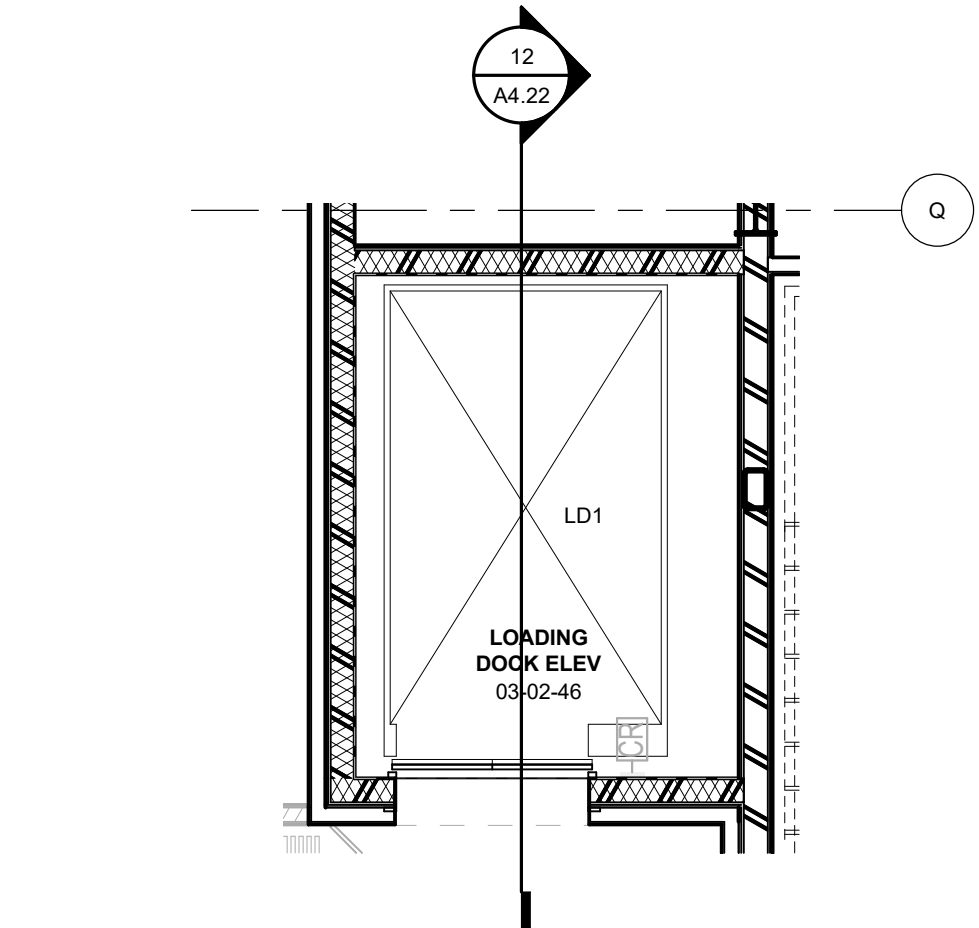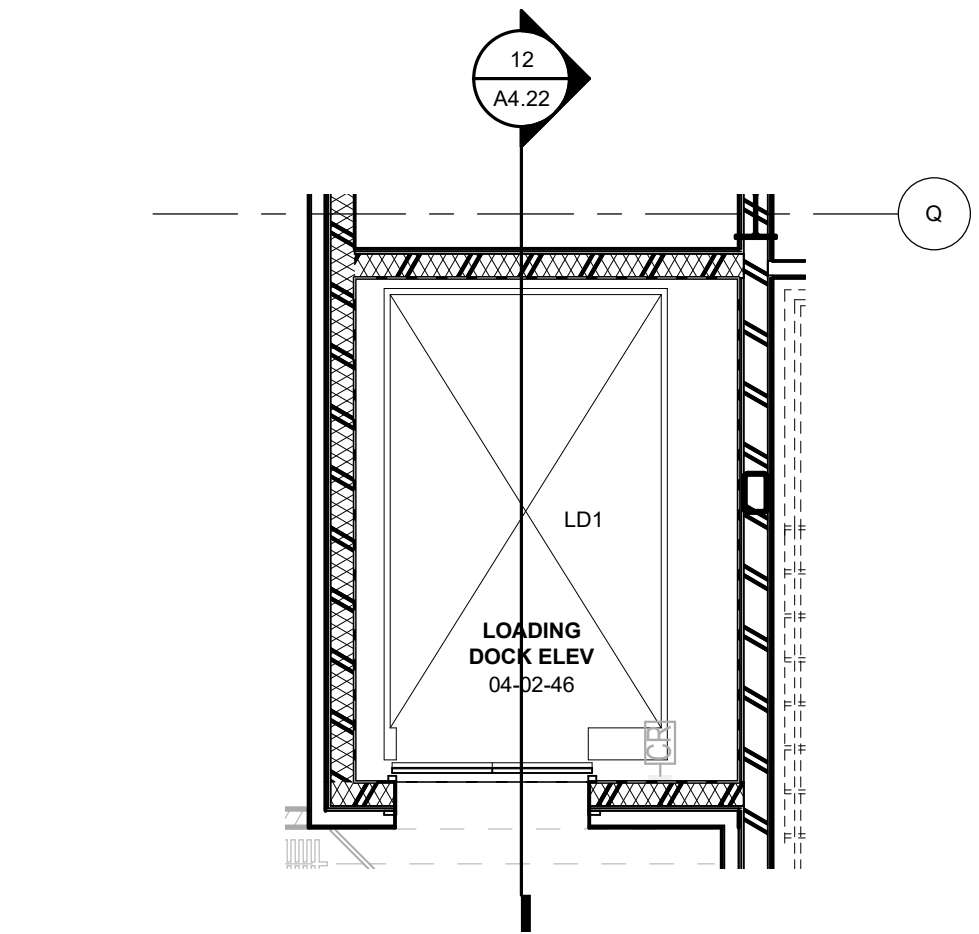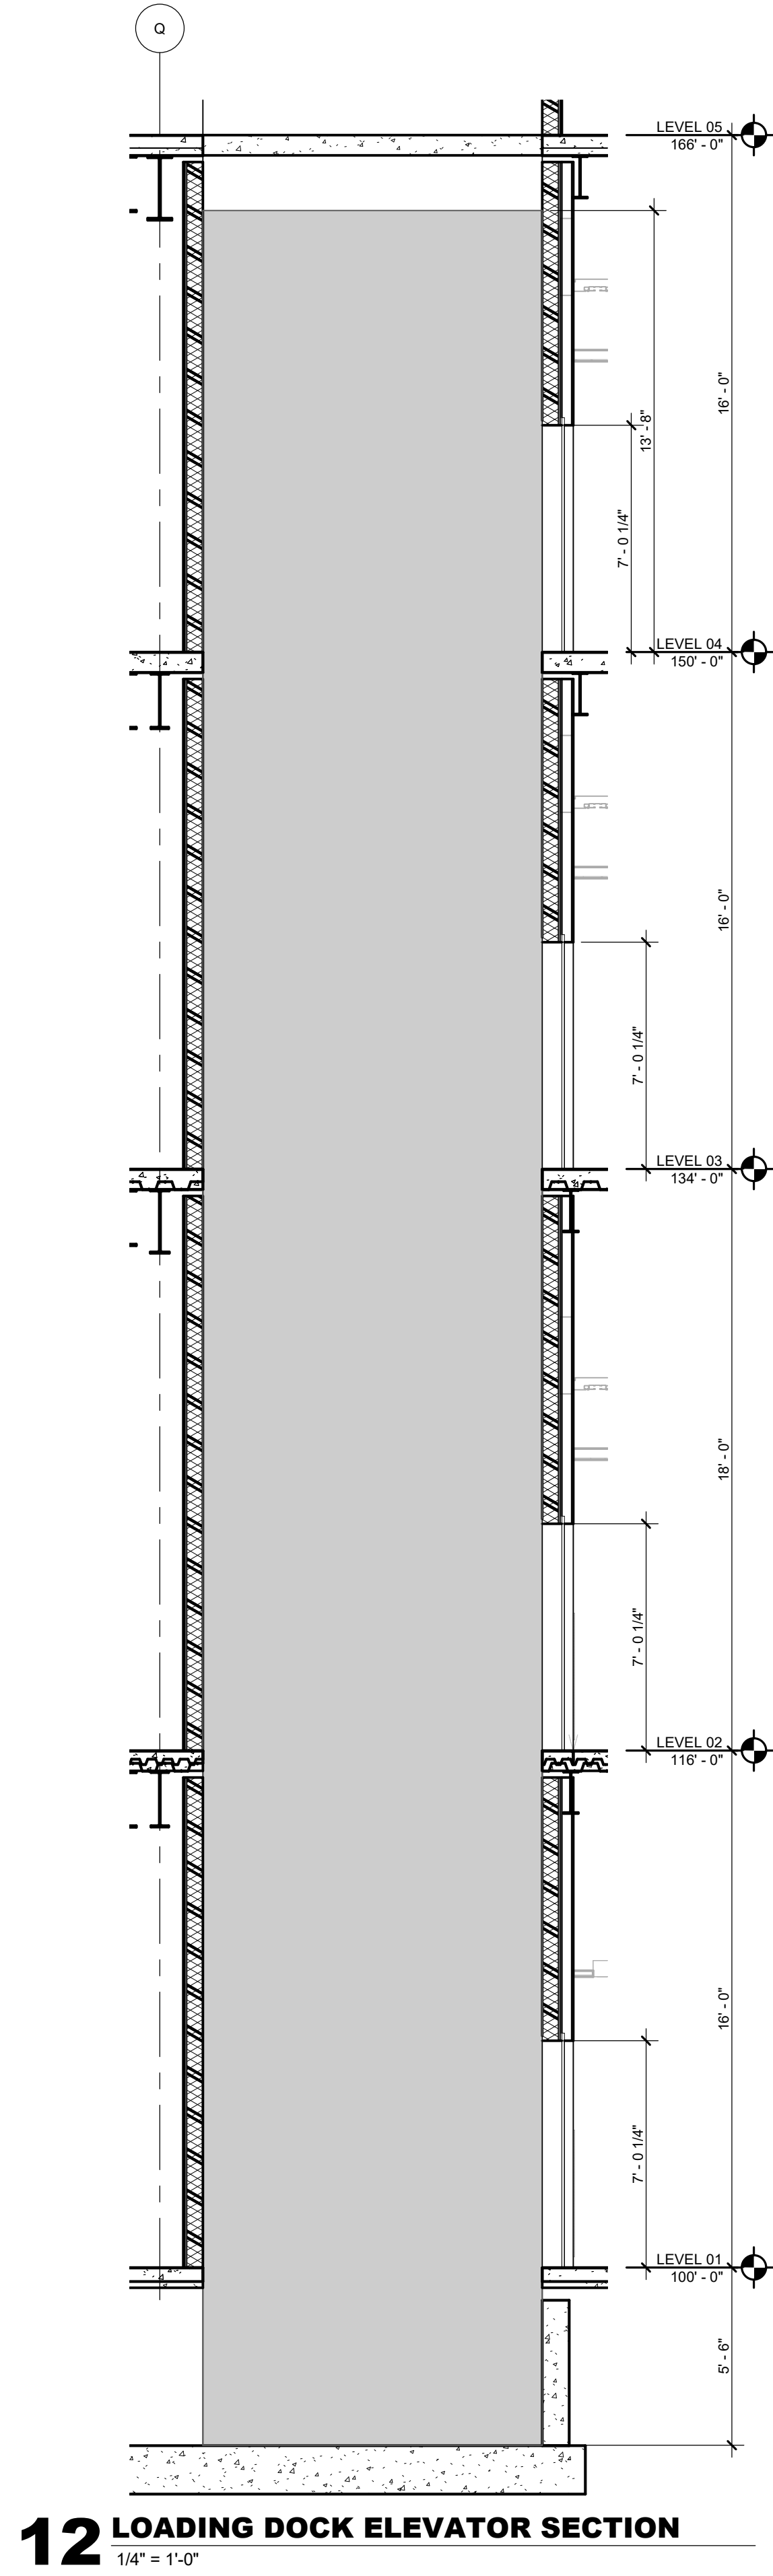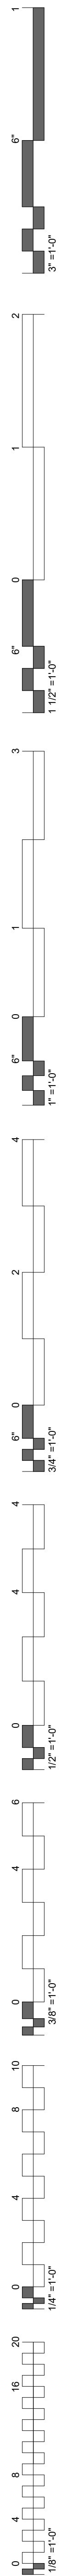


08 LOADING DOCK ELEVATOR LEVEL 01
1/4" = 1'-0"

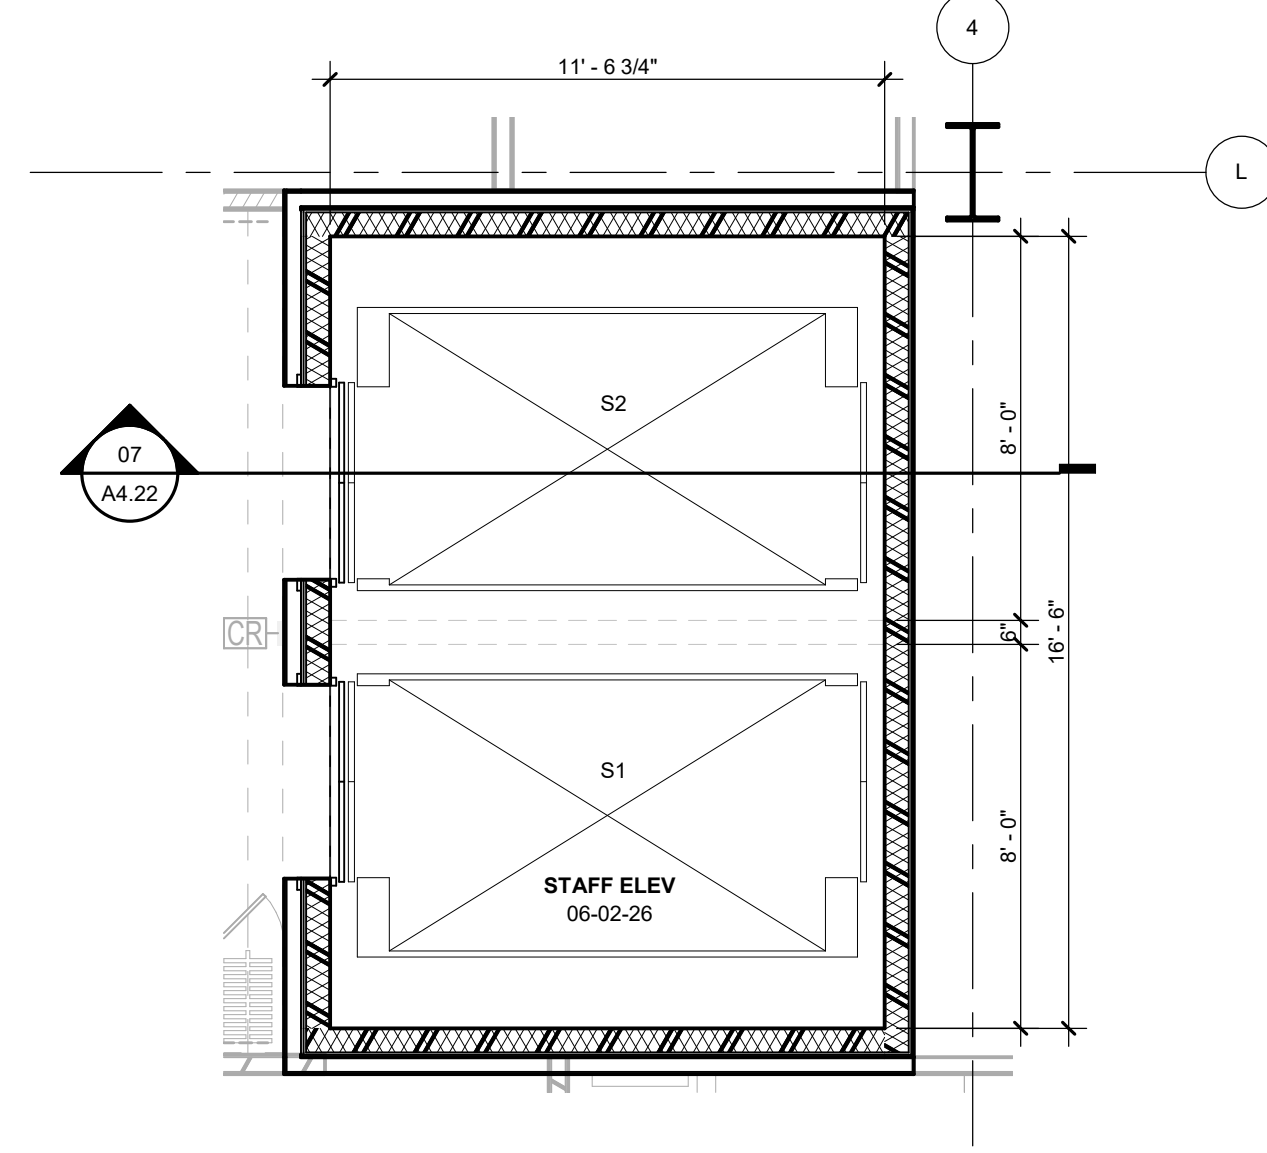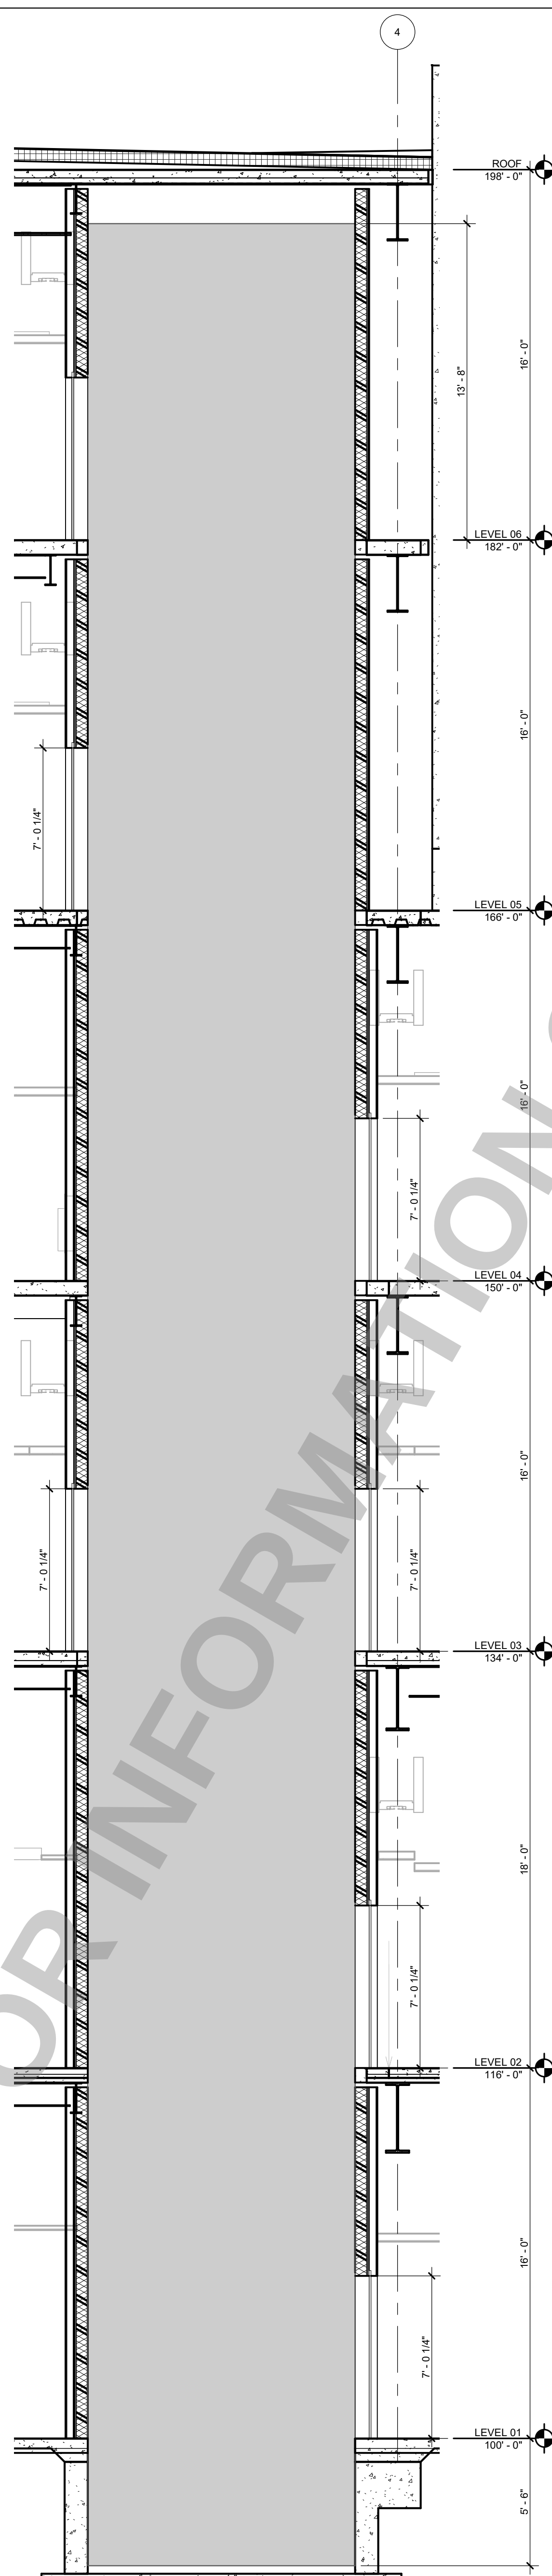


06 STAFF ELEVATOR LEVEL 06
1/4" = 1'-0"

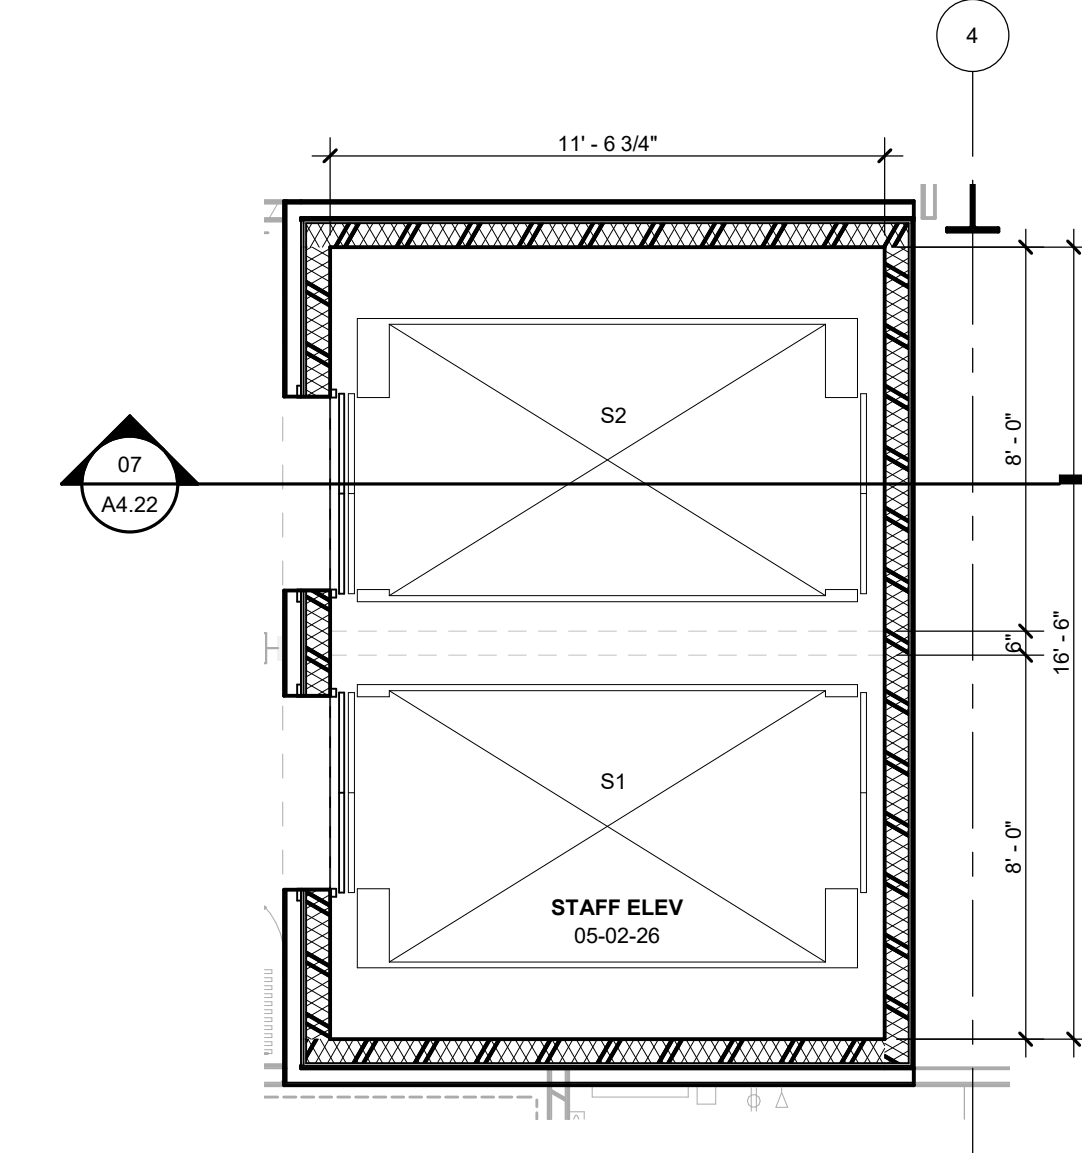


05 STAFF ELEVATOR LEVEL 05
1/4" = 1'-0"

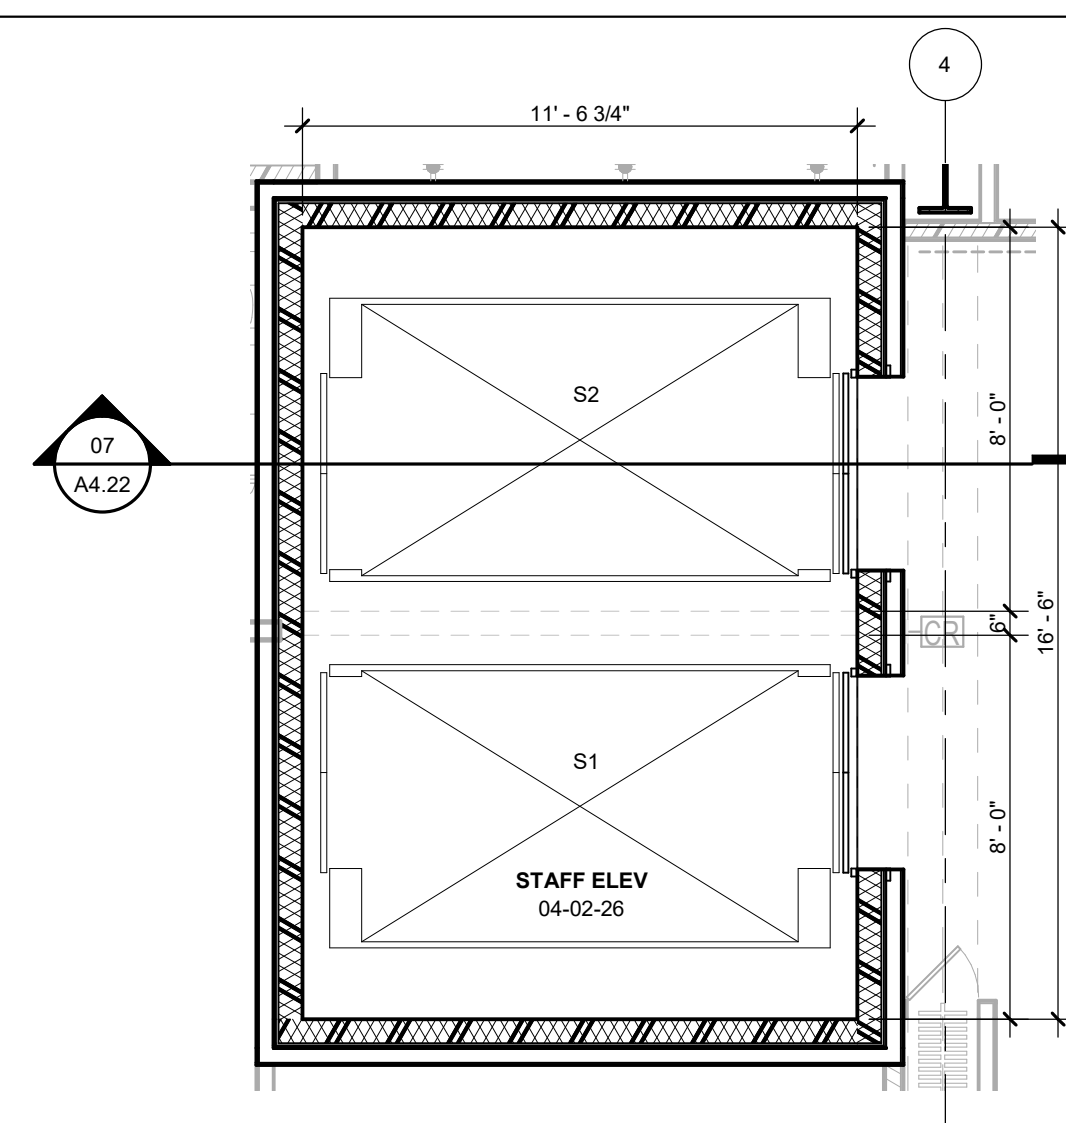


04 STAFF ELEVATOR LEVEL 04
1/4" = 1'-0"

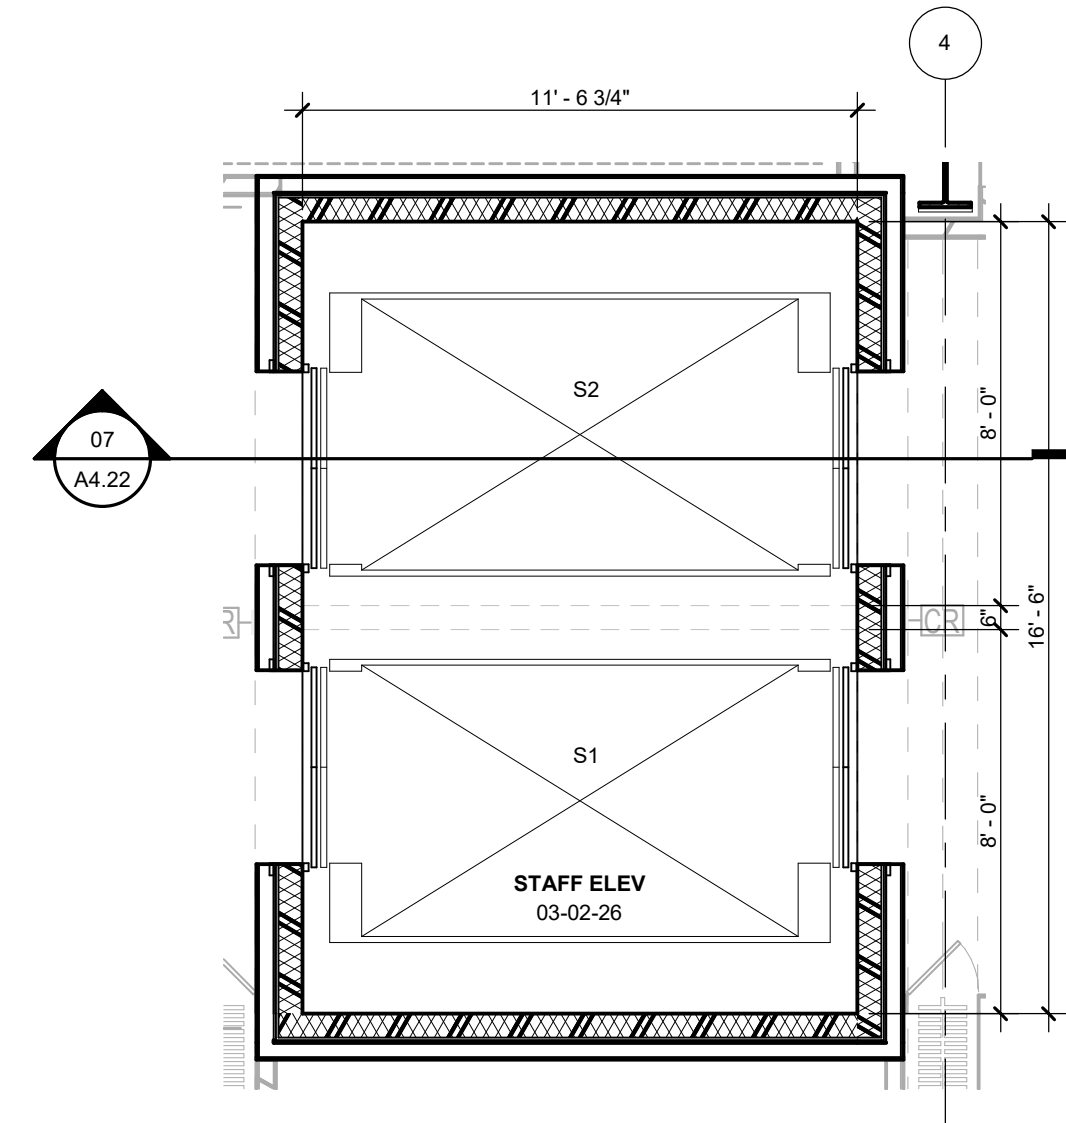


03 STAFF ELEVATOR LEVEL 03
1/4" = 1'-0"

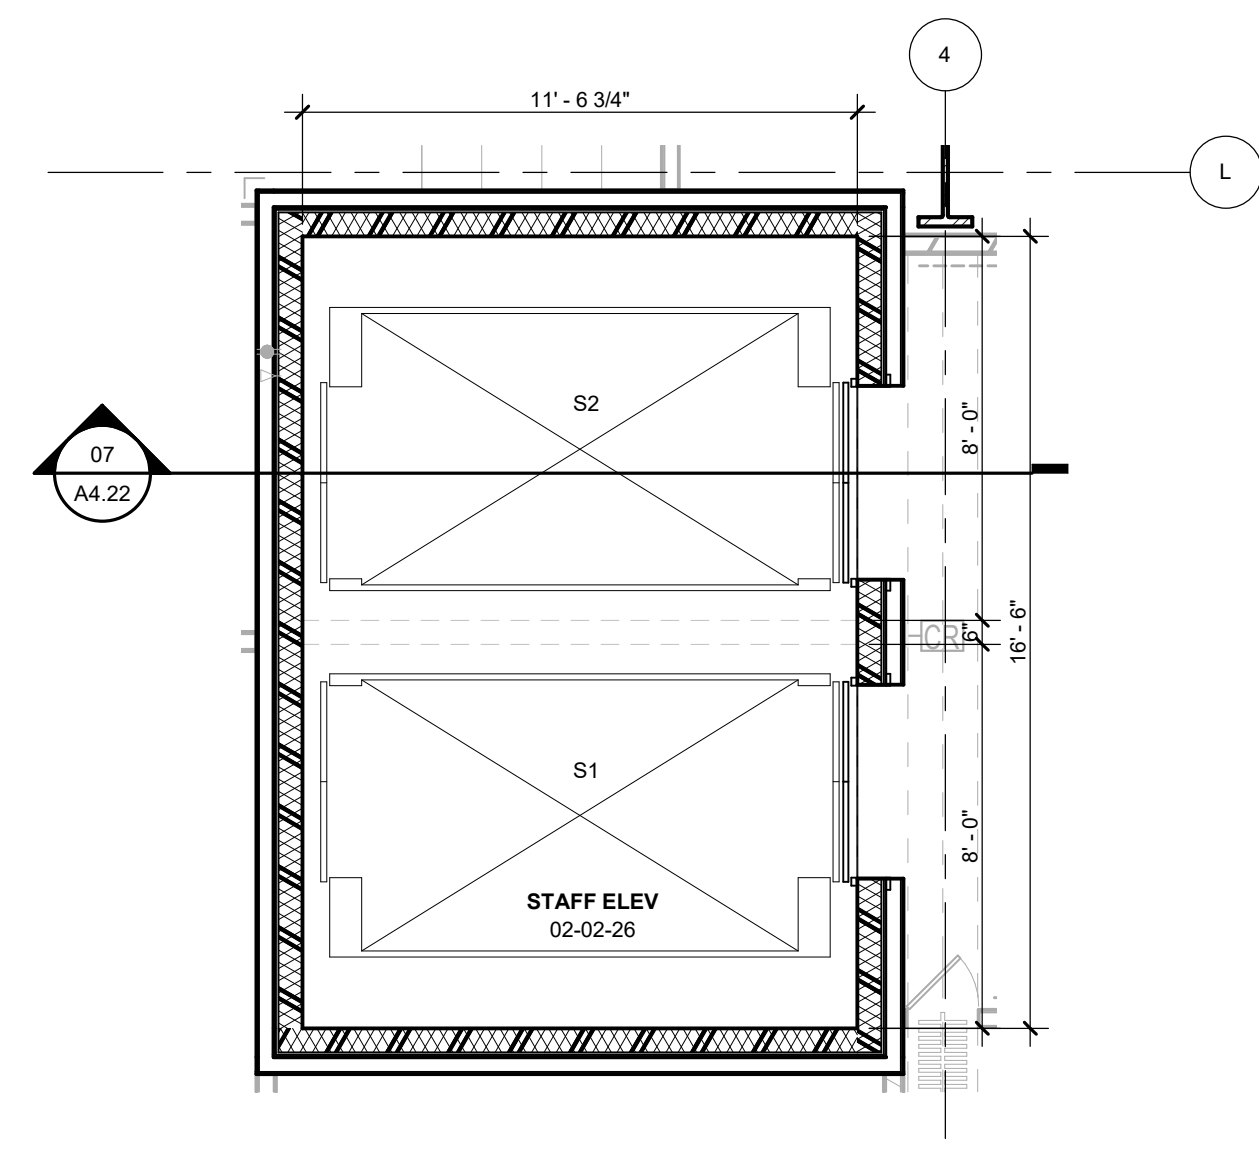


02 STAFF ELEVATOR LEVEL 02
1/4" = 1'-0"

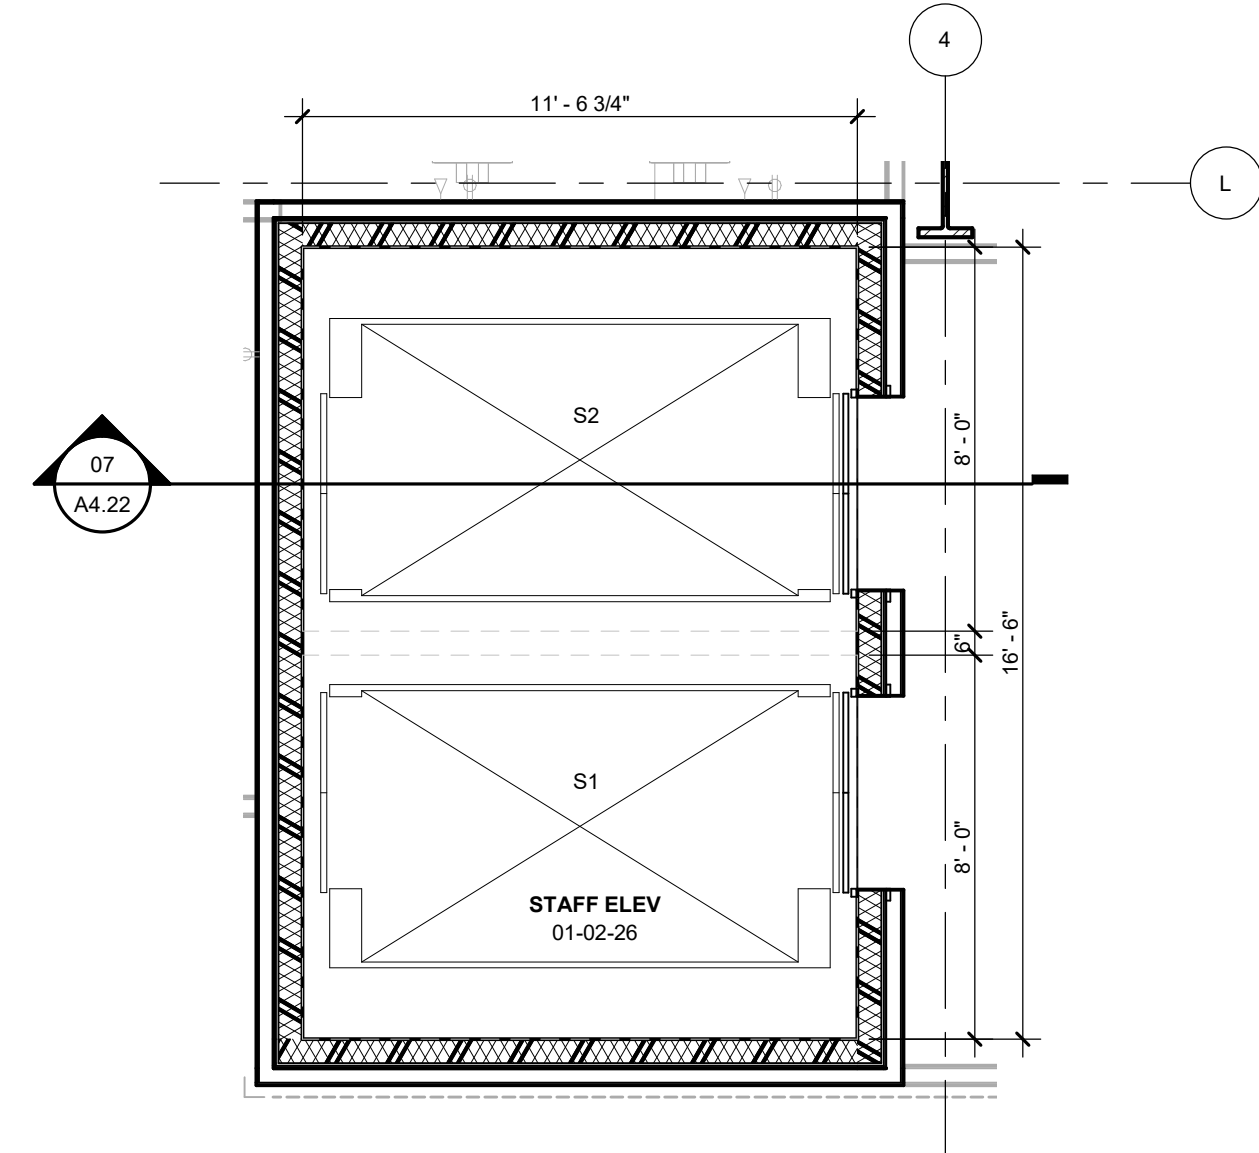


01 STAFF ELEVATOR LEVEL 01
1/4" = 1'-0"

 


ELEVATOR FINISHES	
PUBLIC ELEVATOR CABS:	
FLOOR: TERRAZZO	
MANUFACTURER'S STANDARD CAB INTERIOR:	
MANUFACTURER: KONE	
STYLE: MONOSPACE 500	
REAR WALL: STUDIO TEAK (L414) WOOD LAMINATE	
SIDE WALLS: BRUSHED STAINLESS STEEL (4SS)	
CEILING: RECTANGULAR LED LIGHT PANEL (C3M4)	
BRUSHED STAINLESS STEEL (4SS)	
HANDRAIL: ROUND, STRAIGHT ENDS (HR61)	
BRUSHED STAINLESS STEEL (4SS)	
SKIRTING: BRUSHED STAINLESS STEEL (4SS)	
PATIENT TRANSFER ELEVATOR CABS:	
FLOOR: RESILIENT RUBBER SHEET	
MANUFACTURER'S STANDARD CAB INTERIOR:	
MANUFACTURER: KONE	
STYLE: MEDICAL FACILITIES - TRAUMA SERIES	
REAR WALL: BRUSHED STAINLESS STEEL (4SS)	
SIDE WALLS: BRUSHED STAINLESS STEEL (4SS)	
CEILING: ROUND LED SPOTLIGHTS(C3L8)	
BRUSHED STAINLESS STEEL (4SS)	
HANDRAIL: ROUND, STRAIGHT ENDS (HR61)	
BRUSHED STAINLESS STEEL (4SS)	
SKIRTING: BRUSHED STAINLESS STEEL (4SS)	
STAFF / LOADING DOCK ELEVATOR CABS:	
FLOOR: VCT	
MANUFACTURER'S STANDARD CAB INTERIOR:	
MANUFACTURER: KONE	
STYLE: MONOSPACE 500	
REAR WALL: BRUSHED STAINLESS STEEL (4SS)	
SIDE WALLS: BRUSHED STAINLESS STEEL (4SS)	
CEILING: ROUND LED SPOTLIGHTS(C3L8)	
BRUSHED STAINLESS STEEL (4SS)	
HANDRAIL: ROUND, STRAIGHT ENDS (HR61)	
BRUSHED STAINLESS STEEL (4SS)	
SKIRTING: BRUSHED STAINLESS STEEL (4SS)	

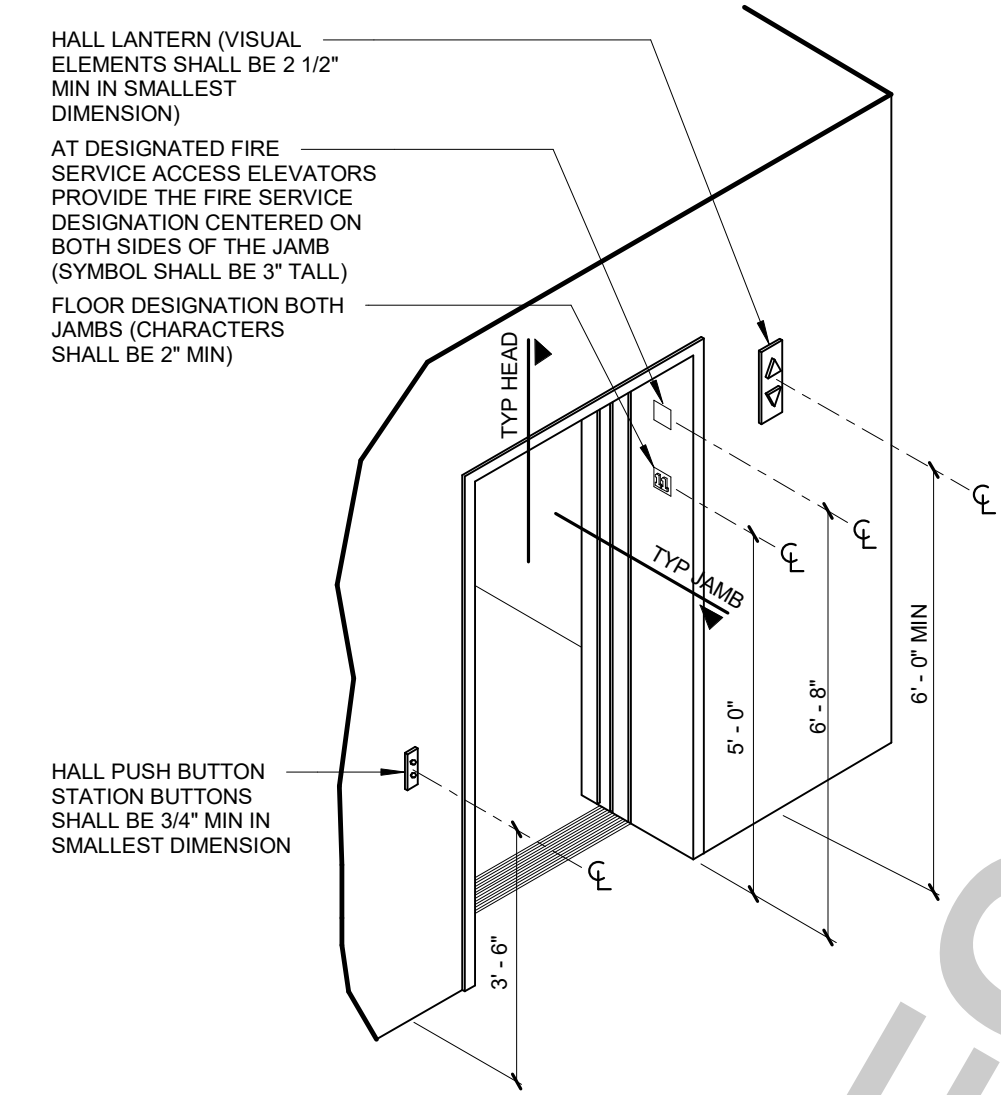


ELEVATOR ENTRY AND MOUNTING HEIGHTS
NTS

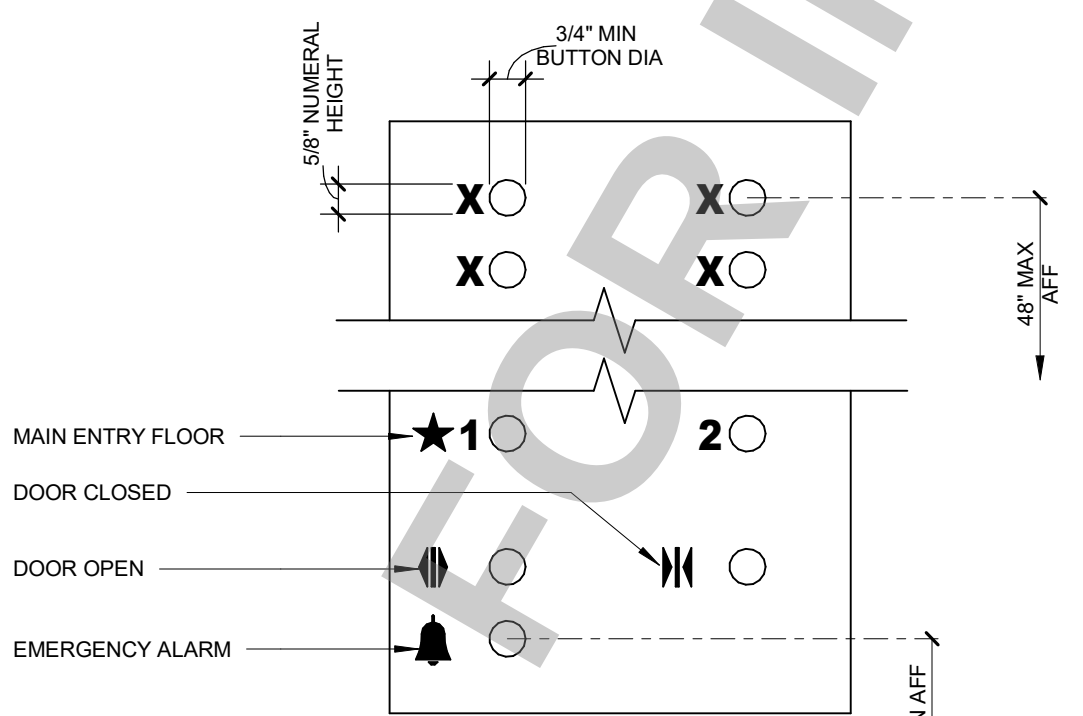


ELEVATOR PANEL DETAIL
3\"/>

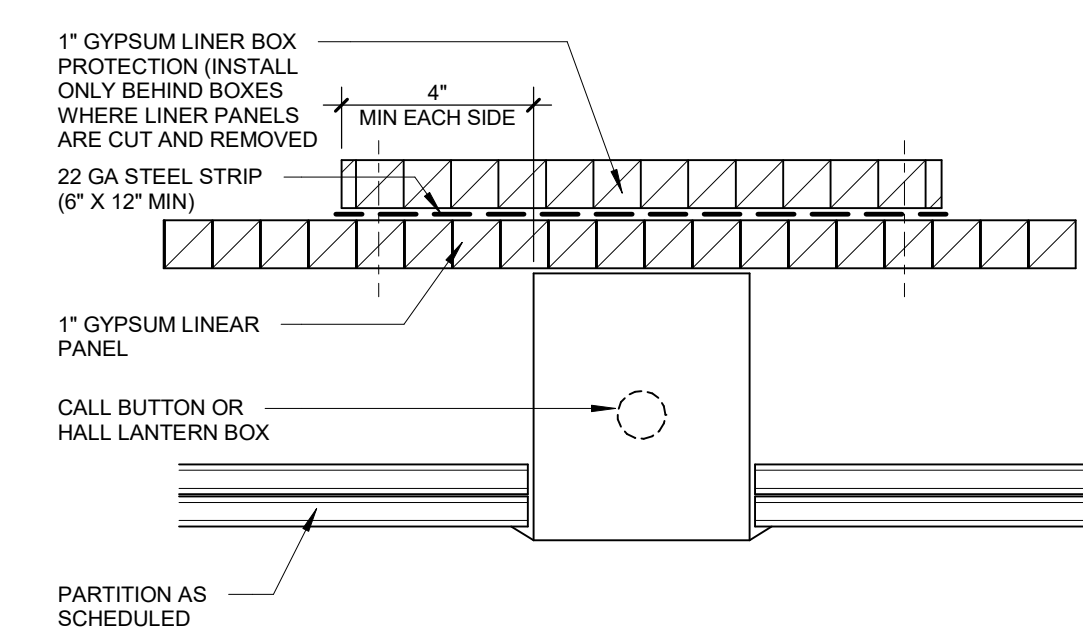


SHAFTWALL PENETRATION DETAIL AT CALL BOX AND OR HALL LANTERN
3\"/>

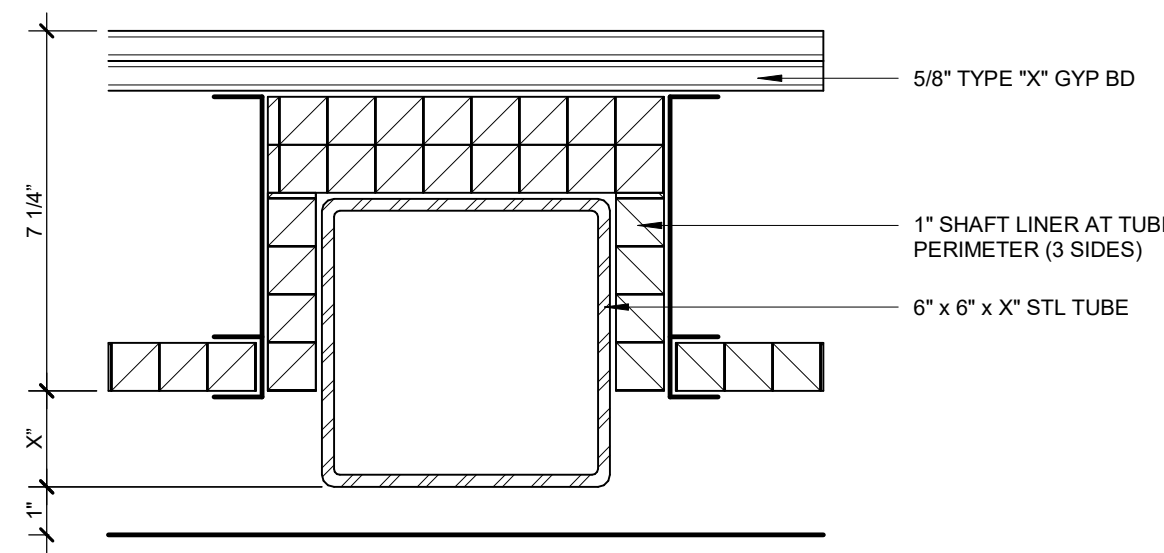


FIRE PROTECTION DETAIL AT ELEVATOR GUIDERAIL SUPPORT - STEEL TUBE GREATER THAN 4"
3\"/>

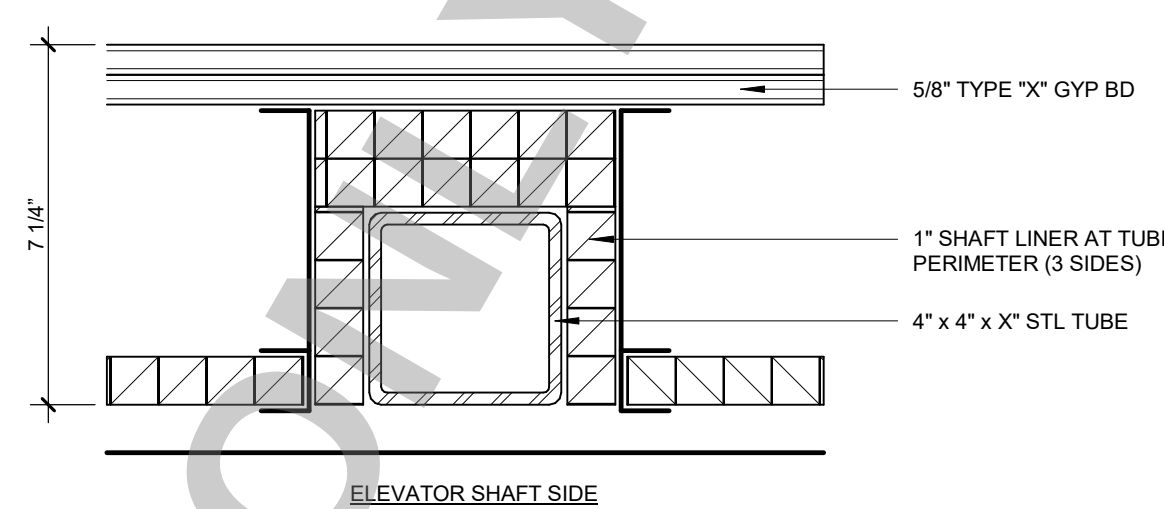


FIRE PROTECTION DETAIL AT ELEVATOR GUIDERAIL SUPPORT - STEEL TUBE 4\" OR LESS
3\"/>

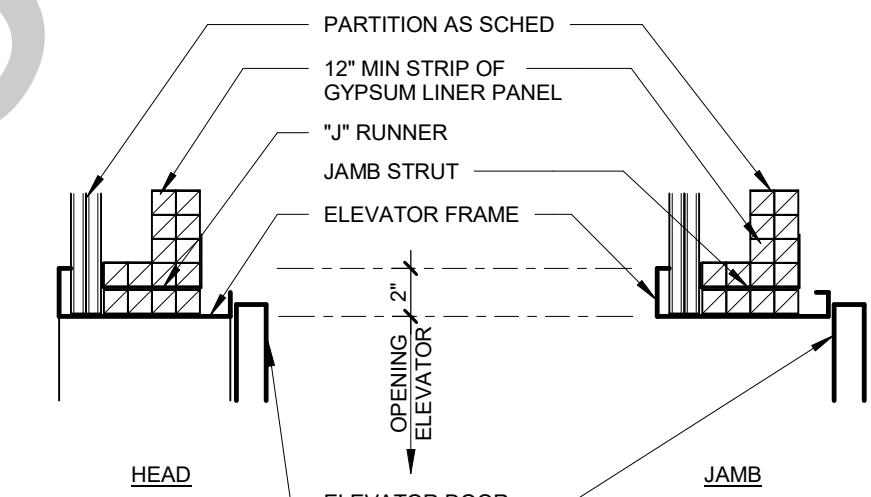


ELEVATOR DOOR DETAIL DRYWALL
1 1/2\"/>

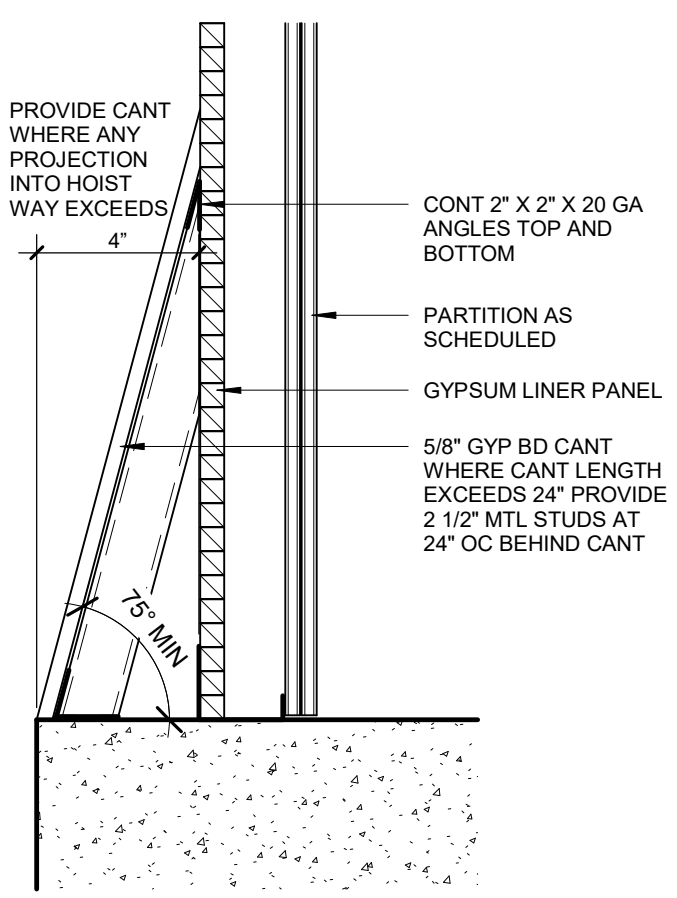


HOISTWAY DETAIL PROJECTION CANT
NTS

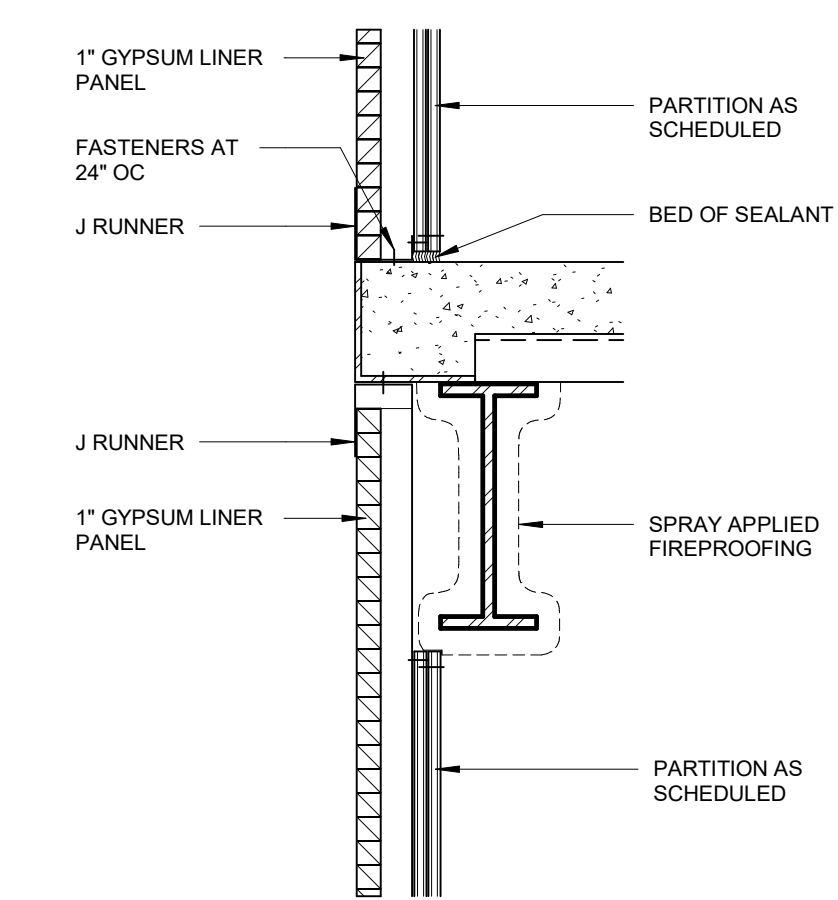


SHAFTWALL AT ELEVATOR
1 1/2\"/>

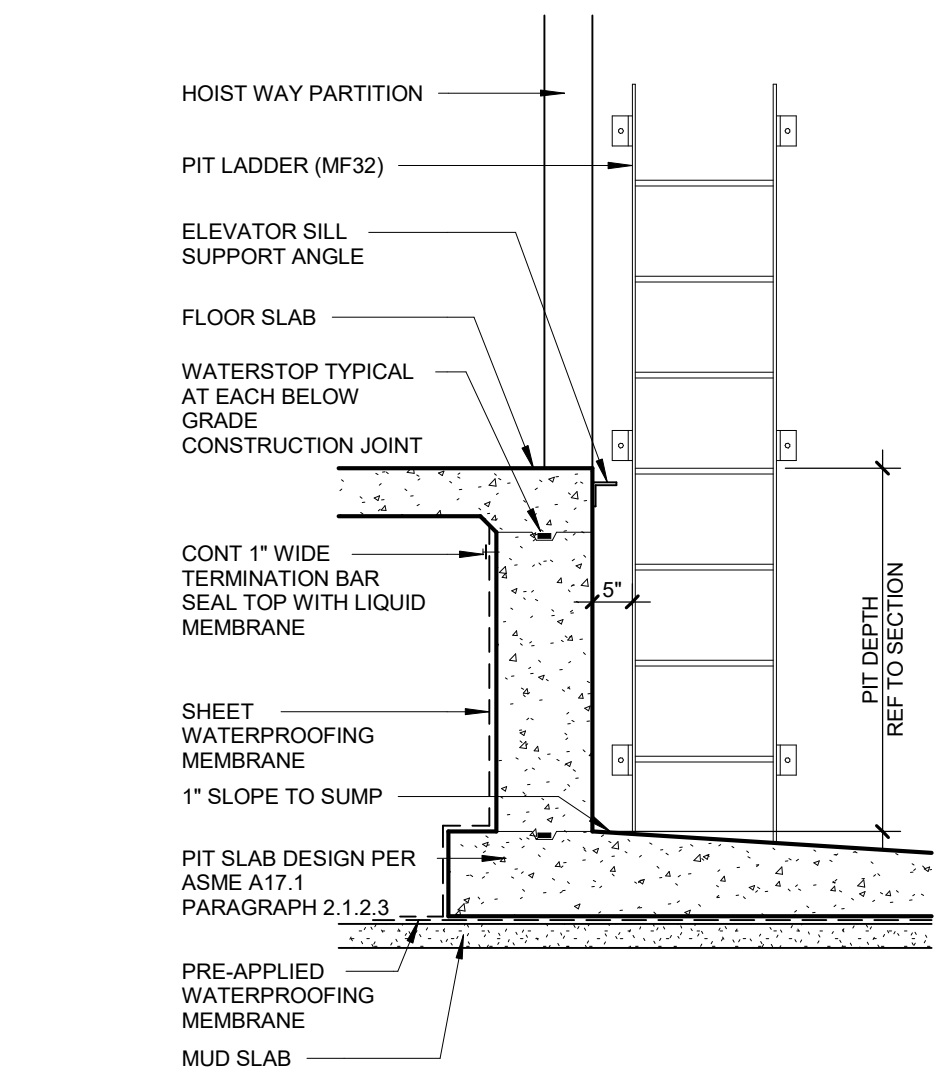


PIT SECTION WITH POSITIVE SIDE WATERPROOFING
1/2\"/>

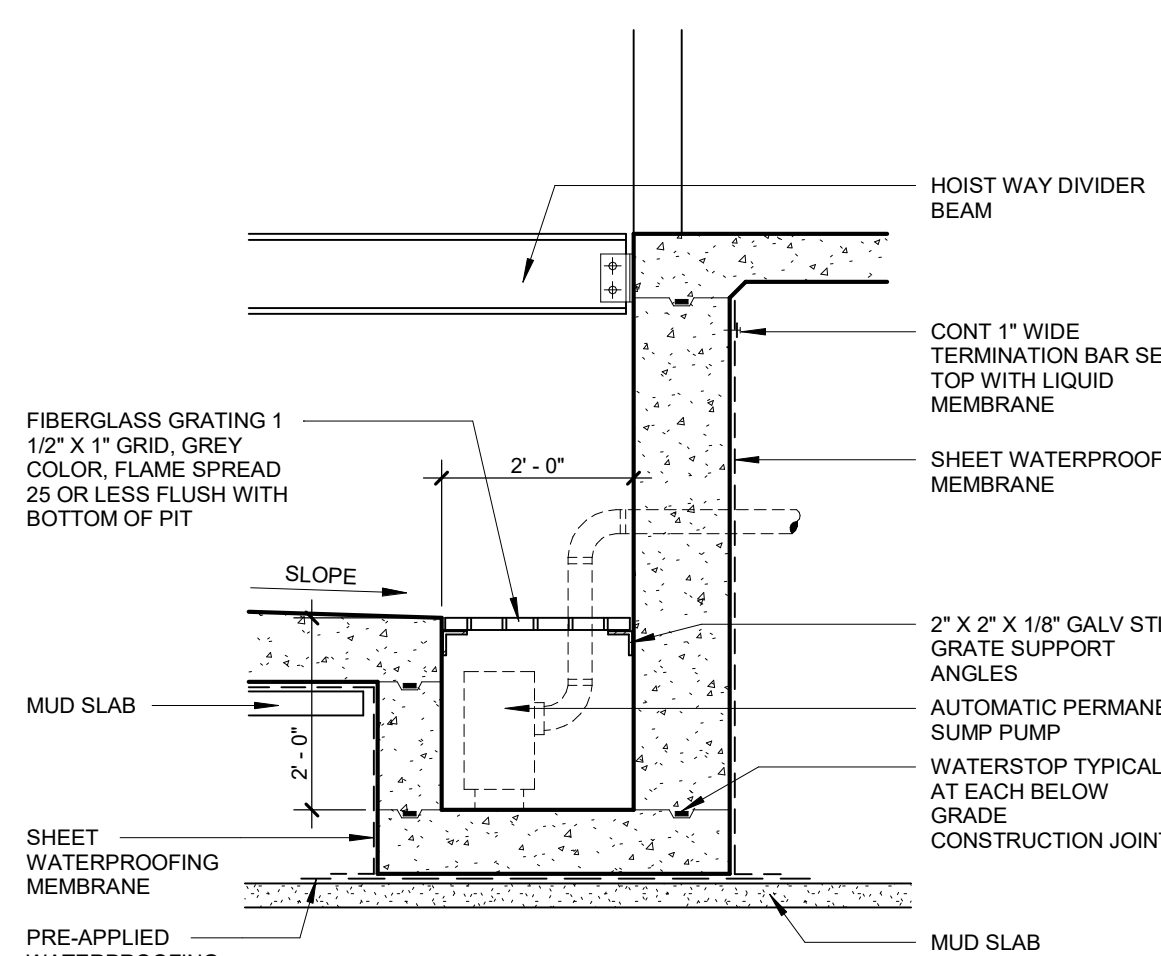


PIT SECTION AT SUMP WITH POSITIVE SIDE WATERPROOFING
1/2\"/>

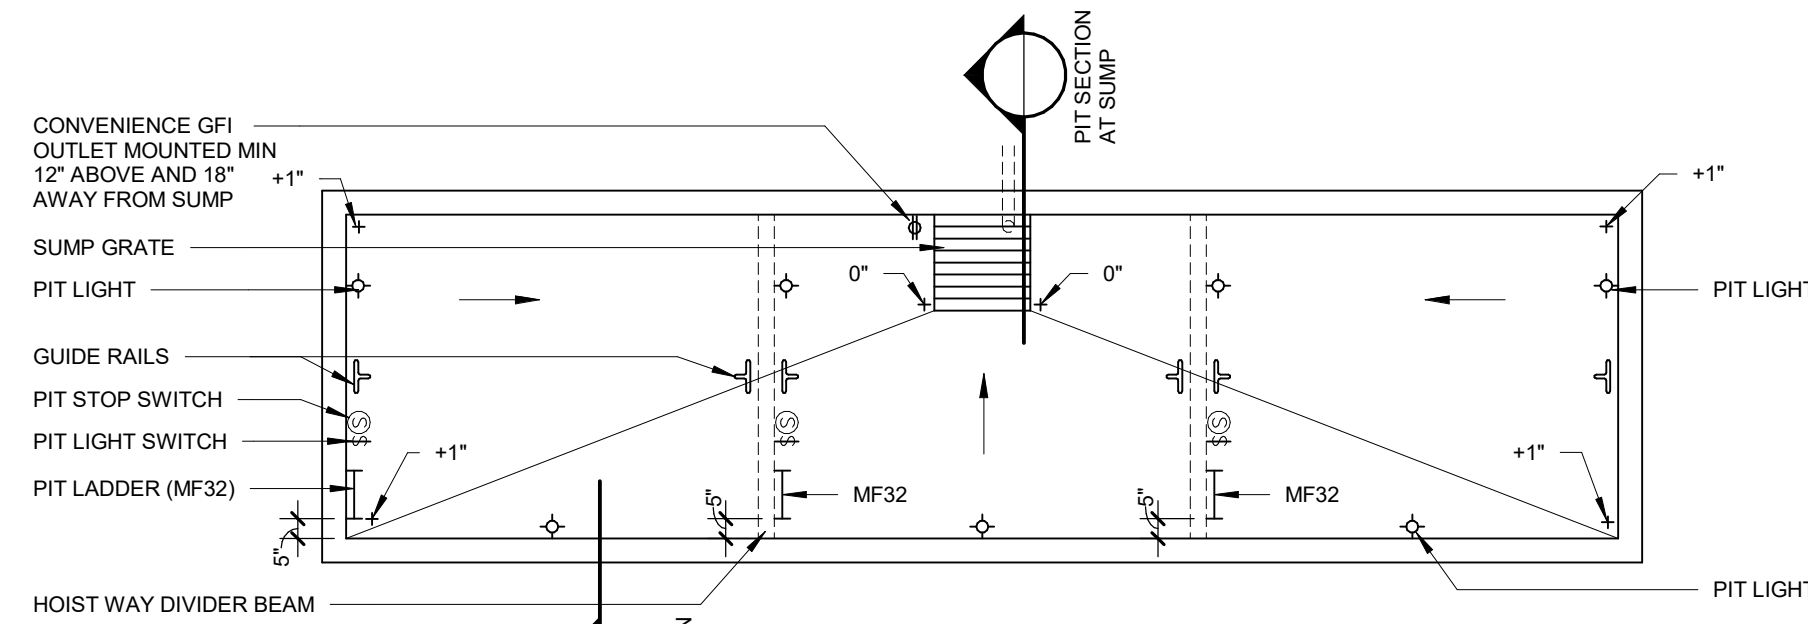

ELEVATOR PIT PLAN (TYPICAL 3 CAB)
1/4\"/>

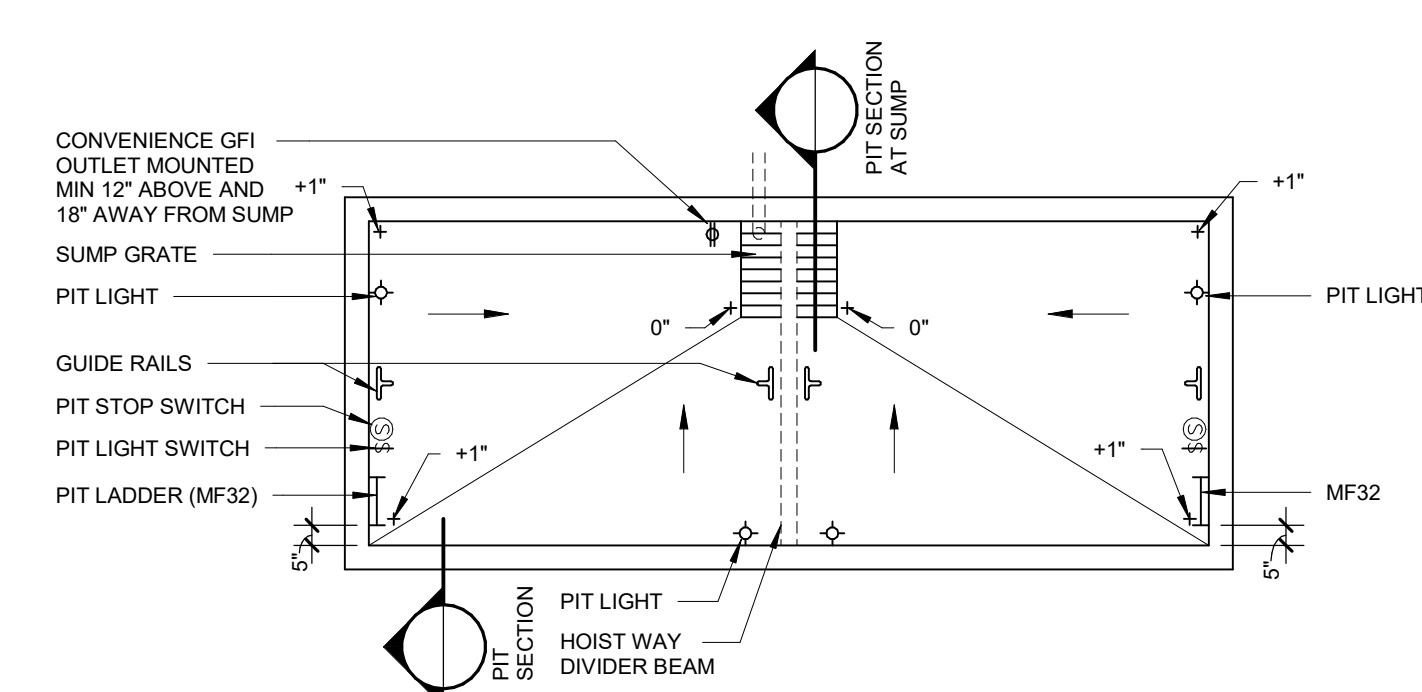


ELEVATOR PIT PLAN (TYPICAL 2 CAB)
1/4\"/>

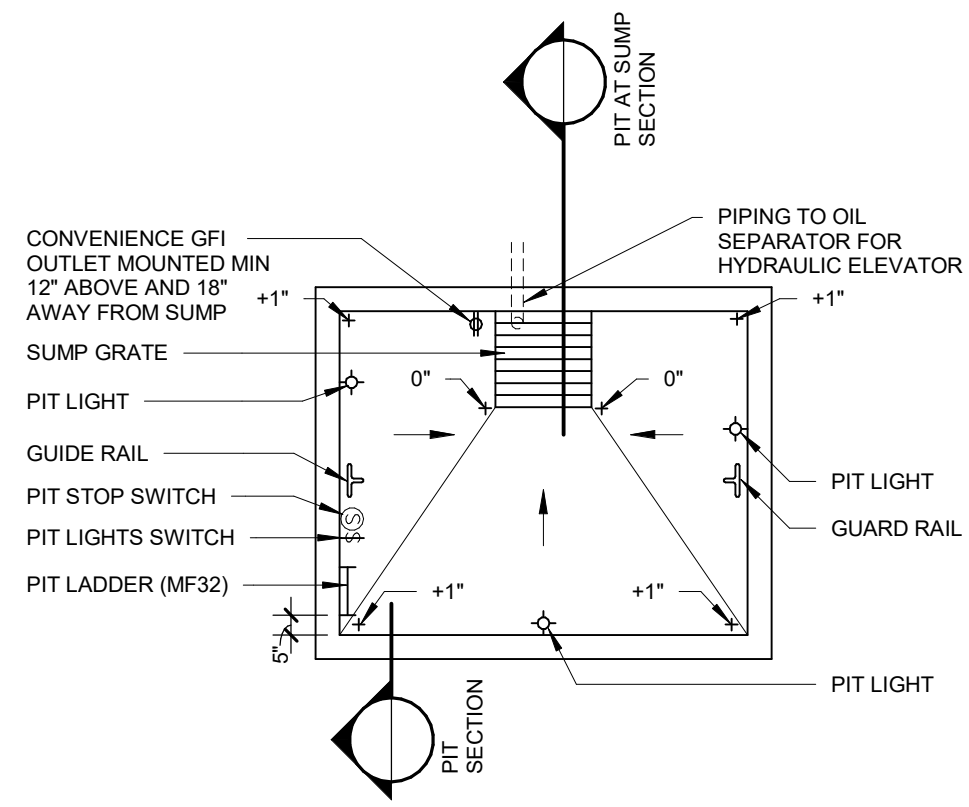

ELEVATOR PIT PLAN (TYPICAL 1 CAB)
1/4\"/>

PROFESSIONAL SEAL:

CONSULTANT LOGO

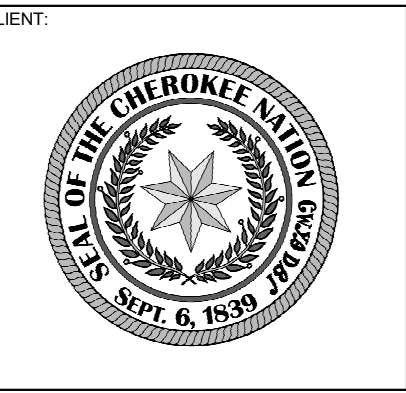

**CHEROKEE NATION
REPLACEMENT HOSPITAL**
TAHLEQUAH, OKLAHOMA

KEY PLAN:

PROJECT PHASE:
BID PACKAGE 03
(ELEVATORS)

#	DATE	REVISIONS	DESCRIPTION

JOB NUMBER: 21-08.21
DATE: 10-07-2022
SHEET NUMBER: **A4.23**
SHEET TITLE: ELEVATOR DETAILS