

X:\Egryte\SharedResources\Title Sheets and Logos\Cherokee Nation.jpg

CHEROKEE NATION VIAN HOUSING

SHEET INDEX

	COVER SHEET
S101	FOUNDATION PLAN
A101	FLOOR PLAN PLAN
A102	POWER PLAN AND ROOF PLAN
A201	ELEVATIONS
A301	SECTIONS
A401	INTERIOR ELEVATIONS

PLAN

<input type="checkbox"/>	1	
<input type="checkbox"/>	2	
<input type="checkbox"/>	3	
<input type="checkbox"/>	4	HC
<input checked="" type="checkbox"/>	5	



10035 N. 177TH EAST AVE.
OWASSO, OK 74055-7841
918-798-5979
joe@bbk.com

3600 SUNVALLEY DR.
NORMAN, OK 73026-0632
405-821-2137
egb@bbk.com

BBK/A&E, P.L.L.C. Oklahoma
C.A. No. 02409 (Arch), EXPIRES 06.30.2016



CONSULTANTS:

**MIRRORED FOR
CONSTRUCTION
03.01.2016**

THESE DRAWINGS ARE THE PROPERTY OF ED G. BISHOP ARCHITECT AIA AND BBK/A&E P.L.L.C. UNAUTHORIZED REPRODUCTION FOR ANY PURPOSE IS AN INFRINGEMENT UPON COPYRIGHT LAWS. VIOLATORS WILL BE SUBJECT TO PROSECUTION TO THE FULLEST EXTENT OF THE LAW.

WRITTEN DIMENSIONS ON THESE DRAWINGS SHALL HAVE PRECEDENCE OVER SCALE DIMENSIONS. CONTRACTORS SHALL VERIFY AND BE RESPONSIBLE FOR ALL DIMENSIONS AND CONDITIONS ON THE JOB AND THIS OFFICE MUST BE NOTIFIED OF ANY VARIATION FROM THE DIMENSIONS AND CONDITIONS SHOWN BY THESE DRAWINGS. NO CHANGE ORDERS SHALL BE ISSUED FOR CHANGES REQUIRED IN THE FIELD AFTER CONSTRUCTION HAS COMMENCED UNLESS SPECIFICALLY AUTHORIZED BY THE OWNER. ©2015 BBK/A&E

REVISIONS:	DATE:
▲	
▲	
▲	
▲	
▲	

RELEASED FOR:	DATE:
<input type="checkbox"/> PRELIMINARY ONLY	
<input type="checkbox"/> BIDDING	
<input type="checkbox"/> PERMITS	
<input checked="" type="checkbox"/> CONSTRUCTION	XX.XX.XX

PROJECT NO: CHEROKEE HOUSING
CAD DWG FILE:
DRAWN BY: rmv
CHECKED BY: egb



**CHEROKEE
HOUSING**
VIAN, OK

COVER SHEET

G001M

SHEET NO. 00 of 00



10035 N. 177TH EAST AVE.
OWASSO, OK 74055-7841
918-798-5979
joe@bbkare.com

3600 SUNVALLEY DR.
NORMAN, OK 73026-0632
405-821-2137
egh@bbkare.com

BBK/A&E, P.L.L.C. Oklahoma
C.A. No. 02409 (Arch), EXPIRES 06.30.2016



CONSULTANTS:

**MIRRORED FOR
CONSTRUCTION
03.01.2016**

THESE DRAWINGS ARE THE PROPERTY OF ED G. BISHOP, ARCHITECT AIA AND BBK/A&E P.L.L.C. UNAUTHORIZED REPRODUCTION FOR ANY PURPOSE IS AN INFRINGEMENT UPON COPYRIGHT LAWS. VIOLATORS WILL BE SUBJECT TO PROSECUTION TO THE FULLEST EXTENT OF THE LAW.
WRITTEN DIMENSIONS ON THESE DRAWINGS SHALL HAVE PRECEDENCE OVER SCALE DIMENSIONS. CONTRACTORS SHALL VERIFY AND BE RESPONSIBLE FOR ALL DIMENSIONS AND CONDITIONS ON THE JOB AND THIS OFFICE MUST BE NOTIFIED OF ANY VARIATION FROM THE DIMENSIONS AND CONDITIONS SHOWN BY THESE DRAWINGS. NO CHANGE ORDERS WILL BE ISSUED FOR CHANGES REQUESTED IN THE FIELD AFTER CONSTRUCTION HAS COMMENCED UNLESS SPECIFICALLY AUTHORIZED BY THE OWNER. ©2015 BBK/A&E

REVISIONS:	DATE:
△	.
△	.
△	.
△	.
△	.

RELEASED FOR:	DATE:
<input type="checkbox"/> PRELIMINARY ONLY	.
<input type="checkbox"/> BIDDING	.
<input type="checkbox"/> PERMITS	.
<input checked="" type="checkbox"/> CONSTRUCTION	XXXXXXXX

PROJECT NO: CHEROKEE HOUSING
CAD DWG FILE:
DRAWN BY: mvv
CHECKED BY: egh




**CHEROKEE
HOUSING**
VIAN, OK

HOUSE 5M
FOUNDATION
PLAN

S101M

SHEET NO. - - -

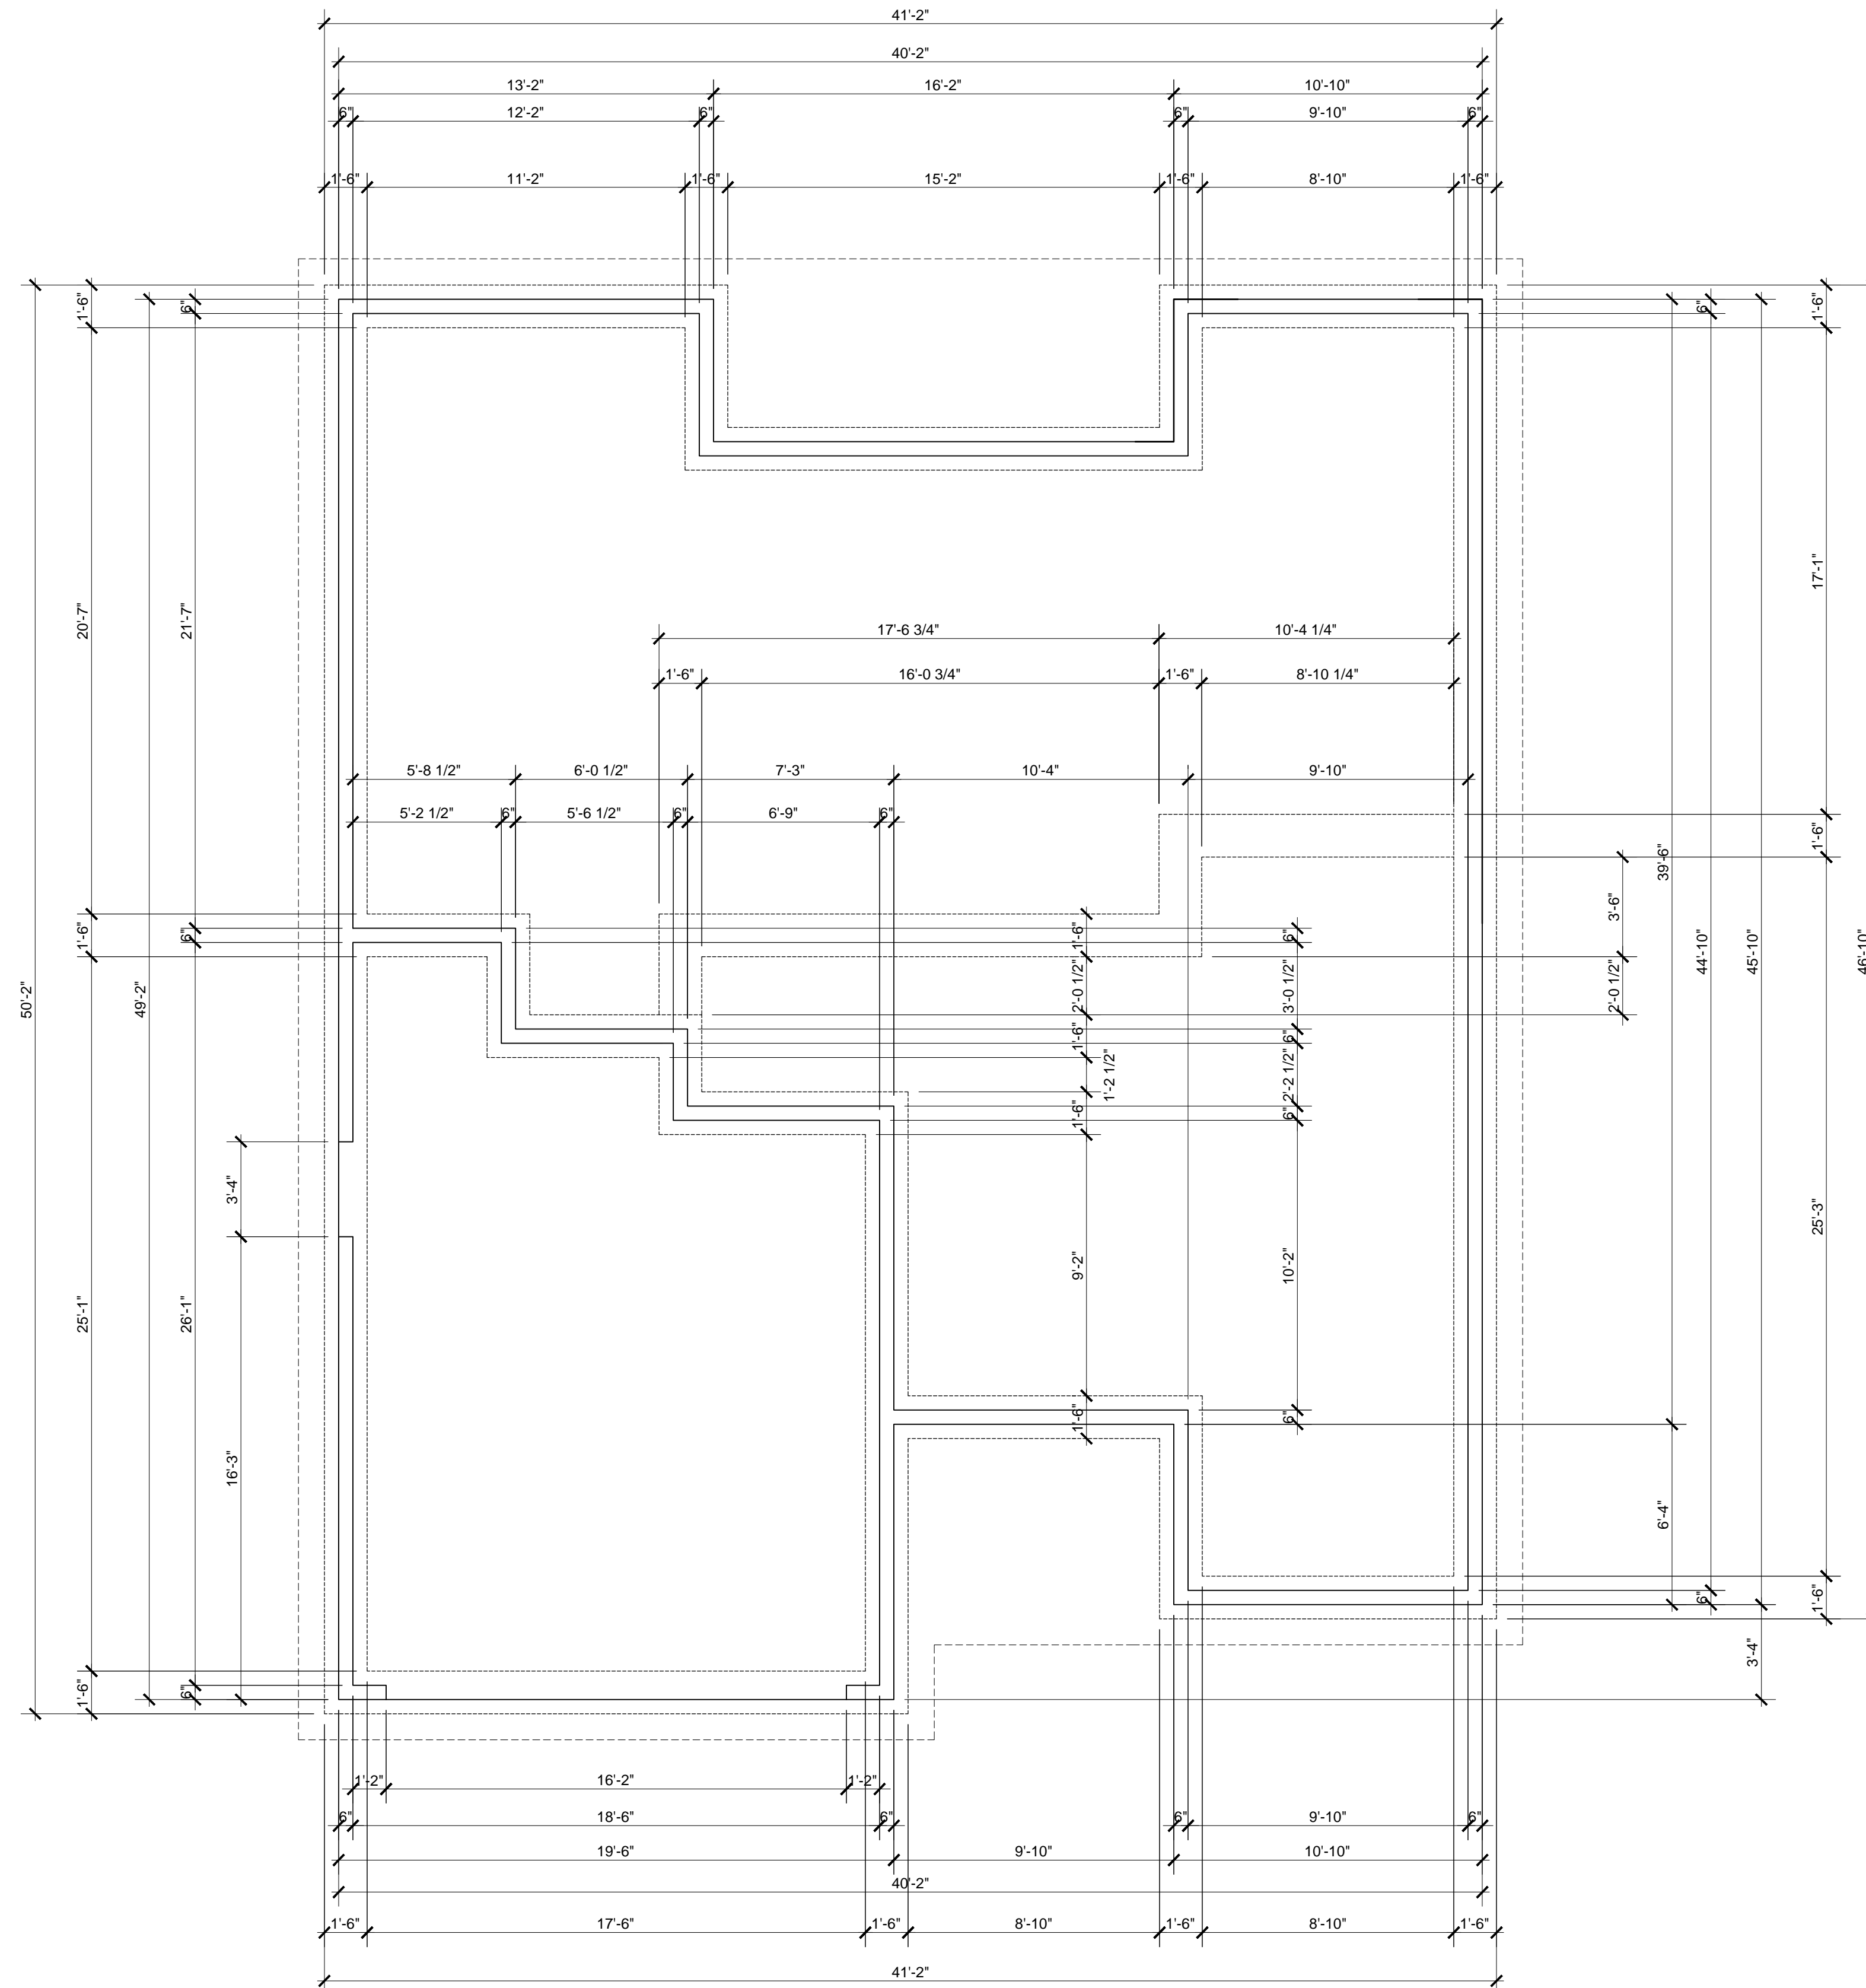

1 HOUSE 5M - FOUNDATION PLAN
SCALE: 1/4"=1'-0"



10035 N. 177TH EAST AVE.
OWASSO, OK 74055-7841
918-798-5979
joe@bbkare.com

3600 SUNVALLEY DR.
NORMAN, OK 73026-0632
405-821-2137
egh@bbkare.com

BBK/A&E, P.L.L.C. Oklahoma
C.A. No. 02409 (Arch), EXPIRES 06.30.2016



CONSULTANTS:

**MIRRORED FOR
CONSTRUCTION
03.01.2016**

THESE DRAWINGS ARE THE PROPERTY OF ED G. BISHOP, ARCHITECT AIA. ANY REPRODUCTION OR TRANSMISSION OF THESE DRAWINGS WITHOUT THE WRITTEN PERMISSION OF ED G. BISHOP, ARCHITECT AIA IS AN INFRINGEMENT OF COPYRIGHT LAWS. VIOLATORS WILL BE SUBJECT TO PROSECUTION TO THE FULLEST EXTENT OF THE LAW.

WRITTEN DIMENSIONS ON THESE DRAWINGS SHALL HAVE PRECEDENCE OVER SCALE DIMENSIONS. CONTRACTORS SHALL VERIFY AND BE RESPONSIBLE FOR ALL DIMENSIONS AND CONDITIONS ON THE JOB AND THIS OFFICE MUST BE NOTIFIED OF ANY VARIATION FROM THE DIMENSIONS AND CONDITIONS SHOWN BY THESE DRAWINGS. NO CHANGE ORDERS WILL BE ISSUED OR CHANGES INCURRED IN THE FIELD AFTER CONSTRUCTION HAS COMMENCED UNLESS SPECIFICALLY AUTHORIZED BY THE OWNER. ©2015 BBK/A&E.

REVISIONS:	DATE:
△	.
△	.
△	.
△	.
△	.

RELEASED FOR:	DATE:
<input type="checkbox"/> PRELIMINARY ONLY	.
<input type="checkbox"/> BIDDING	.
<input type="checkbox"/> PERMITS	.
<input checked="" type="checkbox"/> CONSTRUCTION	XXXXXXXX

PROJECT NO: CHEROKEE HOUSING
CAD DWG FILE:
DRAWN BY: miv
CHECKED BY: egh




**CHEROKEE
HOUSING**
VIAN, OK

HOUSE 5M

FLOOR PLAN

A101M


SHEET NO: - / -

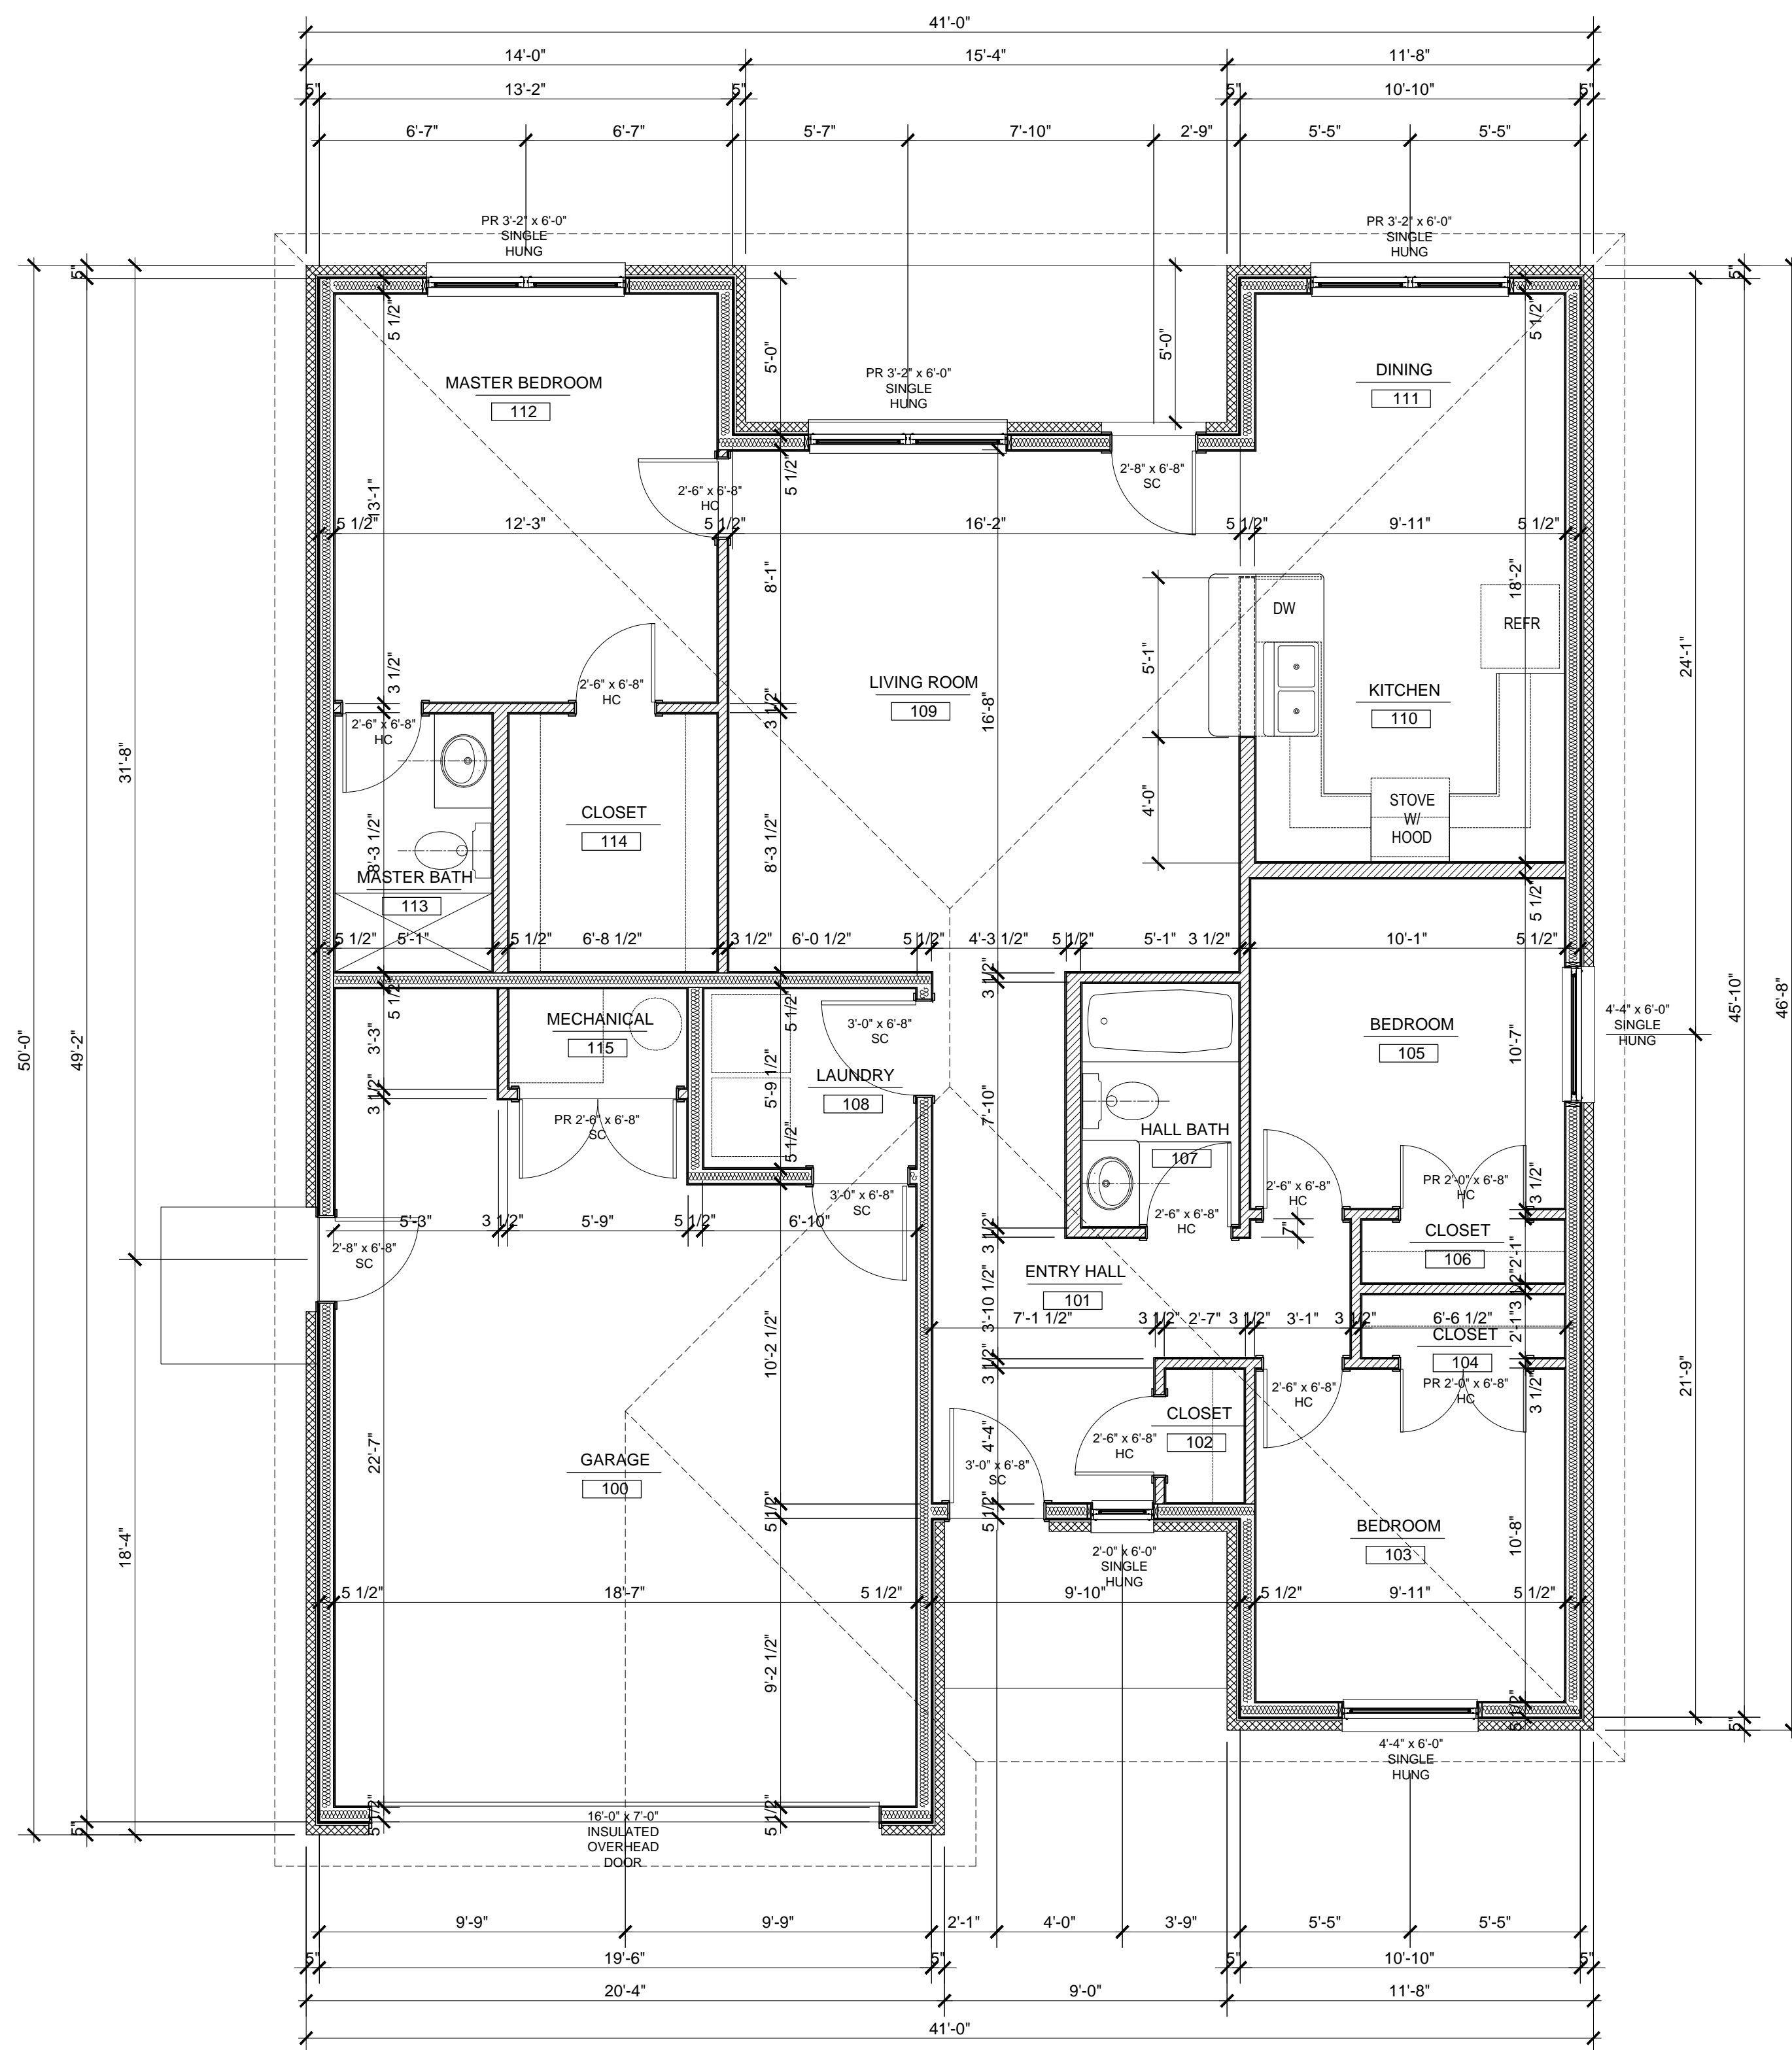

CONDITIONED SPACE = 1230sf


1 HOUSE 5M - FLOOR PLAN

SCALE: 1/4"=1'-0"

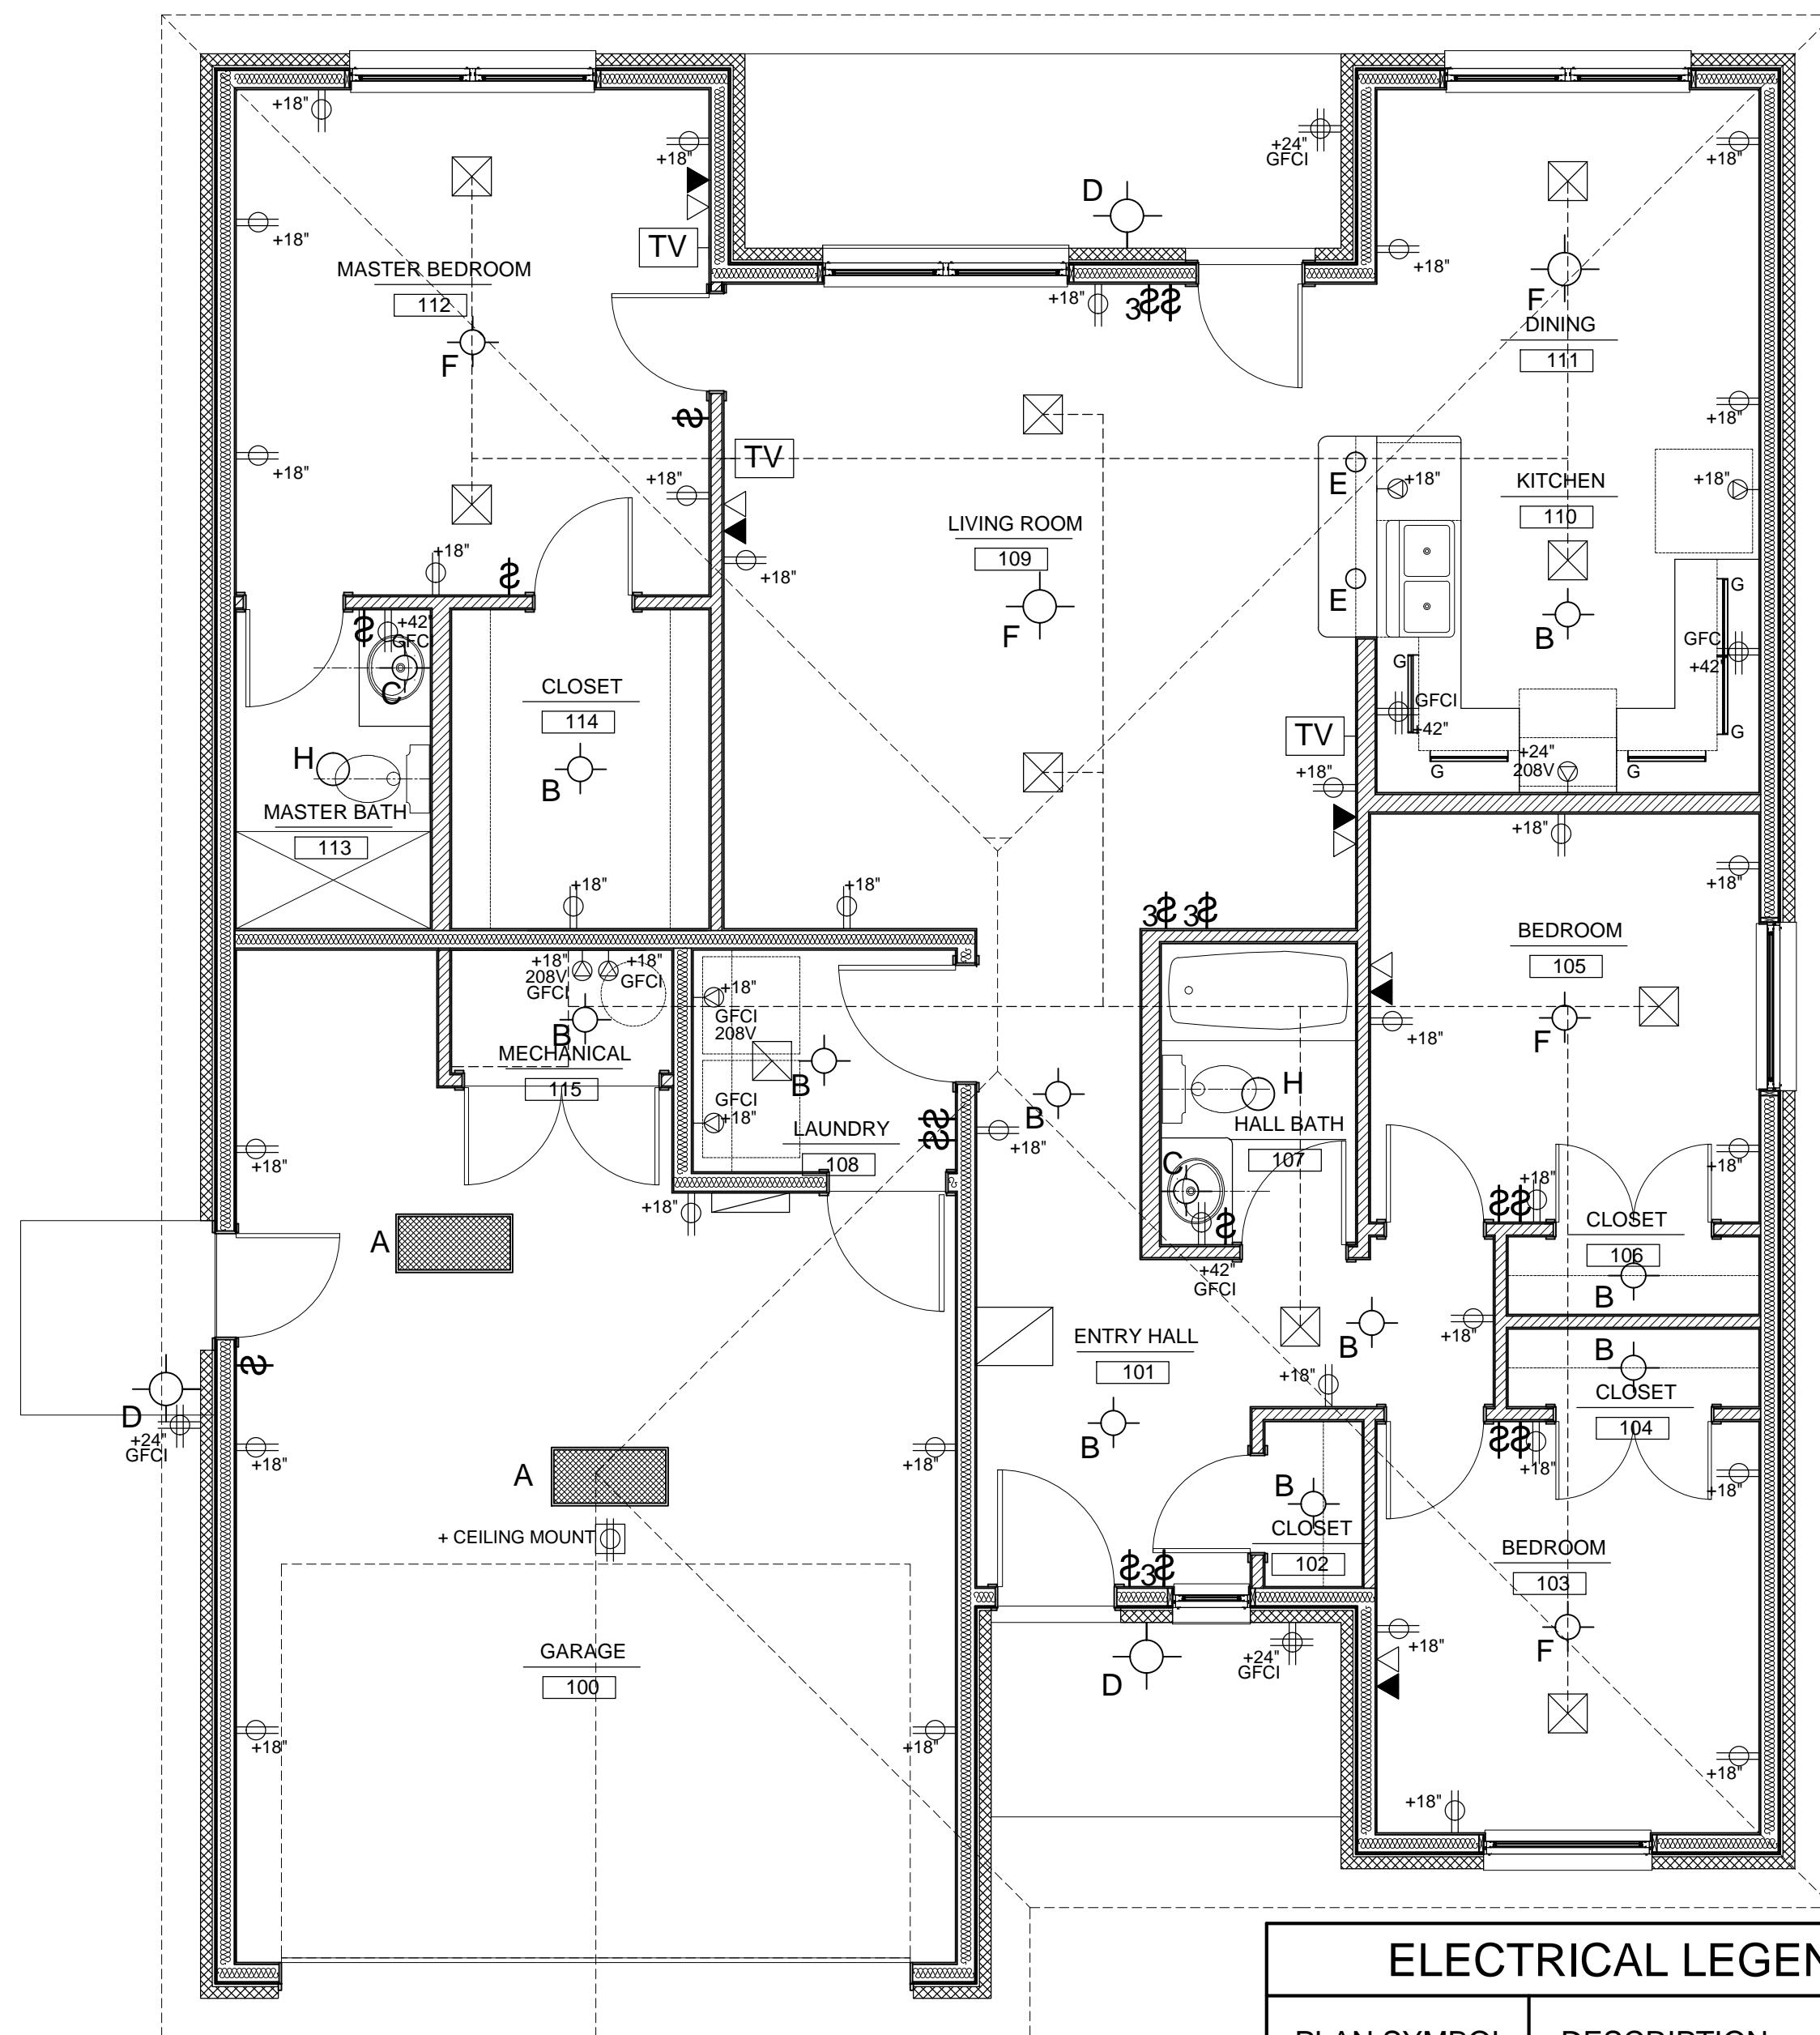

1 HOUSE 5M - ELECTRICAL PLAN
SCALE: 1/4"=1'-0"

PLAN SYMBOL	DESCRIPTION
A	2X4 FLUORESCENT LIGHT SURFACE MOUNT
B	SURFACE MOUNT FIXTURE
C	WALL-MOUNT VANITY FIXTURE
D	WALL-MOUNT EXTERIOR LIGHT
E	LED PENDANT FIXTURE
F	PENDANT-MOUNT FIXTURE (W/ FAN J-BOX)
G	2' STRIP FLUORESCENT FIXTURE MOUNT UNDER UPPER CABINETS
H	COMBO LIGHT/HEATER/FAN UNIT
[Symbol]	ELECTRICAL PANEL - SURFACE MOUNT
⊕ +?	DUPLEX RECEPTACLE OUTLET +? = HEIGHT FROM FINISHED FLOOR
⊕ +?	QUAD RECEPTACLE OUTLET +? = HEIGHT FROM FINISHED FLOOR
⊕	RECEPTACLE OUTLET
⊕ GFI	GROUND FAULT INTERRUPTER
⊕ ?V	SPECIAL-PURPOSE OUTLET - RATING AS INDICATED
\$	LIGHT SWITCH
\$ ₃	3-WAY LIGHT SWITCH
▼	PHONE
▽	DATA PORT
[TV]	CABLE/SATELLITE
[Symbol]	RETURN REGISTER - SIZE TBD
[Symbol]	12" X 12" SUPPLY REGISTER
[Symbol]	EXHAUST FAN

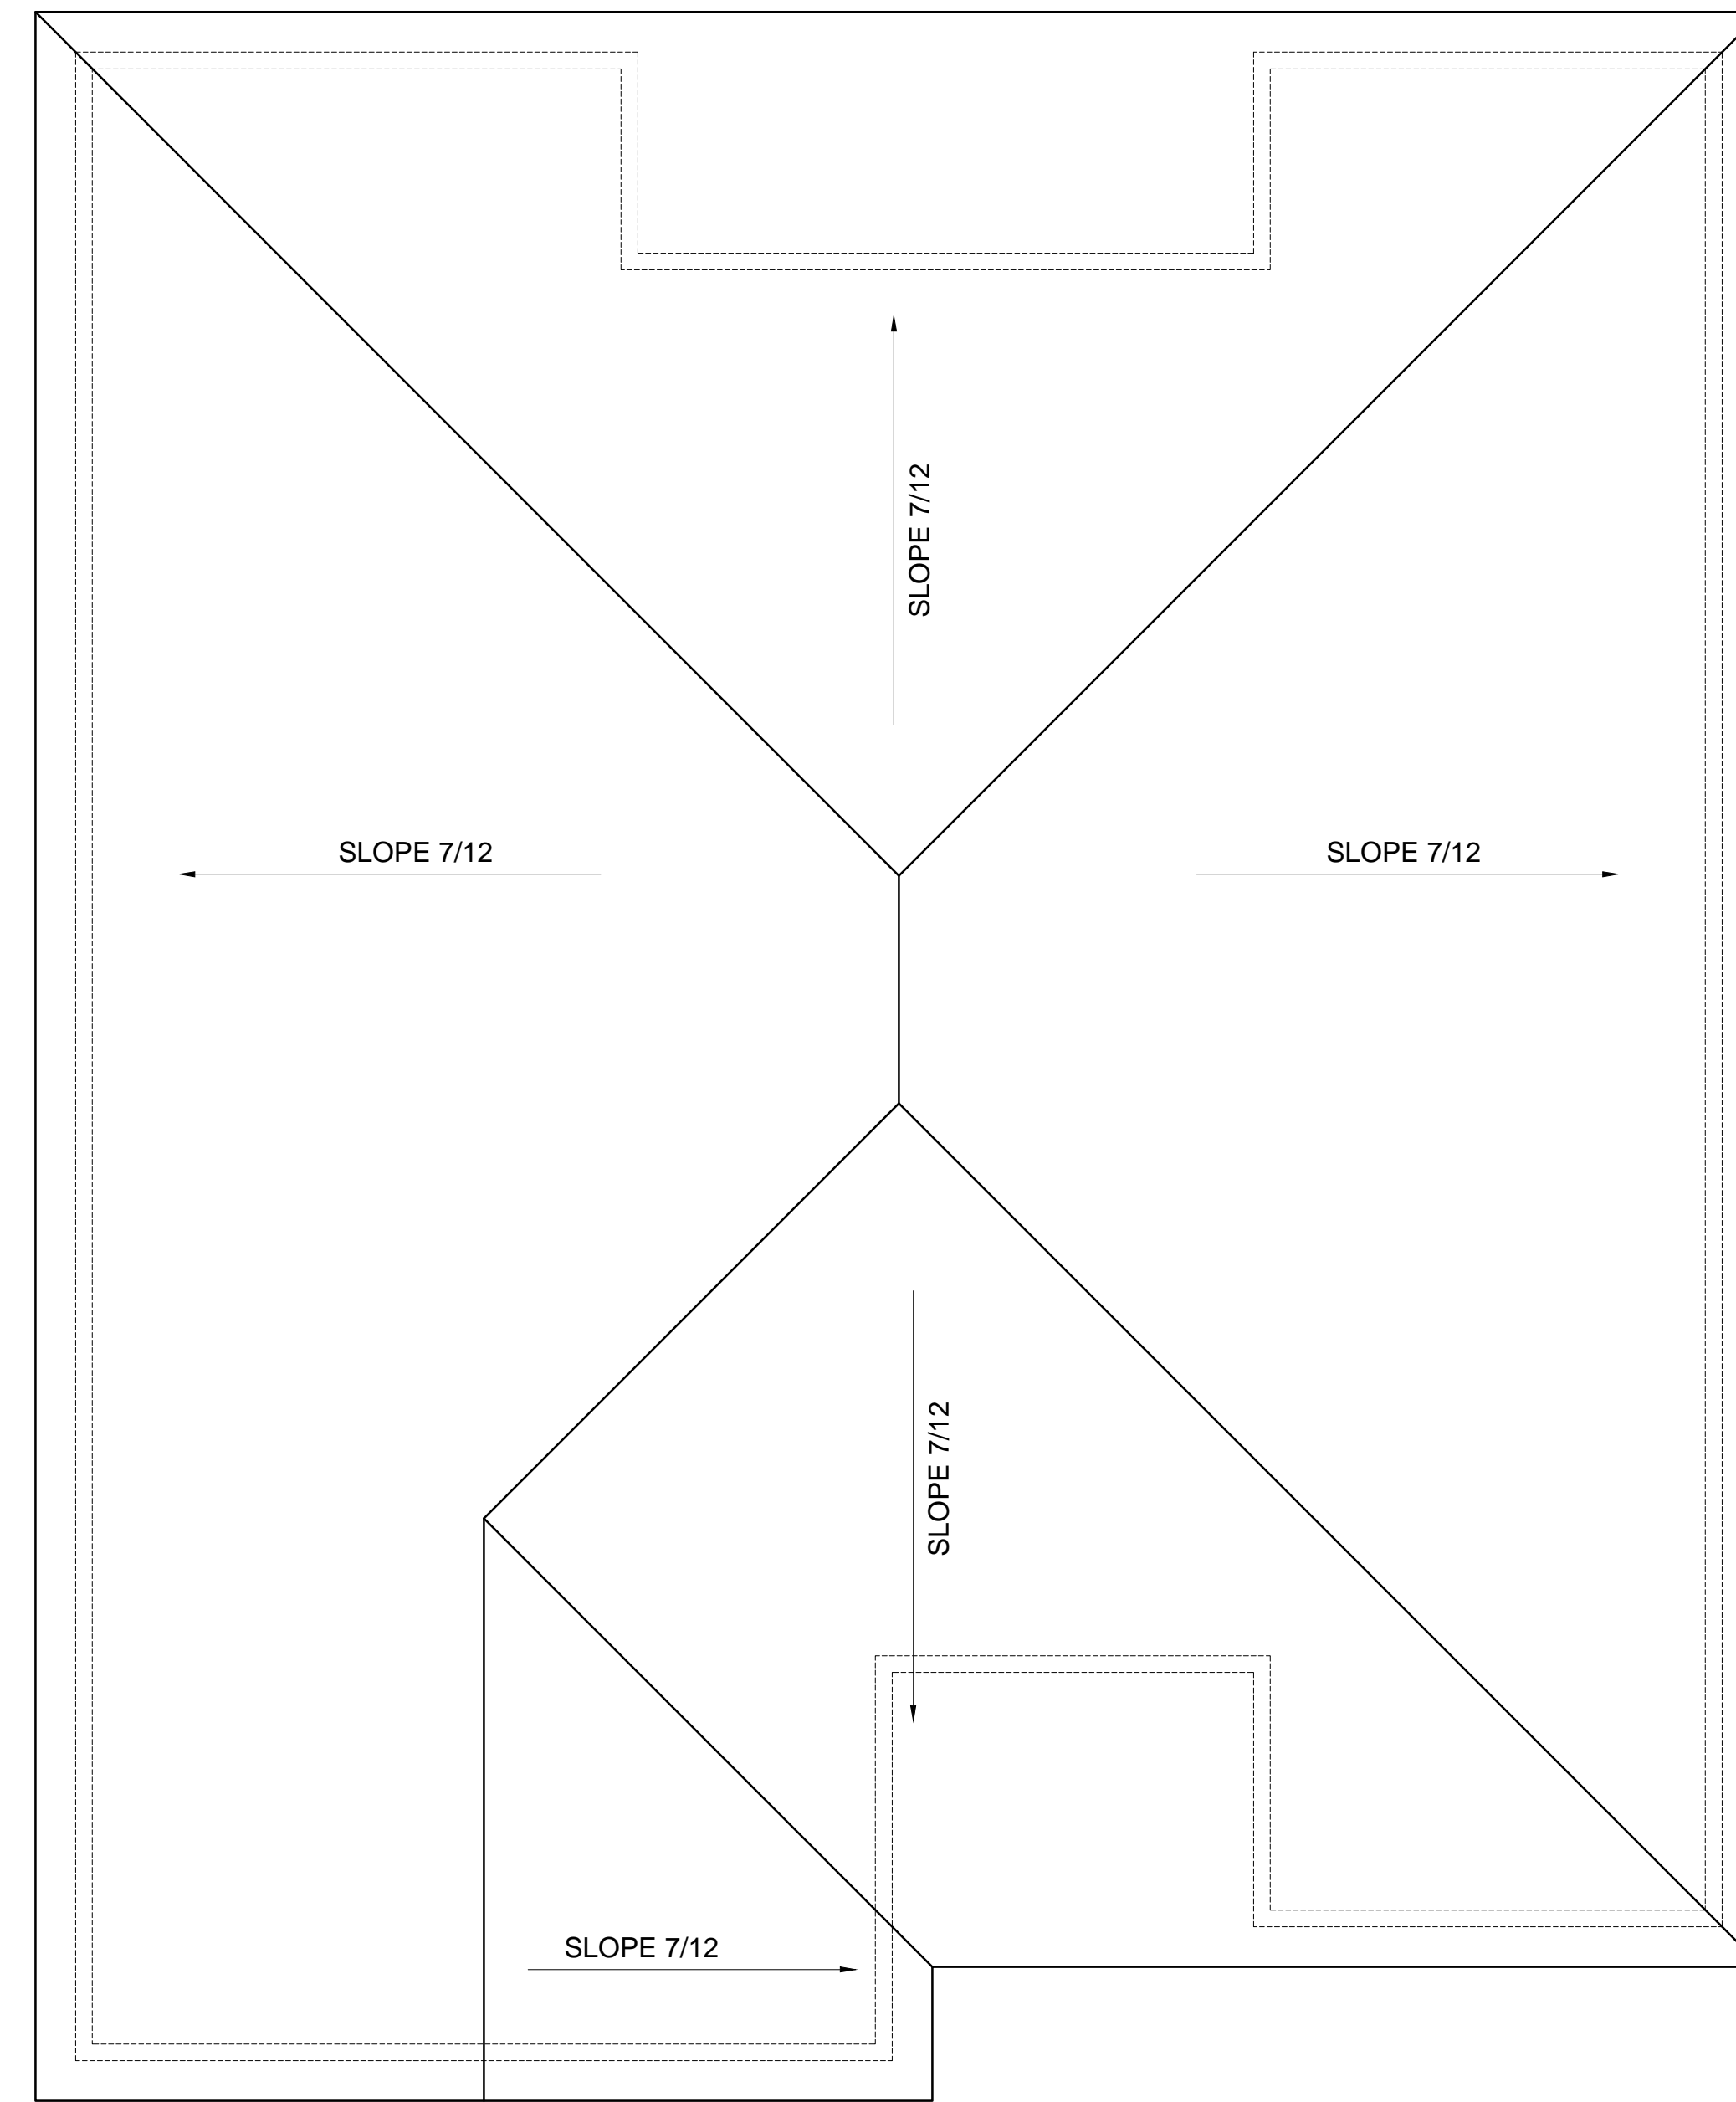

2 HOUSE 5M - ROOF PLAN
SCALE: 1/4"=1'-0"



10035 N. 177TH EAST AVE.
OWASSO, OK 74055-7841
918-798-5979
joe@bbkare.com

3600 SUNVALLEY DR.
NORMAN, OK 73026-0632
405-821-2137
egh@bbkare.com

BBK/A&E, P.L.L.C. Oklahoma
C.A. No. 02409 (Arch), EXPIRES 06.30.2016



CONSULTANTS:

MIRRORED FOR CONSTRUCTION
03.01.2016

THESE DRAWINGS ARE THE PROPERTY OF ED-G. BISHOP, ARCHITECT AIA. ANY REPRODUCTION OR UNAUTHORIZED DISTRIBUTION OF THESE DRAWINGS IS AN INFRINGEMENT UPON COPYRIGHT LAWS. VIOLATORS WILL BE SUBJECT TO PROSECUTION TO THE FULLEST EXTENT OF THE LAW.

WRITTEN DIMENSIONS ON THESE DRAWINGS SHALL HAVE PRECEDENCE OVER SCALE DIMENSIONS. CONTRACTORS SHALL VERIFY AND BE RESPONSIBLE FOR ALL DIMENSIONS AND CONDITIONS ON THE JOB AND THIS OFFICE MUST BE NOTIFIED OF ANY VARIATION FROM THE DIMENSIONS AND CONDITIONS SHOWN BY THESE DRAWINGS. NO CHANGE ORDERS WILL BE ISSUED OR CHANGES INCURRED IN THE FIELD AFTER CONSTRUCTION HAS COMMENCED UNLESS SPECIFICALLY AUTHORIZED BY THE OWNER. ©2015 BBK/A&E.

REVISIONS:	DATE:
△	.
△	.
△	.
△	.
△	.
△	.

RELEASED FOR:	DATE:
<input type="checkbox"/> PRELIMINARY ONLY	.
<input type="checkbox"/> BIDDING	.
<input type="checkbox"/> PERMITS	.
<input checked="" type="checkbox"/> CONSTRUCTION	XXXXXX

PROJECT NO: CHEROKEE HOUSING
CAD DWG FILE:
DRAWN BY: mrv
CHECKED BY: egh




CHEROKEE HOUSING
VIAN, OK


HOUSE 5M
ELECTRICAL PLAN
ROOF PLAN

A102M


SHEET NO. - - -

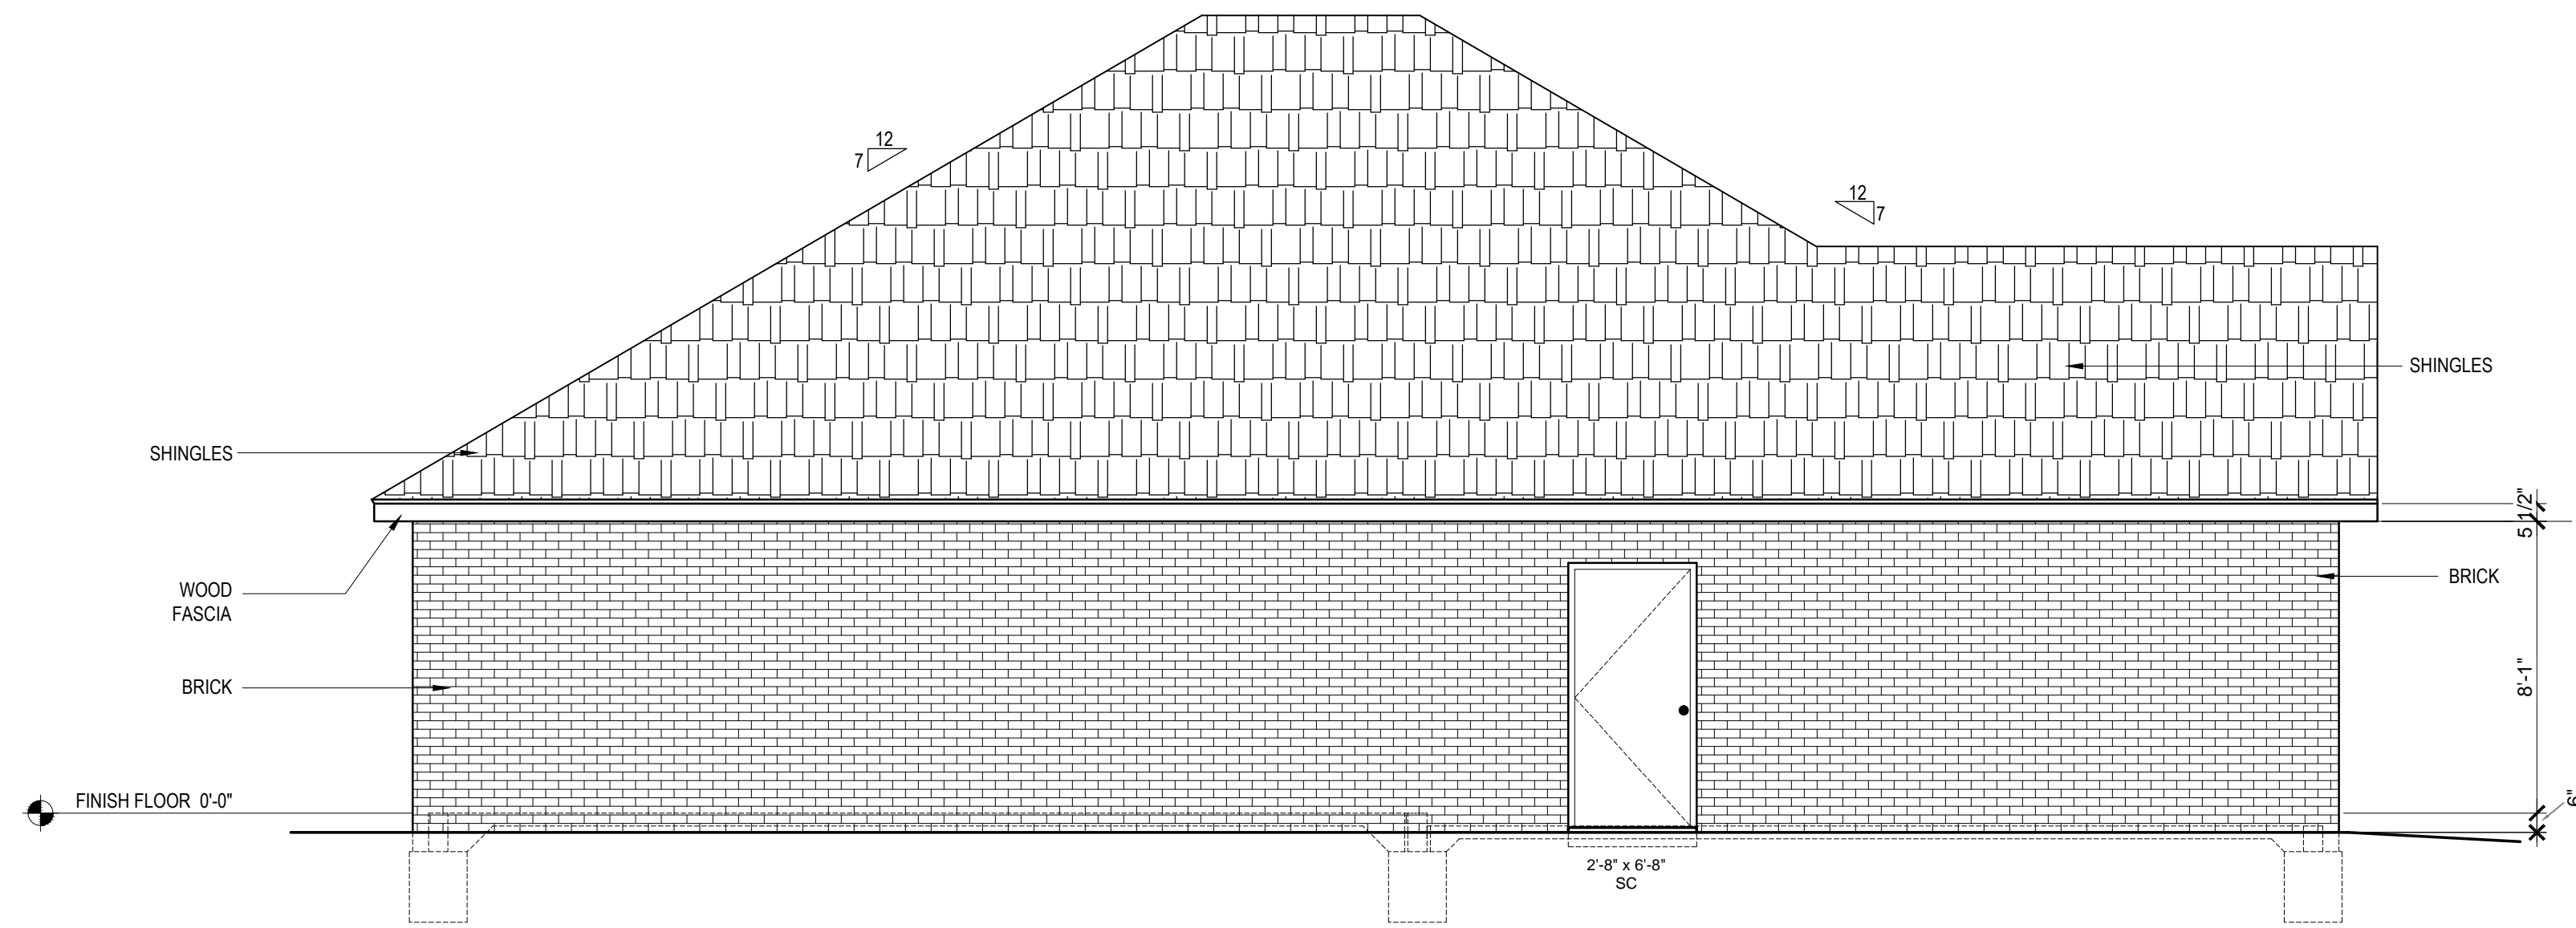


1 HOUSE 5M - SIDE ELEVATION
SCALE: 1/4"=1'-0"

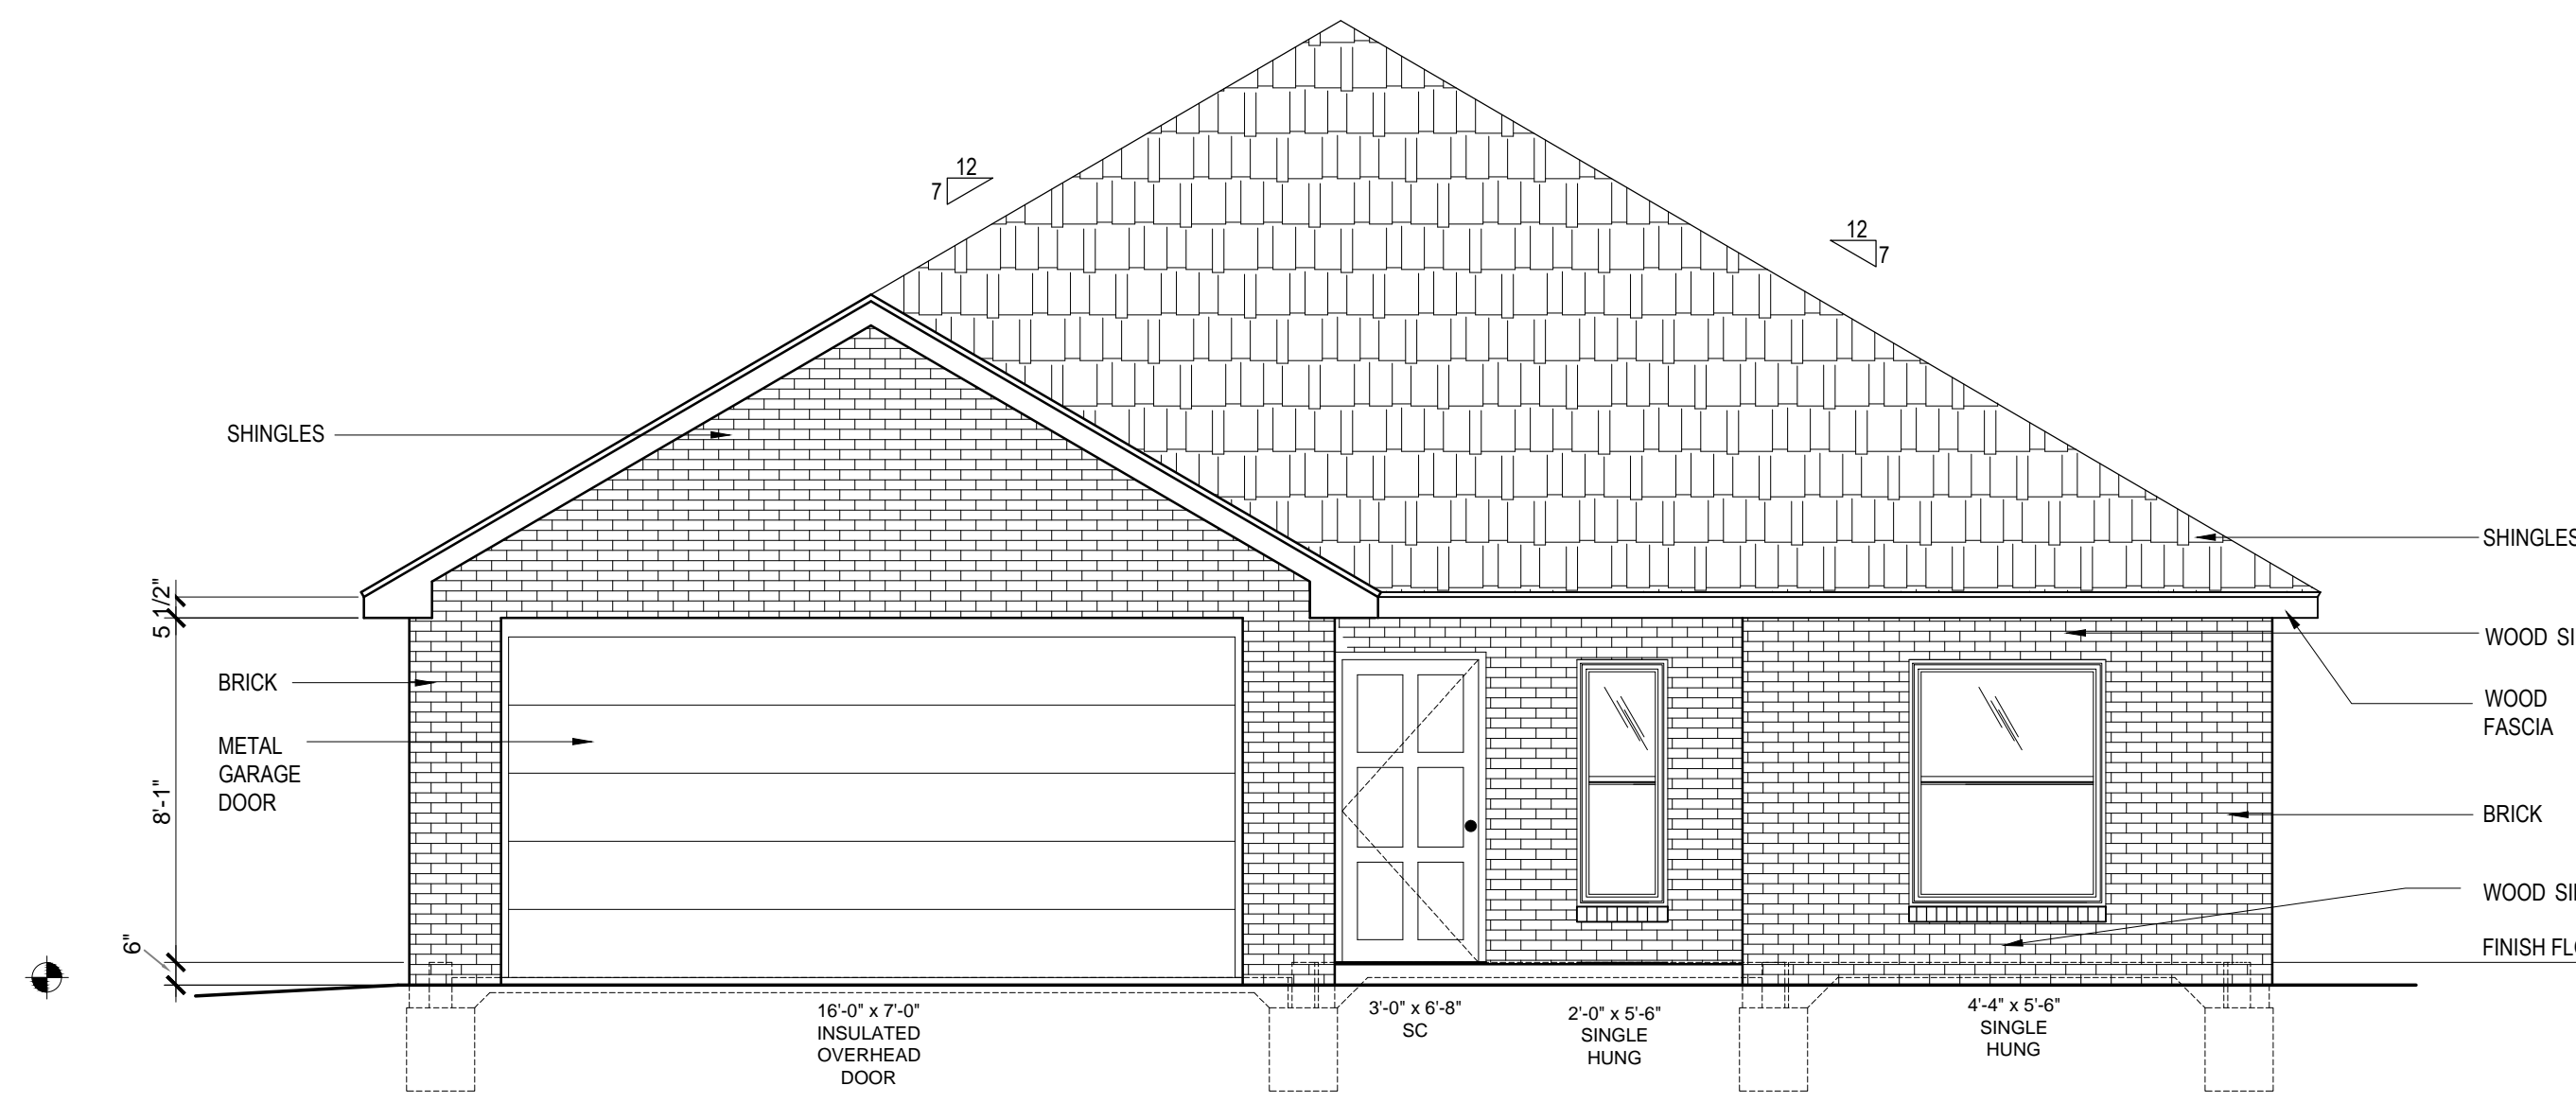

2 HOUSE 5M - FRONT ELEVATION
SCALE: 1/4"=1'-0"

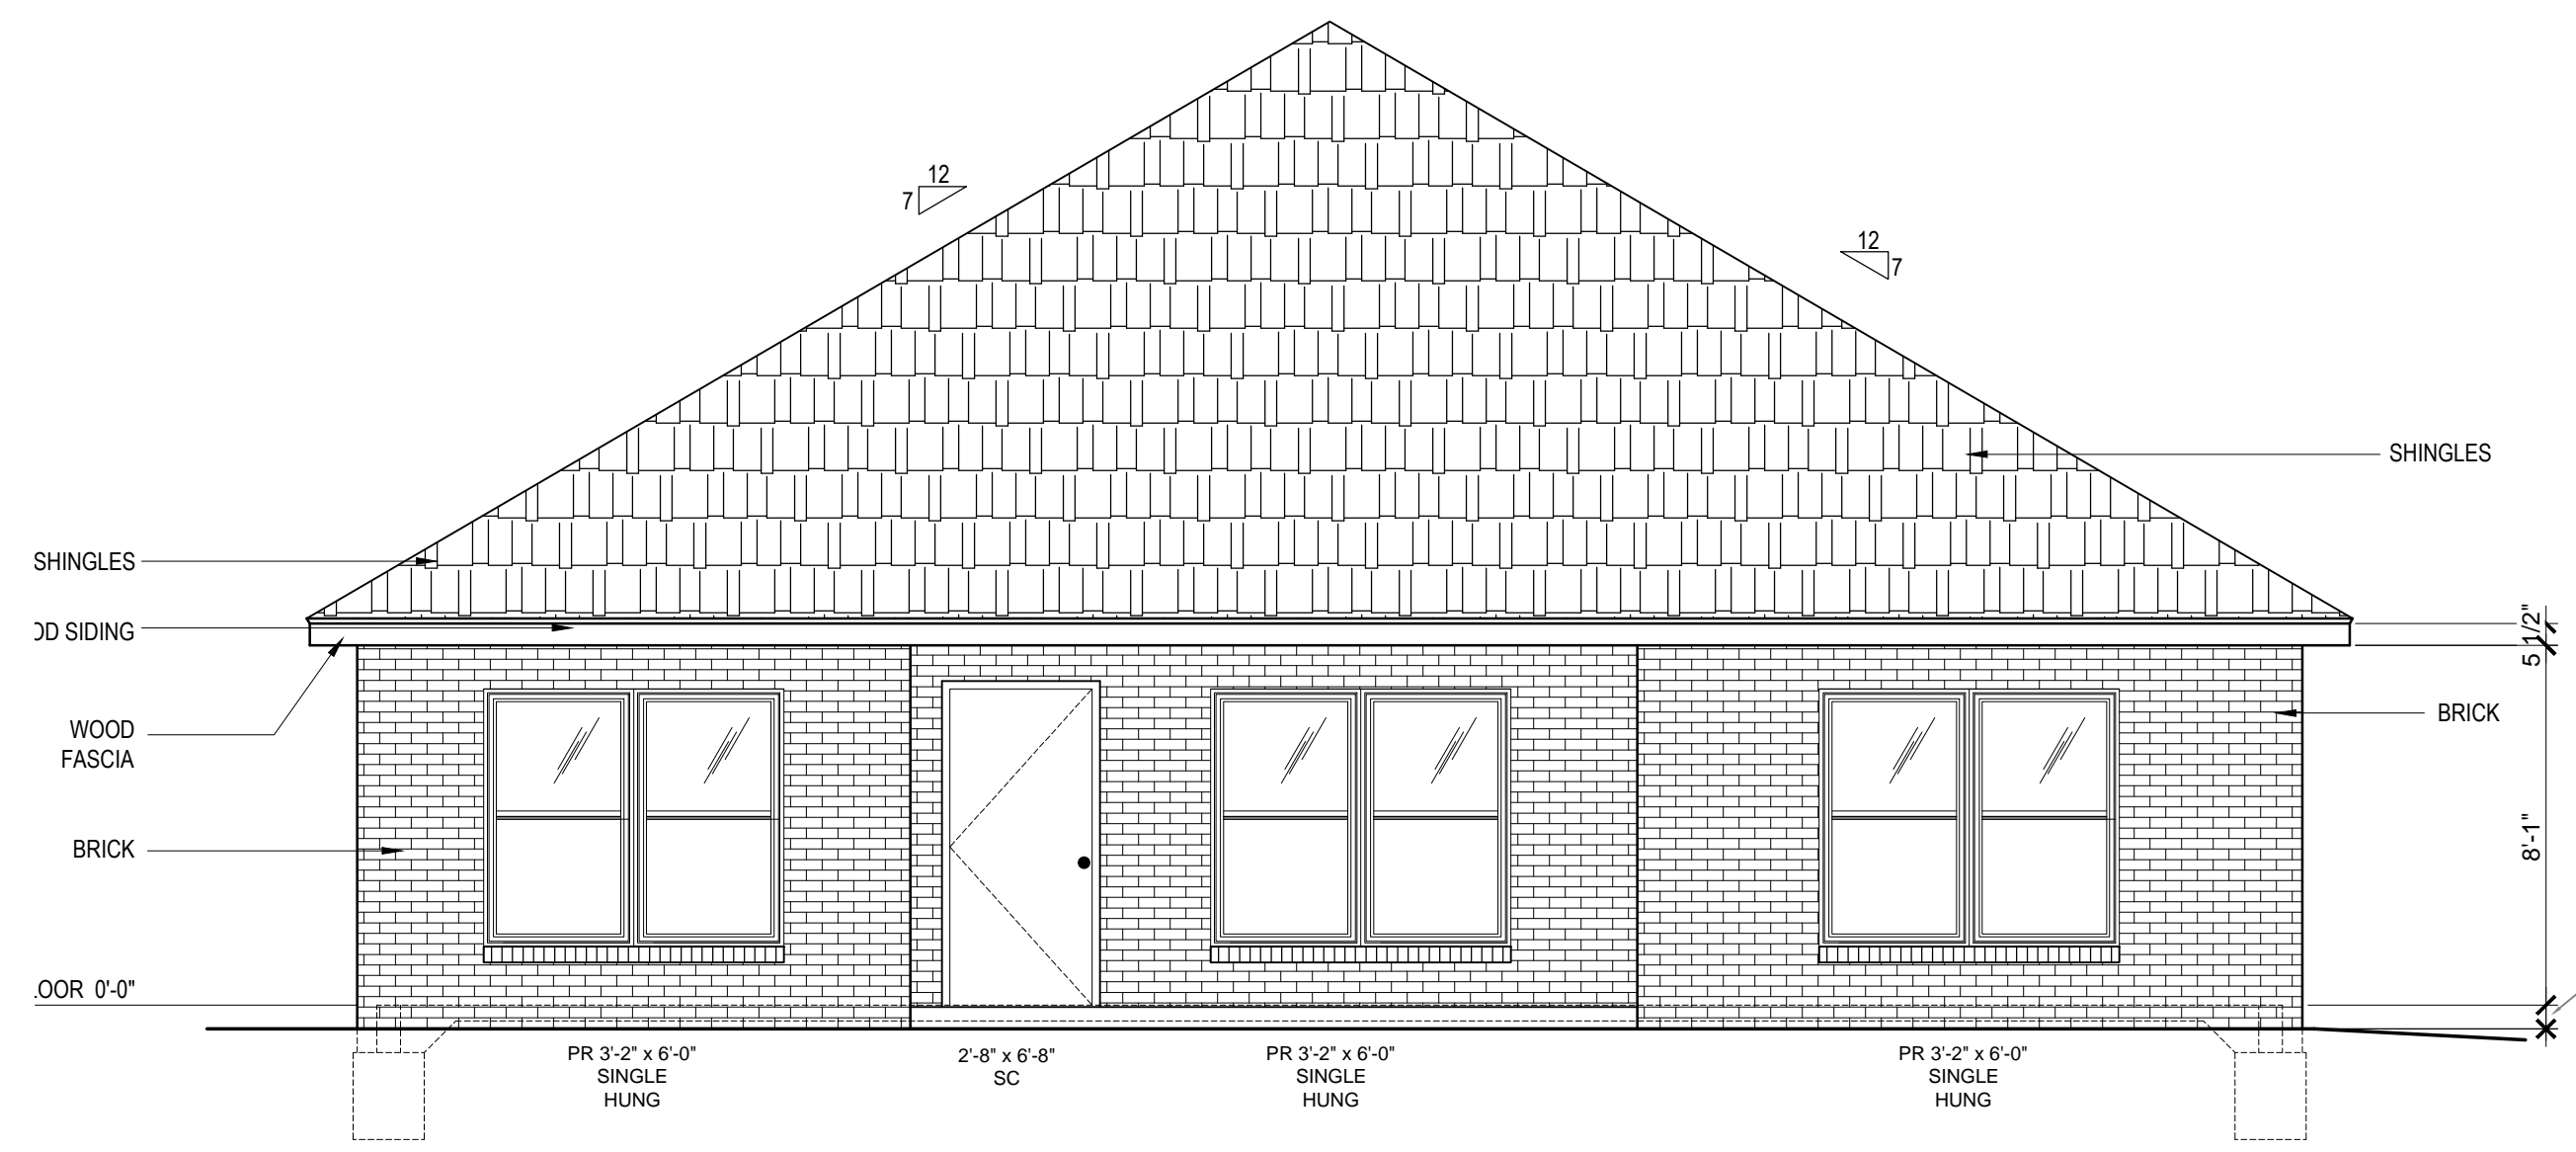

3 HOUSE 5M - REAR ELEVATION
SCALE: 1/4"=1'-0"

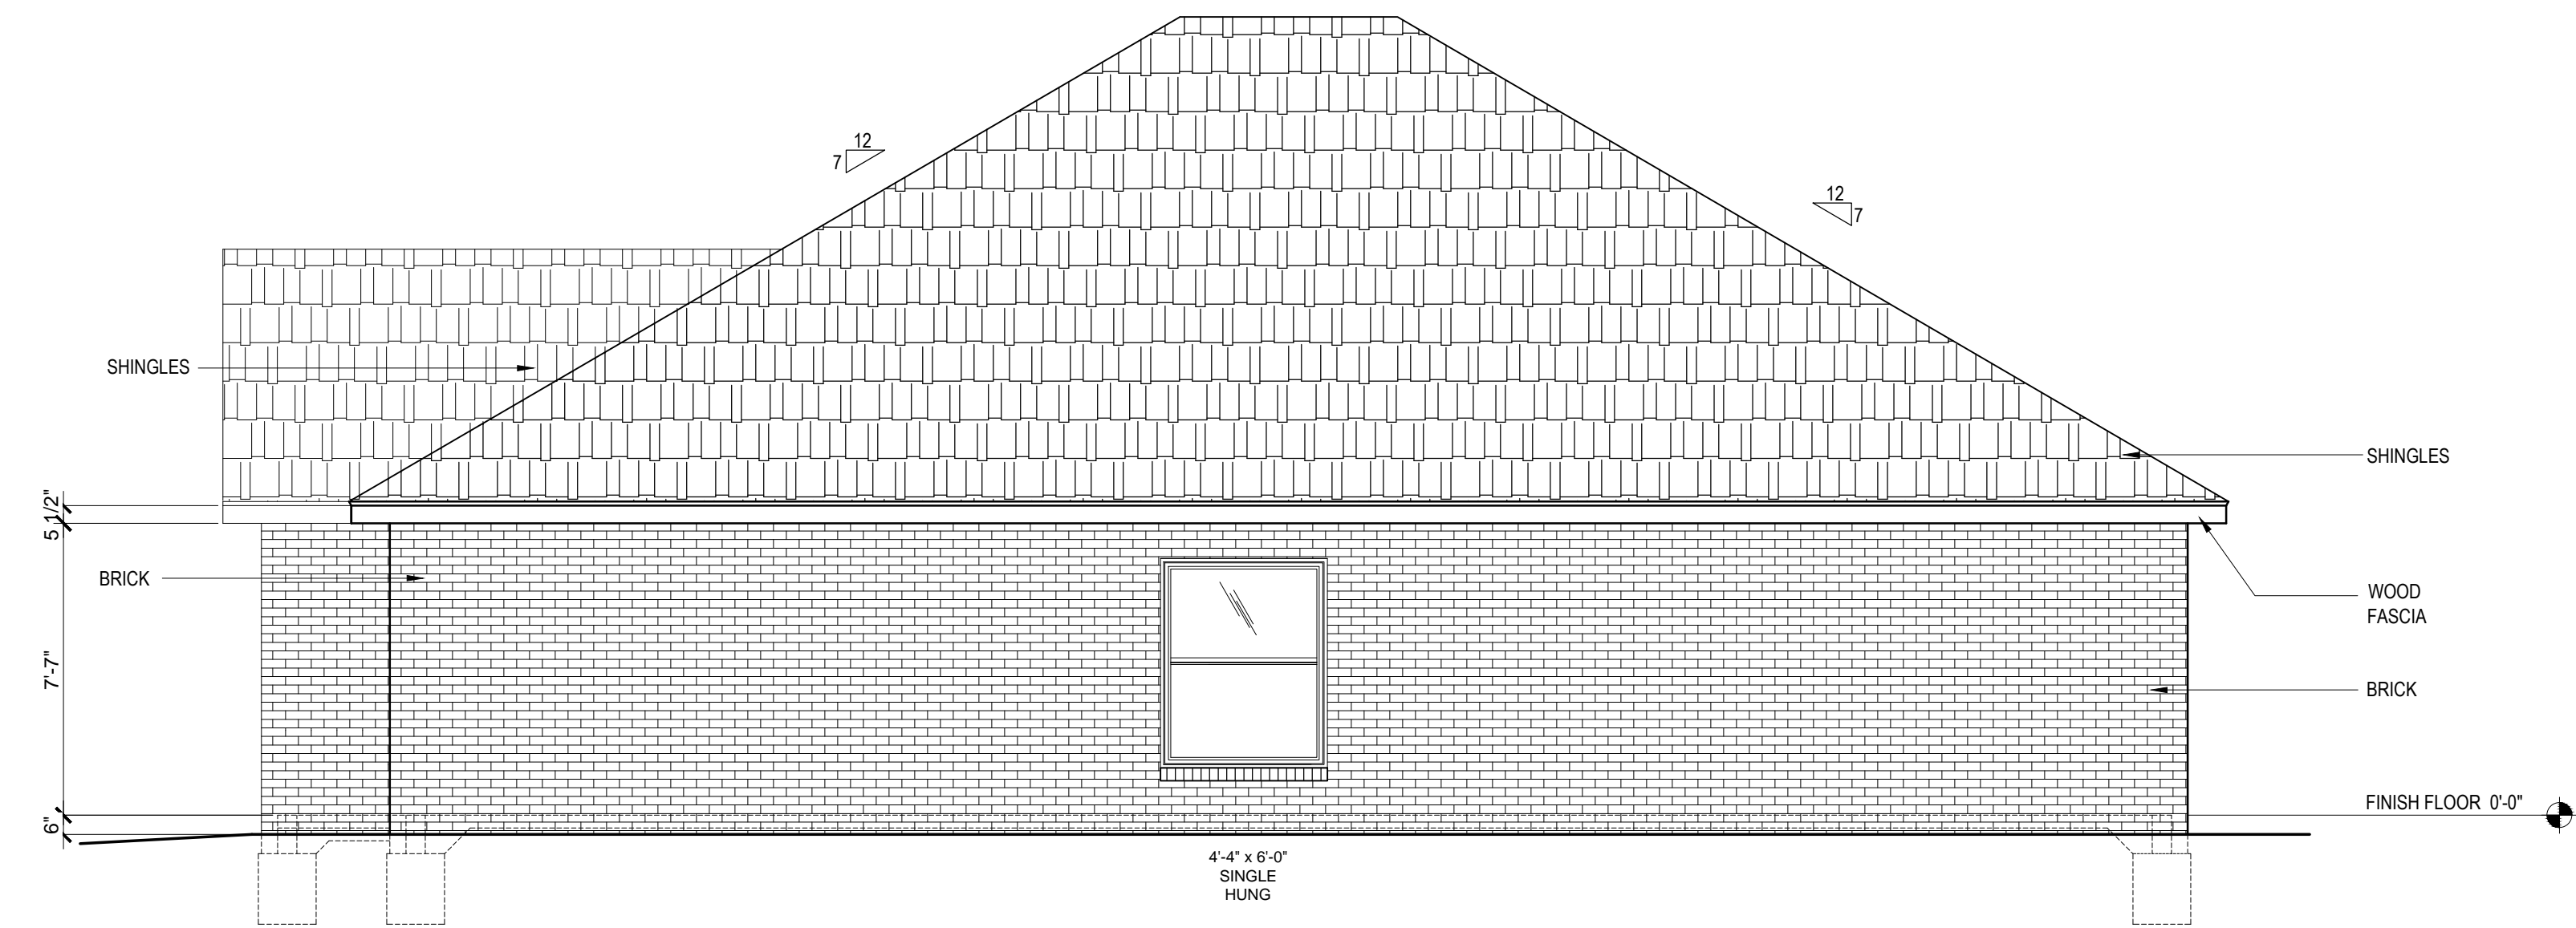

4 HOUSE 5M - SIDE ELEVATION
SCALE: 1/4"=1'-0"



10035 N. 177TH EAST AVE.
OWASSO, OK 74055-7841
918-798-5979
joe@bbkcae.com

3600 SUNVALLEY DR.
NORMAN, OK 73026-0632
405-821-2137
egh@bbkcae.com

BBK/A&E, P.L.L.C. Oklahoma
C.A. No. 02409 (Arch), EXPIRES 06.30.2016



CONSULTANTS:

MIRRORED FOR
CONSTRUCTION
03.01.2016

THESE DRAWINGS ARE THE PROPERTY OF ED G. BISHOP, ARCHITECT AIA. ANY REUSE OR P.L.L.C. UNAUTHORIZED REPRODUCTION FOR ANY PURPOSE IS AN INFRINGEMENT UPON COPYRIGHT LAWS. VIOLATORS WILL BE SUBJECT TO PROSECUTION TO THE FULLEST EXTENT OF THE LAW.
WRITTEN DIMENSIONS ON THESE DRAWINGS SHALL HAVE PRECEDENCE OVER SCALE DIMENSIONS. CONTRACTORS SHALL VERIFY AND BE RESPONSIBLE FOR ALL DIMENSIONS AND CONDITIONS ON THE JOB AND THIS OFFICE MUST BE NOTIFIED OF ANY VARIATION FROM THE DIMENSIONS AND CONDITIONS SHOWN BY THESE DRAWINGS. NO CHANGE ORDERS WILL BE ISSUED OR CHANGES INCURRED IN THE FIELD AFTER CONSTRUCTION HAS COMMENCED UNLESS SPECIFICALLY AUTHORIZED BY THE OWNER. ©2015 BBK/A&E.

REVISIONS:	DATE:
△	.
△	.
△	.
△	.
△	.
△	.

RELEASED FOR:	DATE:
<input type="checkbox"/> PRELIMINARY ONLY	.
<input type="checkbox"/> BIDDING	.
<input type="checkbox"/> PERMITS	.
<input checked="" type="checkbox"/> CONSTRUCTION	XXXXXXXXXX

PROJECT NO: CHEROKEE HOUSING
CAD DWG FILE:
DRAWN BY: mvv
CHECKED BY: egh




CHEROKEE
HOUSING
VIAN, OK


HOUSE 5M
EXTERIOR
ELEVATIONS

A201M


SHEET NO: - / -

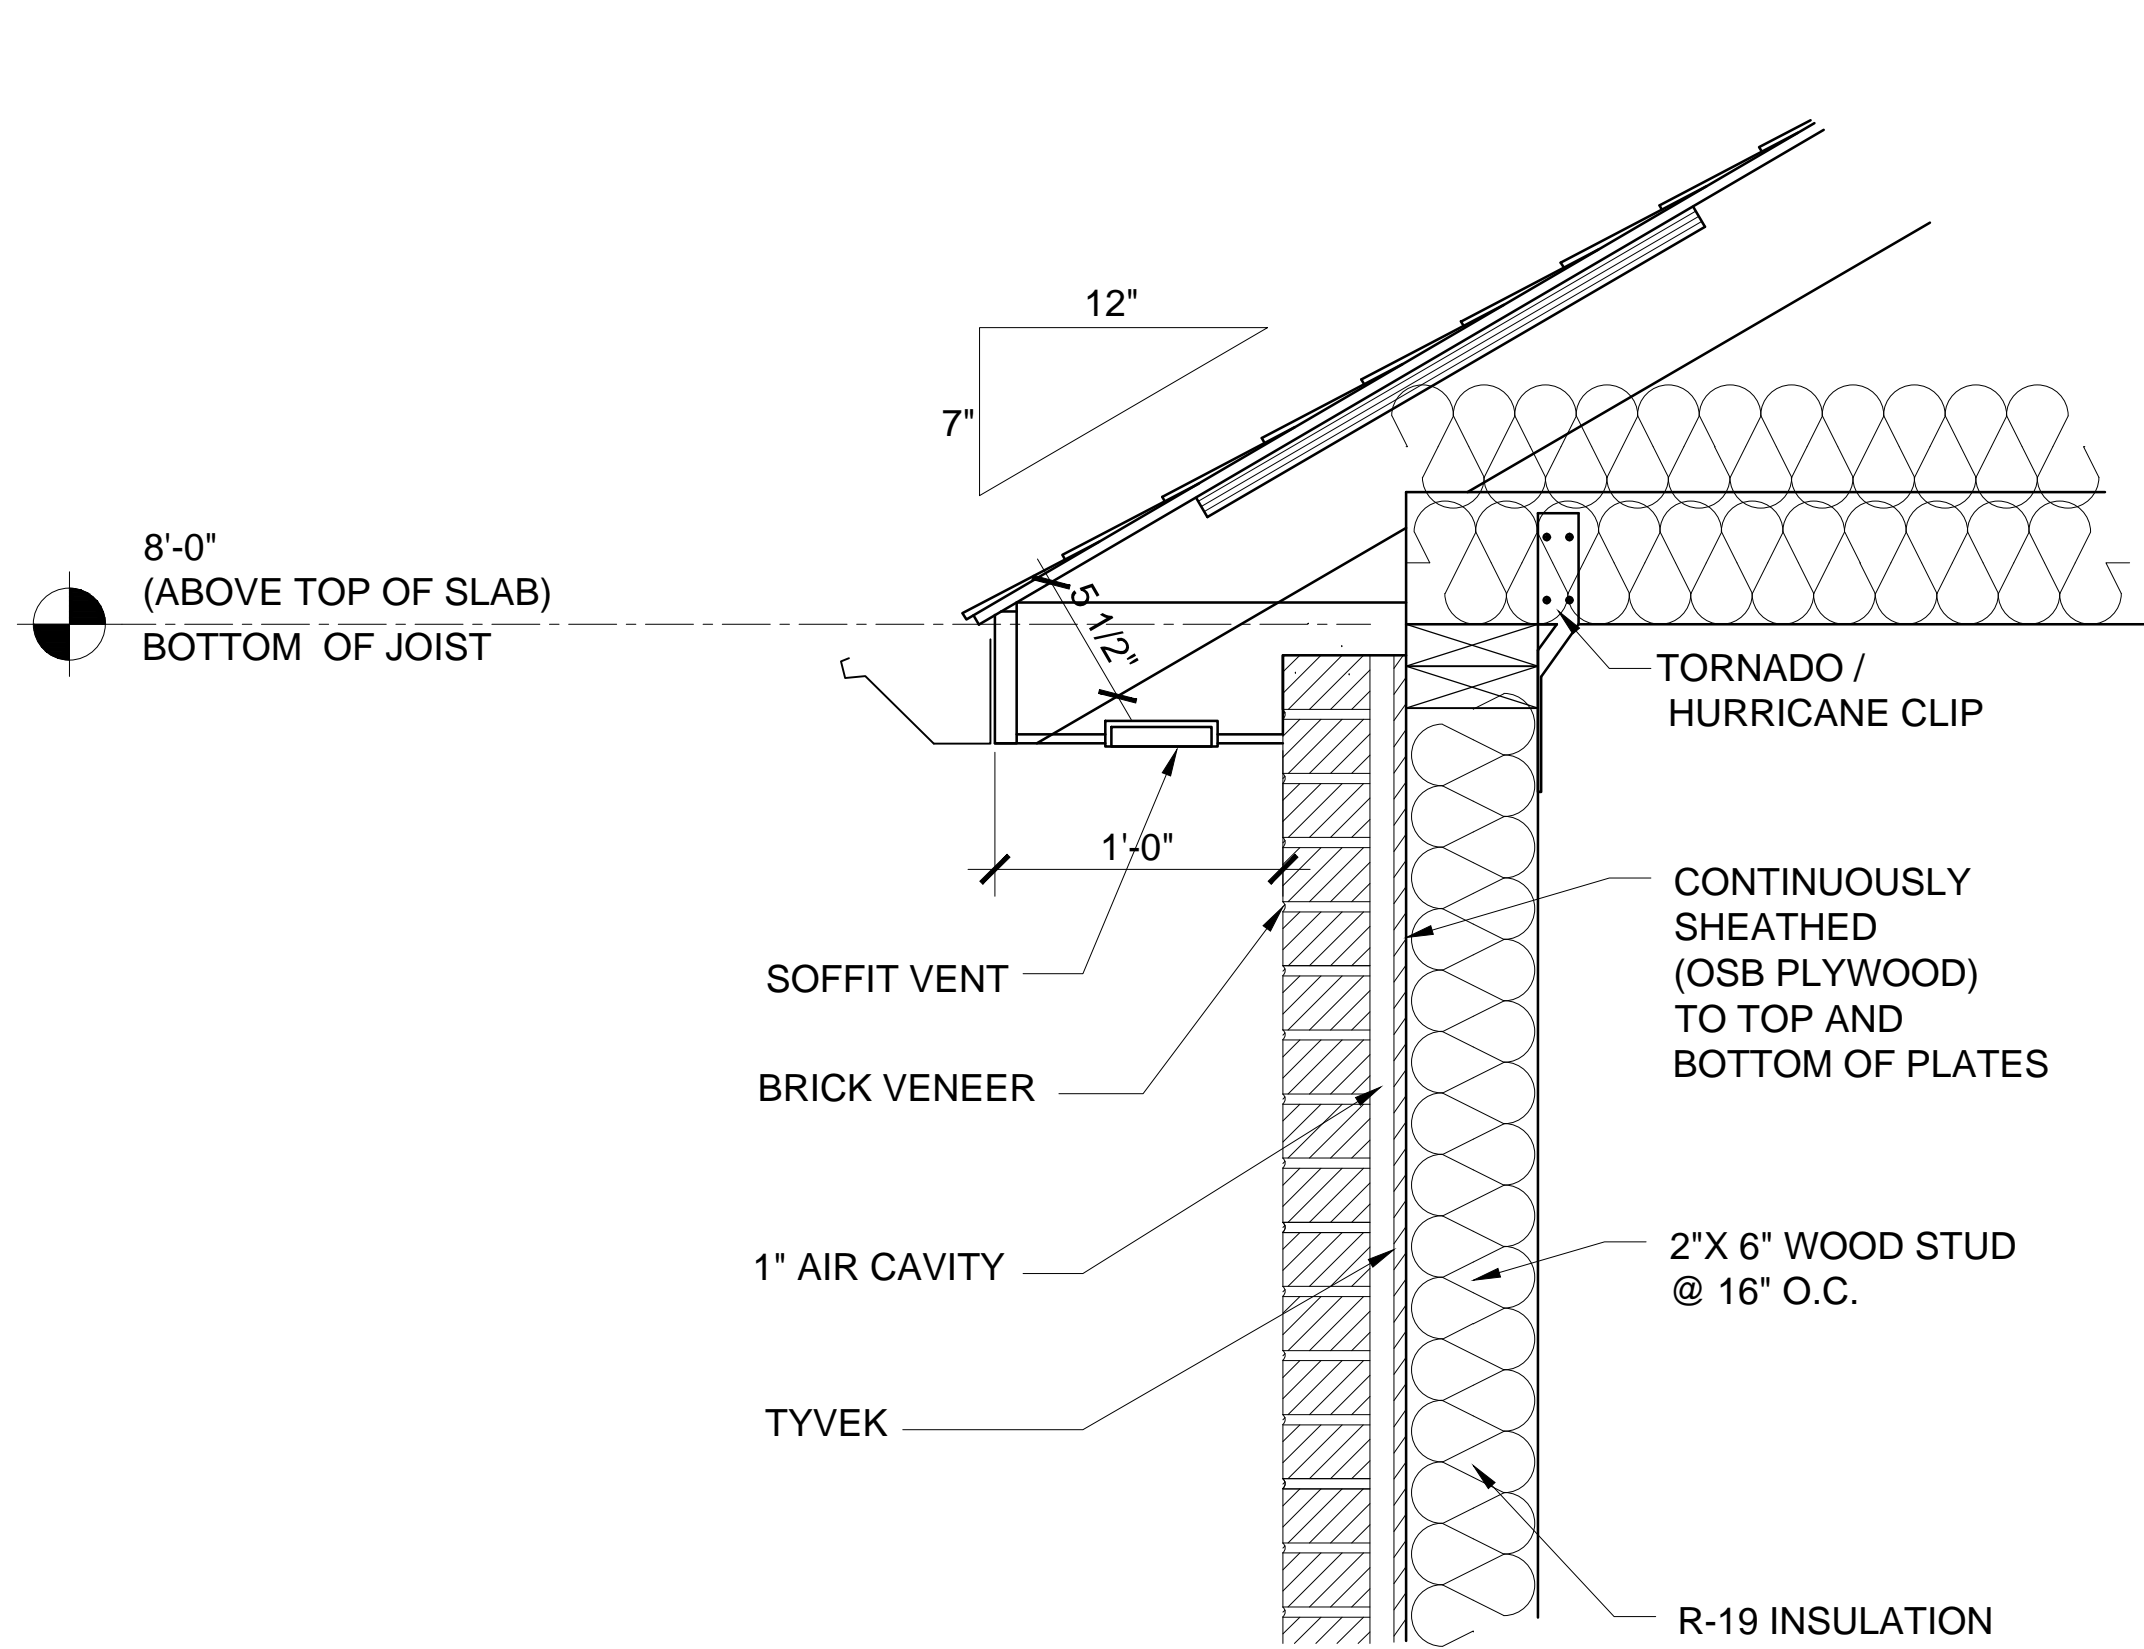

3 DETAIL
SCALE: 1 1/2" = 1'-0"

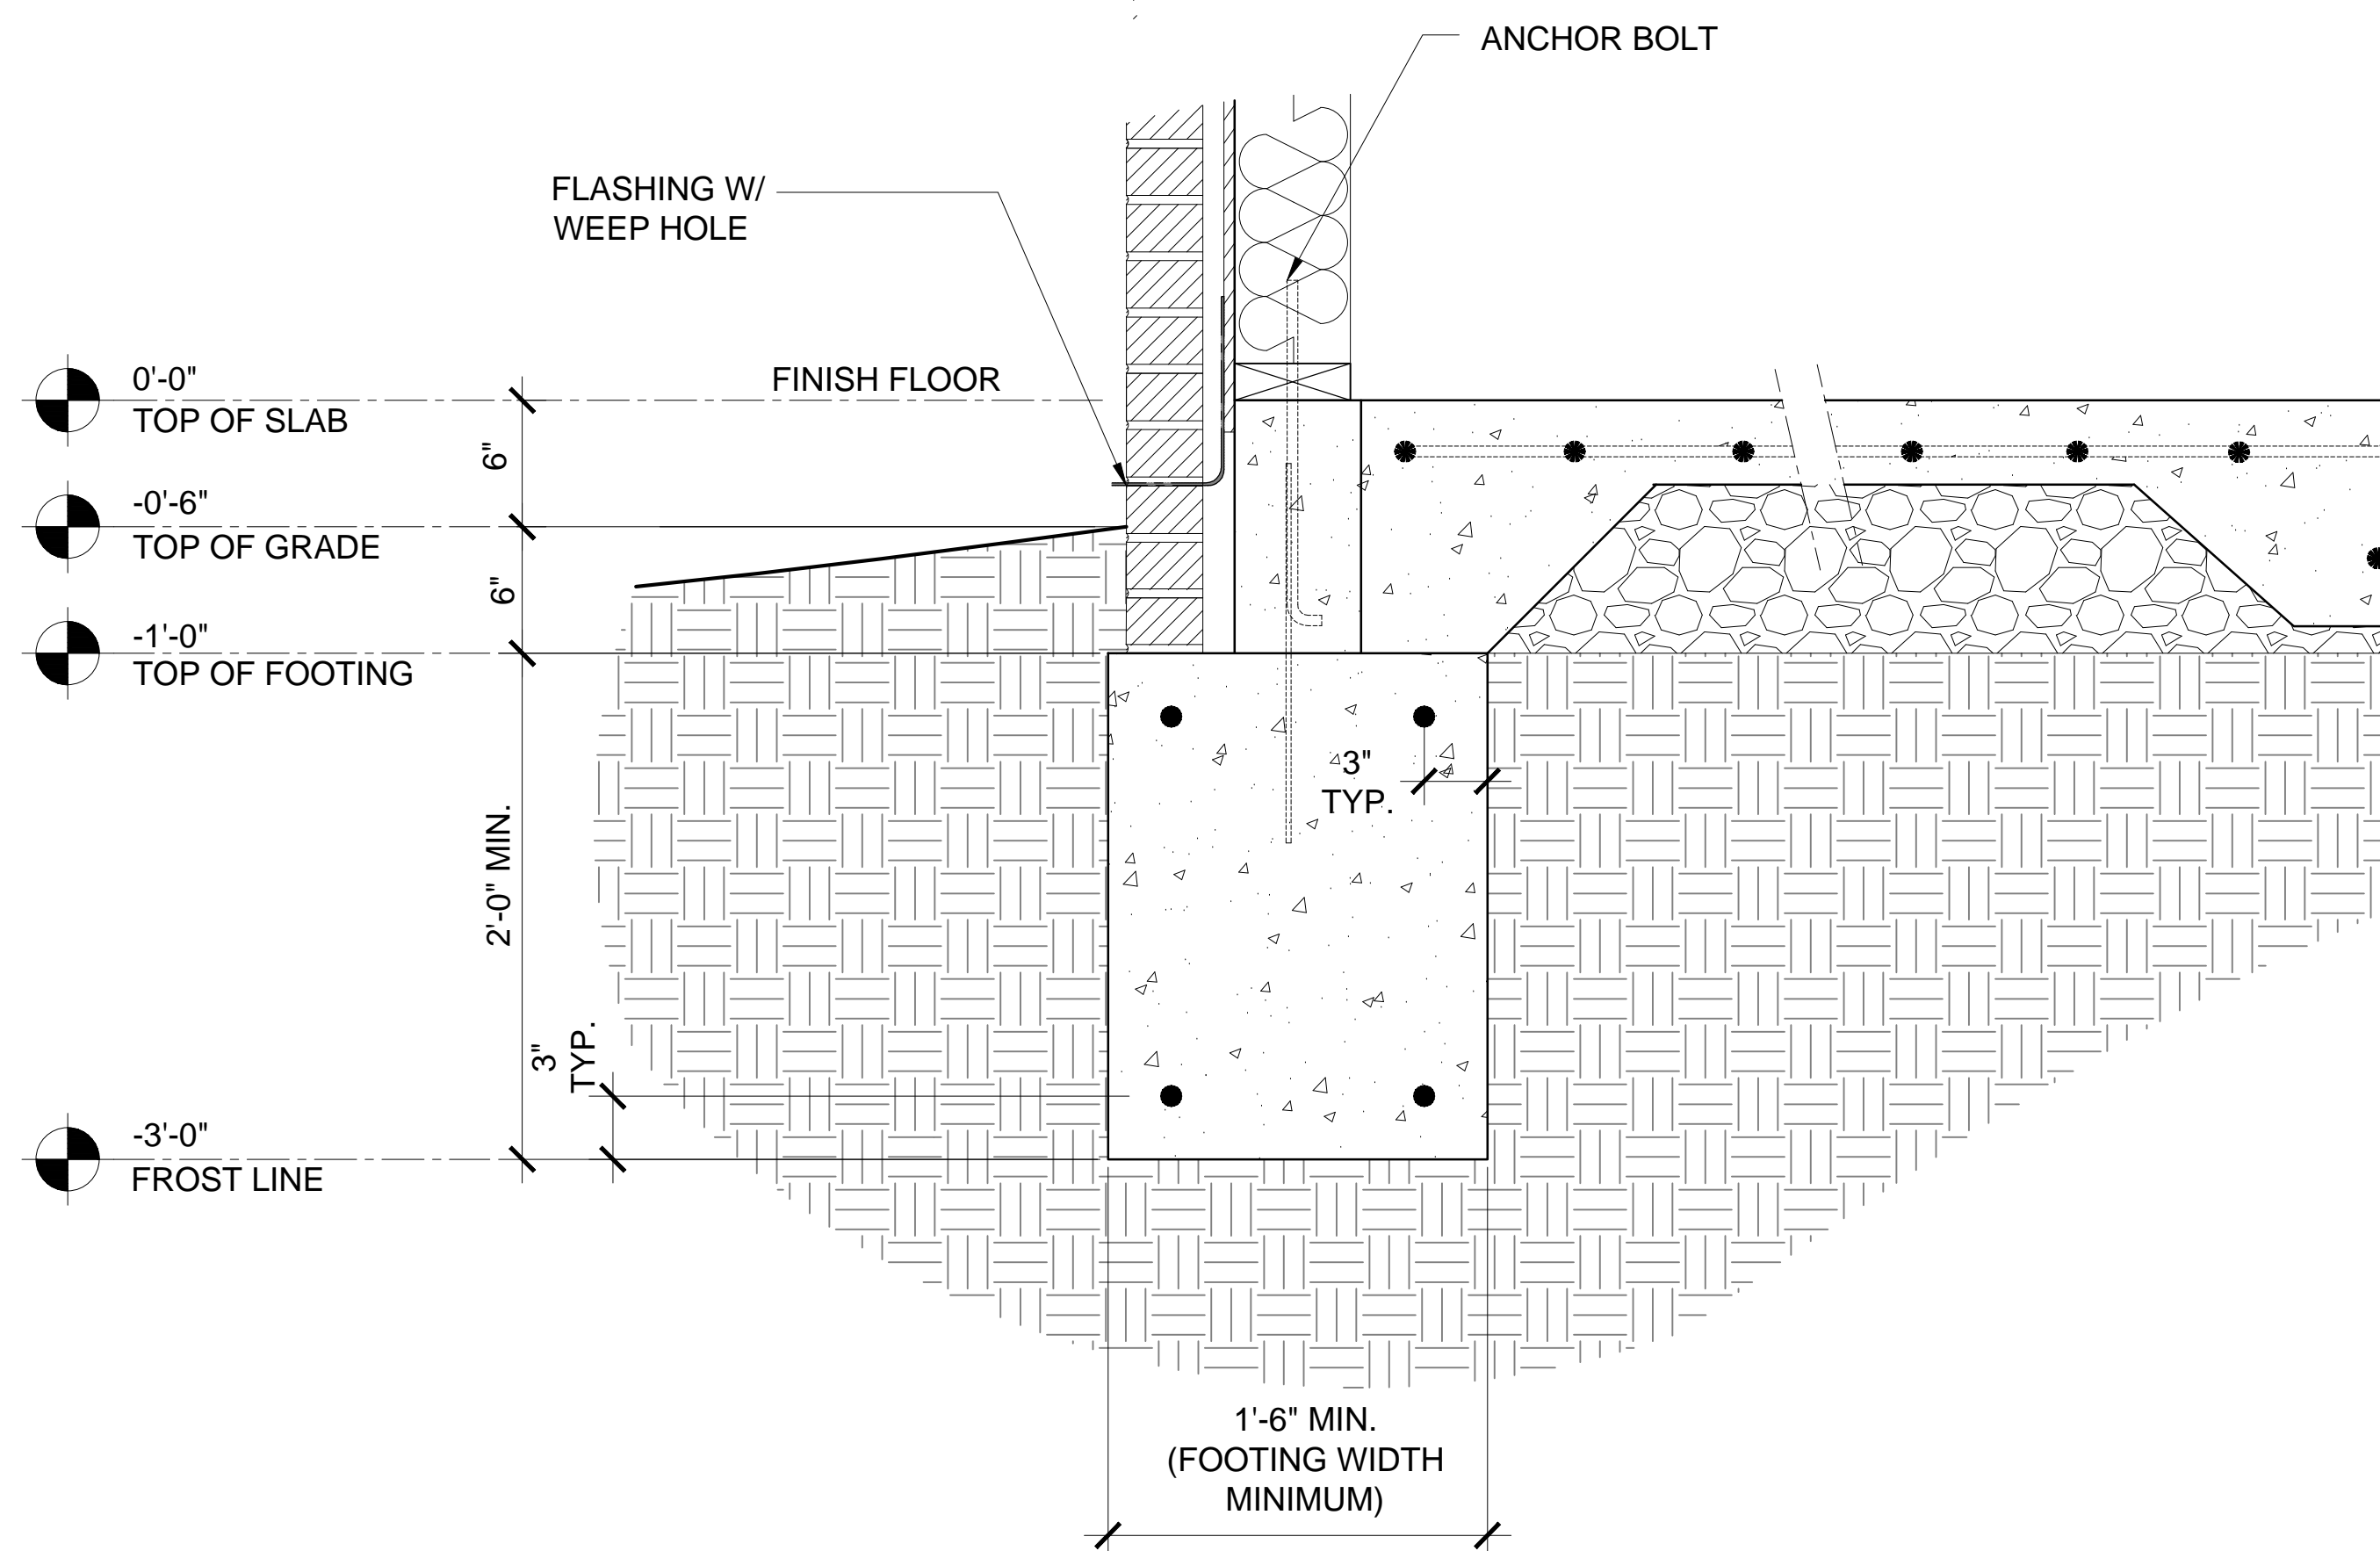

2 DETAIL
SCALE: 1 1/2" = 1'-0"

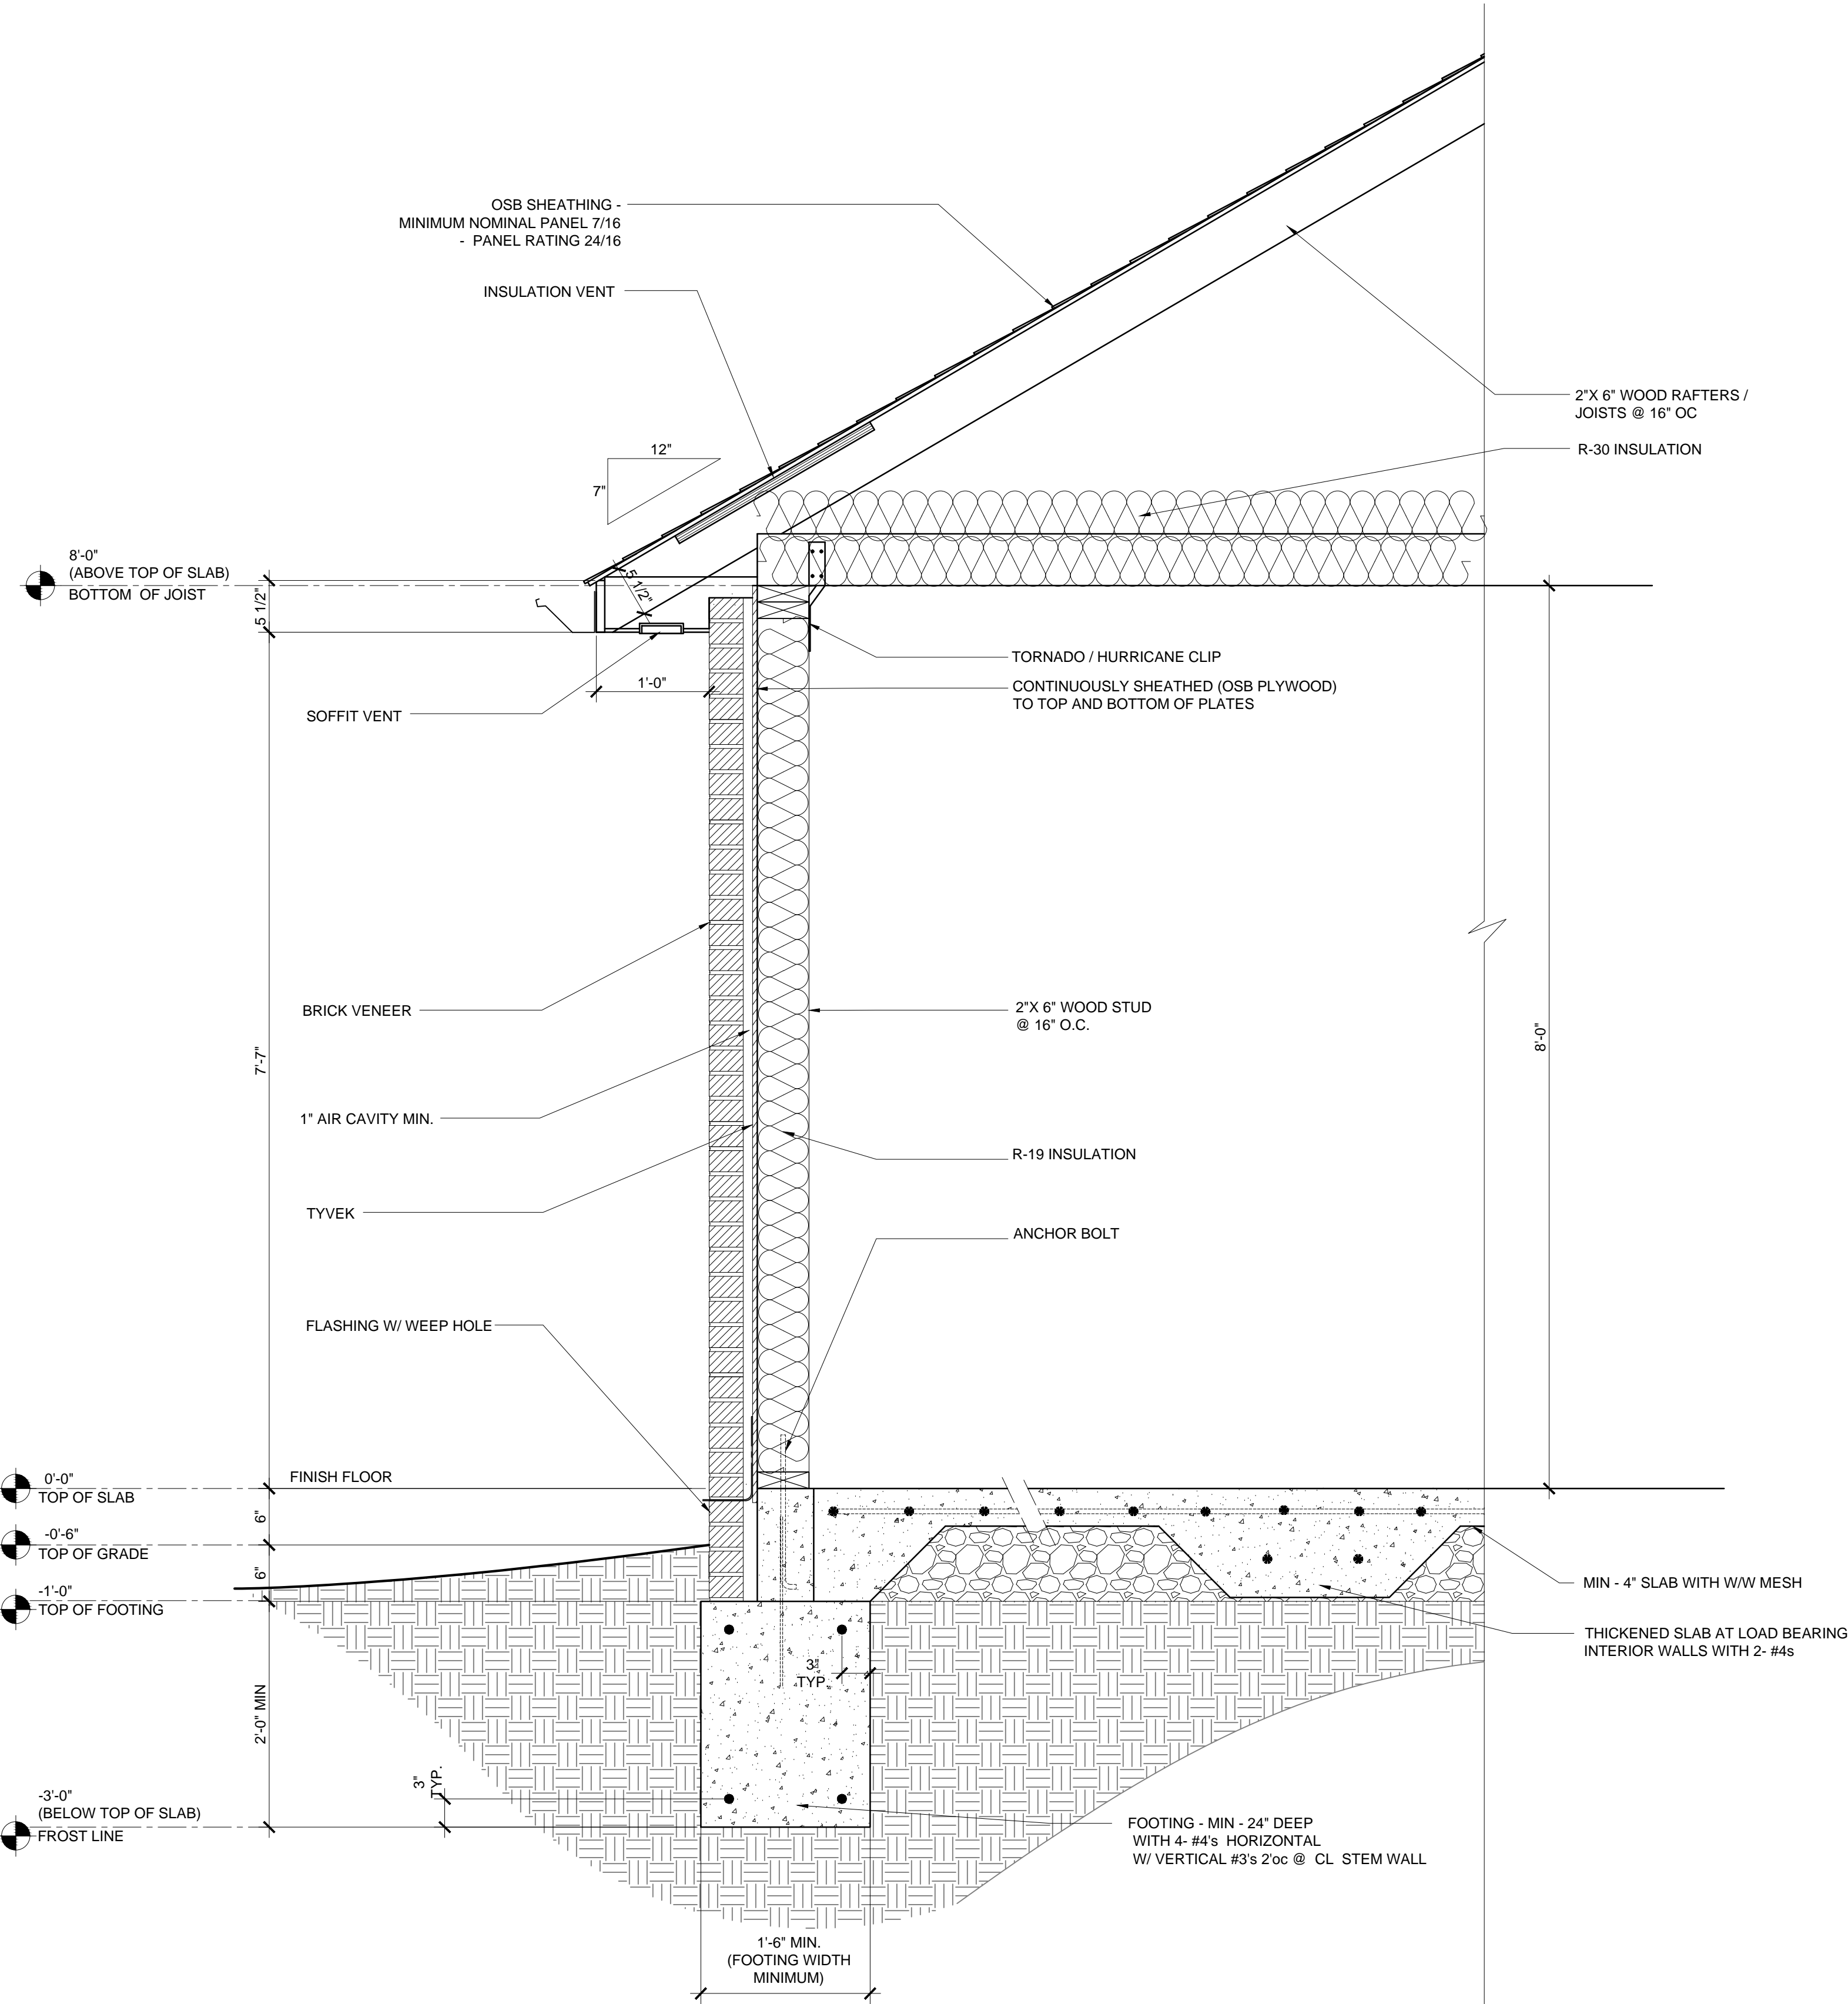

1 SECTION - EXTERIOR WALL
SCALE: 1" = 1'-0"

NOTE: INSTALL STEEL ANGLE LINTELS ABOVE ALL OPENINGS WHERE BRICK/MASONRY VENEER IS TO BE INSTALLED. ON LONGER SPAN OPENINGS WHERE DIMENSIONAL LUMBER IS INSUFFICIENT TO SUPPORT THE BRICK LOAD (SUCH AS GARAGE DOORS), INSTALL LVL HEADERS IN ADDITION TO THE STEEL ANGLE LINTEL.



10035 N. 177TH EAST AVE.
OWASSO, OK 74055-7841
918-798-5979
joe@bbkcae.com

3600 SUNVALLEY DR.
NORMAN, OK 73026-0632
405-821-2137
egb@bbkcae.com

BBK/A&E, P.L.L.C. Oklahoma
C.A. No. 02409 (Arch), EXPIRES 06.30.2016



CONSULTANTS:

MIRRORED FOR CONSTRUCTION
03.01.2016

THESE DRAWINGS ARE THE PROPERTY OF ED G. BISHOP, ARCHITECT AIA AND BBK/A&E P.L.L.C. UNAUTHORIZED REPRODUCTION FOR ANY PURPOSE IS AN INFRINGEMENT UPON COPYRIGHT LAWS. VIOLATORS WILL BE SUBJECT TO PROSECUTION TO THE FULLEST EXTENT OF THE LAW.

WRITTEN DIMENSIONS ON THESE DRAWINGS SHALL HAVE PRECEDENCE OVER SCALE DIMENSIONS. CONTRACTORS SHALL VERIFY AND BE RESPONSIBLE FOR ALL DIMENSIONS AND CONDITIONS ON THE JOB AND THIS OFFICE MUST BE NOTIFIED OF ANY VARIATION FROM THE DIMENSIONS AND CONDITIONS SHOWN BY THESE DRAWINGS. NO CHANGE ORDERS WILL BE ISSUED FOR CHANGES REQUIRED IN THE FIELD AFTER CONSTRUCTION HAS COMMENCED UNLESS SPECIFICALLY AUTHORIZED BY THE OWNER. ©2015 BBK/A&E.

REVISIONS:	DATE:
△	-
△	-
△	-
△	-
△	-
△	-

RELEASED FOR:	DATE:
<input type="checkbox"/> PRELIMINARY ONLY	-
<input type="checkbox"/> BIDDING	-
<input type="checkbox"/> PERMITS	-
<input checked="" type="checkbox"/> CONSTRUCTION	XX.XX.XX

PROJECT NO: CHEROKEE HOUSING
CAD DWG FILE:
DRAWN BY: rrv
CHECKED BY: egb



CHEROKEE HOUSING
VIAN, OK

HOUSE 5M WALL SECTIONS

A301M

SHEET NO. 04




10035 N. 177TH EAST AVE.
OWASSO, OK 74055-7841
918-798-5979
joe@bbkare.com

3600 SUNVALLEY DR.
NORMAN, OK 73026-0632
405-821-2137
egh@bbkare.com


BBK/A&E, P.L.L.C. Oklahoma
C.A. No. 02409 (Arch), EXPIRES 06.30.2016




CONSULTANTS:

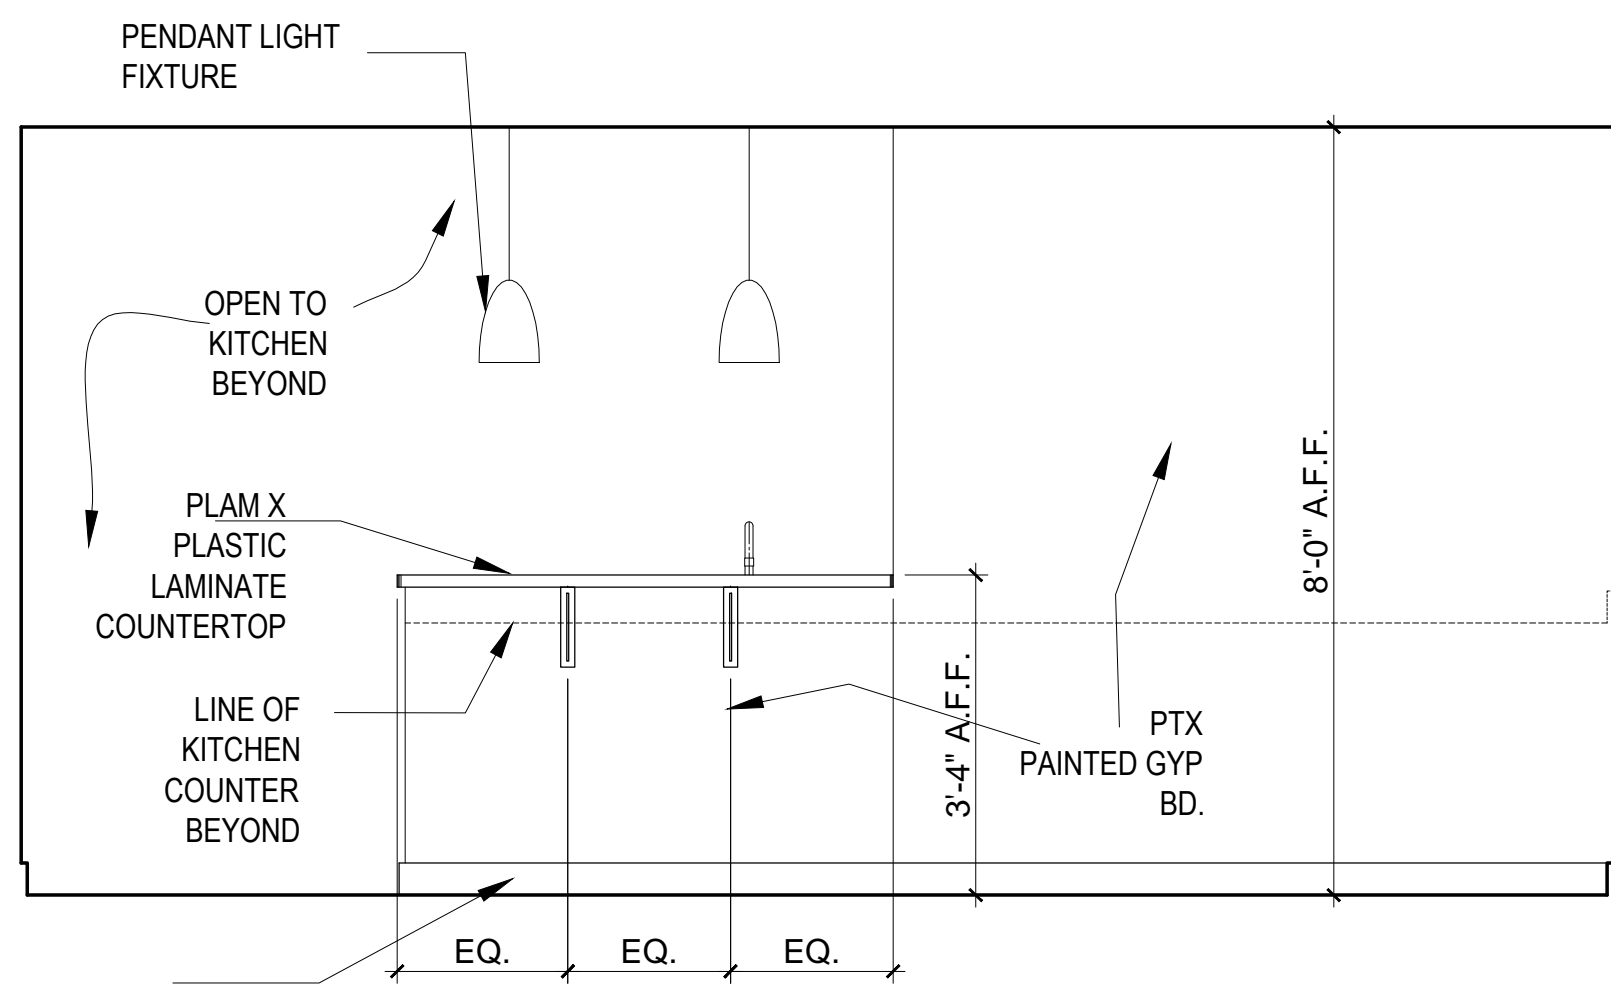


3 HOUSE 5M - PASS-THRU ELEVATION
SCALE: 1/2"=1'-0"

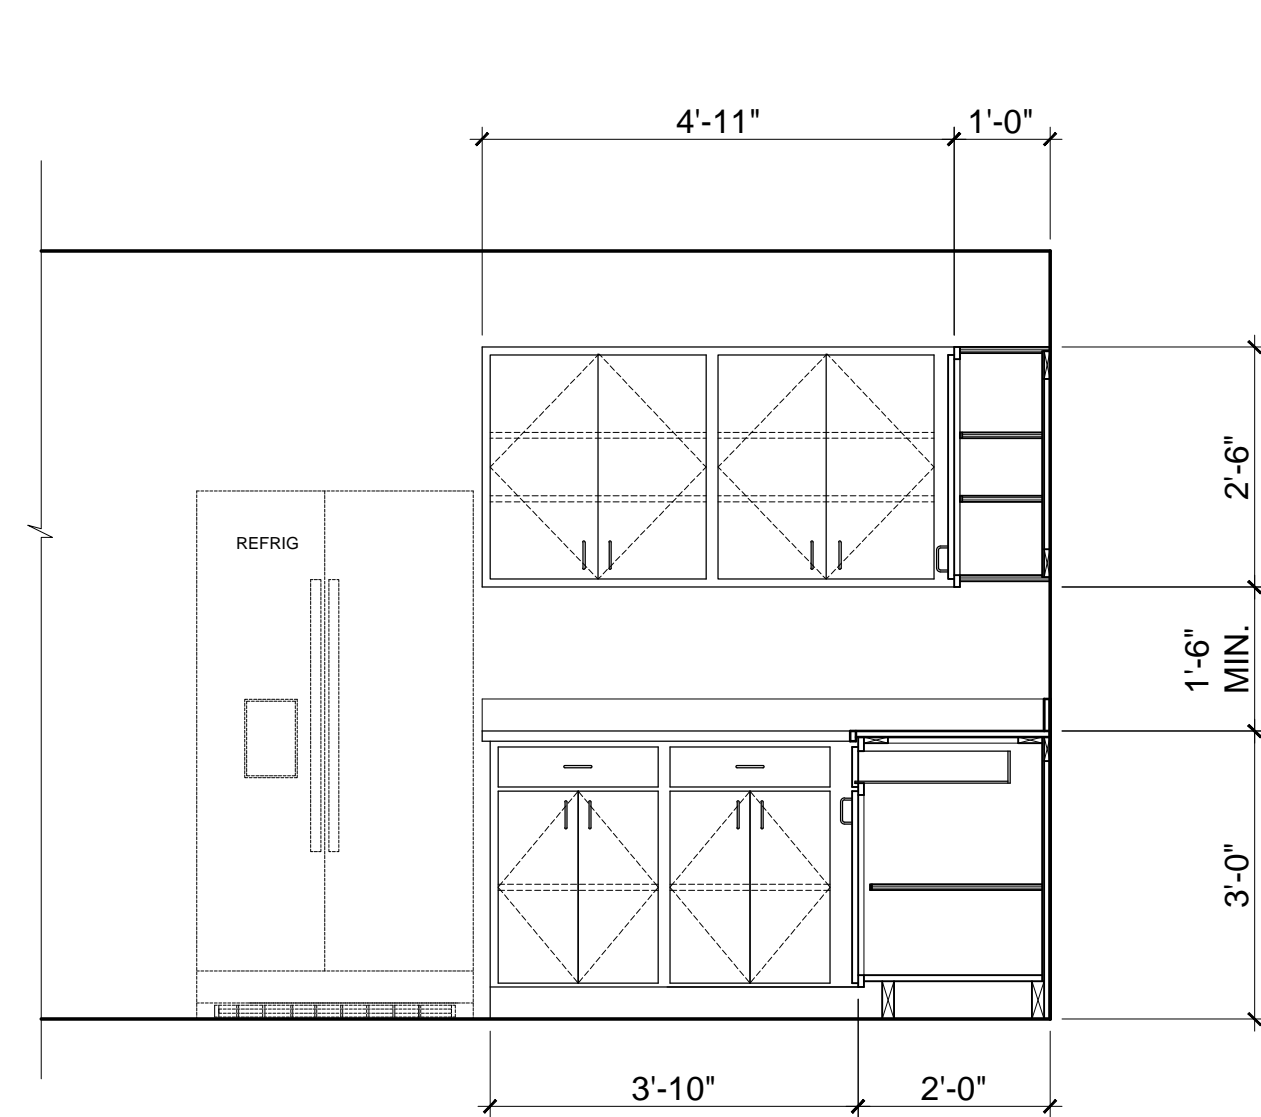


4 HOUSE 5M - KITCHEN ELEVATION
SCALE: 1/2"=1'-0"

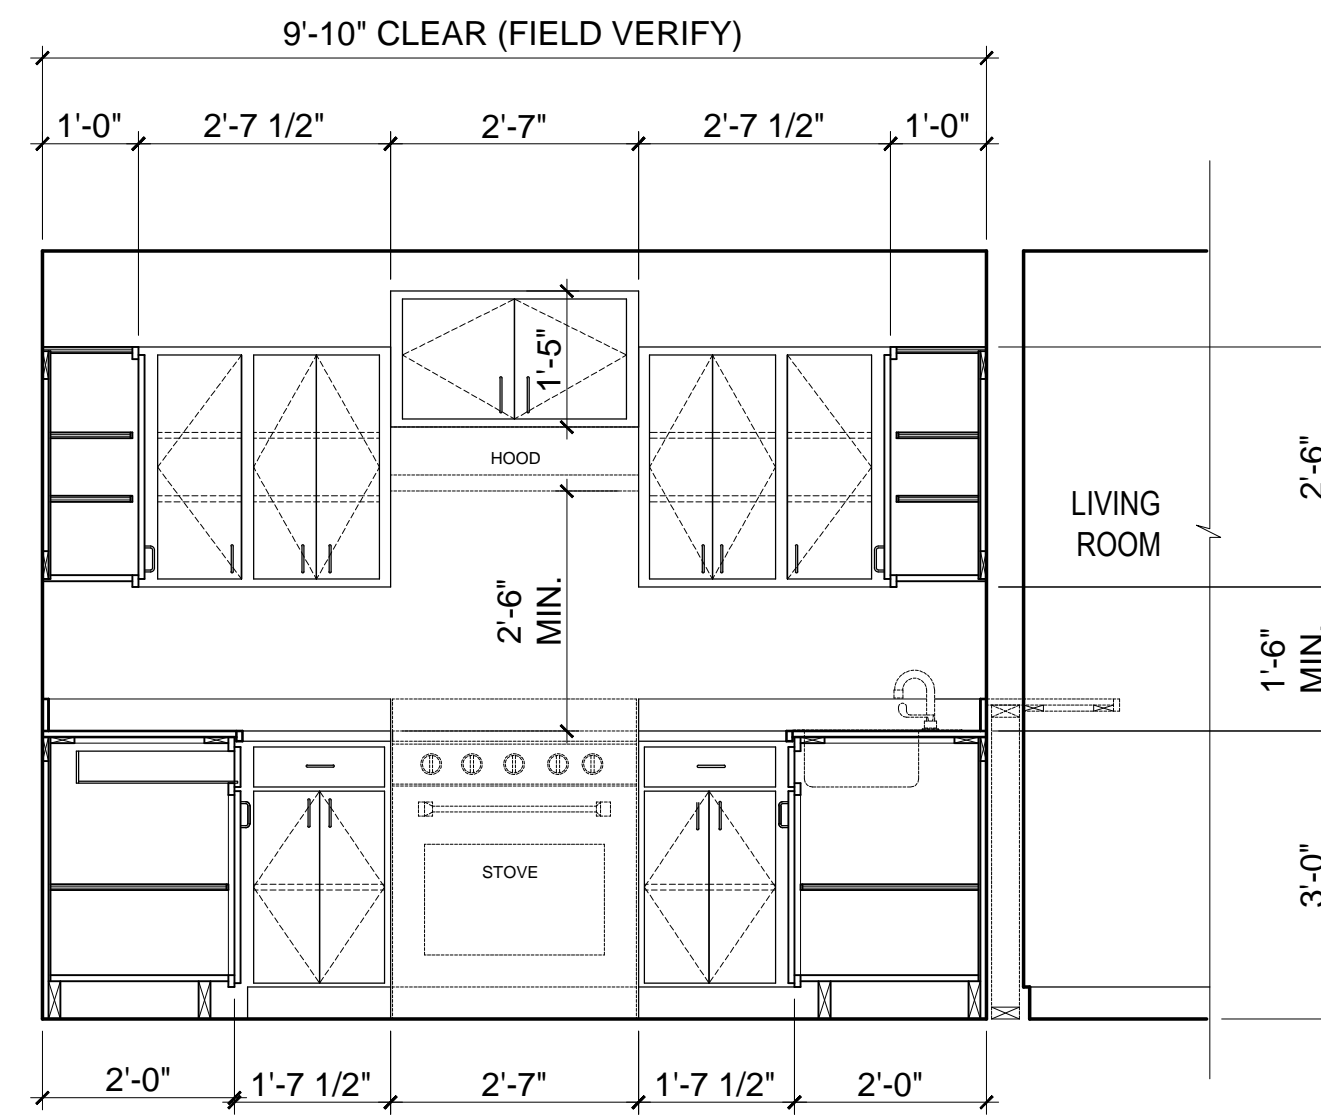


5 HOUSE 5M - KITCHEN ELEVATION
SCALE: 1/2"=1'-0"

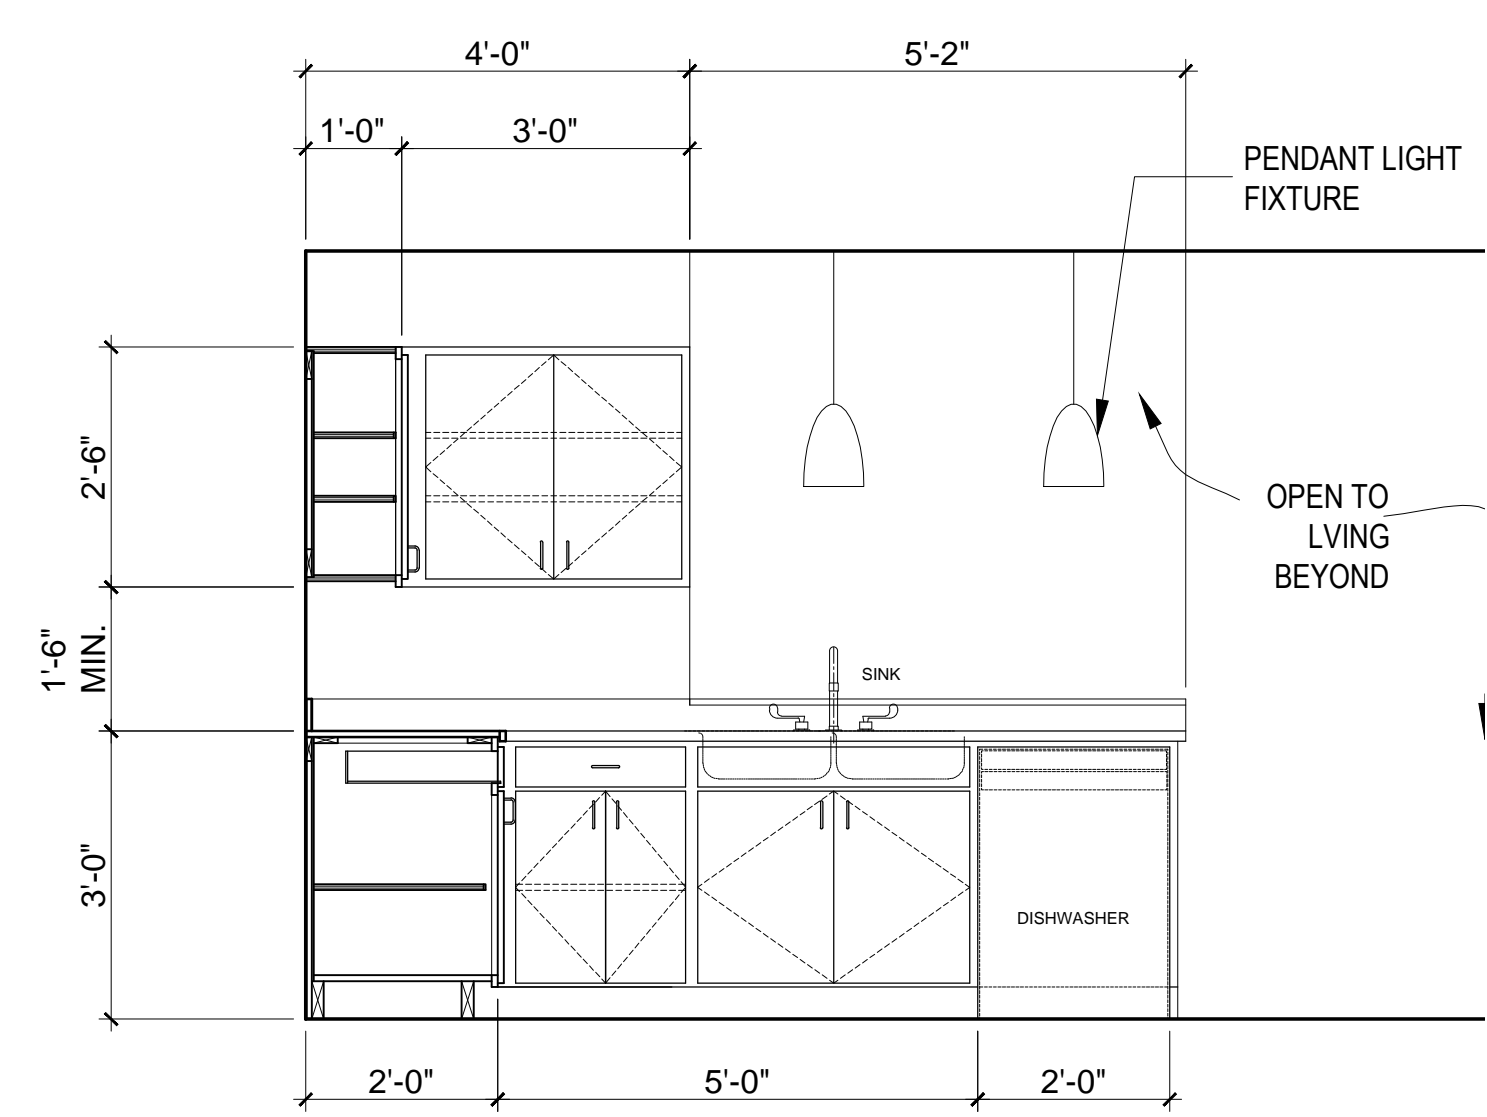

6 HOUSE 5M - KITCHEN ELEVATION
SCALE: 1/2"=1'-0"

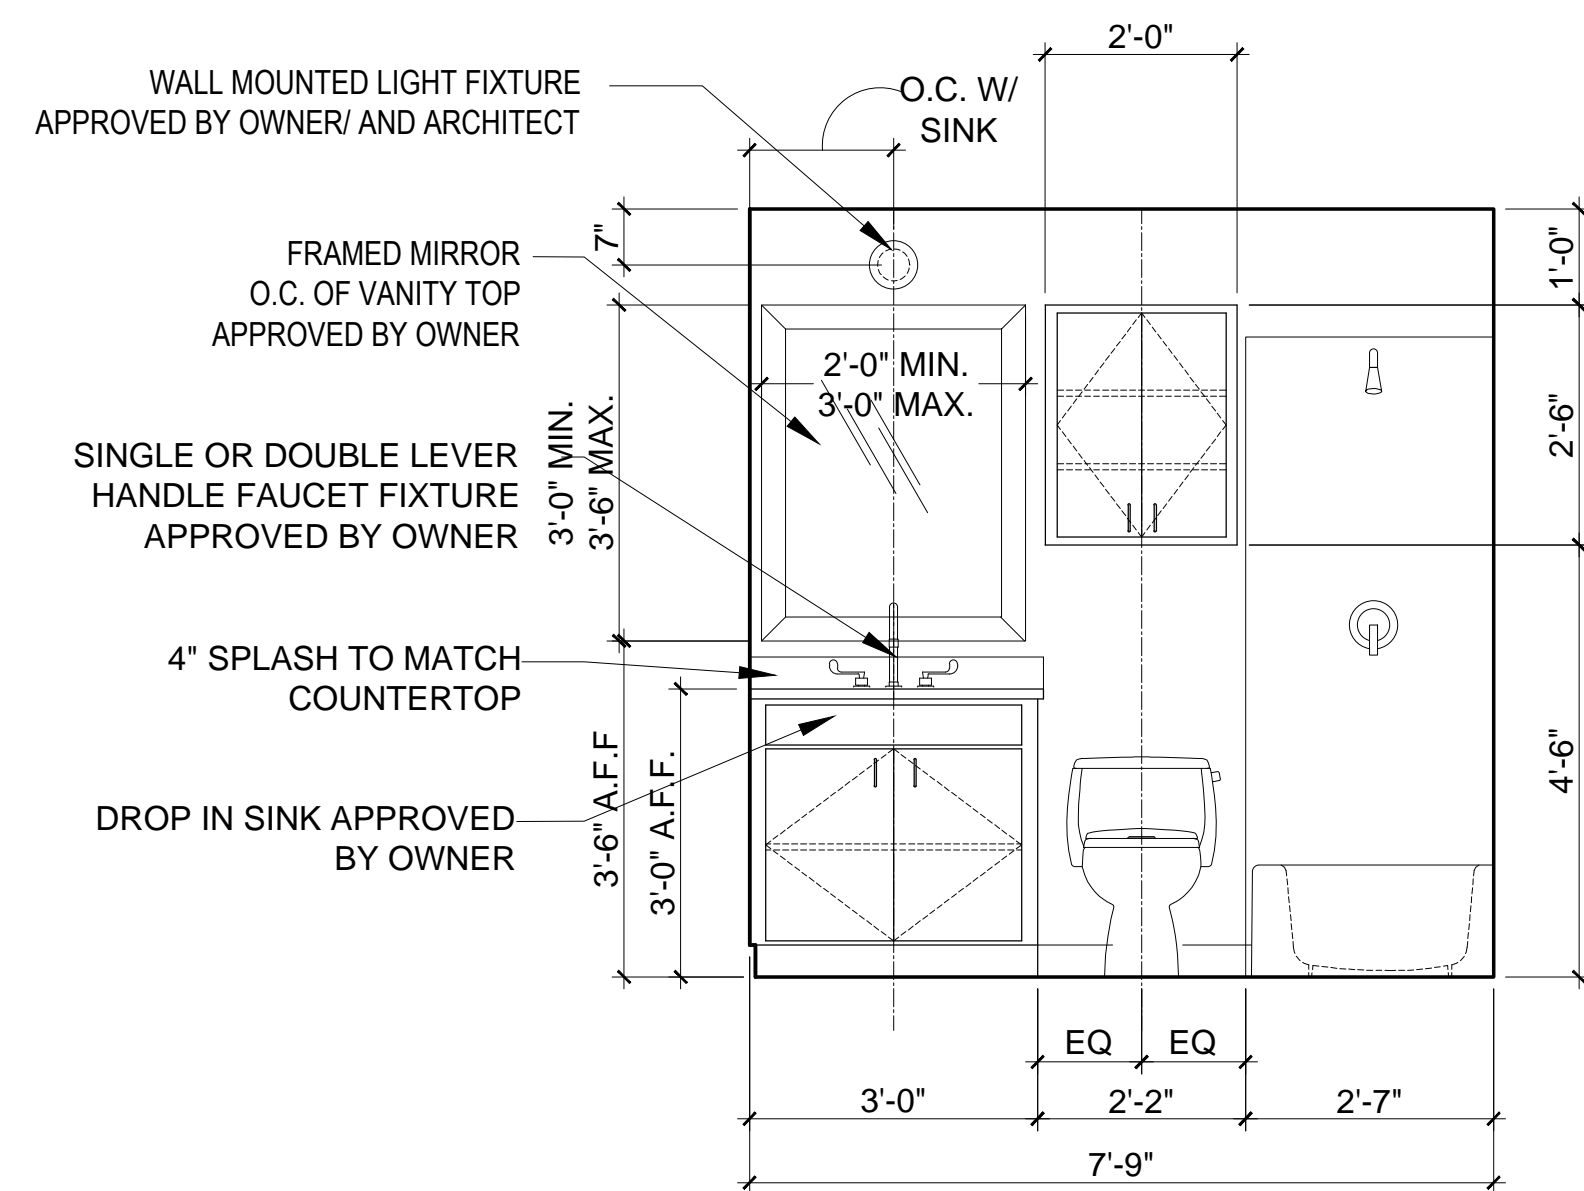

1 HOUSE 5M - MAIN BATH ELEVATION
SCALE: 1/2"=1'-0"

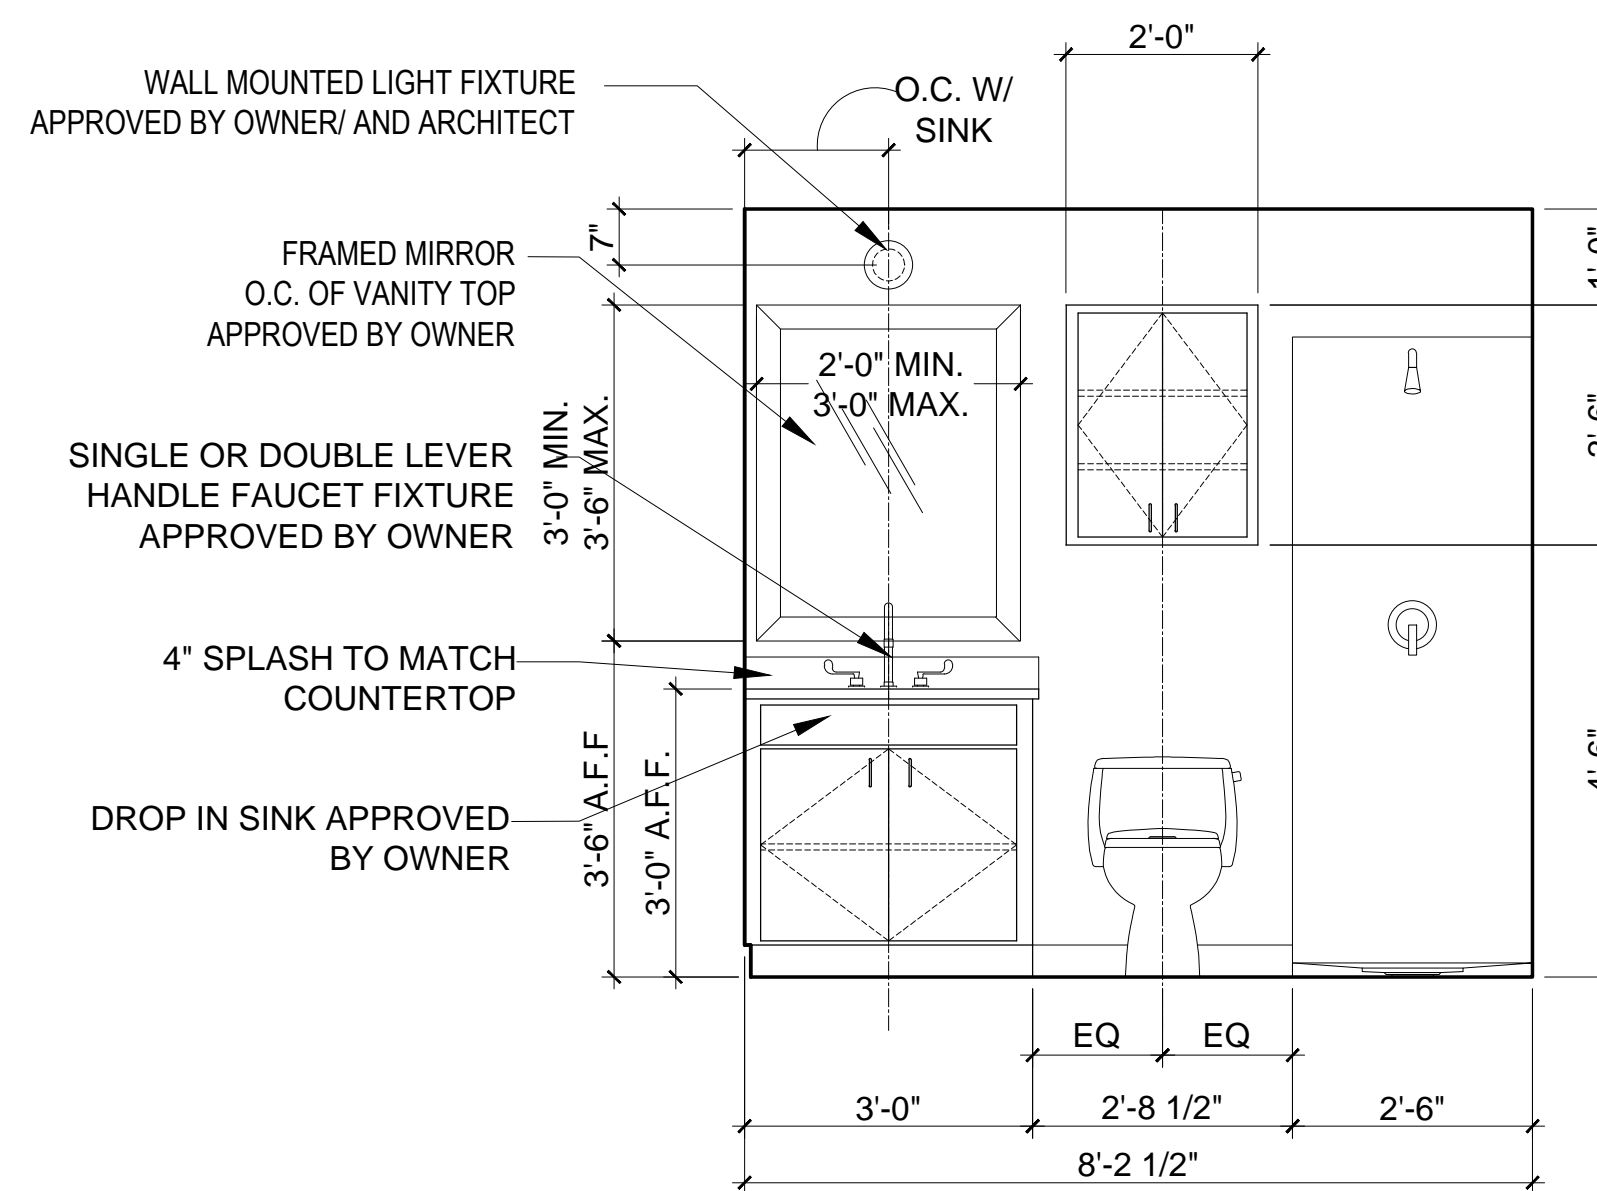

2 HOUSE 5M - MASTER BATH ELEVATION
SCALE: 1/2"=1'-0"

MIRRORED FOR CONSTRUCTION
03.01.2016

THESE DRAWINGS ARE THE PROPERTY OF ED G. BISHOP, ARCHITECT AIA AND BBK/A&E P.L.L.C. UNAUTHORIZED REPRODUCTION FOR ANY PURPOSE IS AN INFRINGEMENT UNDER COPYRIGHT LAWS. VIOLATORS WILL BE SUBJECT TO PROSECUTION TO THE FULLEST EXTENT OF THE LAW.
WRITTEN DIMENSIONS ON THESE DRAWINGS SHALL HAVE PRECEDENCE OVER SCALE DIMENSIONS. CONTRACTORS SHALL VERIFY AND BE RESPONSIBLE FOR ALL DIMENSIONS AND CONDITIONS ON THE JOB AND THIS OFFICE MUST BE NOTIFIED OF ANY VARIATION FROM THE DIMENSIONS AND CONDITIONS SHOWN BY THESE DRAWINGS. NO CHANGE ORDERS WILL BE ISSUED OR CHANGES INCURRED IN THE FIELD AFTER CONSTRUCTION HAS COMMENCED UNLESS SPECIFICALLY AUTHORIZED BY THE OWNER. ©2015 BBK/A&E

REVISIONS:	DATE:
△	.
△	.
△	.
△	.
△	.

RELEASED FOR:	DATE:
<input type="checkbox"/> PRELIMINARY ONLY	.
<input type="checkbox"/> BIDDING	.
<input type="checkbox"/> PERMITS	.
<input checked="" type="checkbox"/> CONSTRUCTION	XXXXXX

PROJECT NO: CHEROKEE HOUSING
CAD DWG FILE:
DRAWN BY: mrv
CHECKED BY: egh



CHEROKEE HOUSING
VIAN, OK

HOUSE 5M
INTERIOR ELEVATIONS

A401M

SHEET NO: - / -