

CHEROKEE NATION W.W. HASTINGS REPLACEMENT HOSPITAL

SCHEMATIC DESIGN



Parkhill
PARKHILL
4101 WIRELESS WAY, SUITE 350
OKLAHOMA CITY, OK 73134
(405) 832-9900
CIVIL ENGINEERING

Palmerton & Parrish, Inc.
4168 W. KEARNY ST.
SPRINGFIELD, MO 65803
(417) 864-6000
GEOTECHNICAL ENGINEERING

FEC HELIPORTS
5228 RIVER ROAD
CINCINNATI, OH 45233
(817) HELIPAD
HELIPAD DESIGN

hfsd
landscape architecture
HOWARD-FAIRBAIN SITE DESIGN
3100 NW 149TH ST
OKLAHOMA CITY, OK 73134
(405) 752-8018
LANDSCAPE ARCHITECTURE

HKS
999 18th St, #225N
DENVER, CO 80202
(303) 293-2903
INTERIOR ARCHITECTURE | INTERIOR DESIGN

Foy
Consulting & Engineering, LLC
6900 COLLEGE BLVD #600
OVERLAND, KS 66211
(913) 312-0075
STRUCTURAL ENGINEER

HP ENGINEERING
5504 PINNACLE POINTE DRIVE, SUITE 200
ROGERS, AR 72758
(479) 689-6370
MECHANICAL | ELECTRICAL | PLUMBING
LOW-VOLTAGE

Interior Logistics
1316 E 35TH PLACE, SUITE 100
TULSA, OK 74105
(918) 382-9120
EQUIPMENT | FURNITURE PLANING

MMOBLEY
FIRE PROTECTION
MOBLEY FIRE PROTECTION
6242 LLANO AVE.
DALLAS, TX 75214
(817) 614-2361
FIRE PROTECTION | LIFE SAFETY

FDP
2655 VILLA CREEK DR. #233
DALLAS, TX 75234
(972) 245-5300
FOOD SERVICE

ECOWORKS STUDIO
659 AUBURN AVE. NE, SUITE 135
ATLANTA, GA 30312
(404) 480-4499
LEED CONSULTING

James R. Childers Architect, Inc.
45 South 4th Street
Fort Smith, AR 72901
479-783-2460
www.childersarchitect.com

PROFESSIONAL SEAL:

CONSULTANT LOGO

CLIENT:

 
 
 
 
 
 
 
CHEROKEE NATION
W.W. HASTINGS REPLACEMENT HOSPITAL
TAHLEQUAH, OKLAHOMA

KEY PLAN:


PROJECT PHASE:
SCHEMATIC DESIGN

#	DATE	REVISIONS	DESCRIPTION

JOB NUMBER: 21-08.21
DATE: 05-06-2022
SHEET NUMBER:
SDG0.00
SHEET TITLE:
COVER SHEET



INDEX OF DRAWINGS - SCHEMATIC DESIGN	
SHEET NUMBER	SHEET NAME
SDG0.00	COVER SHEET
SDG0.01	DRAWING INDEX
CIVIL	
C0-102	GENERAL CIVIL NOTES
C0-001	PROJECT MAP
C3-101	OVERALL SITE VIEW
C3-102	A1 SITE PLAN
C3-103	A2 SITE PLAN
C3-104	B1 SITE PLAN
C3-105	B2 SITE PLAN
C3-106	C1 SITE PLAN
C3-107	C2 SITE PLAN
C3-108	P1 SITE PLAN
C3-109	P2 SITE PLAN
C3-110	P3 SITE PLAN
C3-111	P4 SITE PLAN
C3-112	P5 SITE PLAN
C3-501	SITE DETAILS
C3-502	SITE DETAILS
C3-503	CONCRETE PAVING JOINT DETAILS
C4-101	OVERALL UTILITY VIEW
C4-102	A1 UTILITIES
C4-103	A2 UTILITIES
C4-104	B1 UTILITIES
C4-105	B2 UTILITIES
C4-106	B2 UTILITIES
C4-107	C2 UTILITIES
C5-101	OVERALL GRADING VIEW
C5-102	A1 GRADING PLAN
C5-103	A2 GRADING PLAN
C5-104	B1 GRADING PLAN
C5-105	B2 GRADING PLAN
C5-106	C1 GRADING PLAN
C5-107	C2 GRADING PLAN
C5-108	P1 GRADING PLAN
C5-109	P2 GRADING PLAN
C5-110	P3 GRADING PLAN
C5-111	P4 GRADING PLAN
C5-112	P5 GRADING PLAN
C5-201	SEWER PLAN AND PROFILE
ARCHITECTURAL	
S00.01	PROJECT INFORMATION
S00.02	BUILDING SQUARE FOOTAGE
SD1.00	SITE PLAN
SD1.01	LEVEL 01 - OVERALL
SD1.02	LEVEL 02 - OVERALL
SD1.03	LEVEL 03 - OVERALL
SD1.04	LEVEL 04 - OVERALL
SD1.05	LEVEL 0500 - OVERALL
SD1.06	OVERALL HIGH ROOF/HELIPAD
S02.01	OVERALL EXTERIOR ELEVATIONS
S02.02	OVERALL EXTERIOR ELEVATIONS
S02.03	EXTERIOR PERSPECTIVES
S02.04	EXTERIOR PERSPECTIVES
S02.05	EXTERIOR PERSPECTIVES
S03.00	STACKING DIAGRAM
S03.01	BUILDING SECTIONS
S03.02	TYPICAL WALL SECTION & DETAILS
SD4.01	LEVEL 01 - ROOM SCHEDULE
SD4.02	LEVEL 02 - ROOM SCHEDULE
SD4.03	LEVEL 03 - ROOM SCHEDULE
SD4.04	LEVEL 04 - ROOM SCHEDULE
SD4.05	LEVEL 0500 - ROOM SCHEDULE
LIFE SAFETY	
LS.00	LIFE SAFETY CODE SUMMARY
LS.01	LIFE SAFETY PLAN - LEVEL 01
LS.02	LIFE SAFETY PLAN - LEVEL 02
LS.03	LIFE SAFETY PLAN - LEVEL 03
LS.04	LIFE SAFETY PLAN - LEVEL 04
LS.05	LIFE SAFETY PLAN - LEVEL 05
LS.06	LIFE SAFETY PLAN - LEVEL 06
LS.07	LIFE SAFETY PLAN - ROOF/HELIPAD
MECHANICAL	
M-S00.05	CEP PLAN
M-S00.10	CEP MEZZANINE PLAN
M-S01.00	LEVEL 1 HVAC PLAN
M-S01.10	LEVEL 2 HVAC PLAN
M-S01.20	LEVEL 3 HVAC PLAN
M-S01.30	LEVEL 4 HVAC PLAN
M-S01.40	LEVEL 5, 6 & ROOF HVAC PLAN
M-S03.00	LEVEL 1 AHU ZONE DIAGRAM
M-S03.10	LEVEL 2 AHU ZONE DIAGRAM
M-S03.20	LEVEL 3 AHU ZONE DIAGRAM
M-S03.30	LEVEL 4 AHU ZONE DIAGRAM
M-S03.40	LEVEL 5&6 AHU ZONE DIAGRAMS
M-S04.00	AHU RISER DIAGRAM
M-S04.01	AHU 3D
FIRE ALARM	
FA-600	FIRE ALARM - RISER DIAGRAM
FIRE PROTECTION	
FP-600	FIRE PROTECTION - RISER DIAGRAM
EQUIPMENT	
EQ1.0	LEVEL 1/ED
EQ1.1	PROPERTY & SUPPLY FACILITIES MAN/CLINICAL ENGINEERING
EQ2.0	PHARMACY LAYOUT REVISED
EQ2.1	LAB/ STERILE PROCESSING
EQ3.0	ADMIN HEALTH EDUC IT
EQ4.0	LDRPPN/CIN/URS/RYC-SECTION
EQ5.0	ACUTE CARE/MS/PHYS. THER.
EQ6.0	TYPICALS EQUIPMENT LAYOUTS
FOOD SERVICE	
K1	FS EQUIPMENT PLAN
K1.6	FS EXHAUST HOODS
K1.7	FS CONDENSING UNITS
K1.8	FS WALK-INS
K1.8.1	FS WALK-INS
HELIPAD	
H-1	HELISTOP GENERAL ARRANGEMENT
Grand Total: 99	

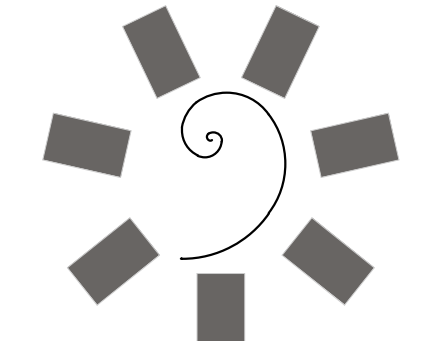

James R. Childers
Architect, Inc.
45 South 4th Street
Fort Smith, AR 72901
479-783-2450
www.childersarchitect.com

PROFESSIONAL SEAL:

CONSULTANT LOGO

CLIENT:


CHEROKEE NATION
NAT. 6, 1959

CHEROKEE NATION

W.W. HASTINGS REPLACEMENT HOSPITAL

TAHLEQUAH, OKLAHOMA

KEY PLAN:

PROJECT PHASE:
SCHEMATIC DESIGN

#	DATE	REVISIONS	DESCRIPTION

JOB NUMBER: 21-08.21

DATE: 05-06-2022

SHEET NUMBER:

SDG0.01

SHEET TITLE:

DRAWING INDEX