




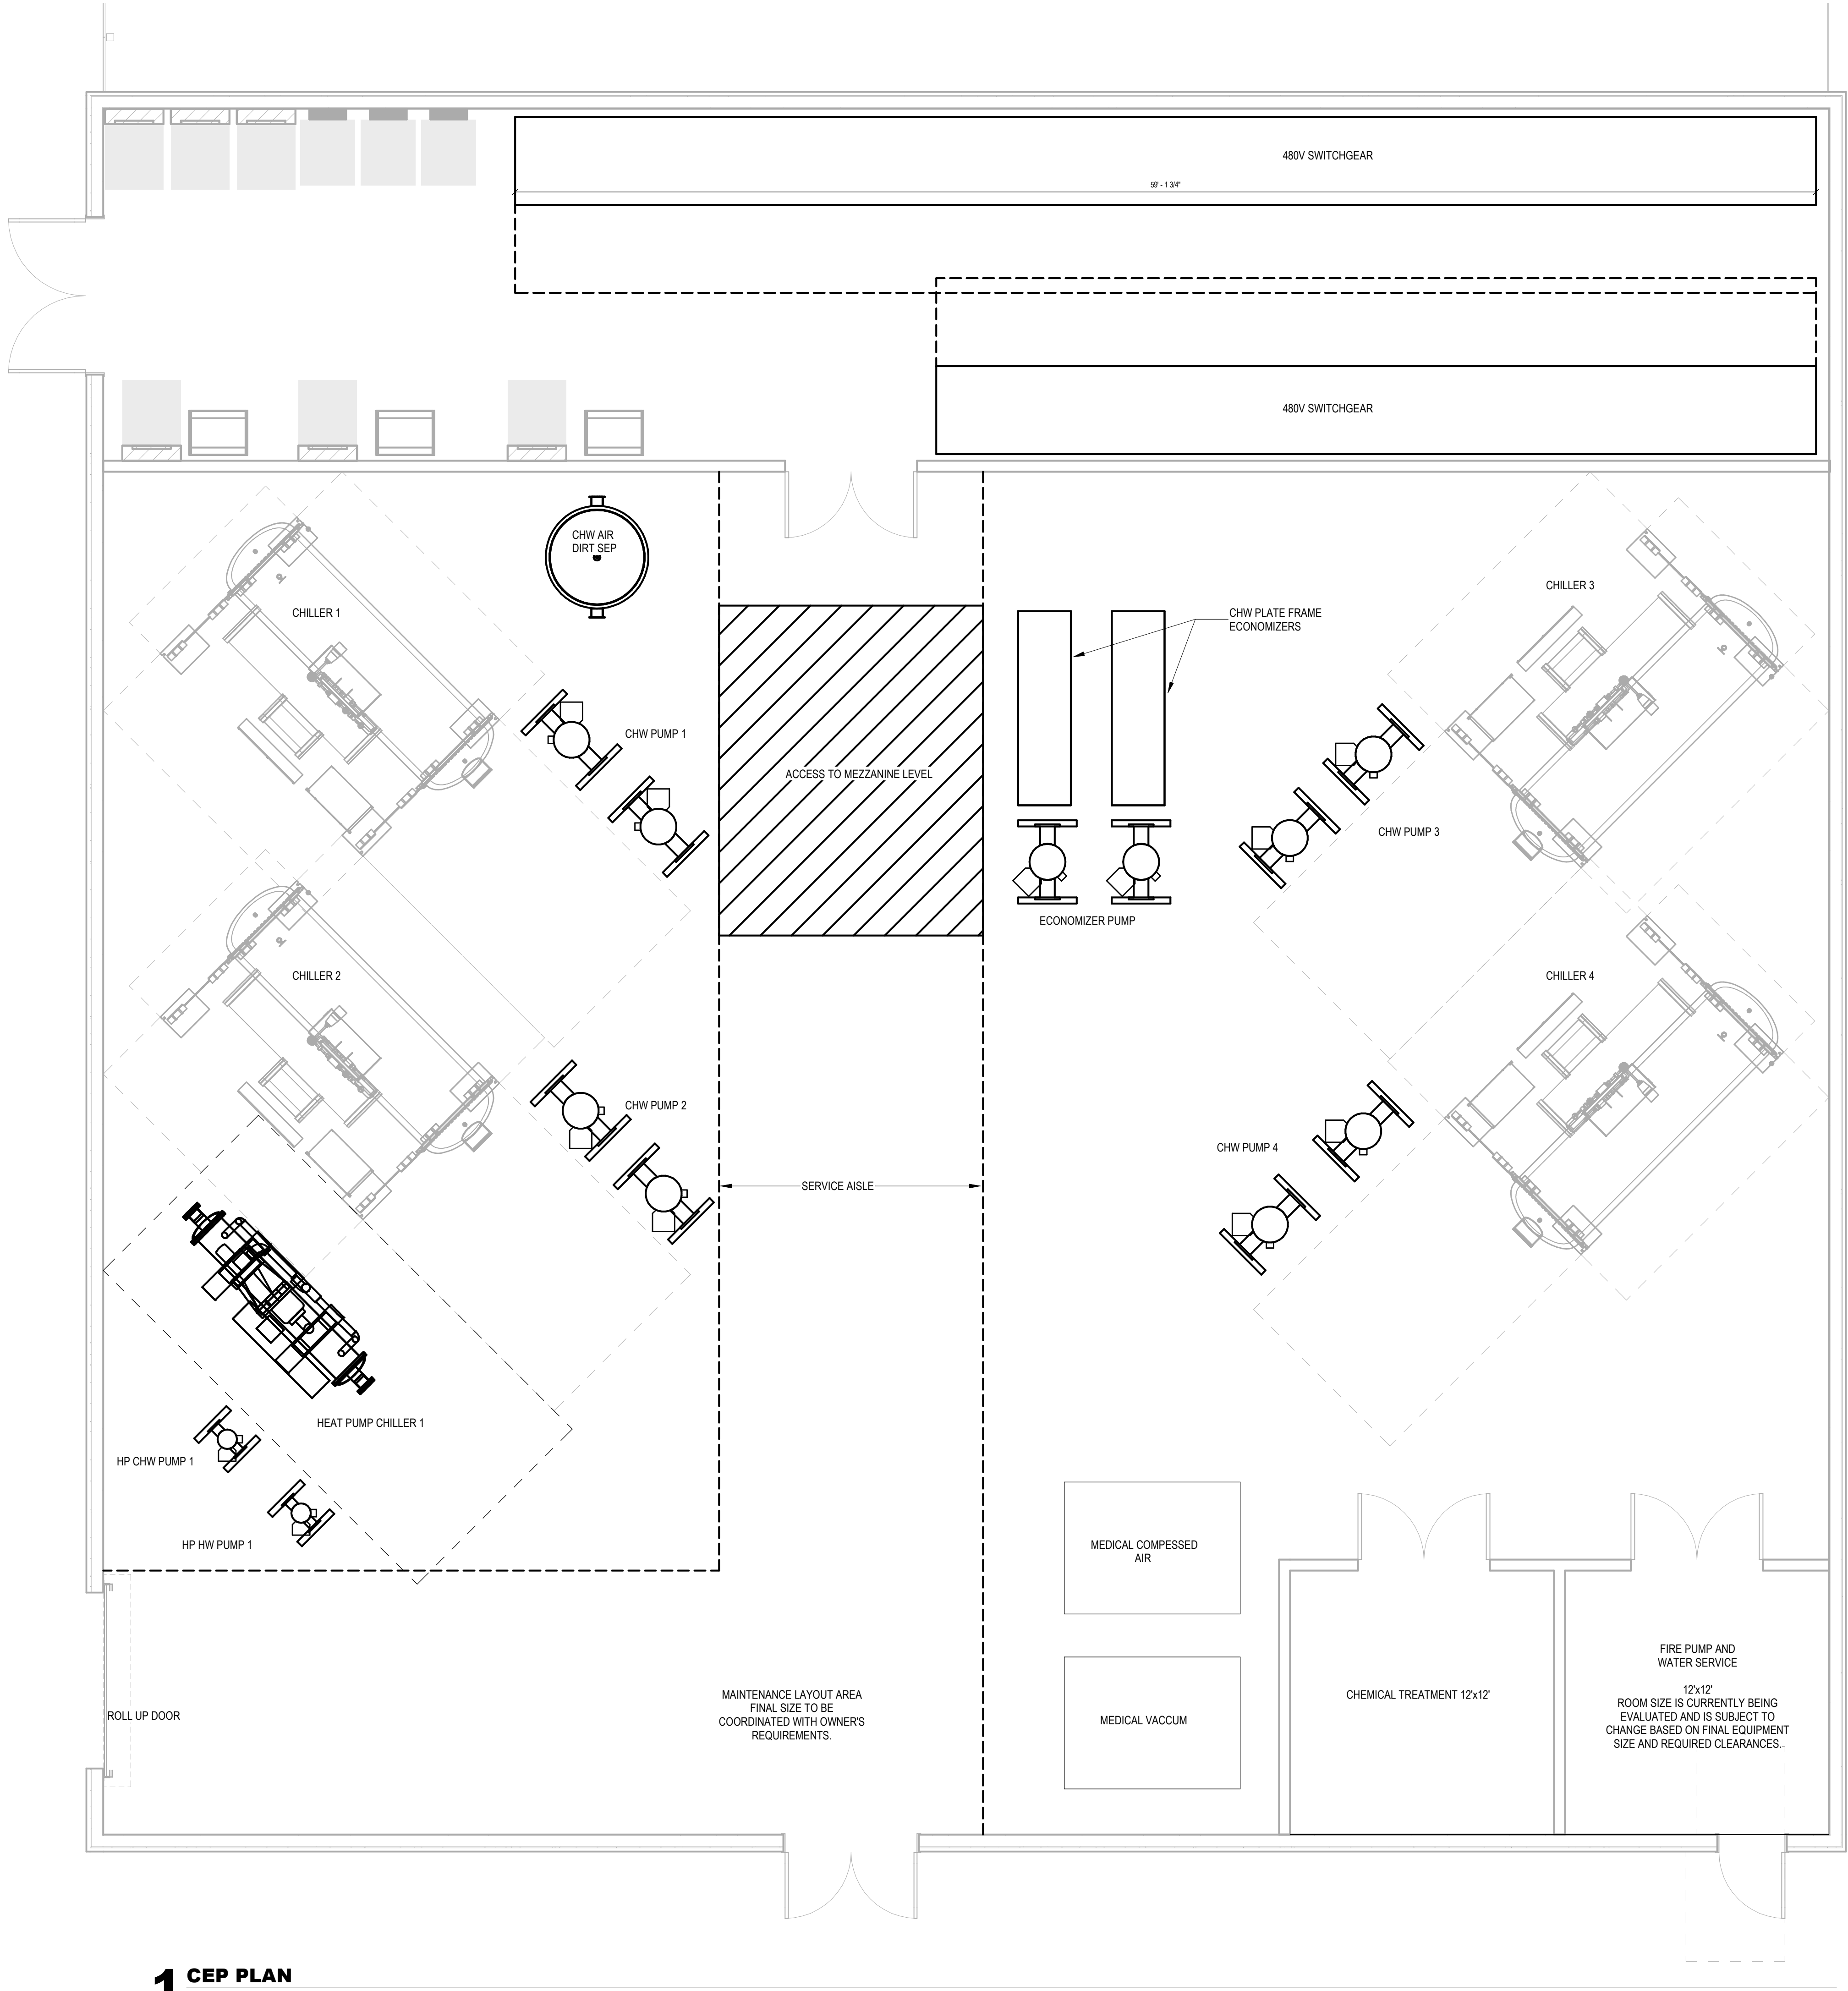

1 CEP PLAN
1/4" = 1'-0"

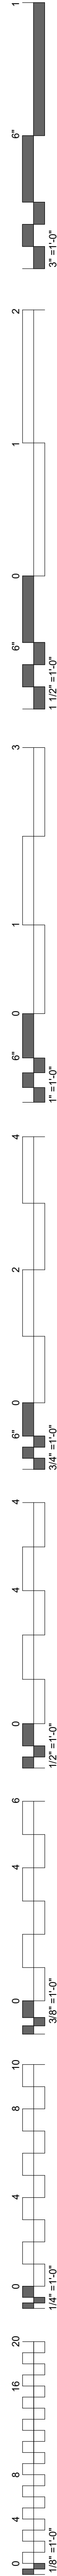


**James R. Childers
Architect, Inc.**
45 South 4th Street
Fort Smith, AR 72901
479-783-2450
www.childersarchitect.com

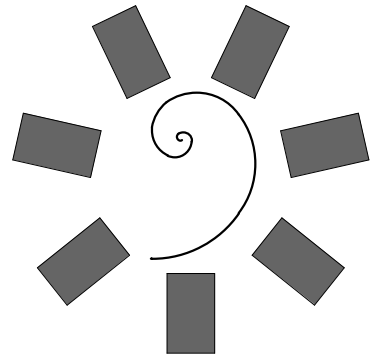


CONSULTANT LOGO

HP ENGINEERING
PROJECT NO. 211808R
HP ENGINEERING INC.
5504 W. PINNACLE POINTE DRIVE
SUITE 200
ROGERS, AR 72758
(479) 899-6370
www.hpengeeringinc.com

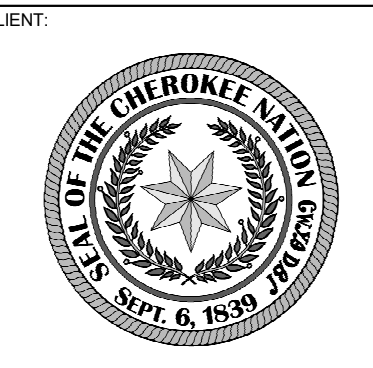



CHEROKEE NATION
W.W. HASTINGS REPLACEMENT HOSPITAL
TAHLEQUAH, OKLAHOMA

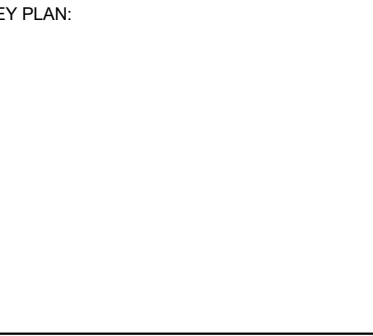

PROJECT PHASE:
SCHEMATIC DESIGN

#	DATE	REVISIONS	DESCRIPTION

 JOB NUMBER: 21-08.21
DATE: 05-06-2022
SHEET NUMBER:
M-SD0.05
SHEET TITLE:
CEP PLAN

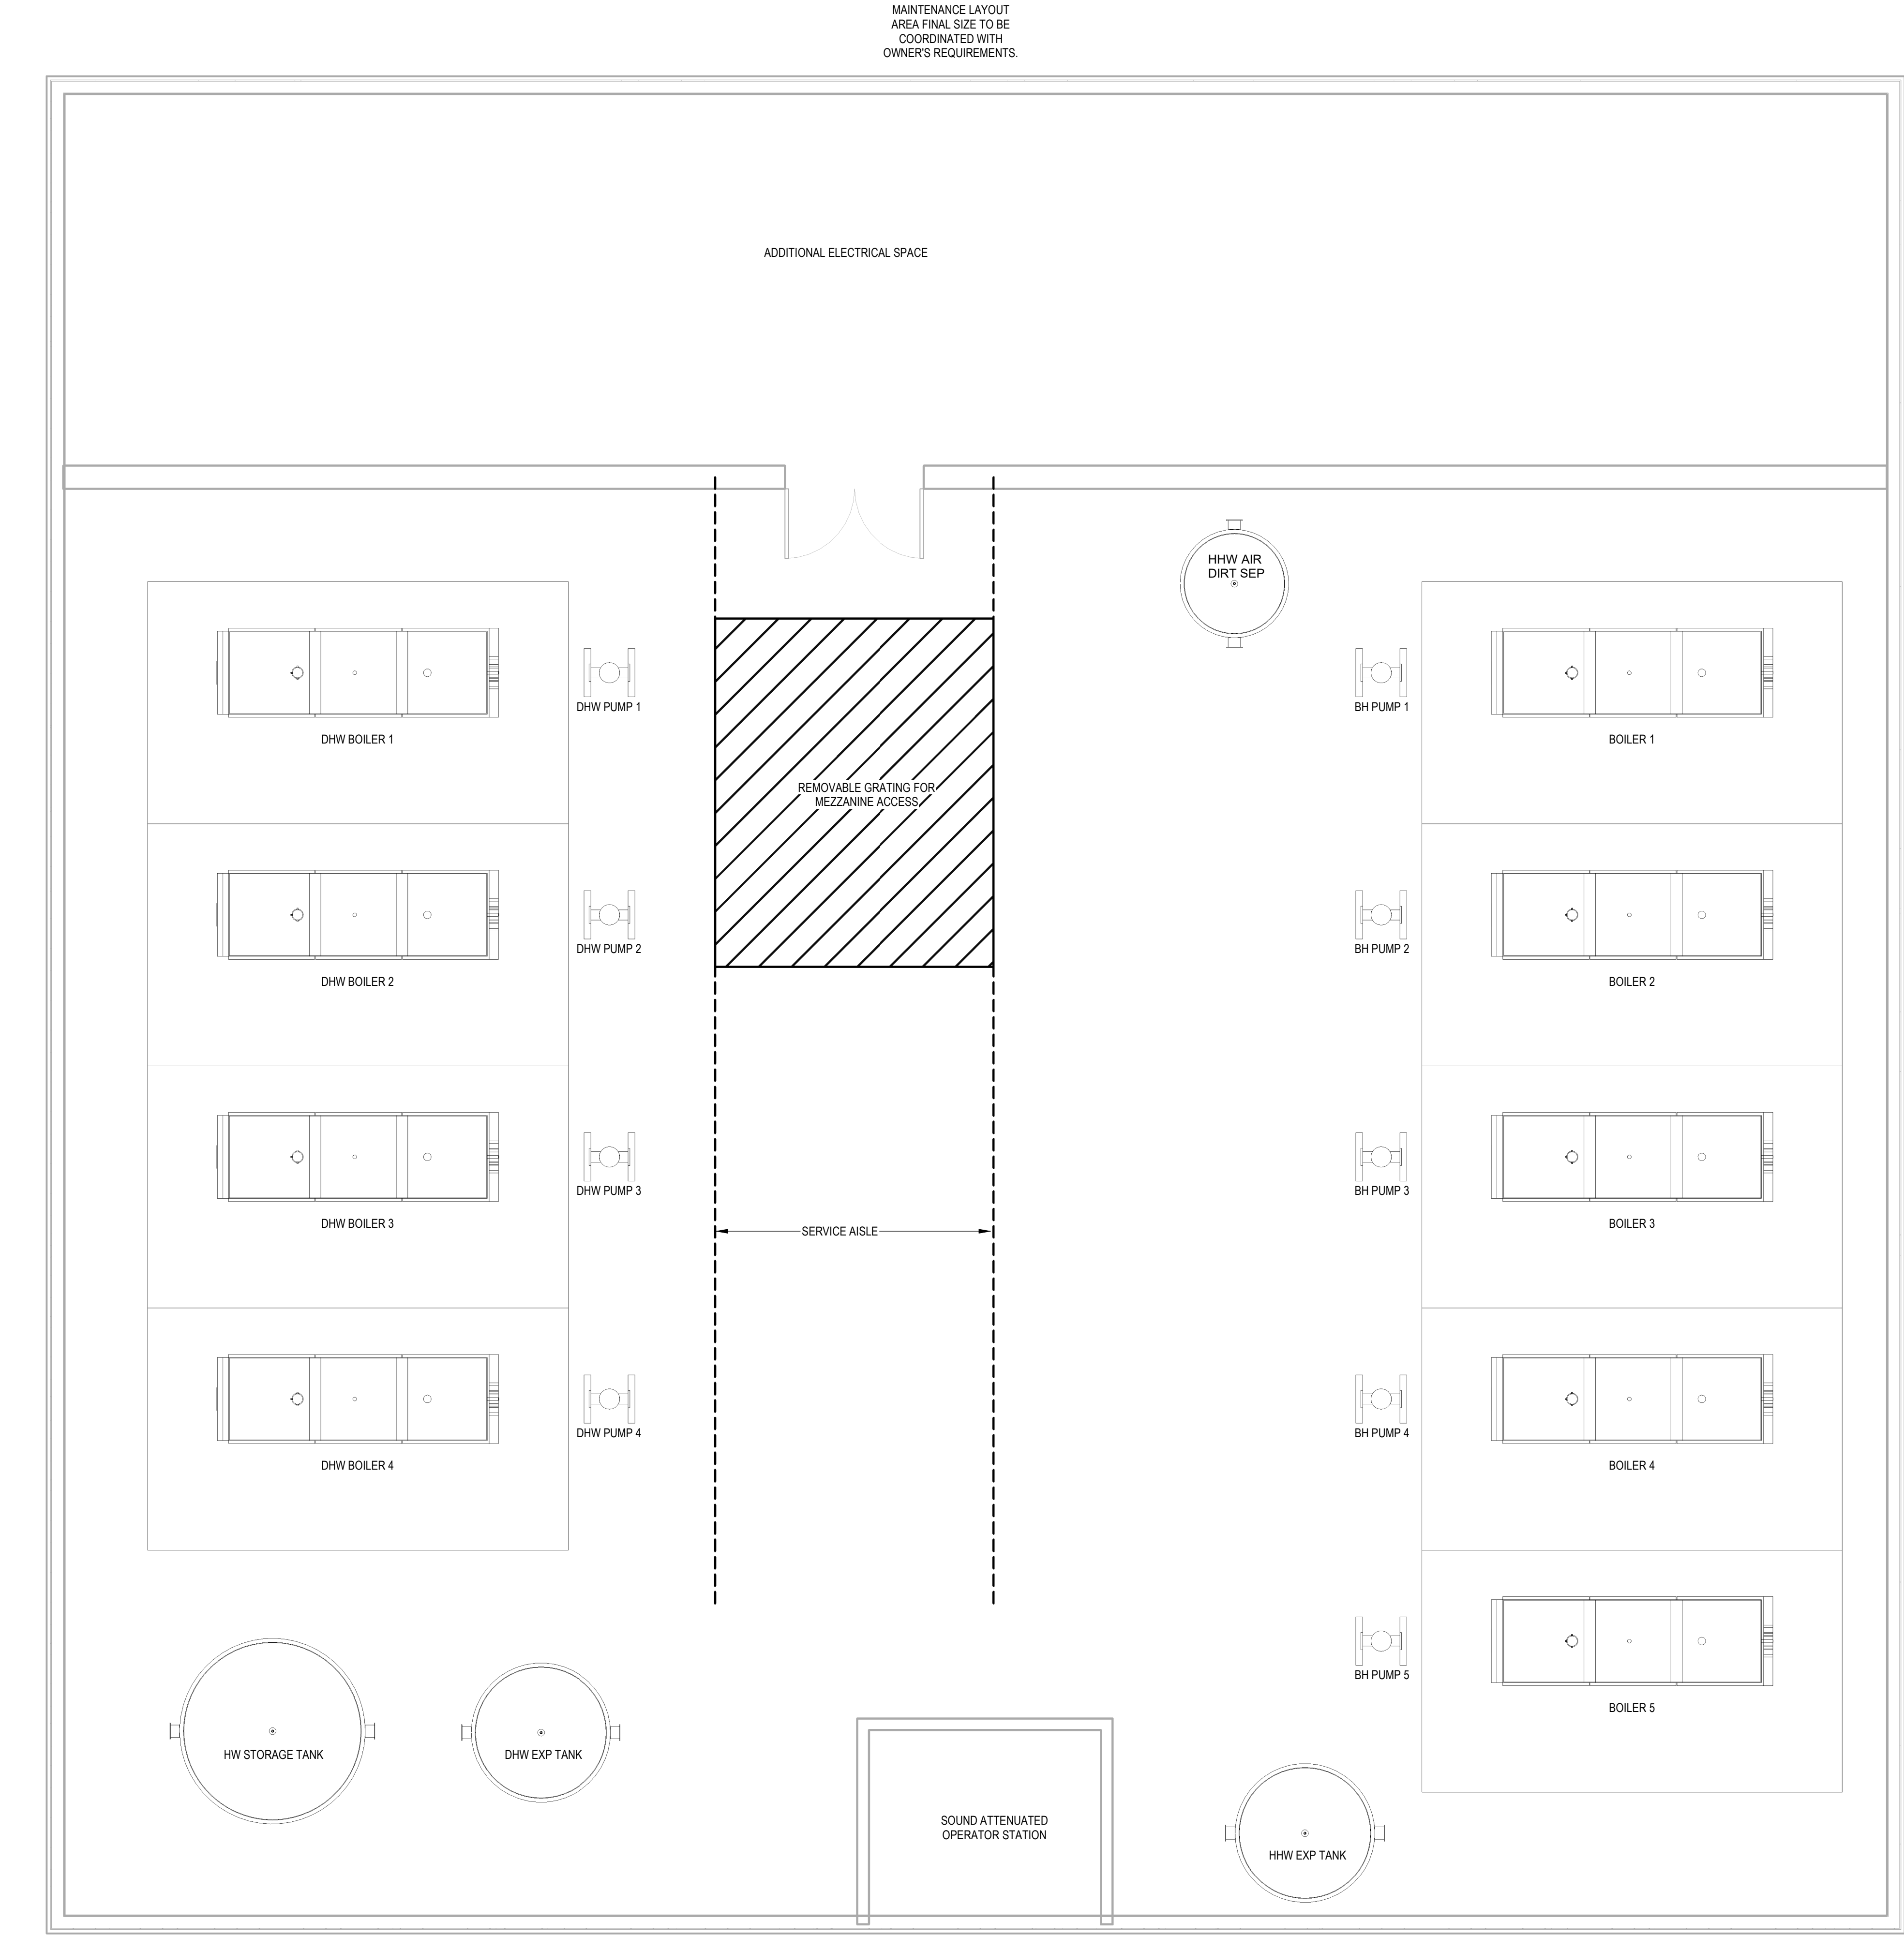

1 CEP MEZZANINE PLAN
1/4" = 1'-0"

**James R. Childers
Architect, Inc.**
45 South 4th Street
Fort Smith, AR 72901
479-783-2450
www.childersarchitect.com

PROFESSIONAL SEAL:

HP ENGINEERING
PROJECT NO. 211808R
HP ENGINEERING INC.
5504 W. PINNACLE POINTE DRIVE
SUITE 200
ROGERS, AR 72758
(479) 899-6370
www.hpengeeringinc.com

CLIENT:

CHEROKEE NATION
W.W. HASTINGS REPLACEMENT HOSPITAL
TAHLEQUAH, OKLAHOMA

KEY PLAN:

PROJECT PHASE:

SCHEMATIC DESIGN




#	DATE	REVISIONS DESCRIPTION

JOB NUMBER: 21-08.21

DATE: 05-06-2022



SHEET NUMBER:
M-SD0.10

SHEET TITLE:
CEP MEZZANINE PLAN

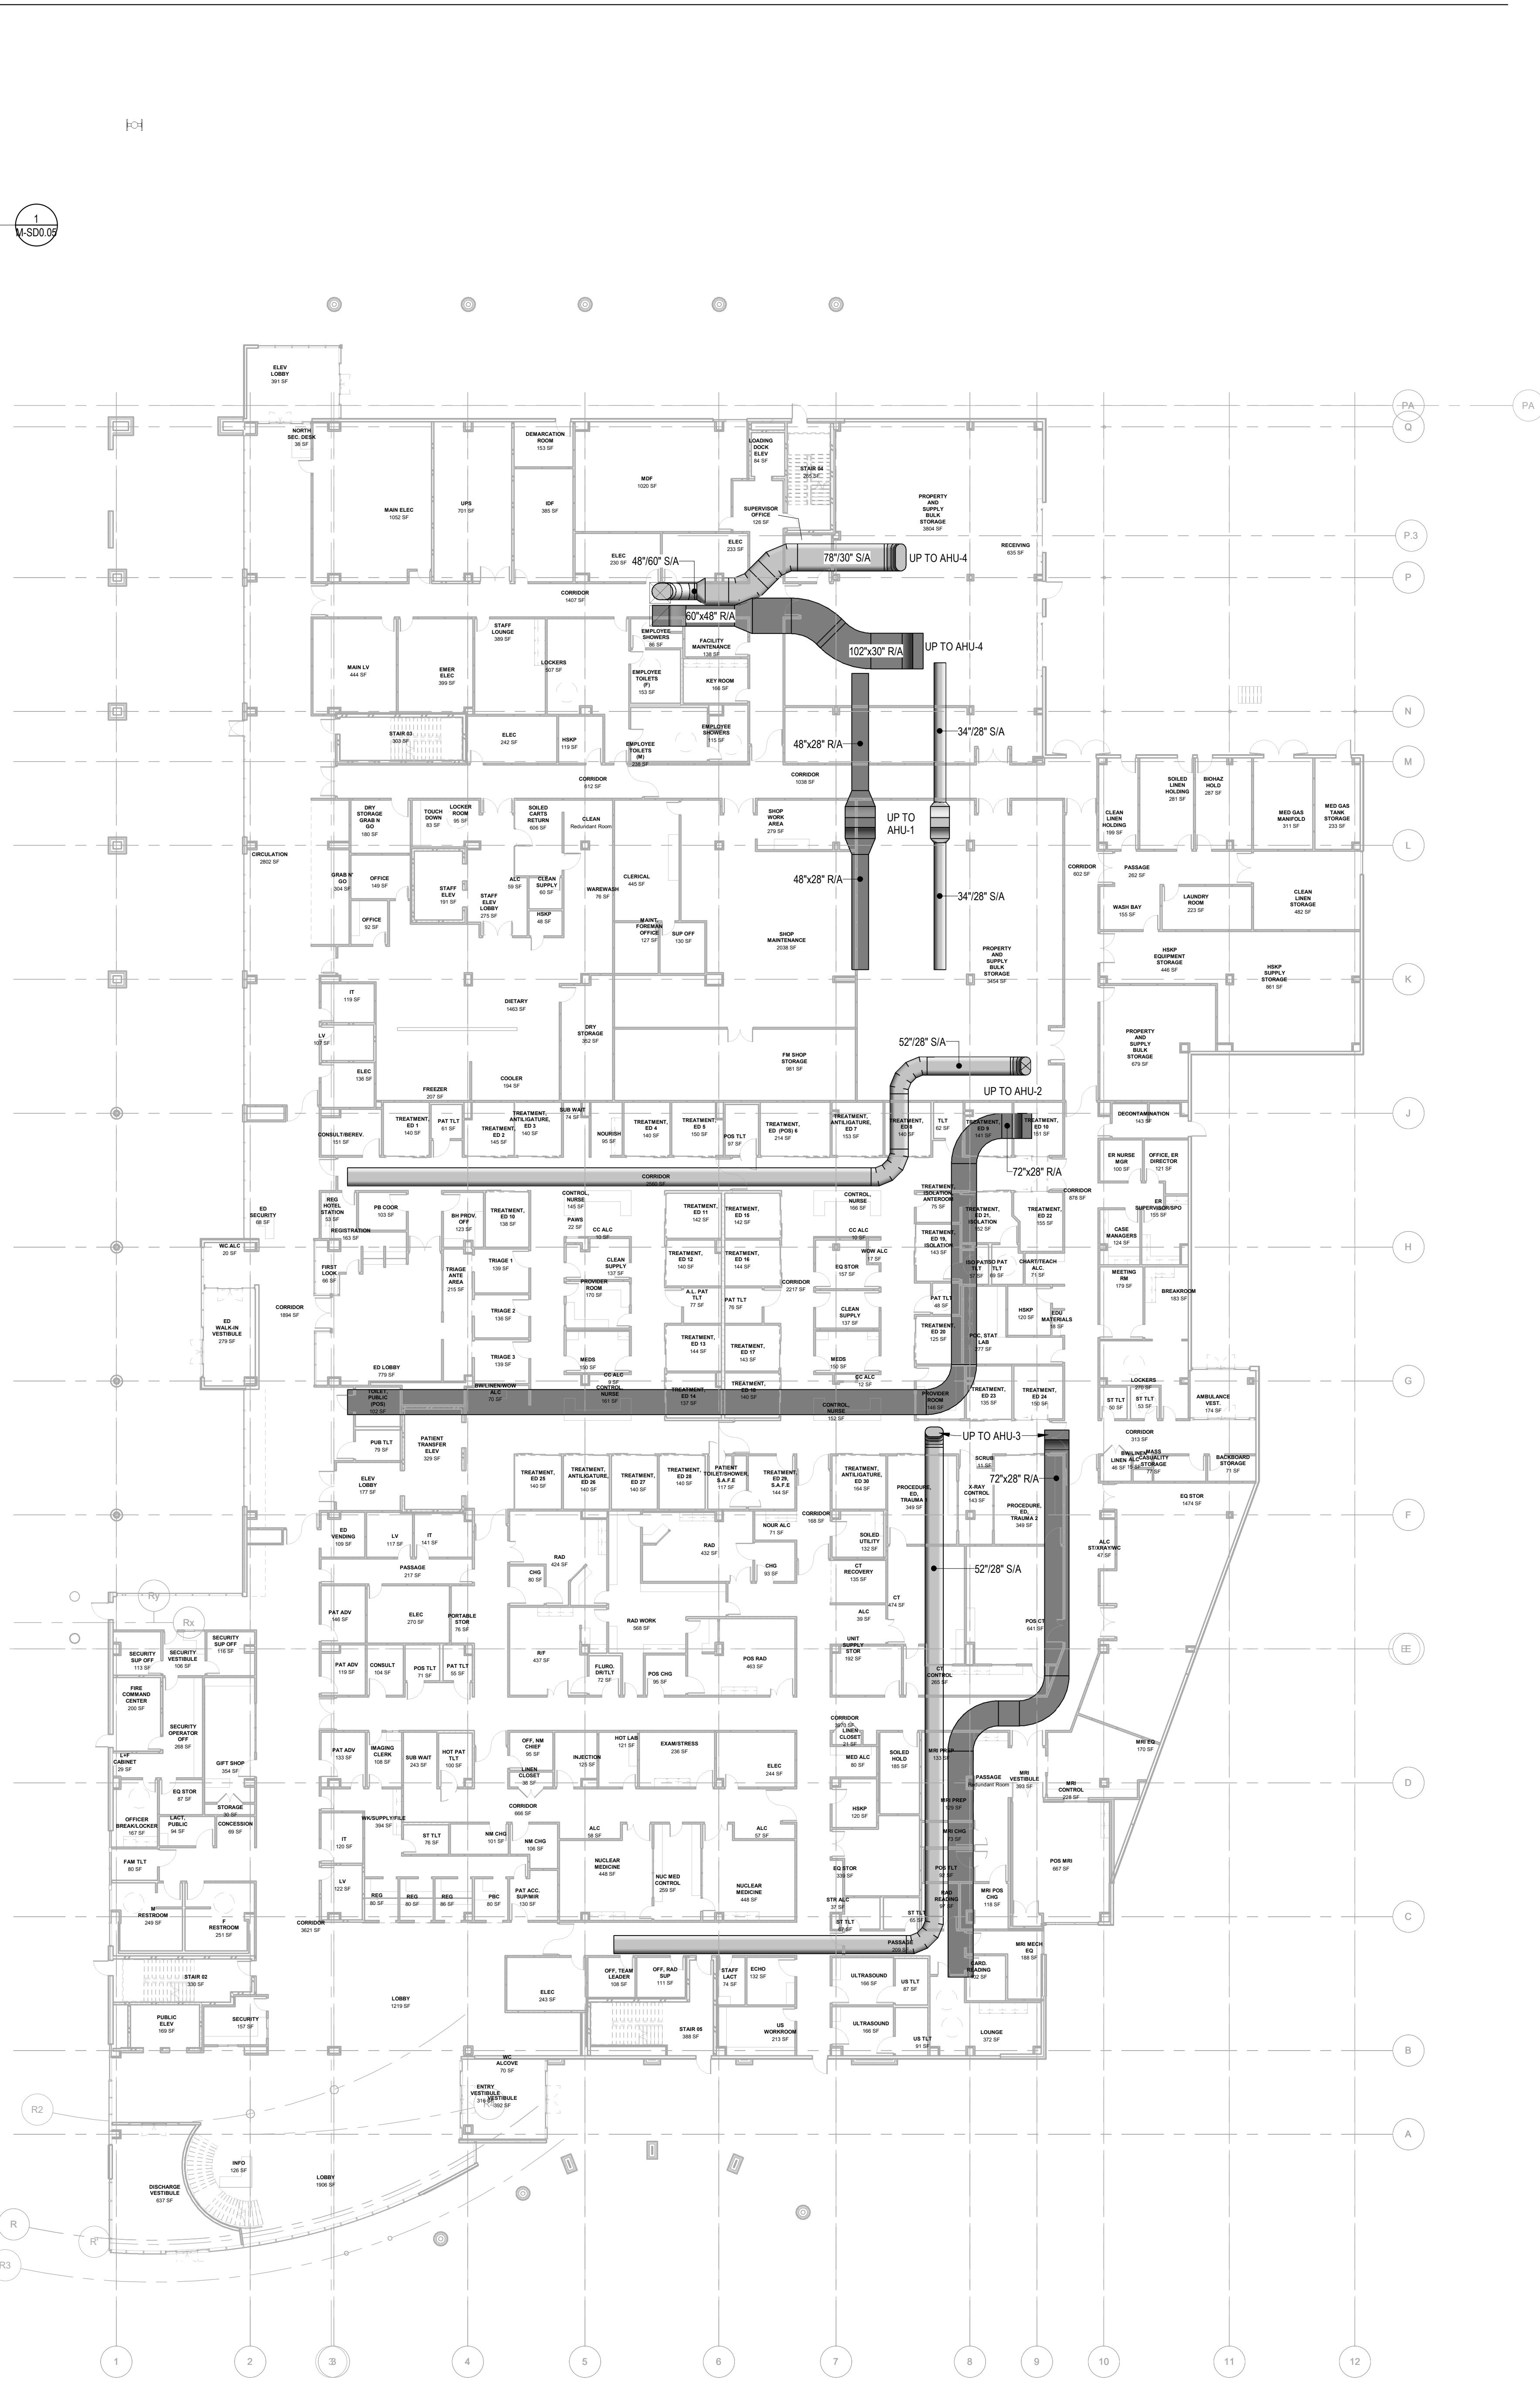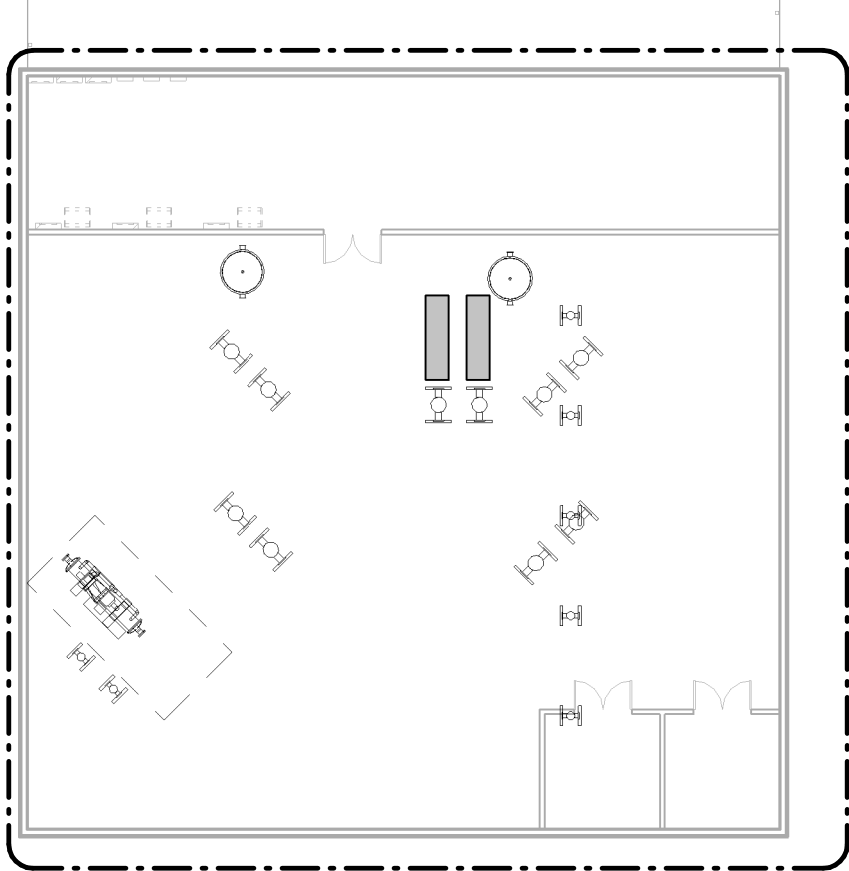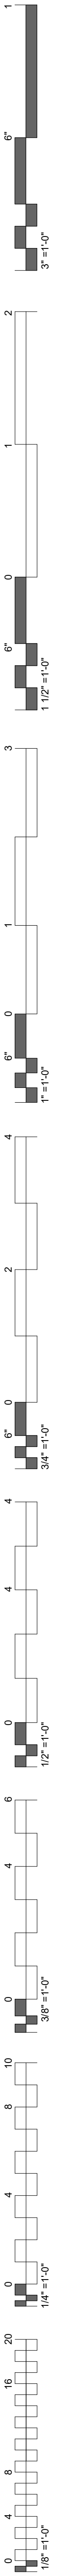



1 LEVEL 1 HVAC PLAN
1" = 20'-0"

#	DATE	REVISIONS	DESCRIPTION

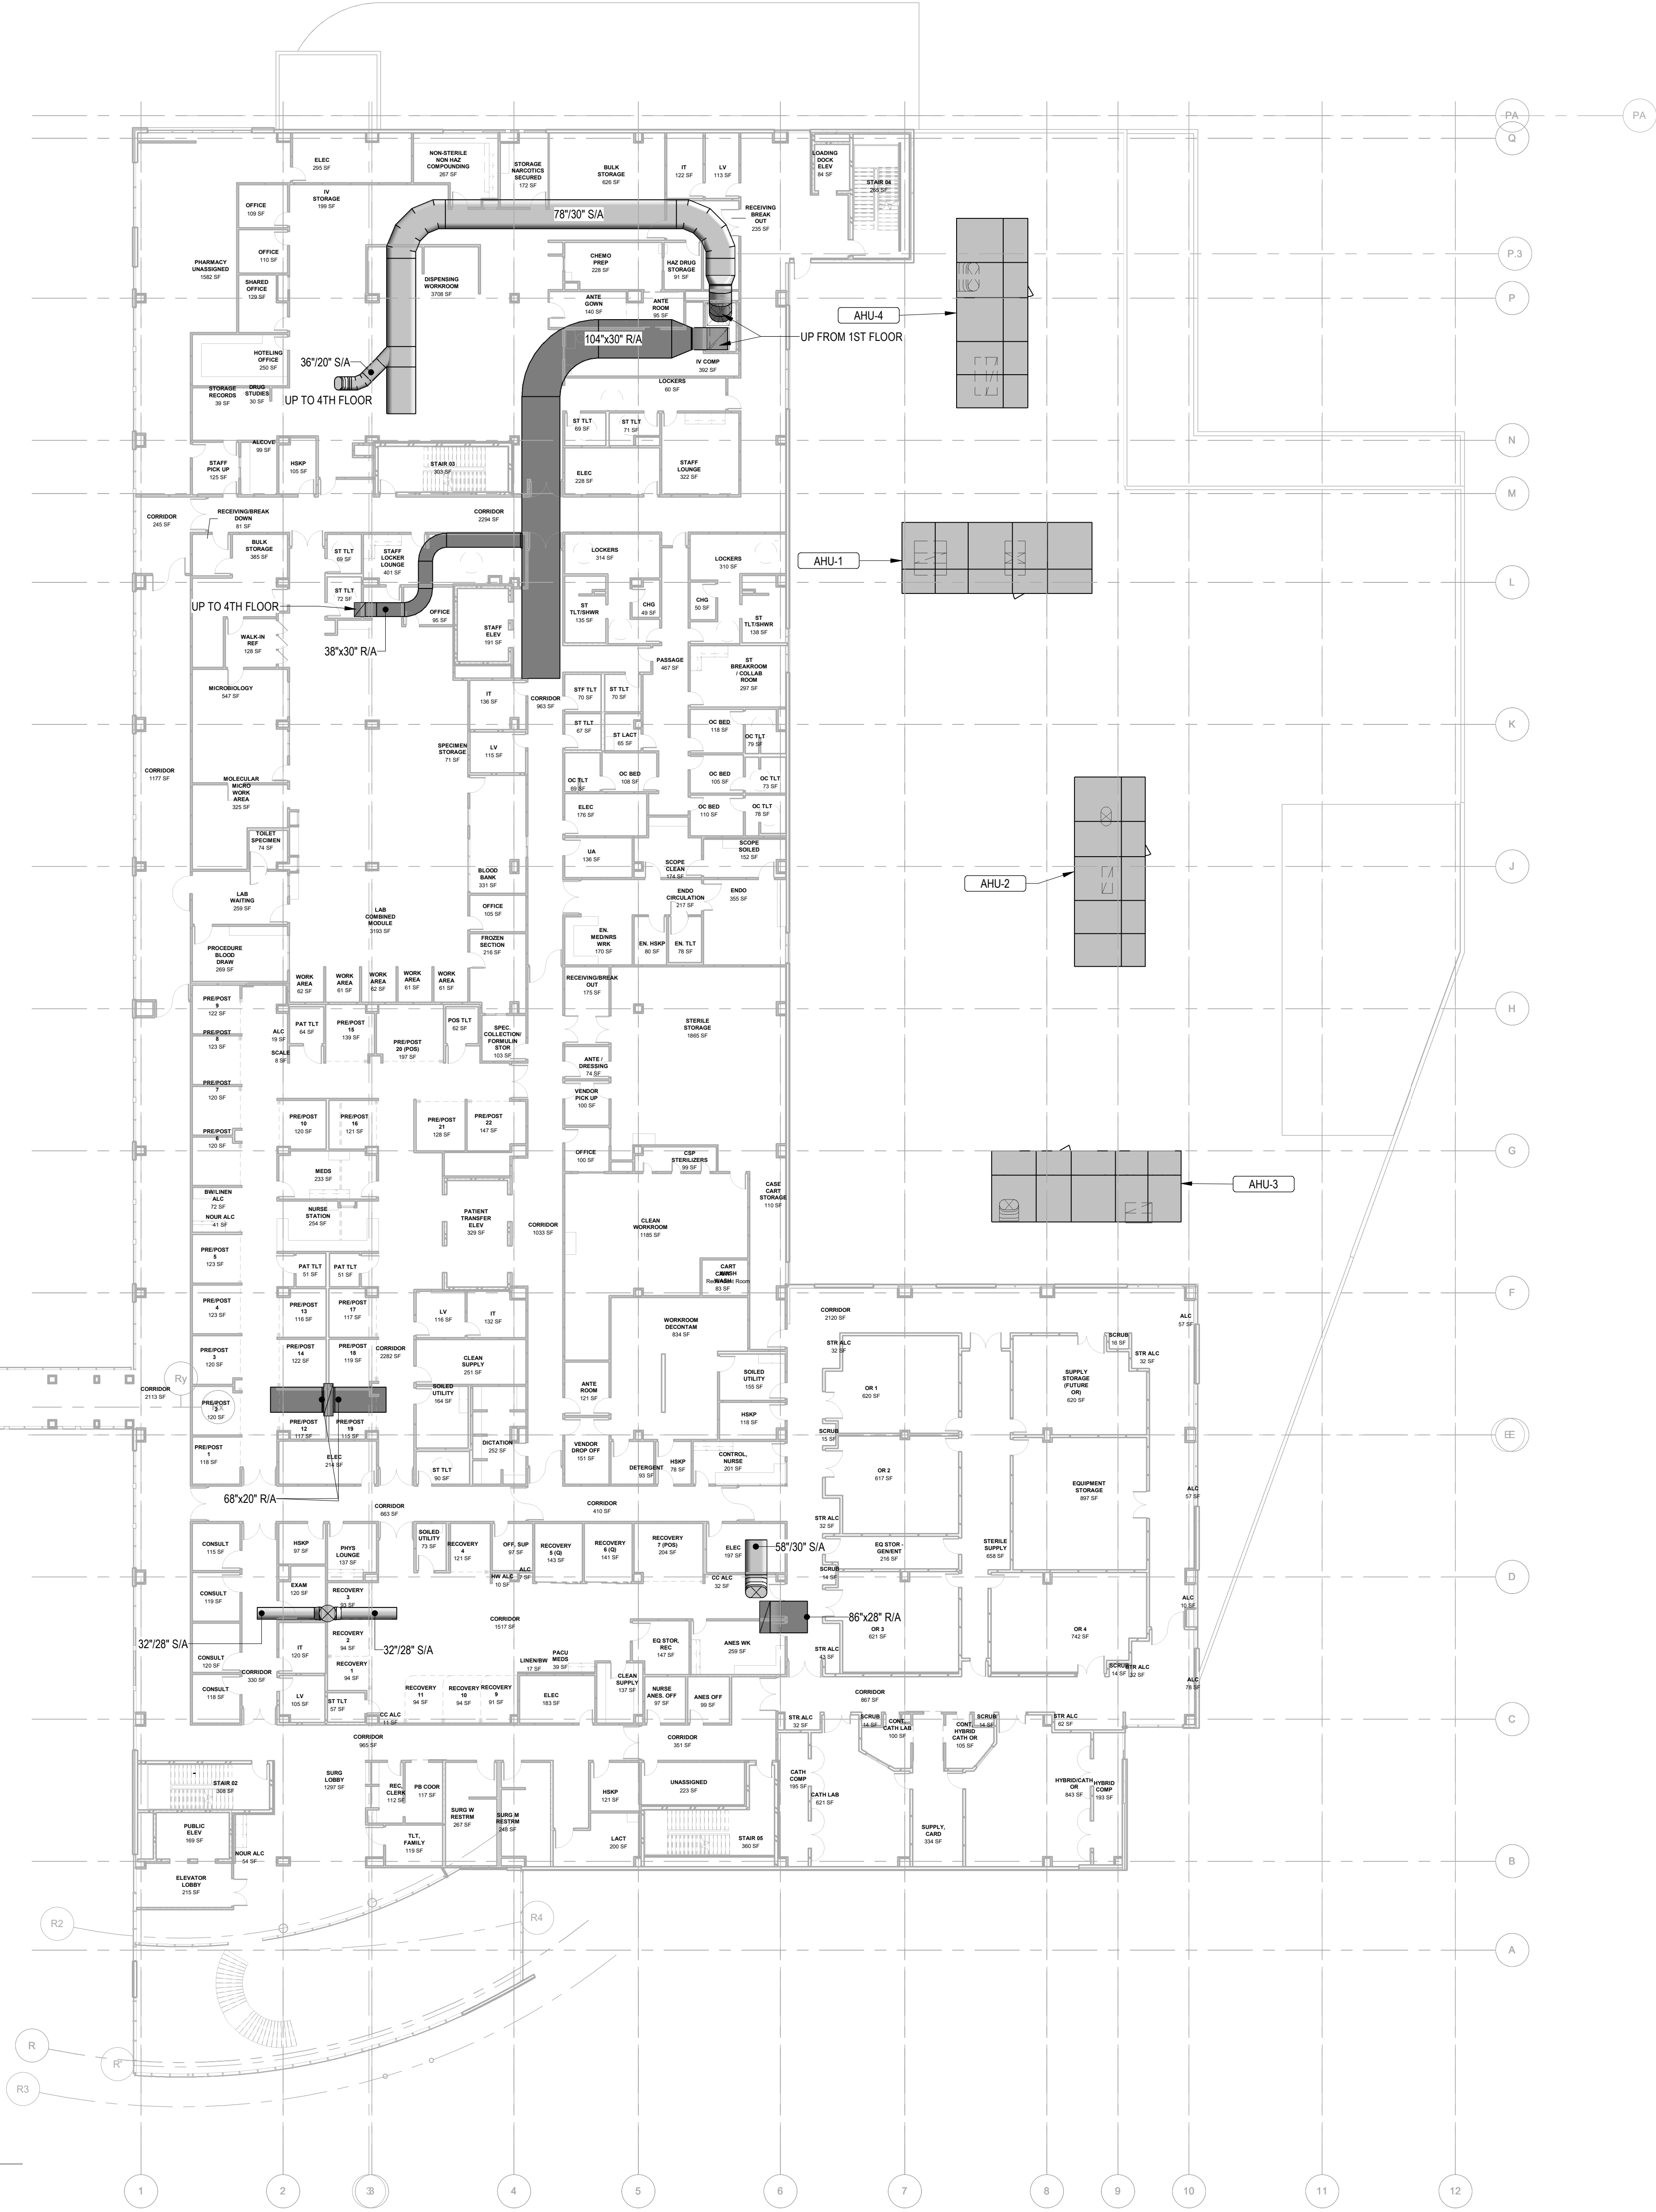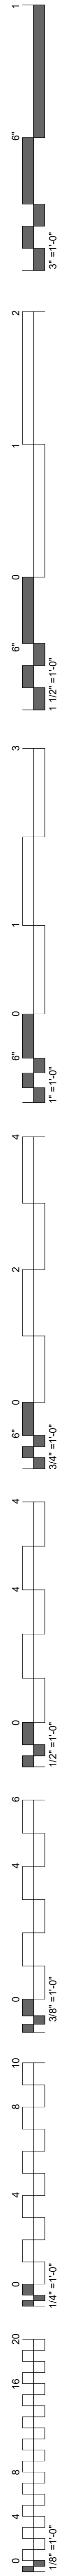

1 LEVEL 2 HVAC PLAN
1" = 20'-0"

#	DATE	REVISIONS	DESCRIPTION

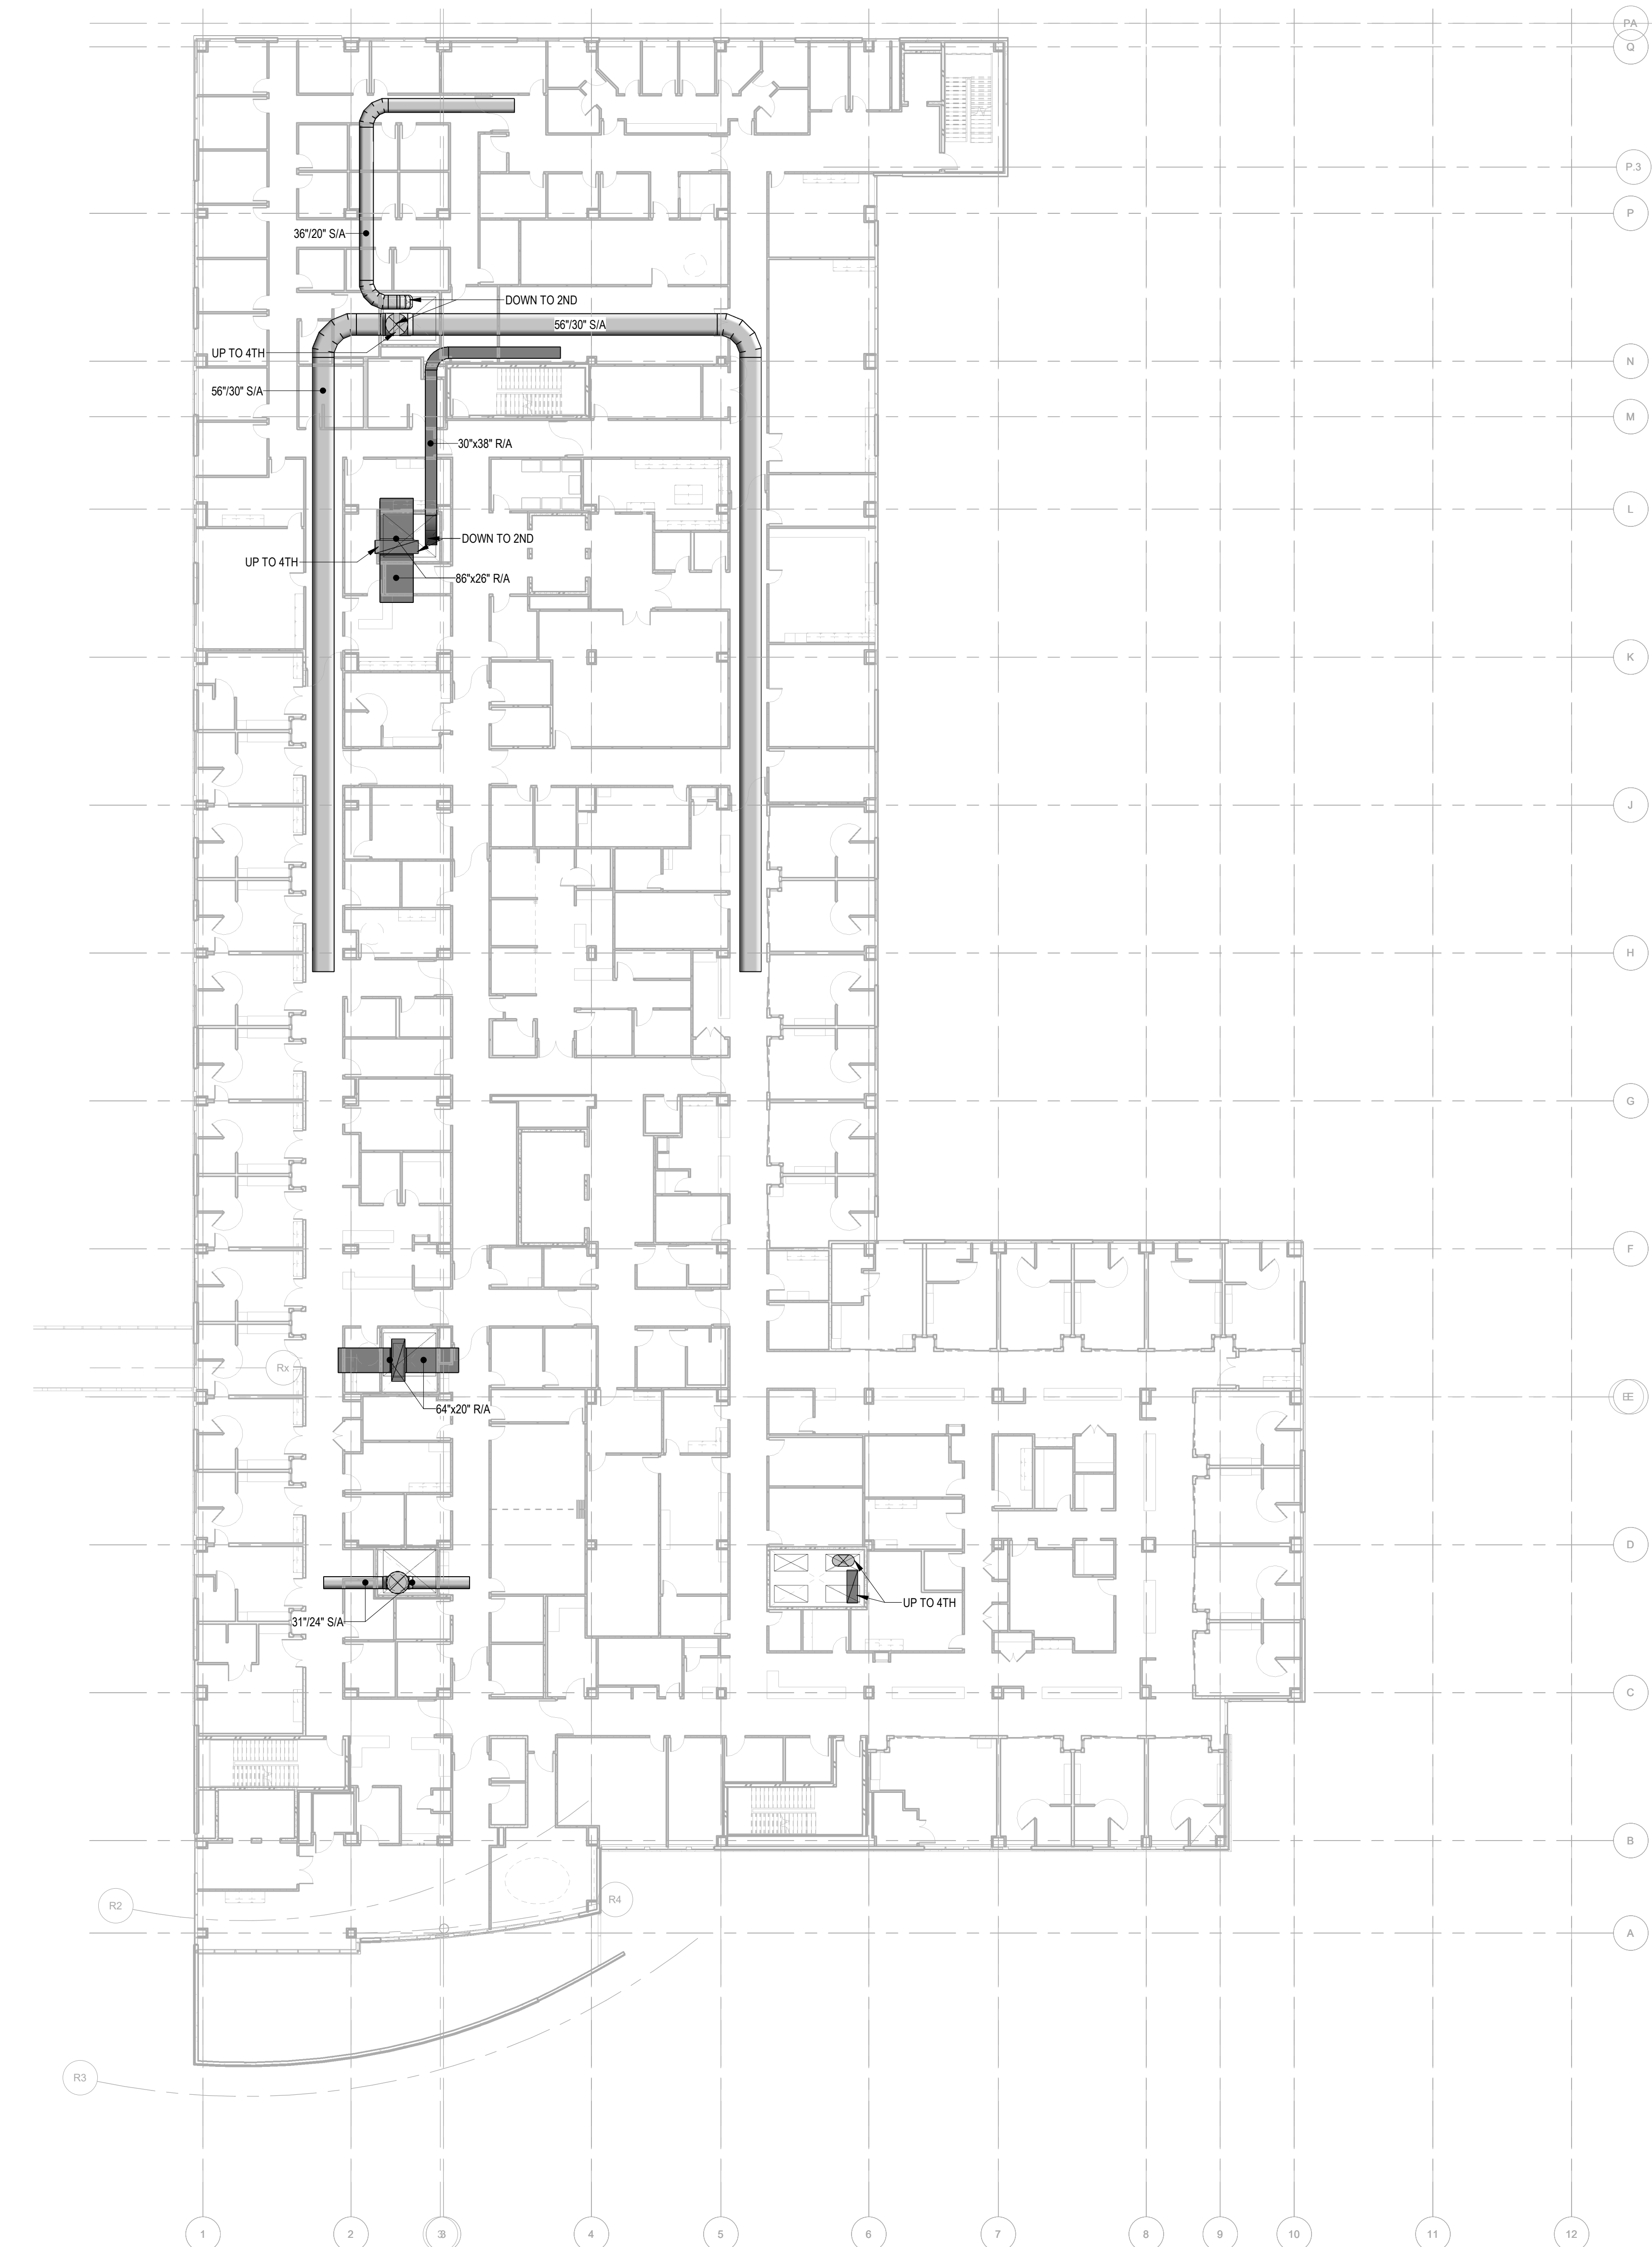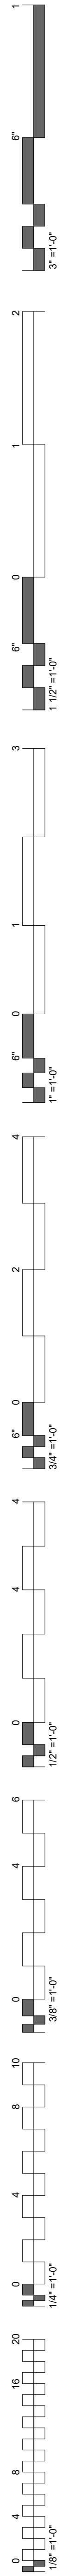


1 LEVEL 3 HVAC PLAN
1" = 20'-0"

CHEROKEE NATION
W.W. HASTINGS REPLACEMENT HOSPITAL
TAHLEQUAH, OKLAHOMA


KEY PLAN:

PROJECT PHASE:
SCHEMATIC DESIGN


#	DATE	REVISIONS	DESCRIPTION

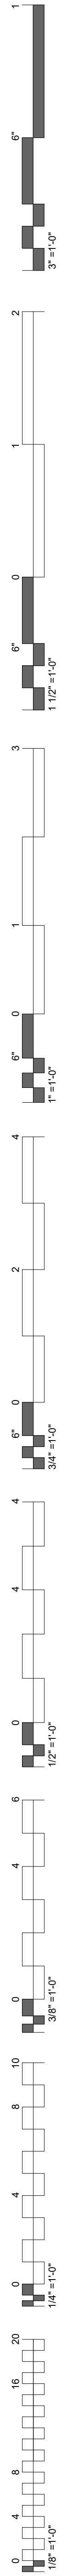


1 LEVEL 4 HVAC PLAN
1" = 20'-0"

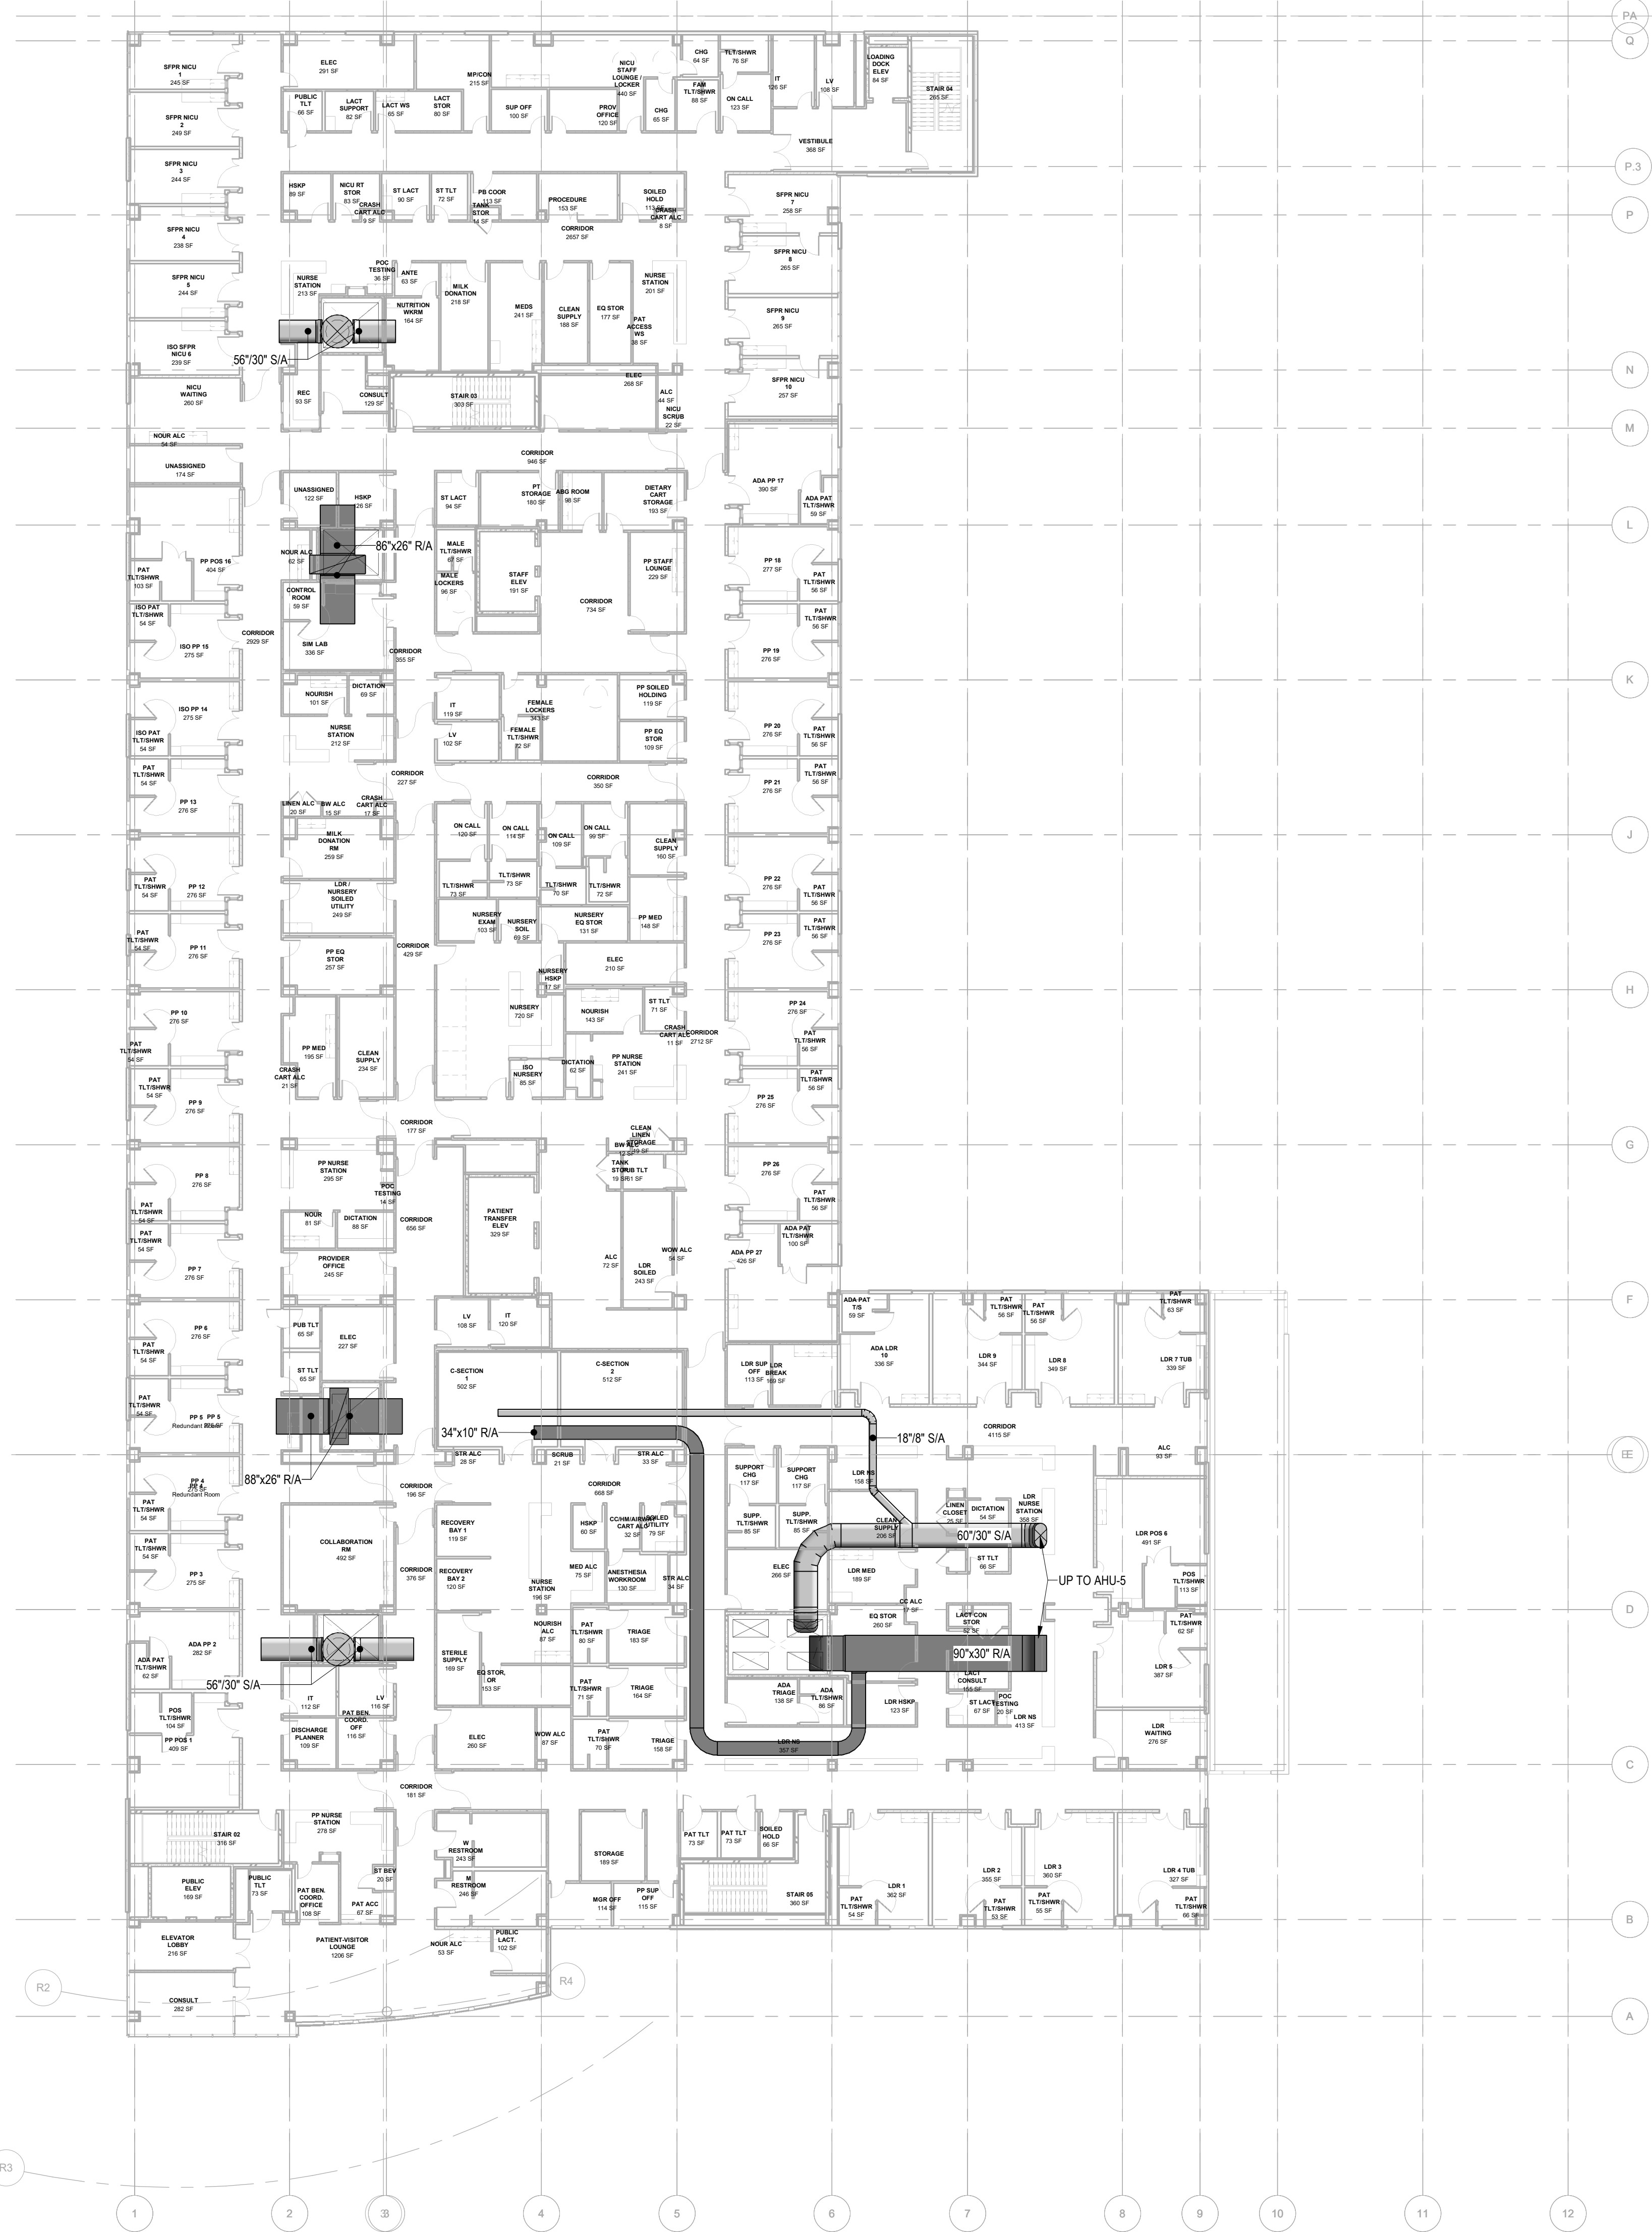

#	DATE	REVISIONS	DESCRIPTION

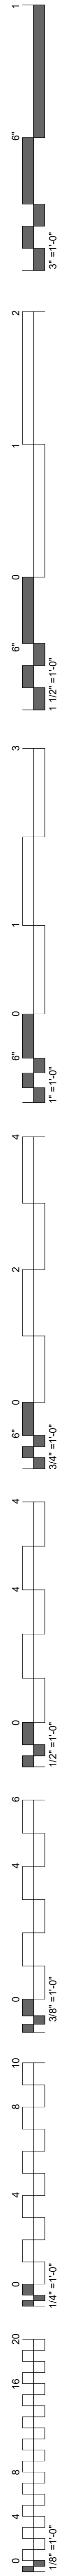


3 LEVEL 5 HVAC PLAN
1" = 20'-0"

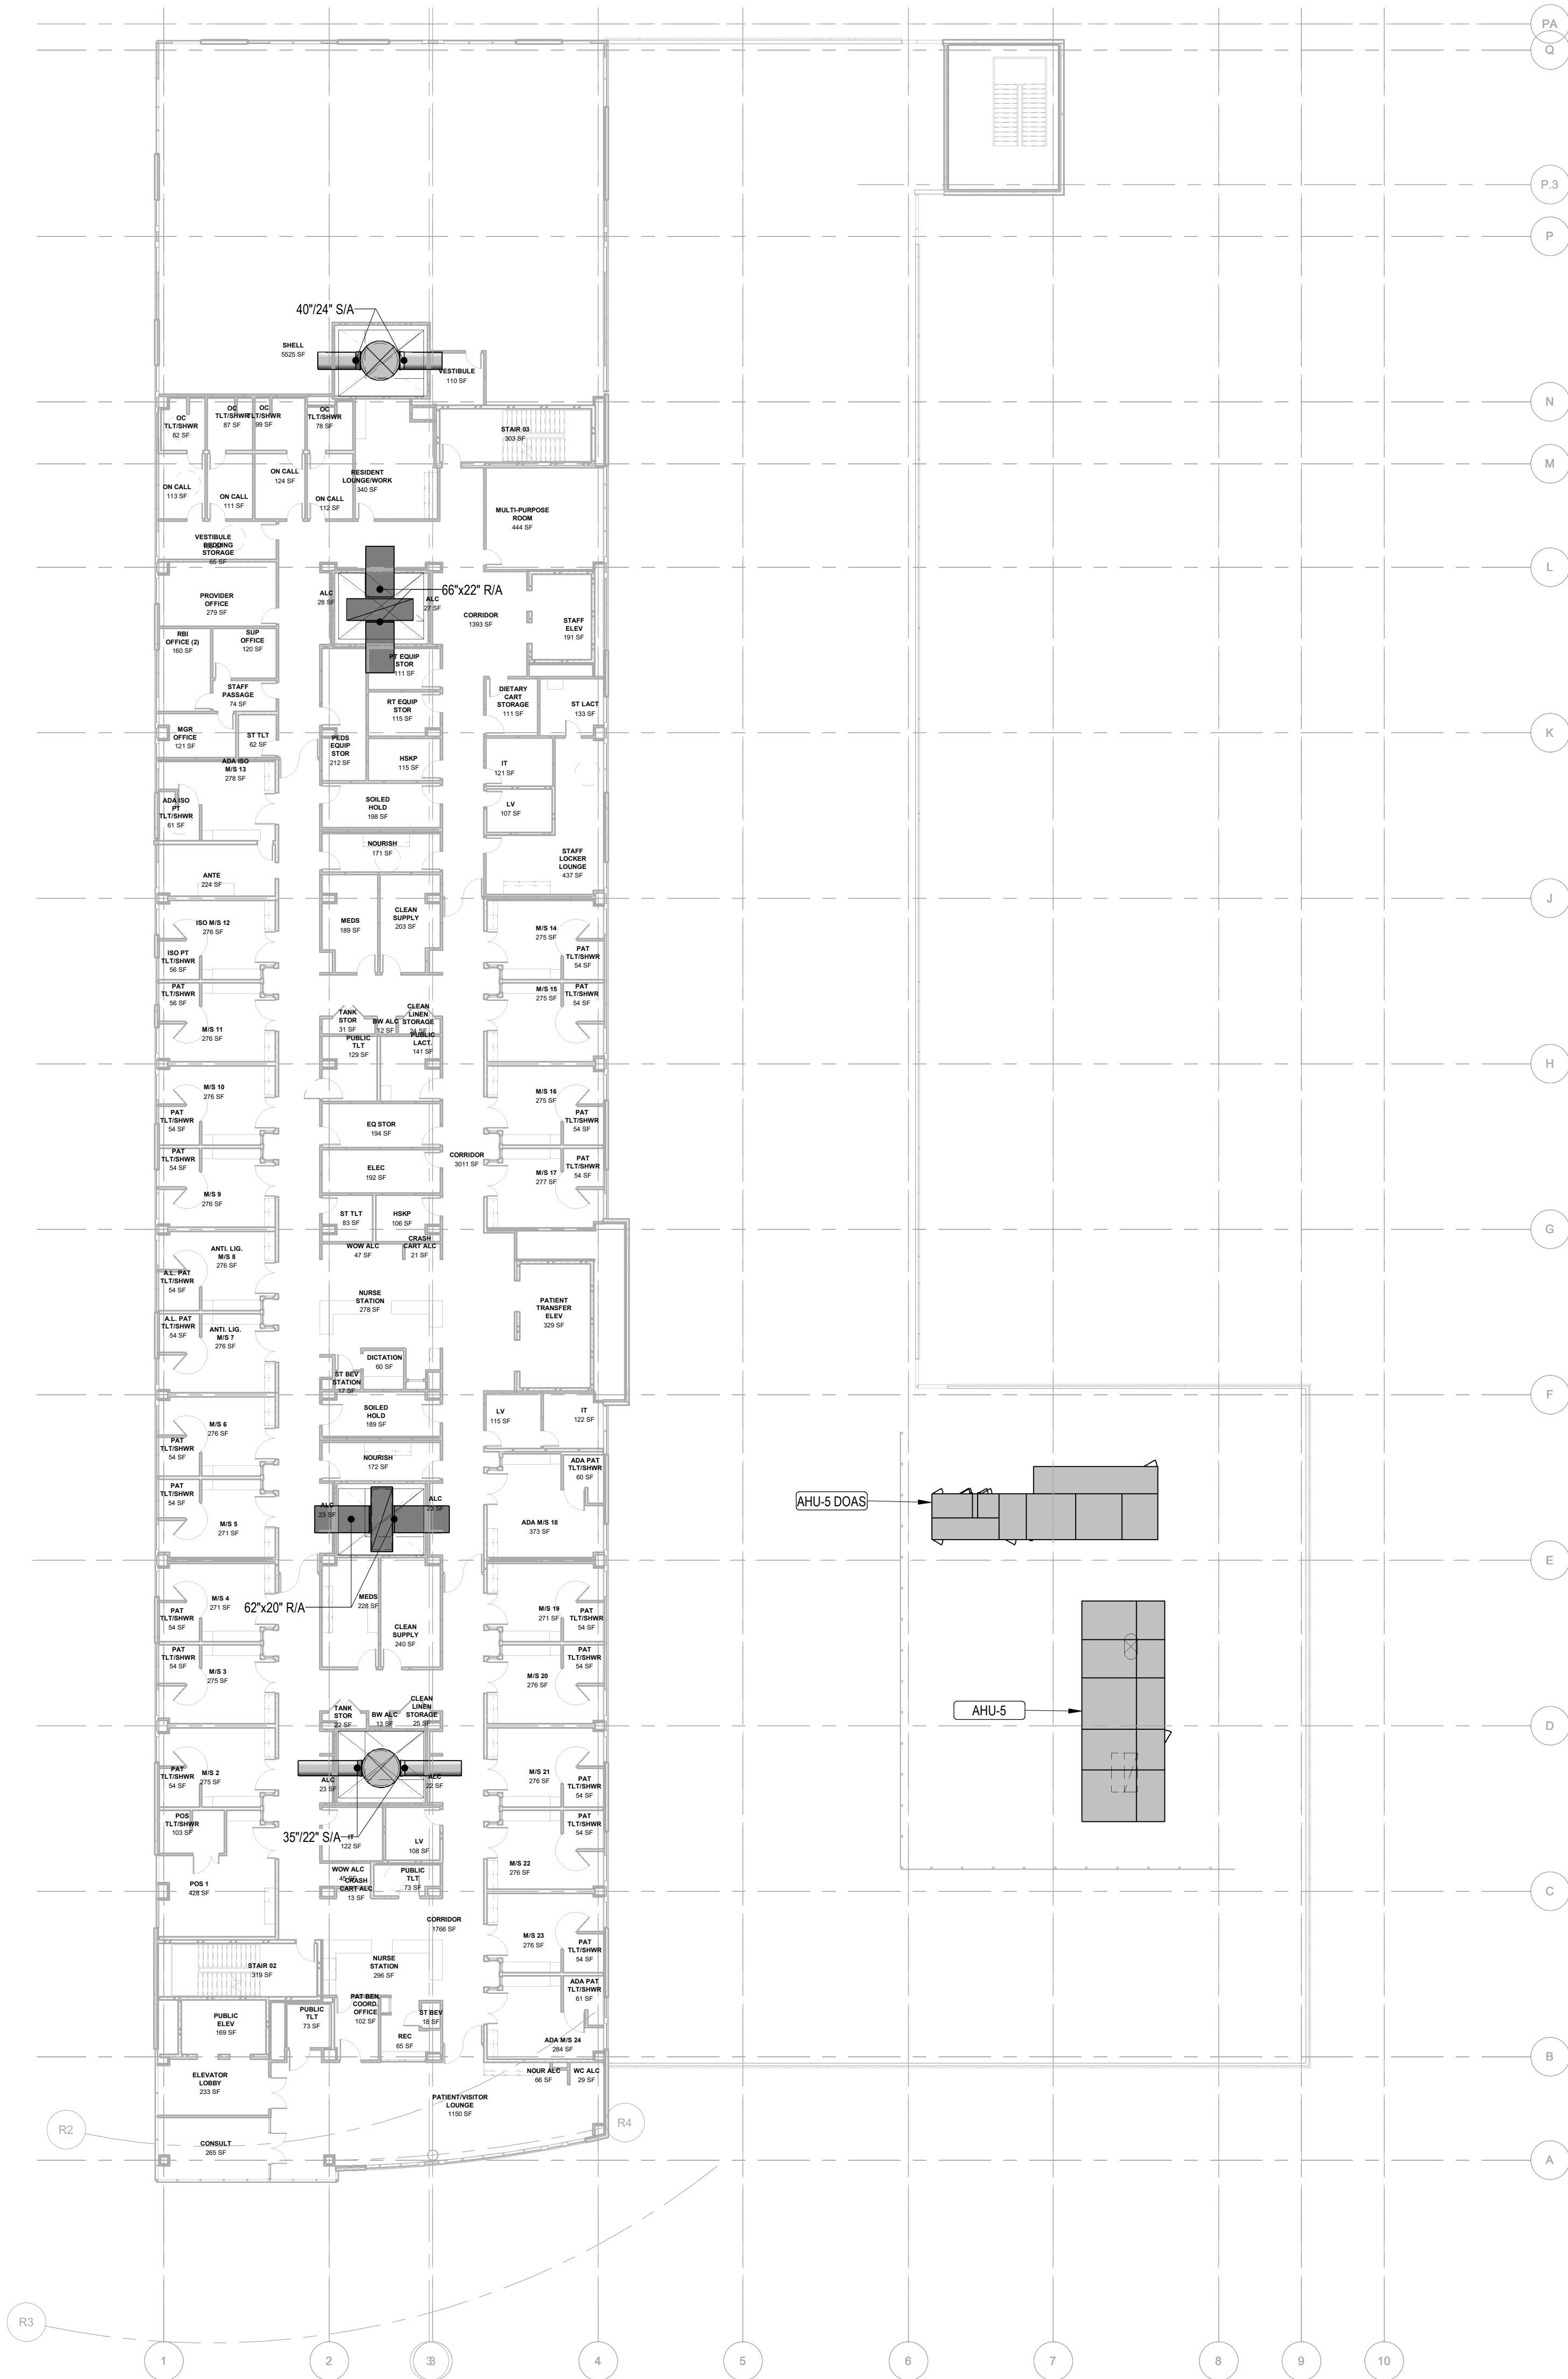











2 LEVEL 6 HVAC PLAN
1" = 20'-0"



1 ROOF HVAC PLAN
1" = 20'-0"

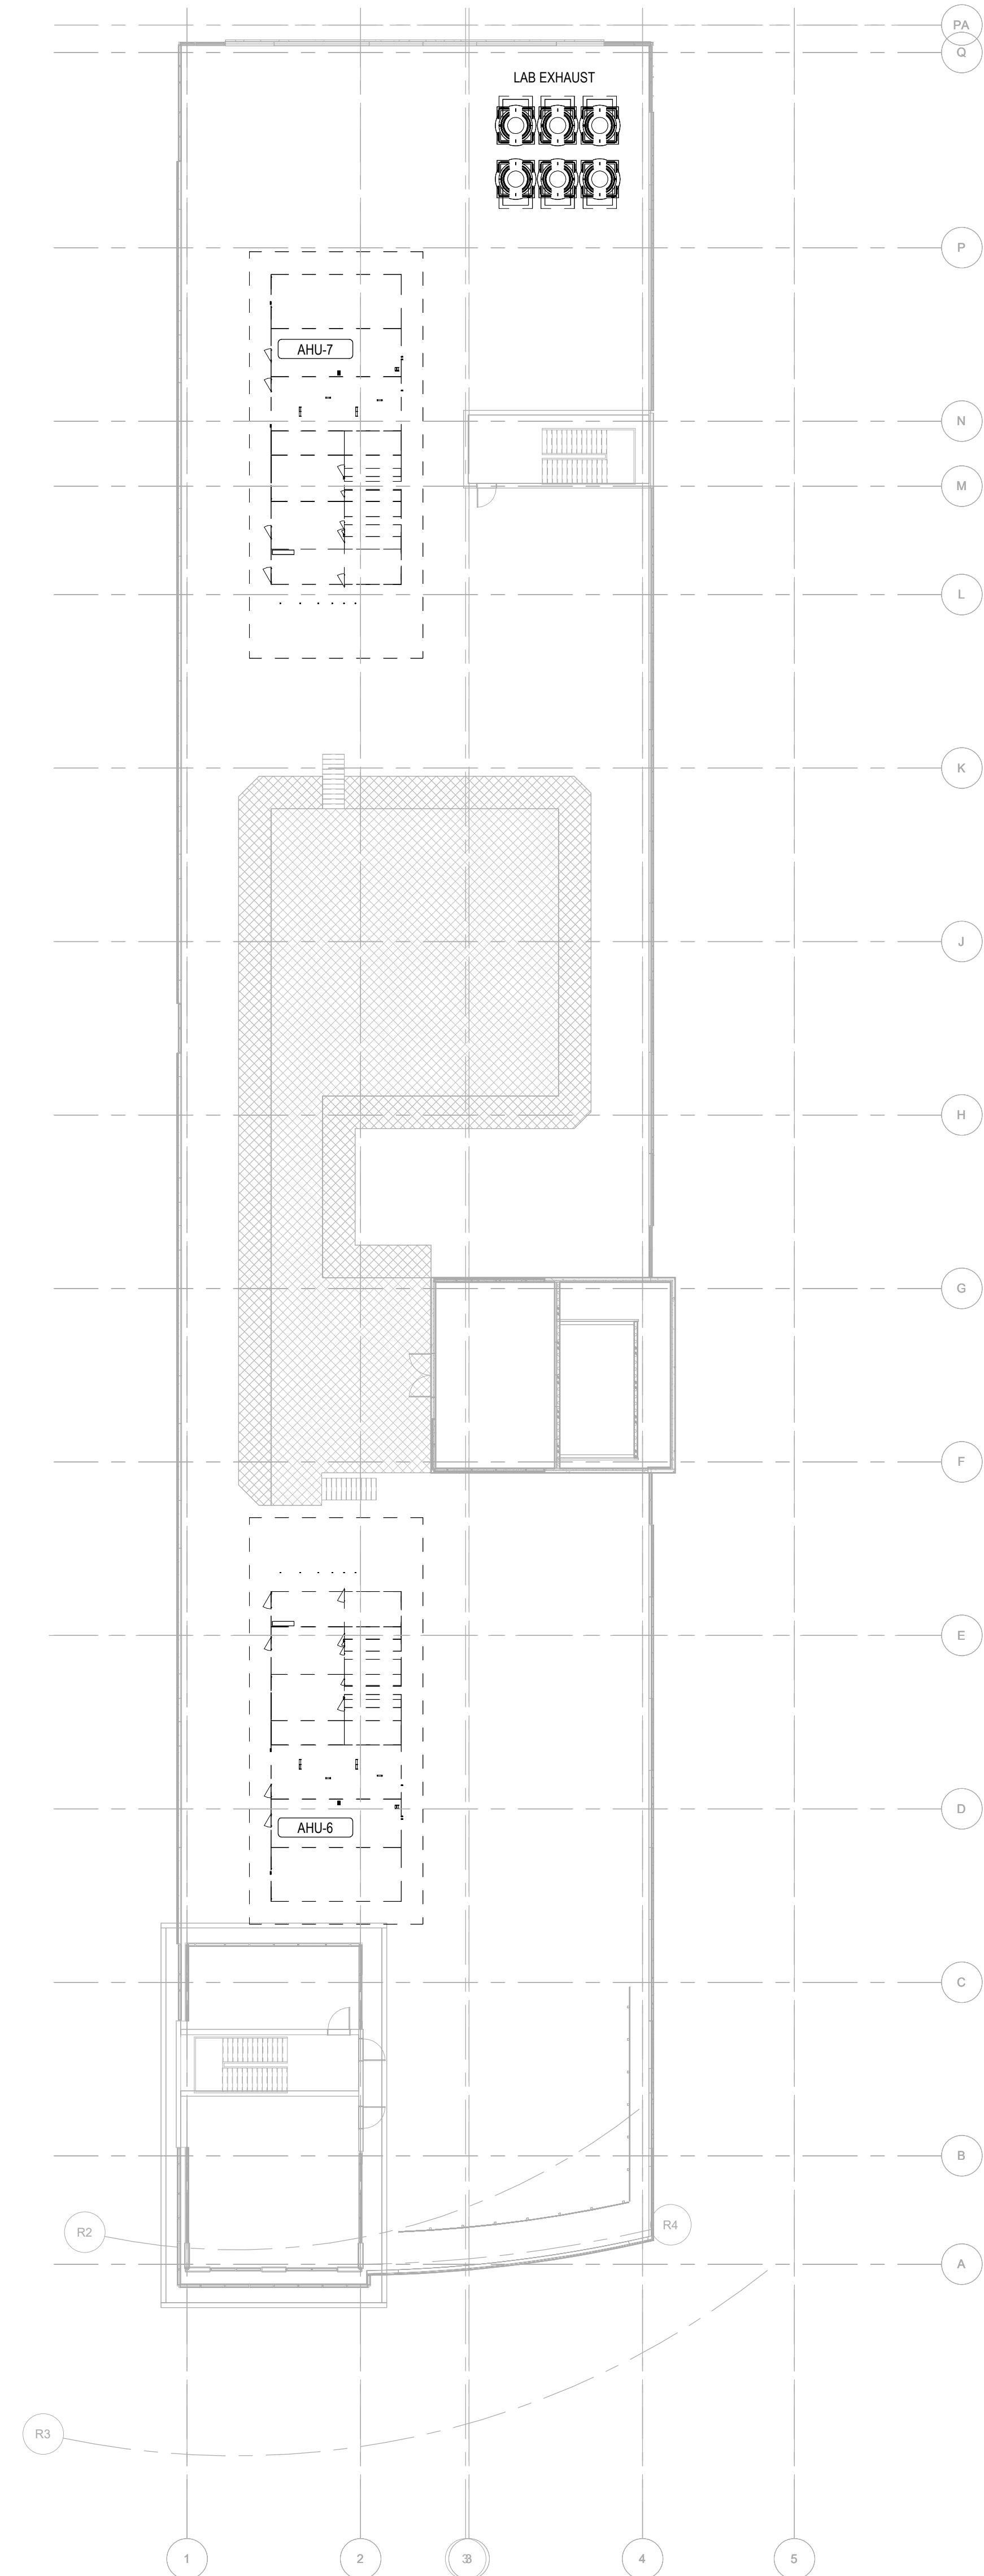

#	DATE	REVISIONS	DESCRIPTION

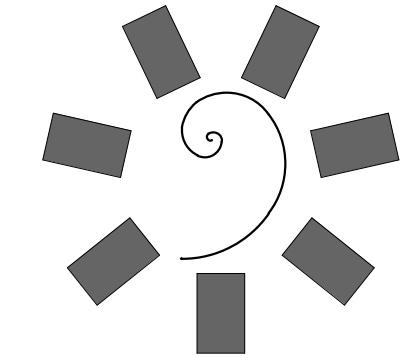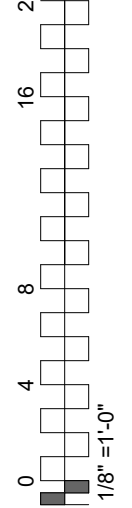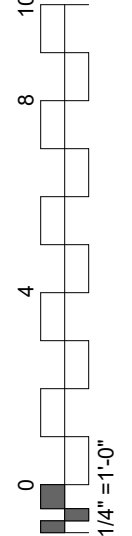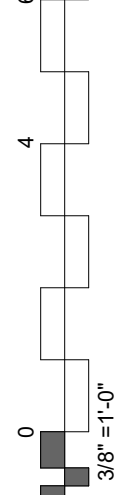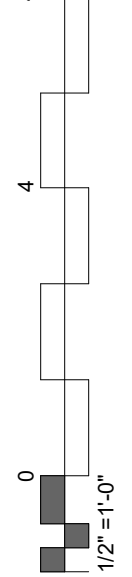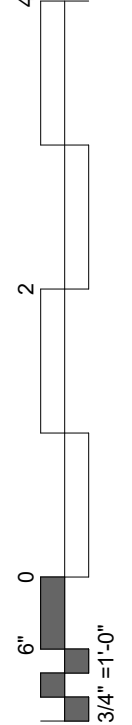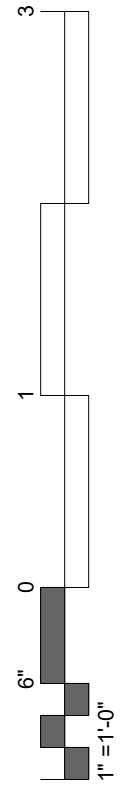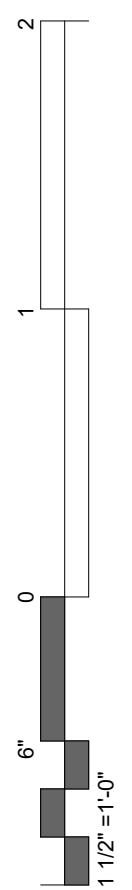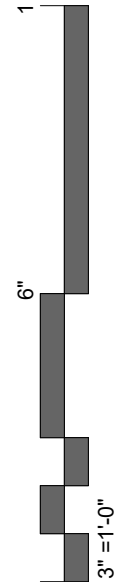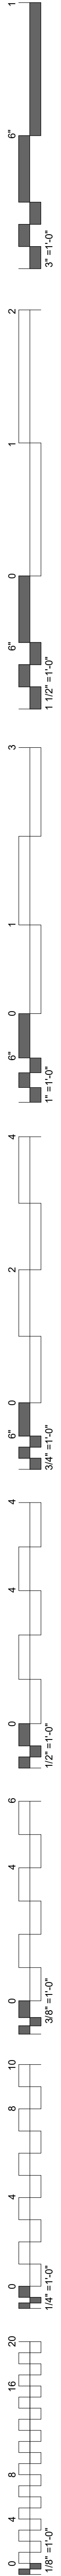

James R. Childers
Architect, Inc.
45 South 4th Street
Fort Smith, AR 72901
479-783-2450
www.childersarchitect.com


PROFESSIONAL SEAL:

CONSULTANT LOGO

HP ENGINEERING

PROJECT NO. 211808R

HP ENGINEERING INC.
5504 W. PINNACLE POINTE DRIVE
SUITE 200
ROGERS, AR 72758
(479) 899-6370
www.hpengineeringinc.com

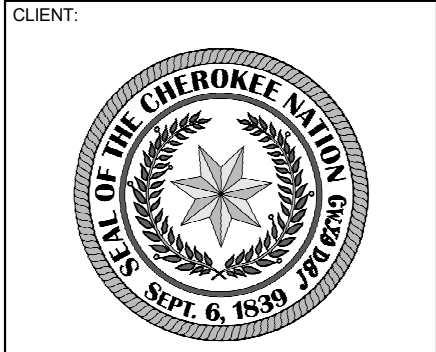

CHEROKEE NATION

W.W. HASTINGS REPLACEMENT HOSPITAL

TAHLEQUAH, OKLAHOMA

KEY PLAN:

PROJECT PHASE:

SCHEMATIC DESIGN

#	DATE	REVISIONS DESCRIPTION

JOB NUMBER: 21-08.21



DATE: 05-06-2022

SHEET NUMBER:

M-SD1.50


SHEET TITLE:

ROOF HVAC PLAN

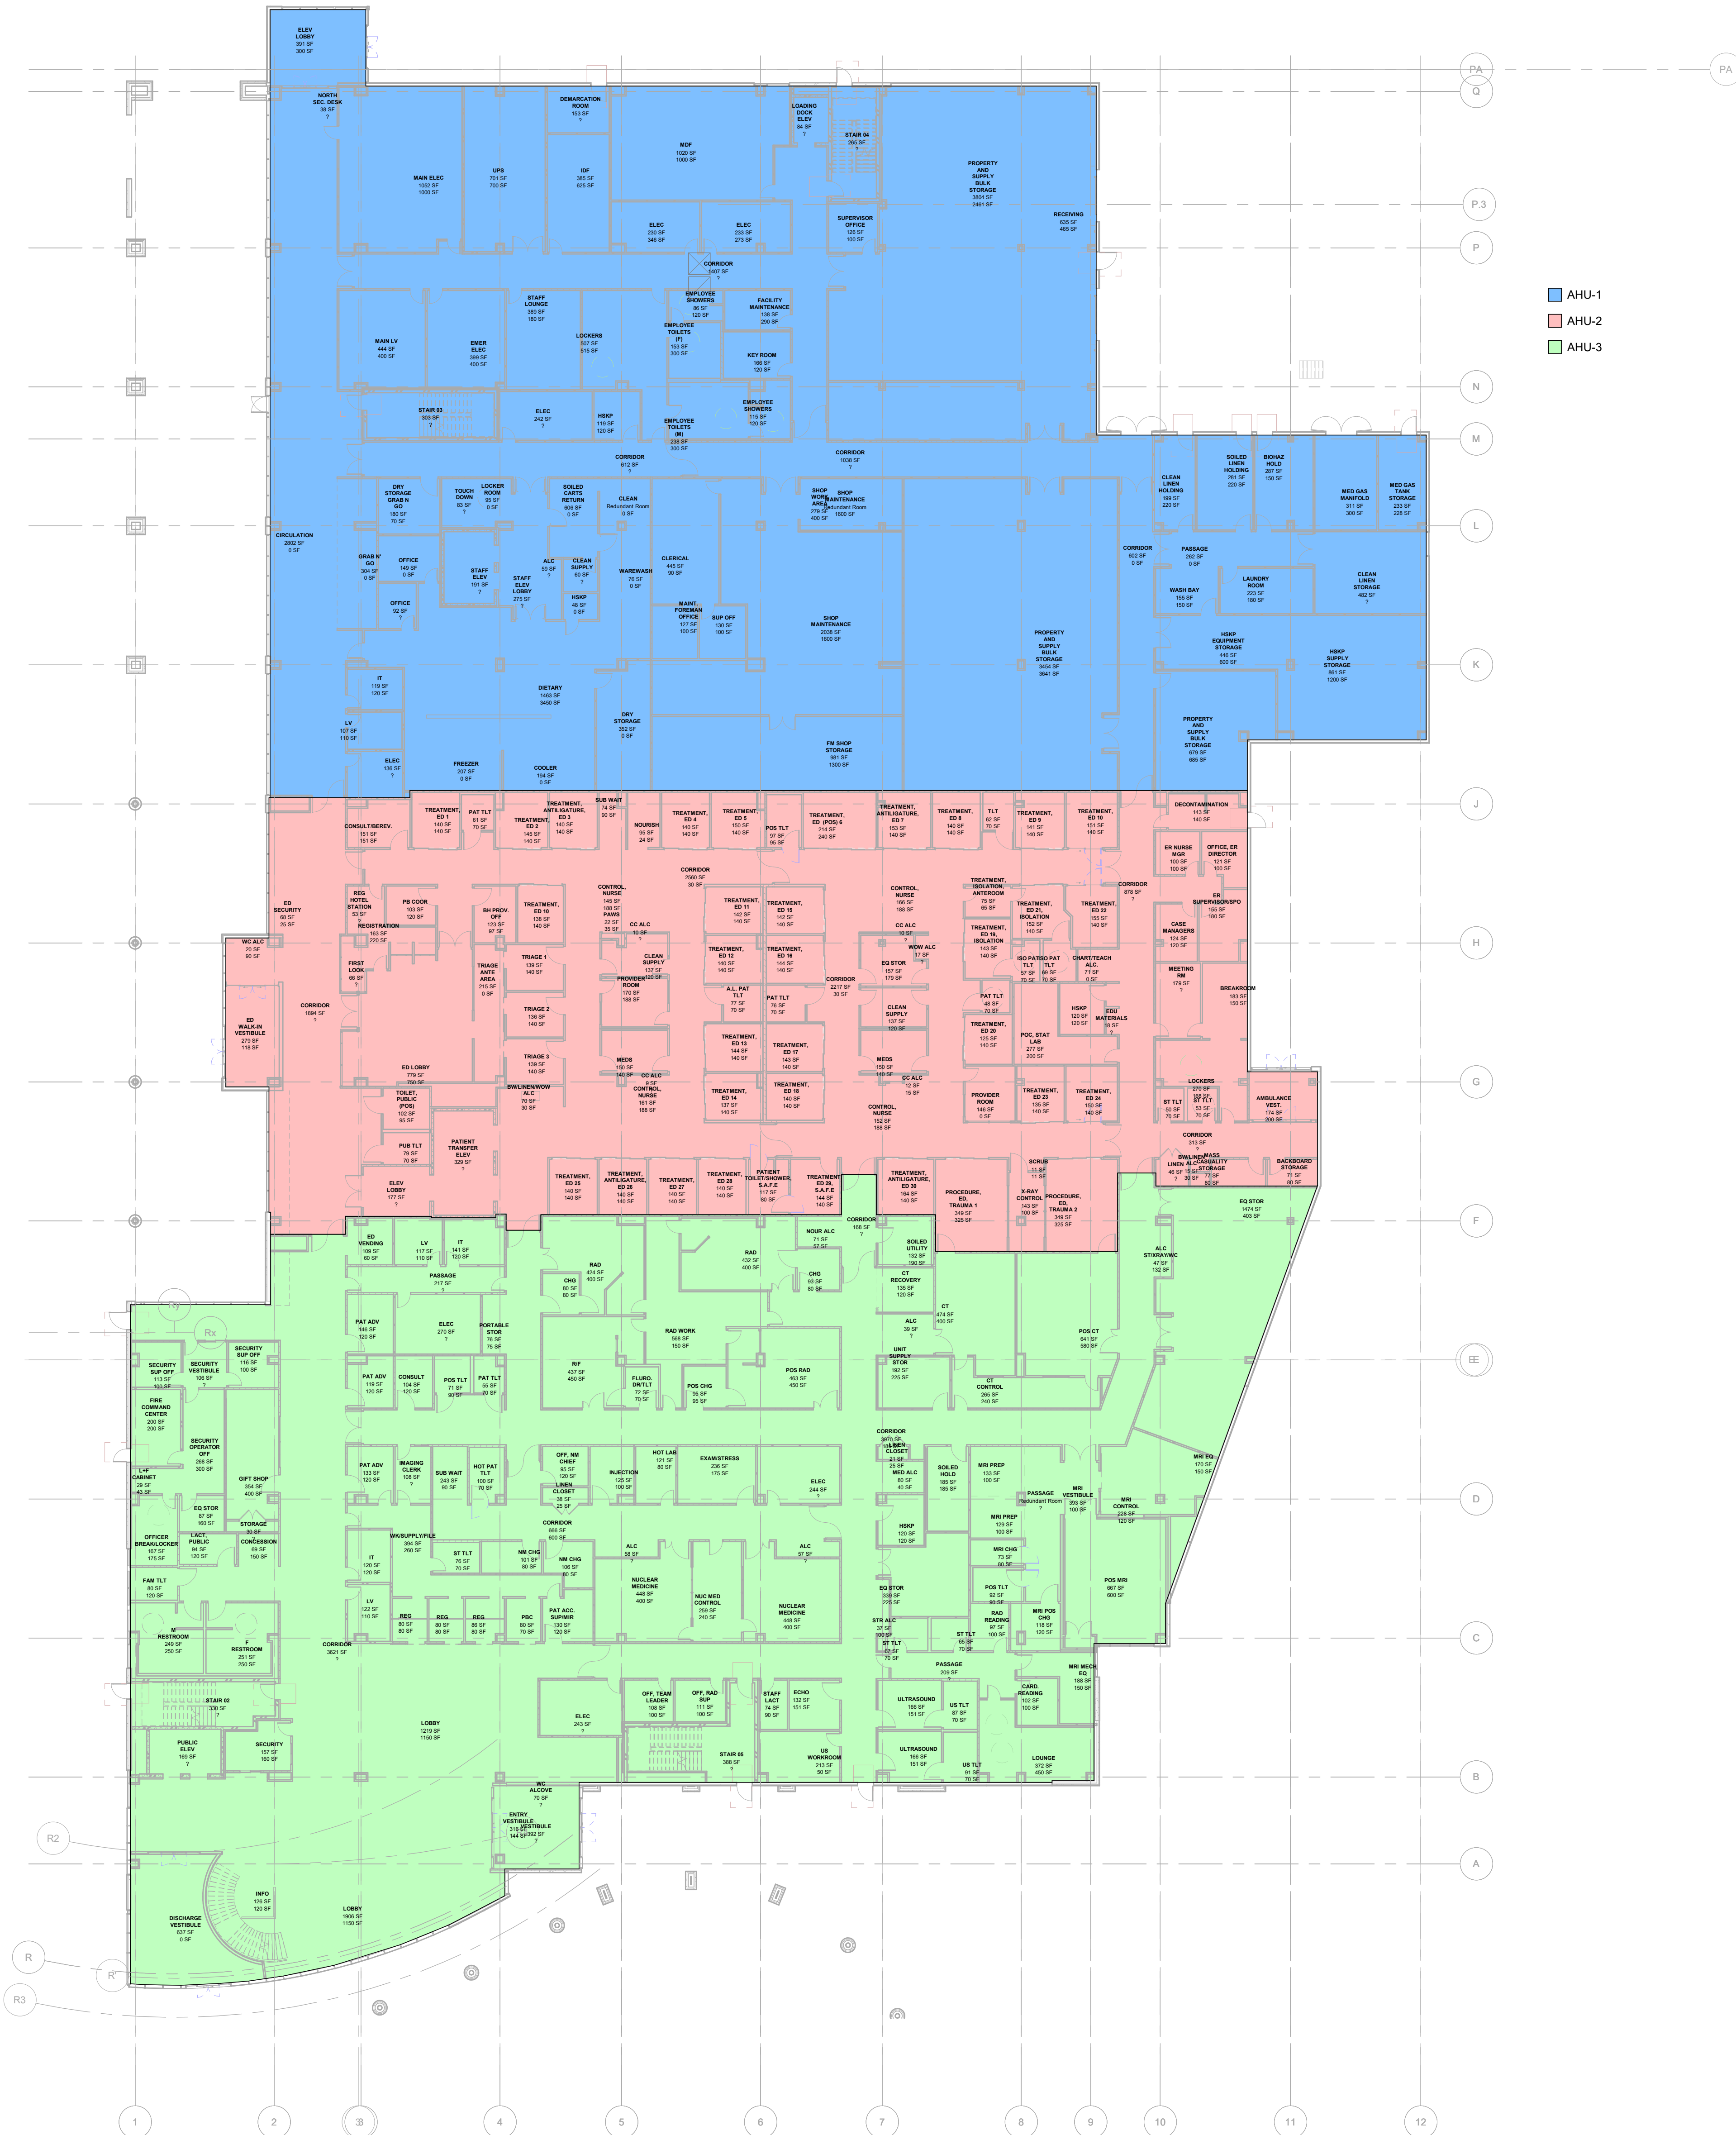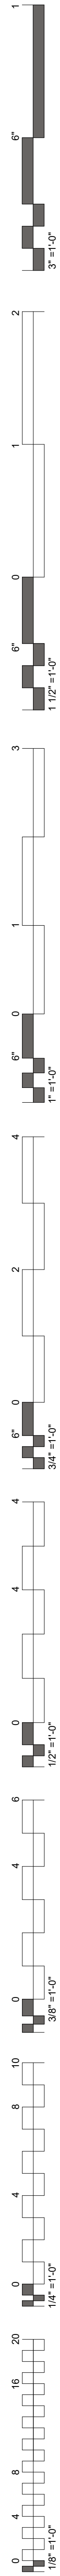


1 AHU ZONING - LEVEL 1
1" = 20'-0"



#	DATE	REVISIONS	DESCRIPTION

 

1 LEVEL 2 HVAC PLAN
1" = 20'-0"


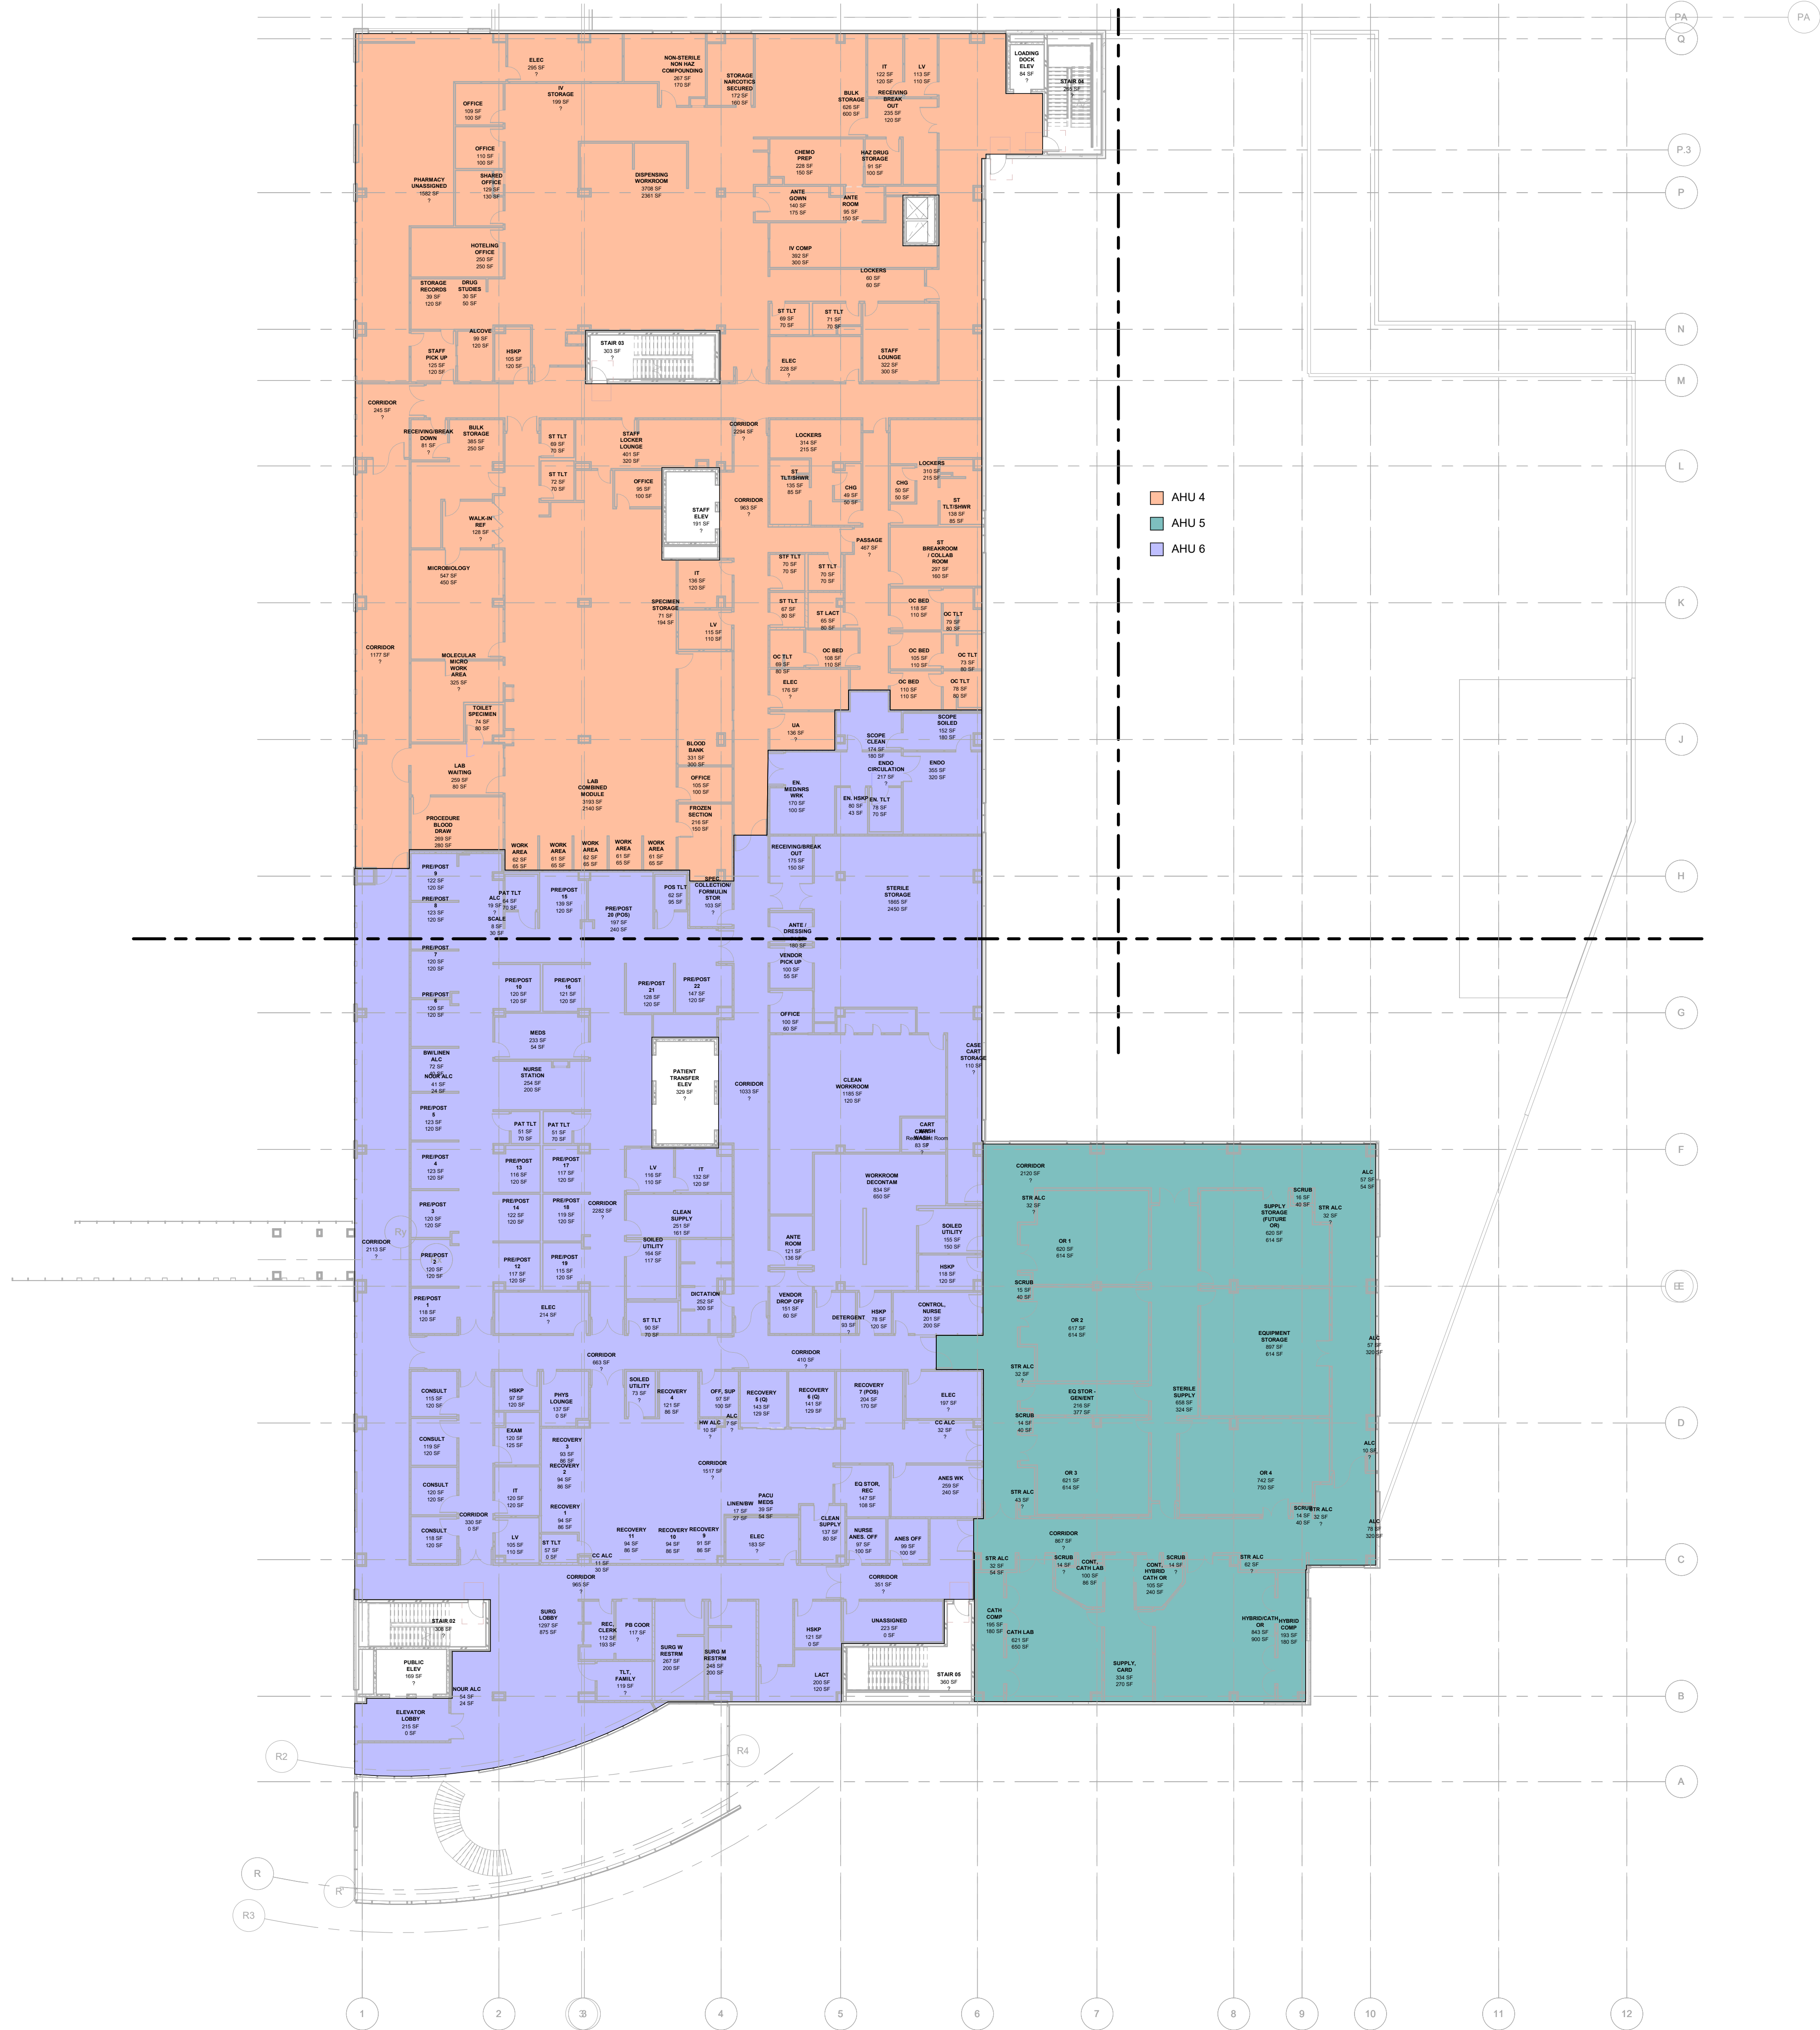


#	DATE	REVISIONS	DESCRIPTION

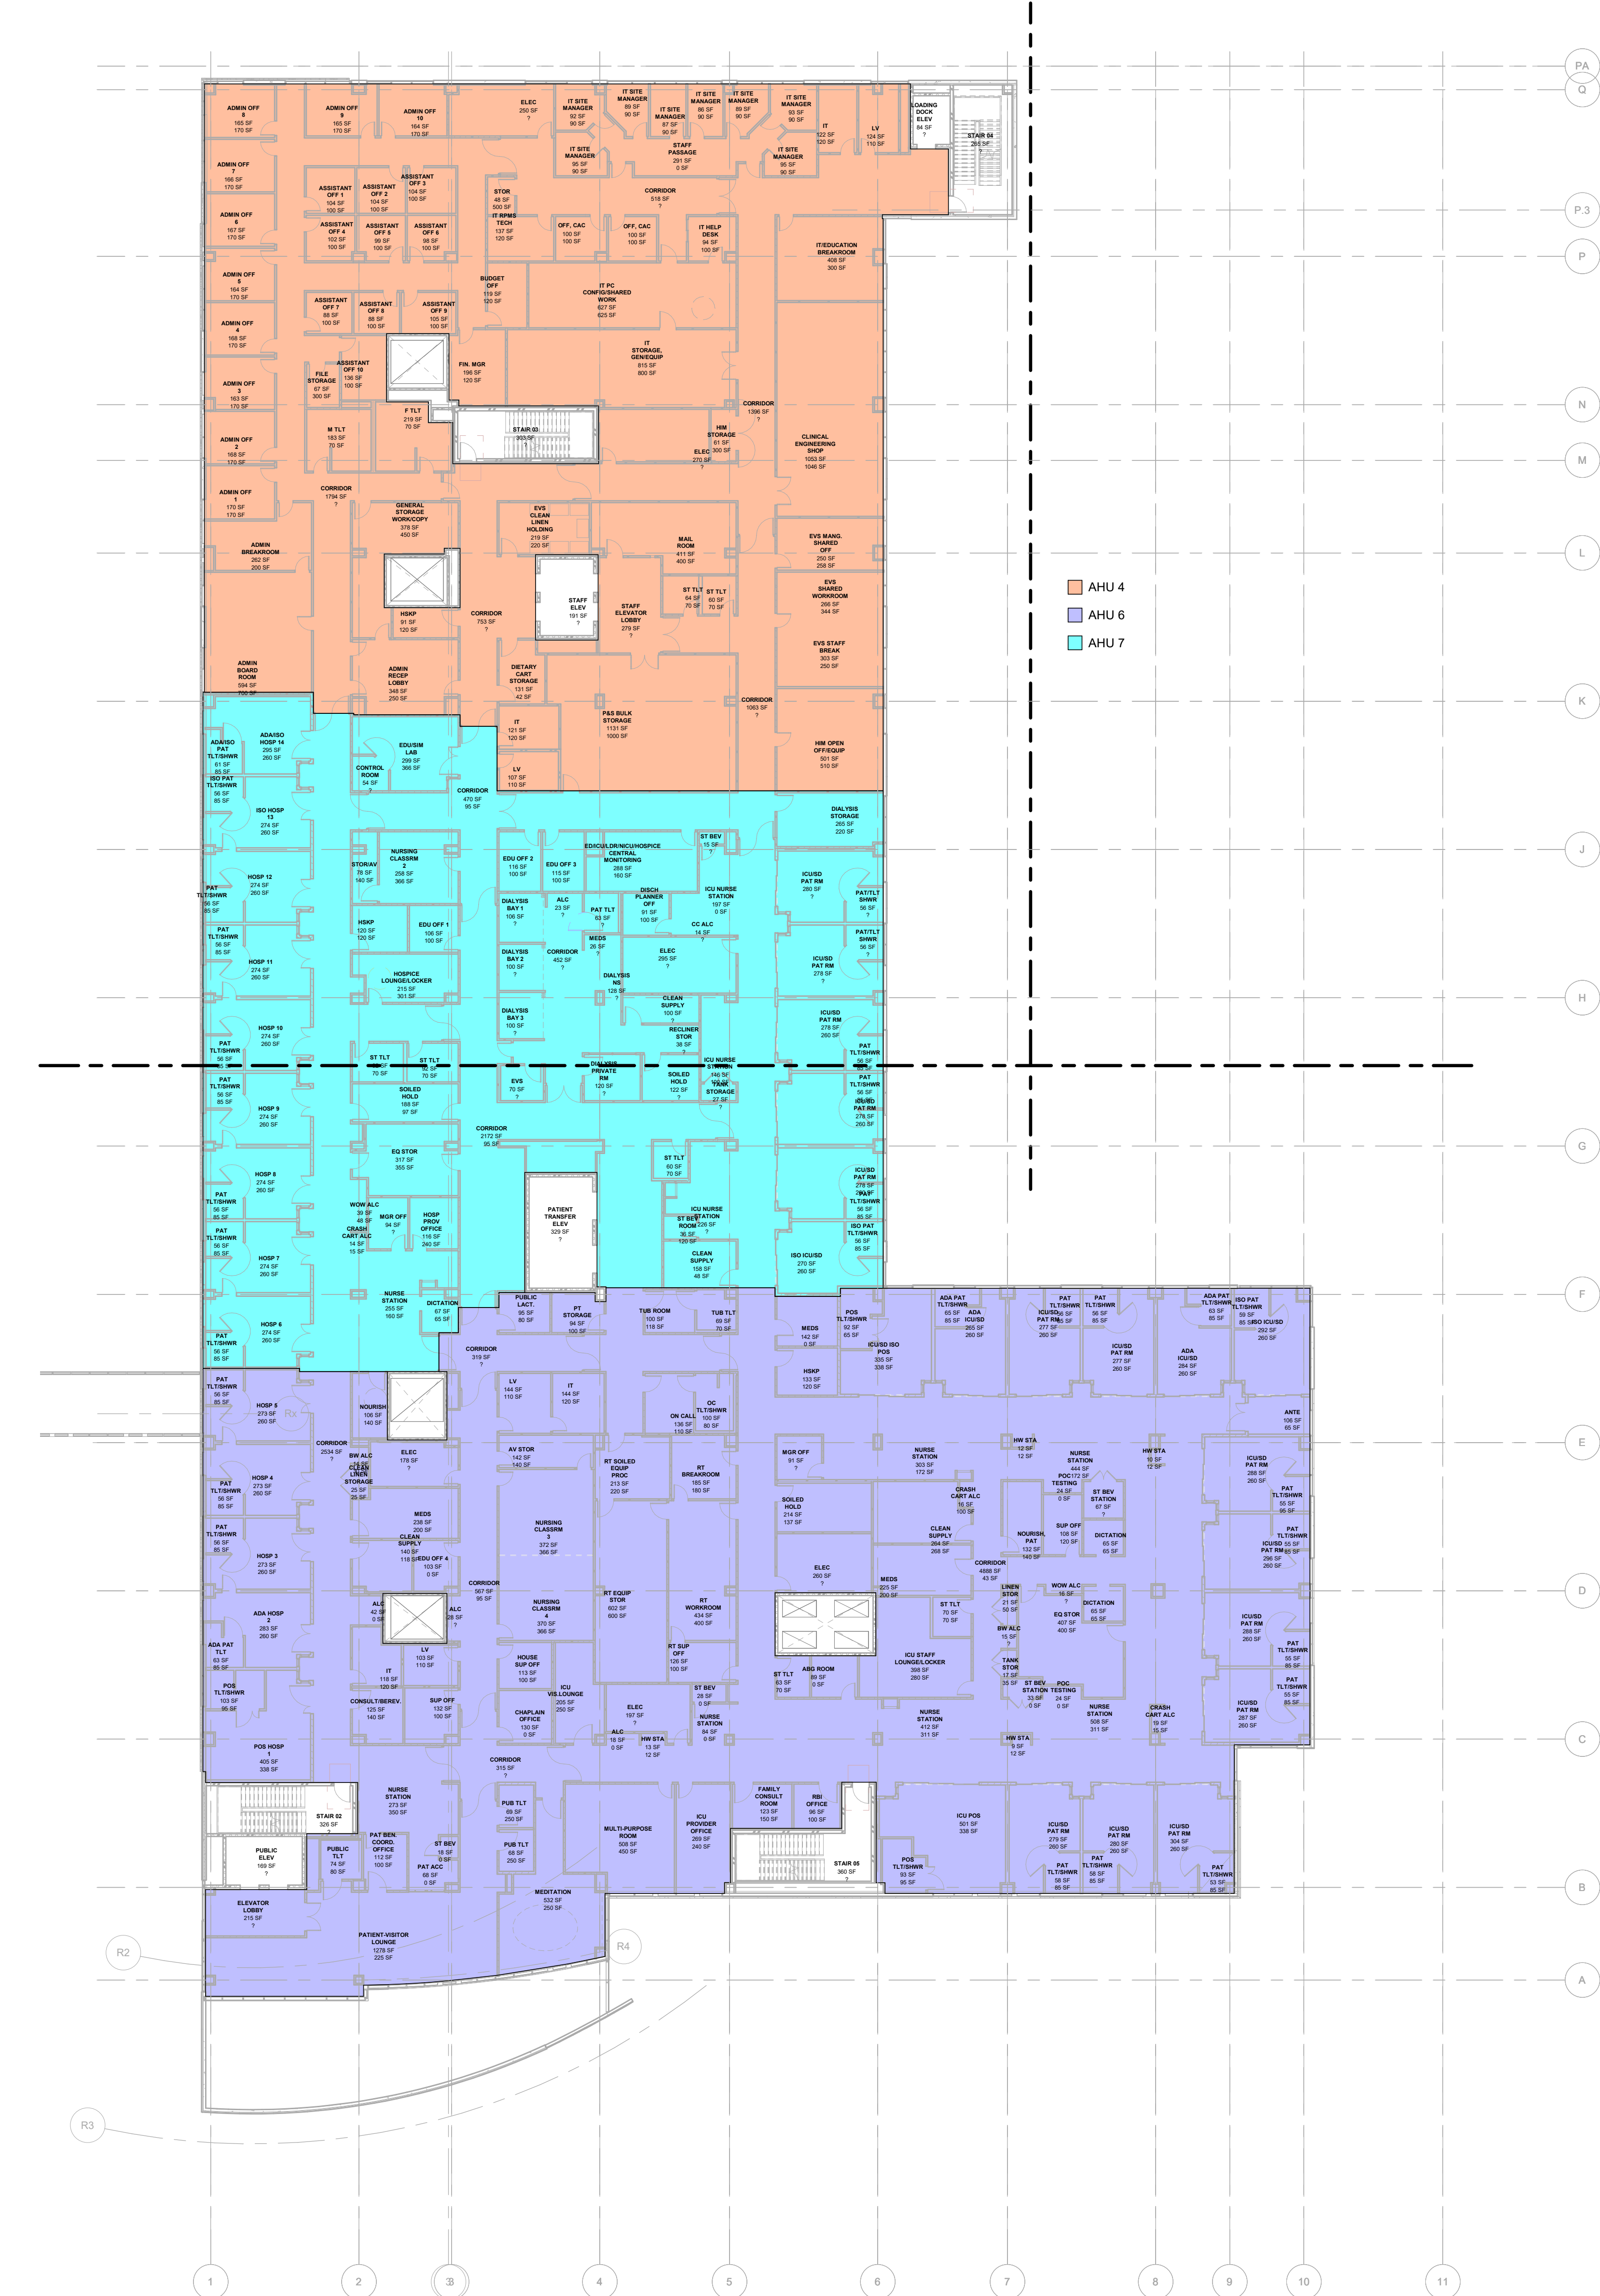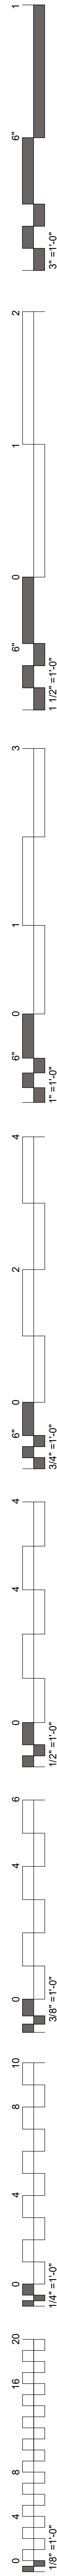


1 AHU ZONING - LEVEL 3
1" = 20'-0"

#	DATE	REVISIONS	DESCRIPTION

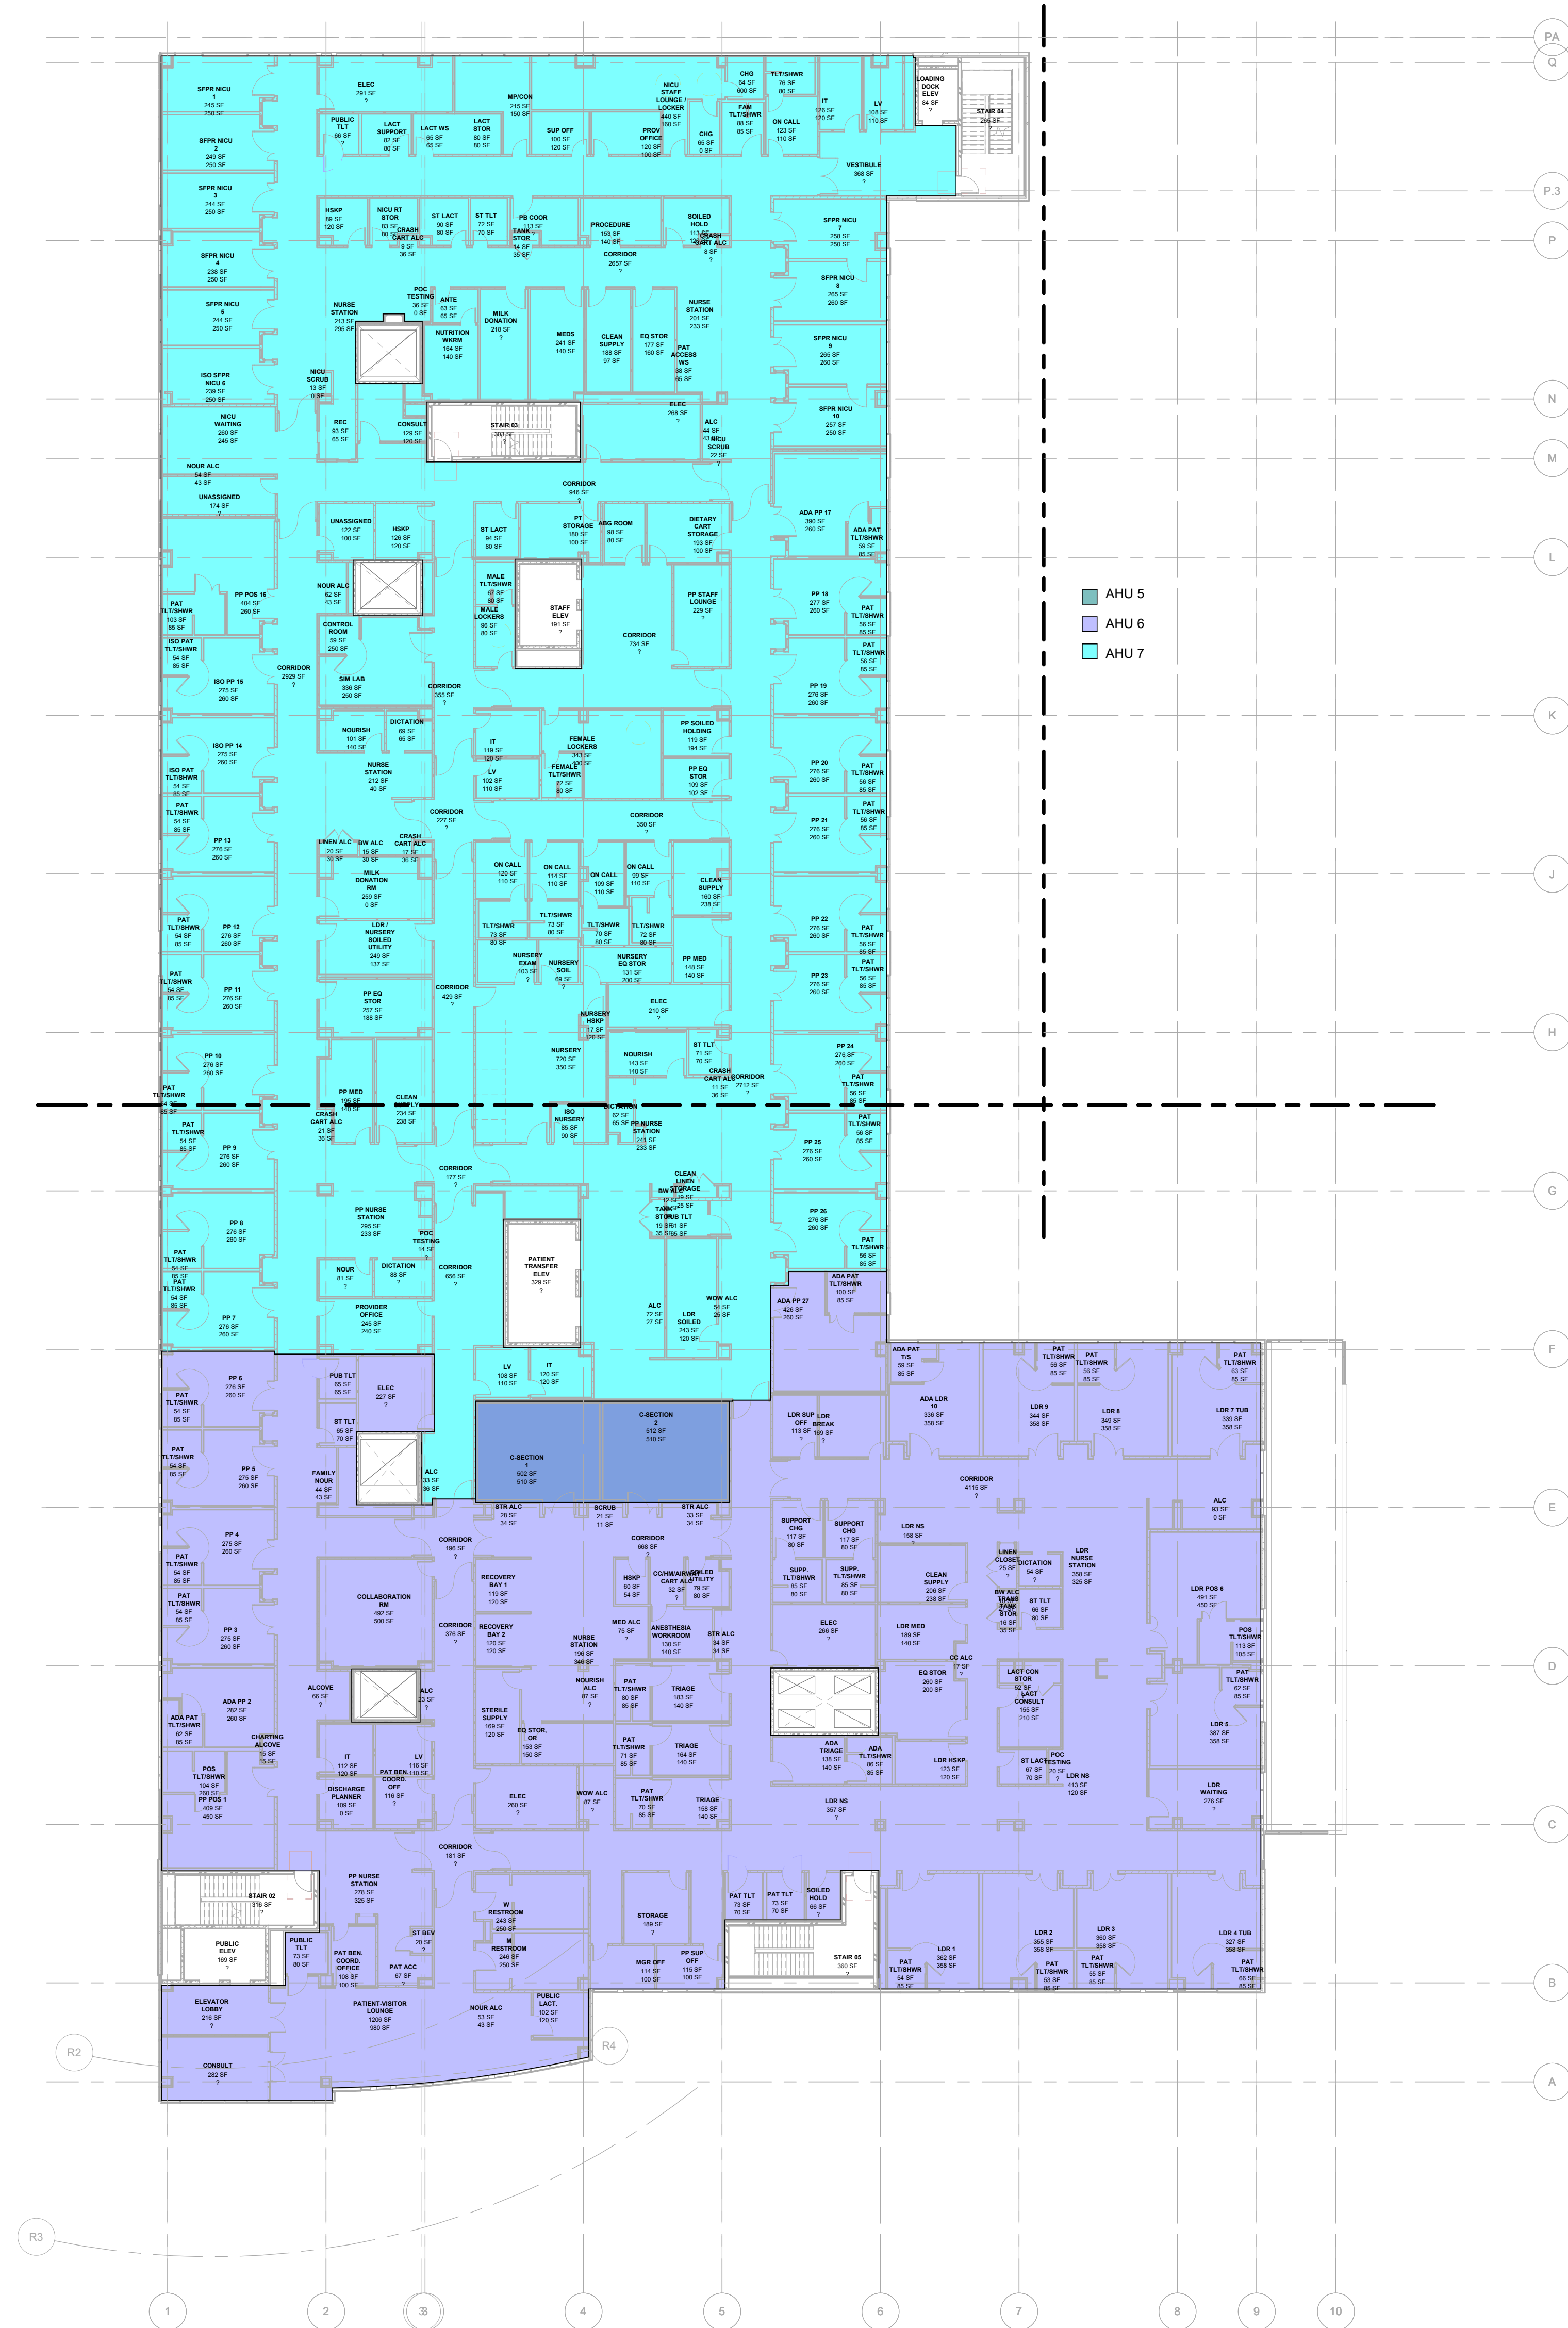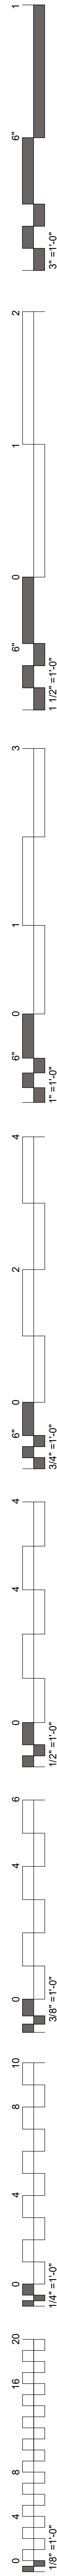


1 AHU ZONING - LEVEL 4
1" = 20'-0"



#	DATE	REVISIONS	DESCRIPTION

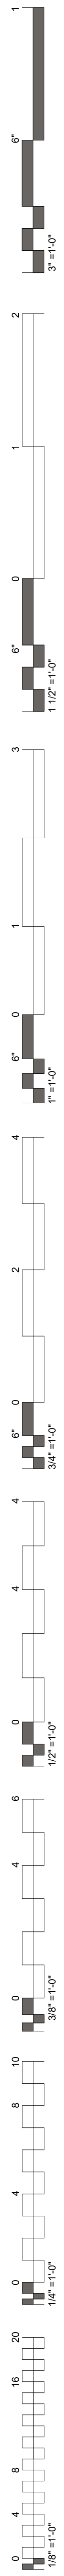

2 AHU ZONING - LEVEL 5
1" = 20'-0"

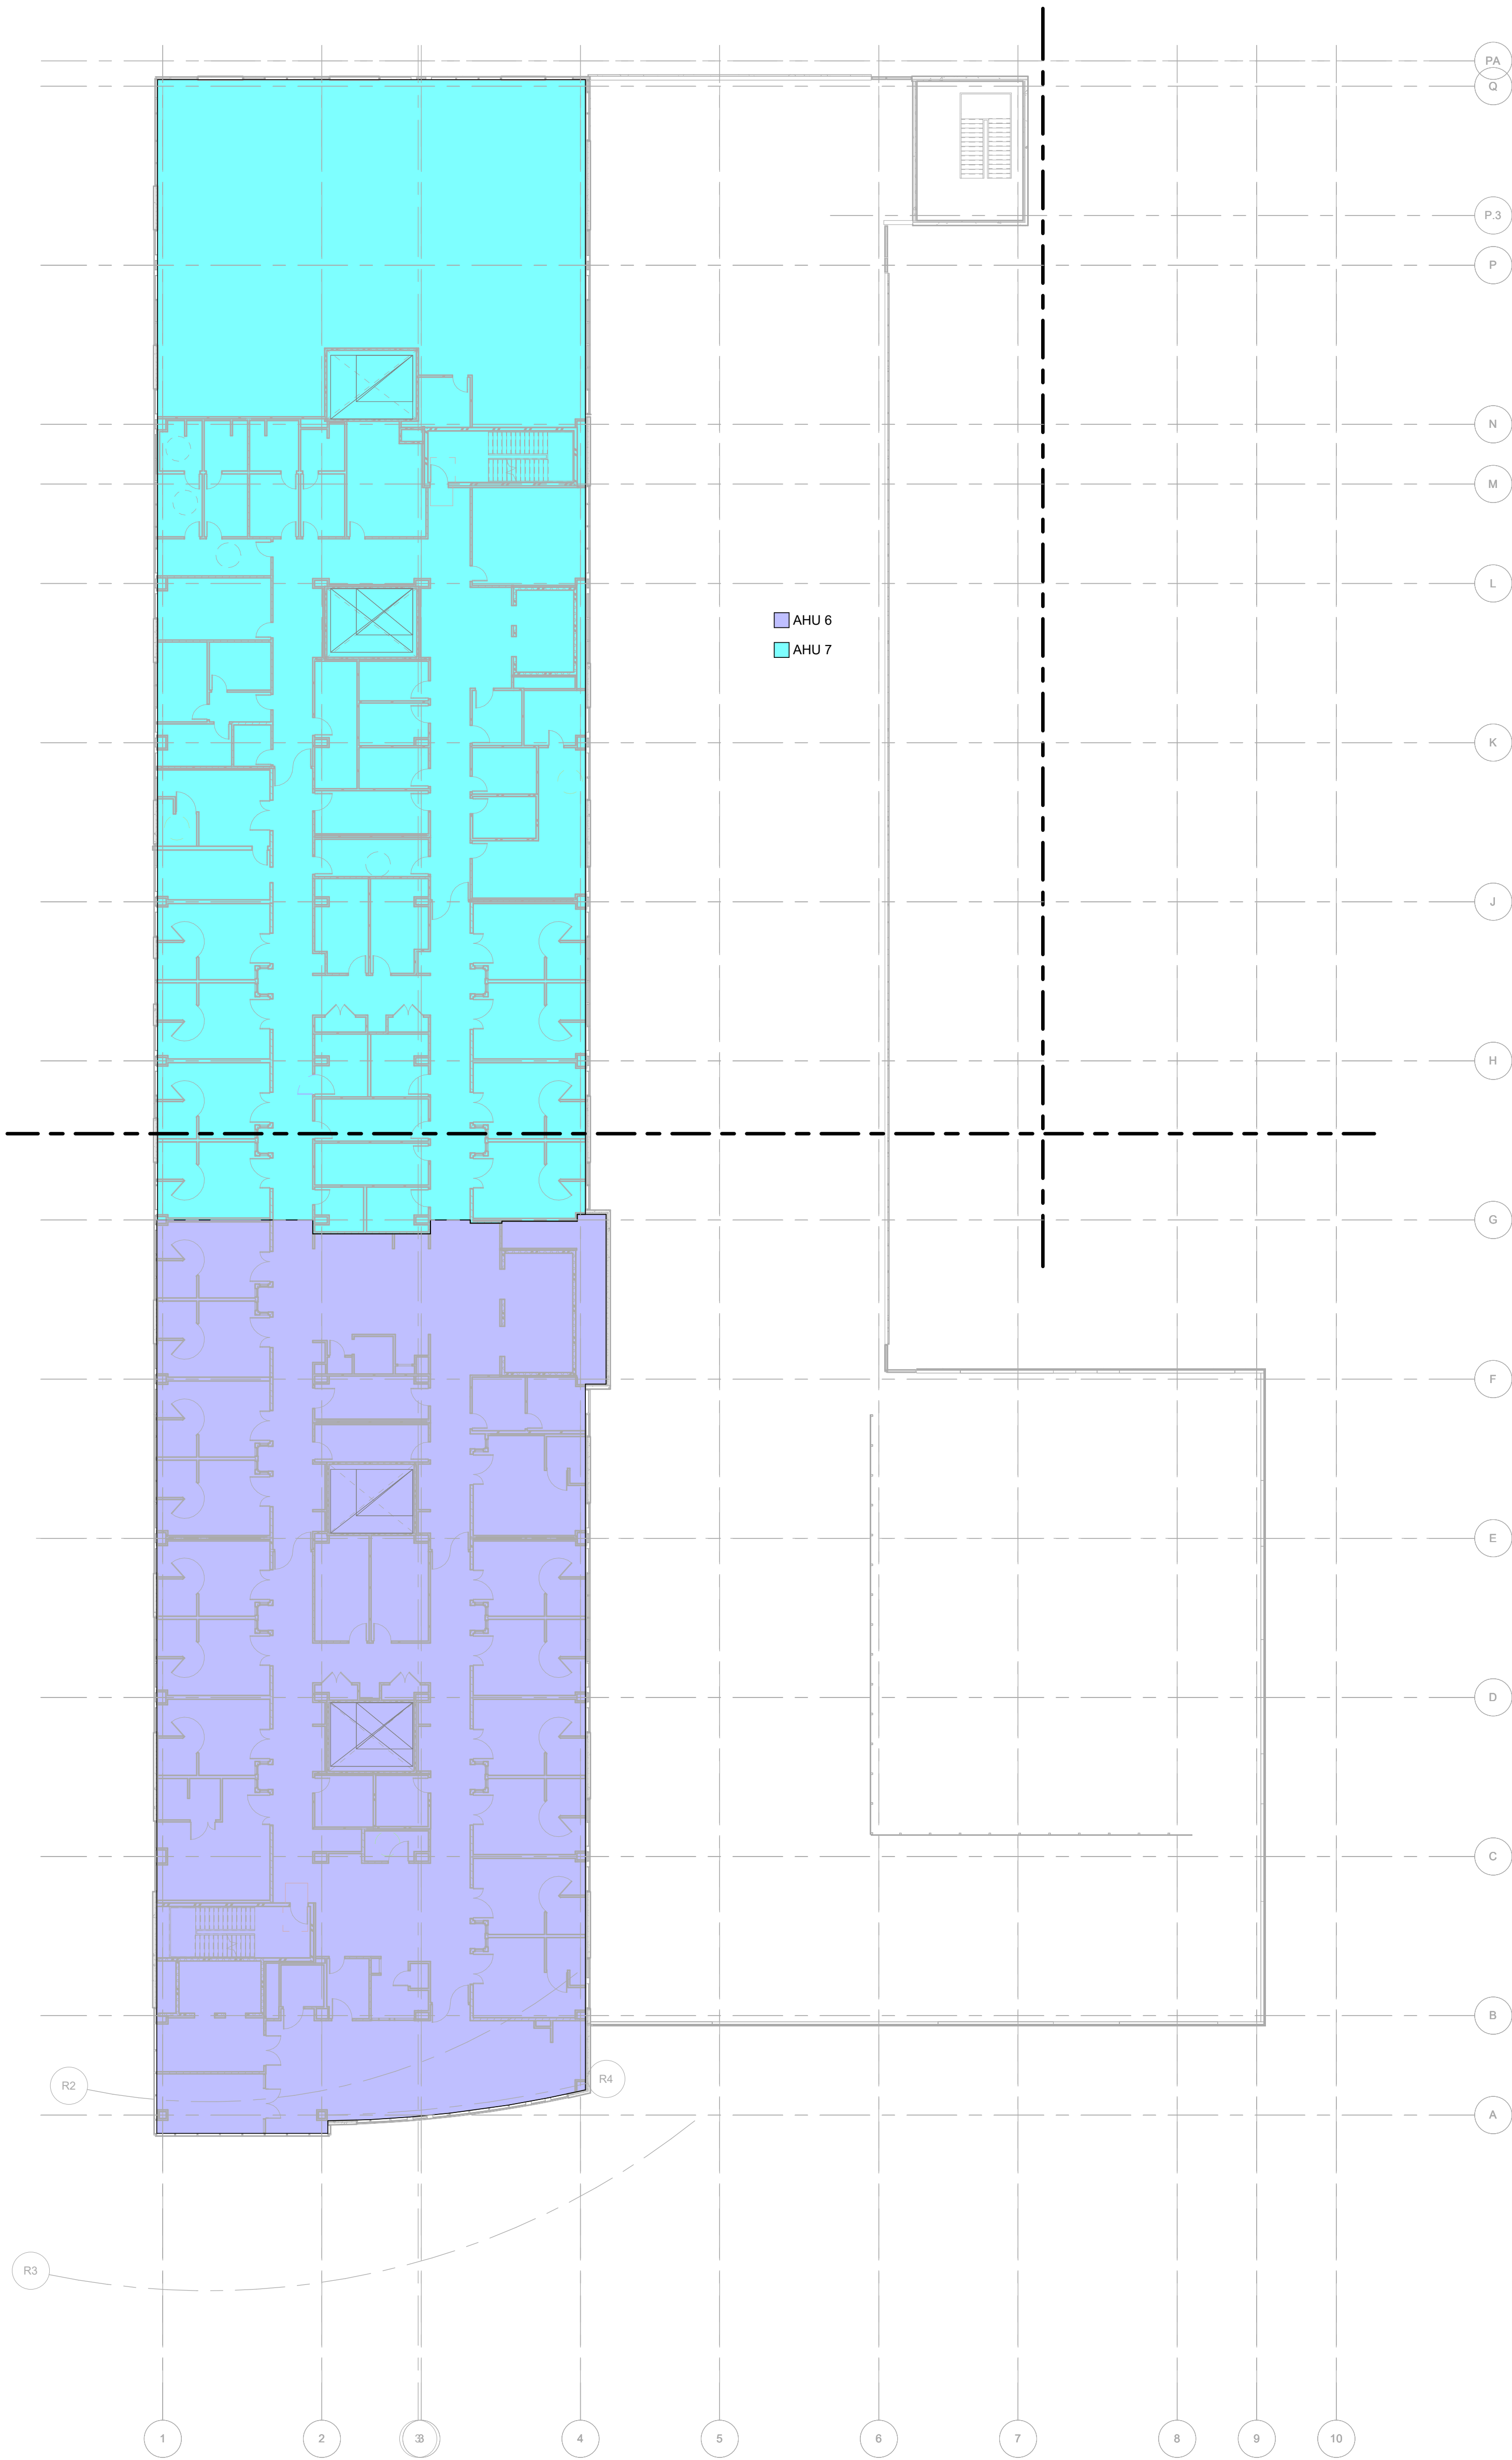

1 AHU ZONING - LEVEL 6
1" = 20'-0"

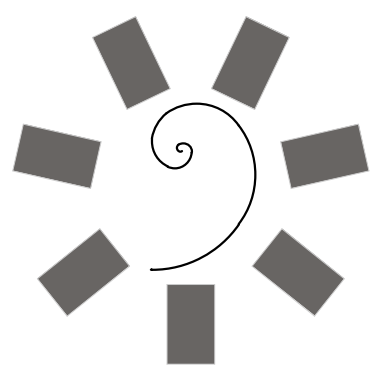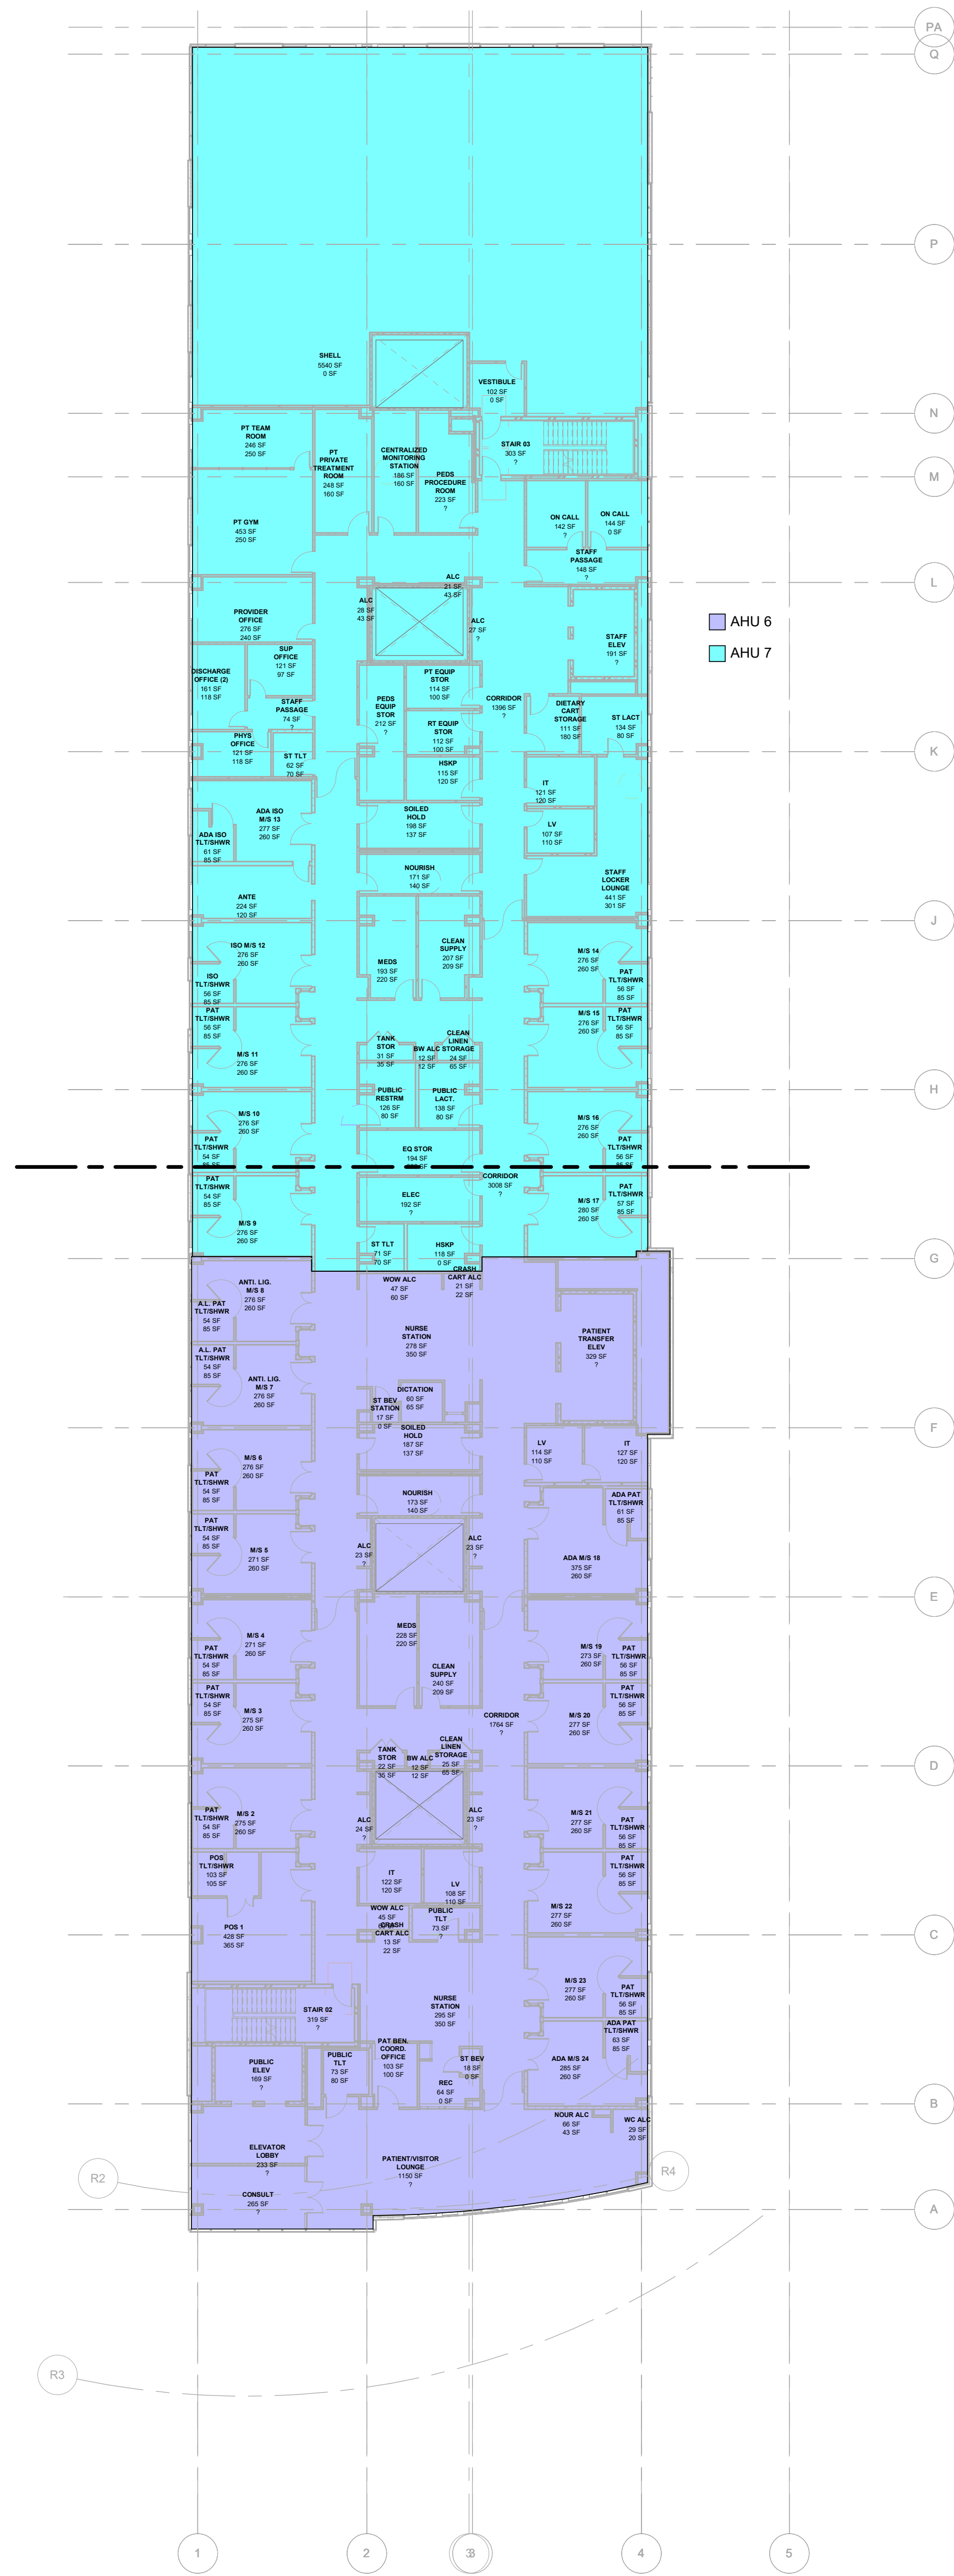


James R. Childers
Architect, Inc.
45 South 4th Street
Fort Smith, AR 72901
479-783-2450
www.childersarchitect.com

PROFESSIONAL SEAL:

CONSULTANT LOGO

HP ENGINEERING
PROJECT NO. 211808R
HP ENGINEERING INC.
5504 W. PINNACLE POINTE DRIVE
ROGERS, AR 72758
(479) 899-6370
www.hpengineeringinc.com

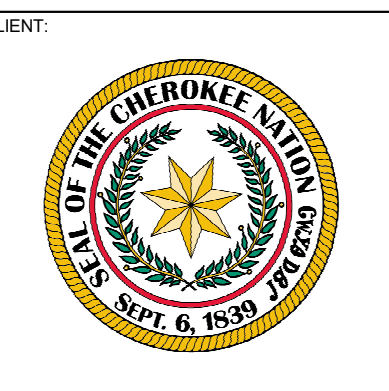

CLIENT:
CHEROKEE NATION
W.W. HASTINGS REPLACEMENT HOSPITAL
TAHLEQUAH, OKLAHOMA

KEY PLAN:

PROJECT PHASE:
SCHEMATIC DESIGN

#	DATE	REVISIONS	DESCRIPTION

JOB NUMBER: 21-08.21



DATE: 05-06-2022

SHEET NUMBER:

M-SD3.40

SHEET TITLE:

LEVELS 5&6 AHU ZONE
DIAGRAMS

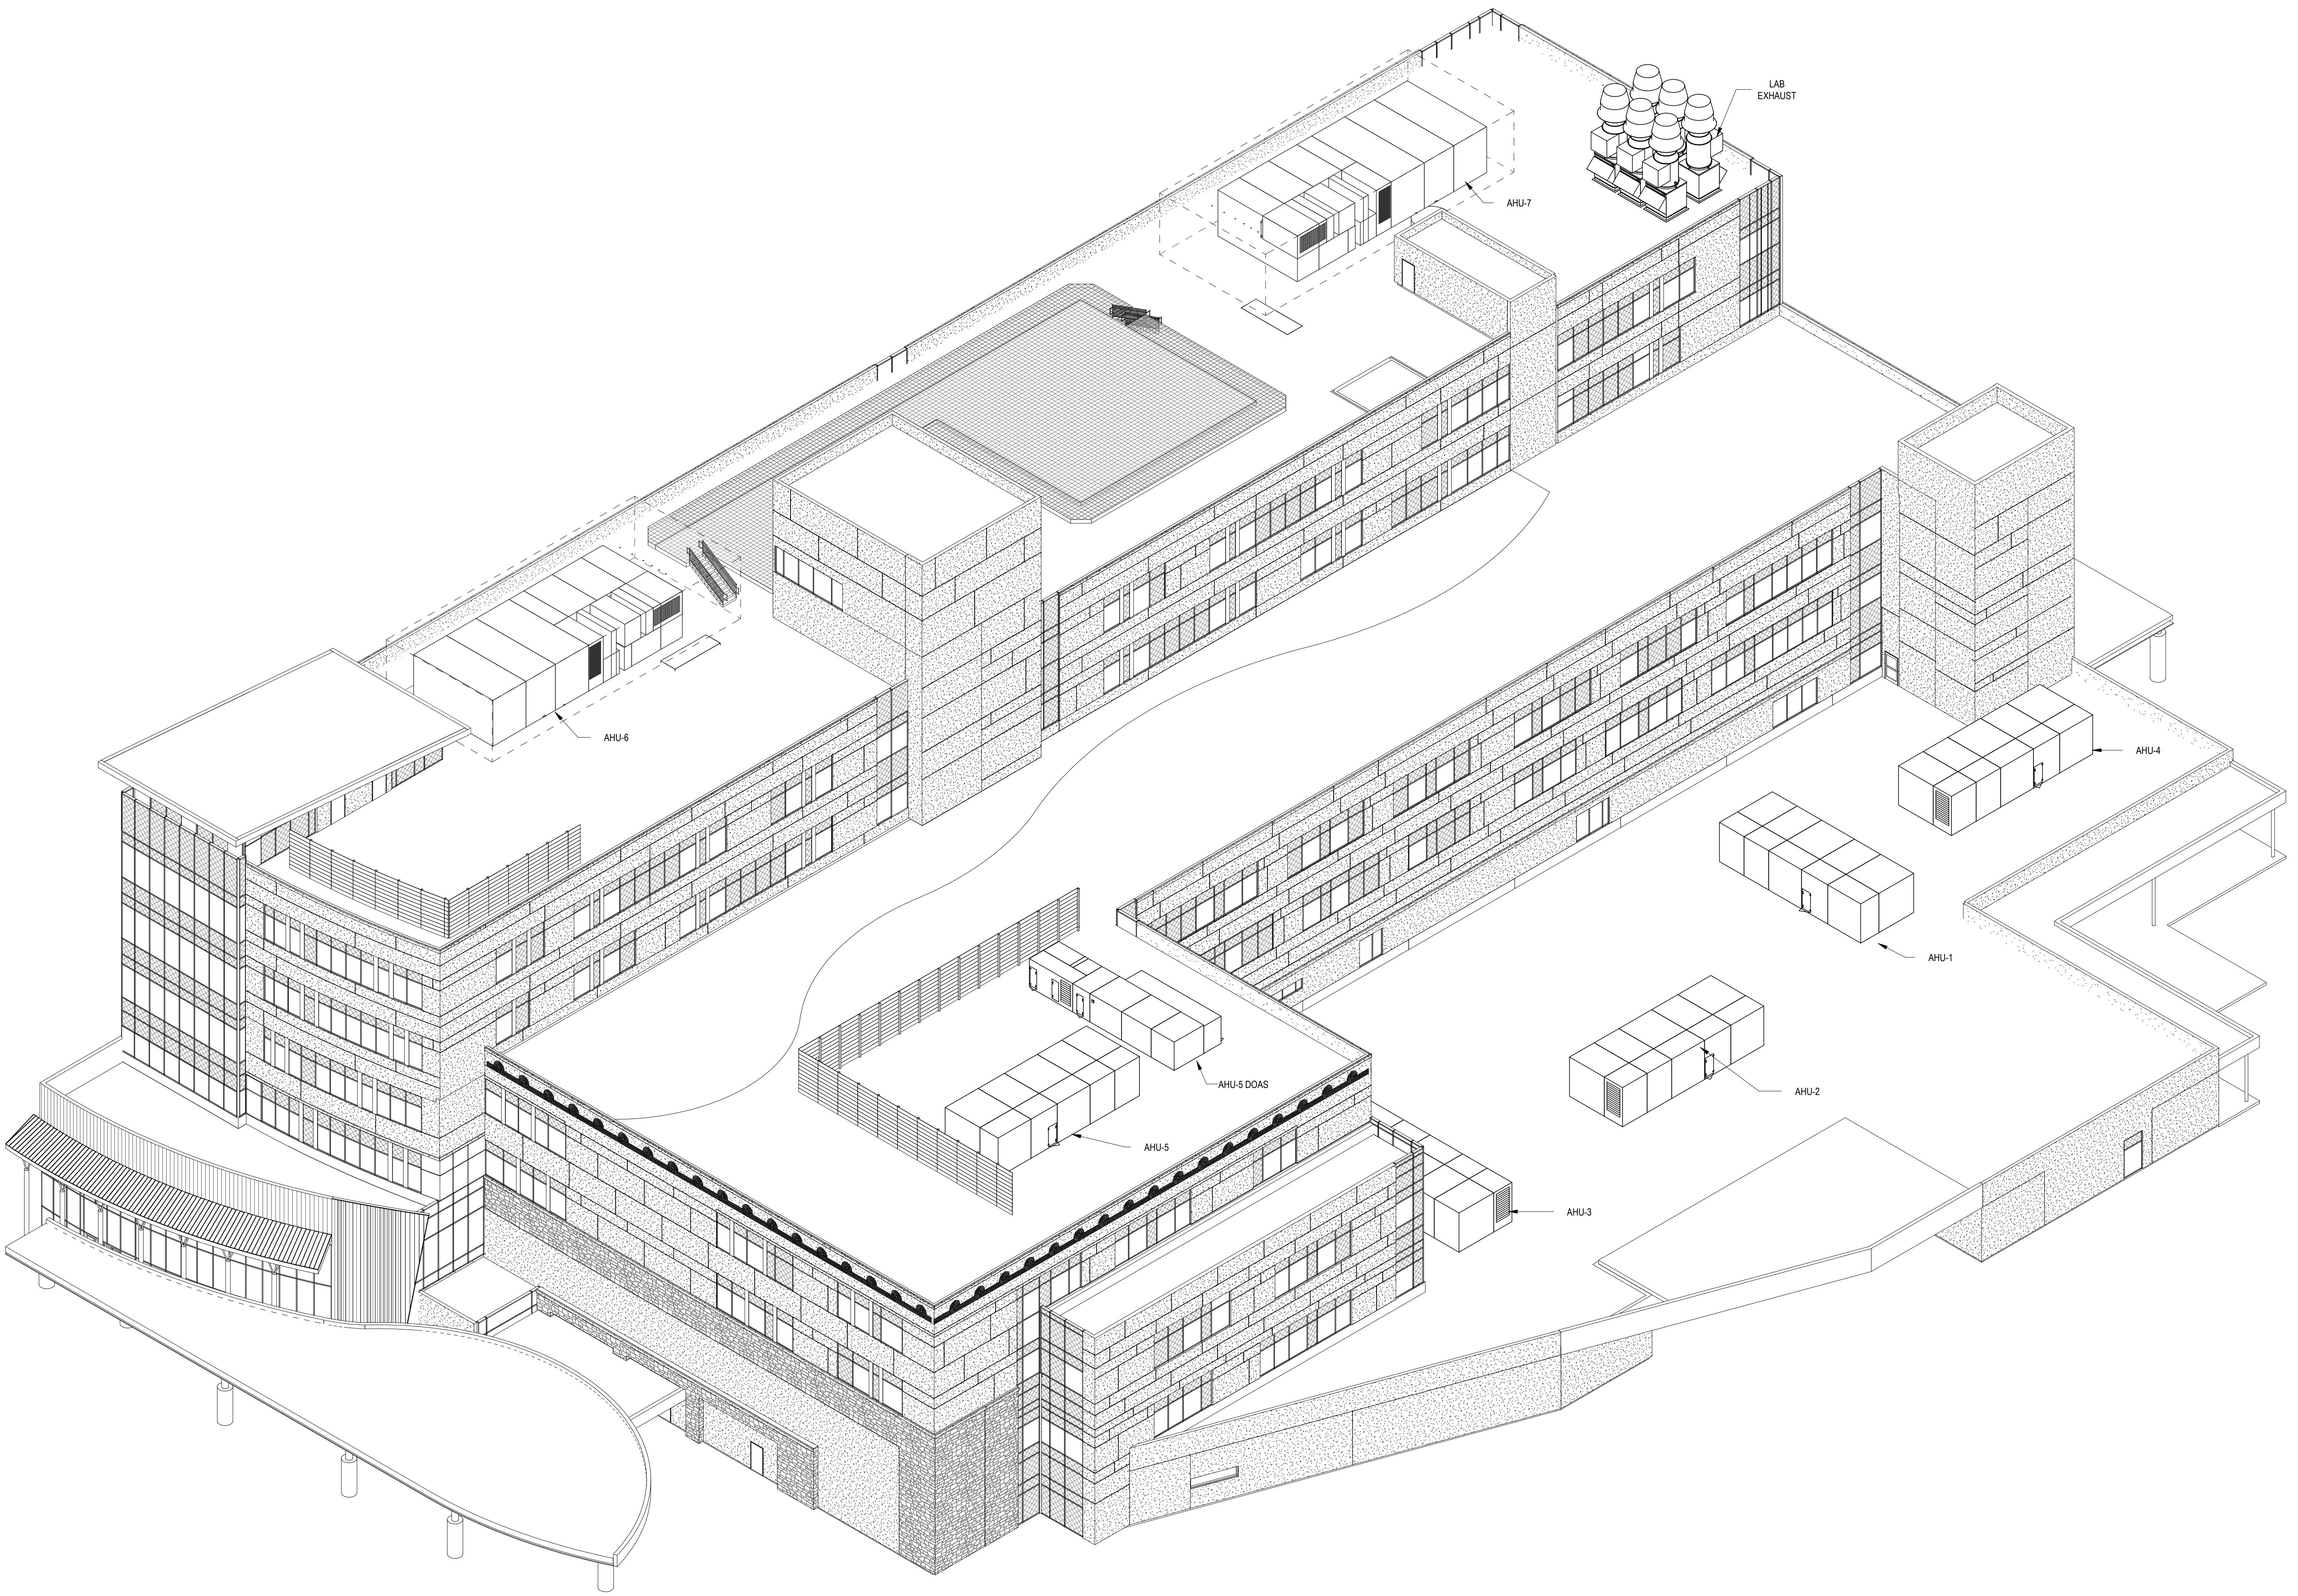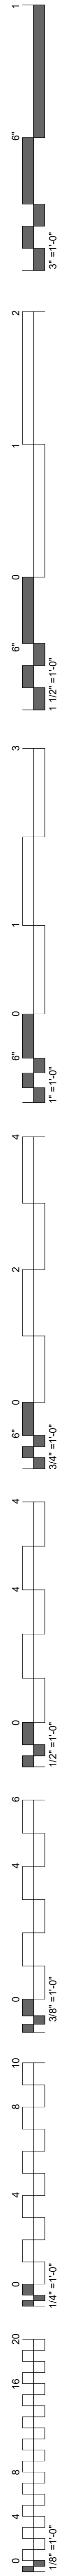

1 SD AHU LOCATIONS

**CHEROKEE NATION
W.W. HASTINGS REPLACEMENT HOSPITAL**
TAHLEQUAH, OKLAHOMA

#	DATE	REVISIONS DESCRIPTION