



PLANS FOR

2 BEDROOM ADA WITH SIDING 1091 SQUARE FOOT

SHEET INDEX

SHEET NO.	DESCRIPTION
A101	TITLE SHEET
A102	FLOOR PLAN
A103	CABINET ELEV./HVAC CLOSET FRAMING
A104	FOUNDATION PLAN
A105	FOUNDATION PLAN DETAILS/WALL SECTION DETAIL
A106	ELEVATIONS - GABLE
M101	HVAC PLANS
P101	WASTE AND VENT PLUMBING PLANS
P102	DOMESTIC WATER PLANS
E101	ELECTRICAL PLAN



ENGINEER
 KAS Gales Company
 Consulting Engineers
 18772 Harmon Road
 Fayetteville, AR 72704
 Wk. 479.361.9977 Cell 479.422.0763
 Email: carl.d.gales@gmail.com

Cherokee Nation
 2 Bedroom Title Sheet
 1091 Square Feet

CLIENT: Cherokee Nation
 Housing Authority


DESIGNED BY	APPROVED BY:
DRAWN BY:	DATE PREPARED:
MBD	MM, 2022

A101
 SHEET NO.

NO REVISION




DATE BY


1091 SQ. FEET

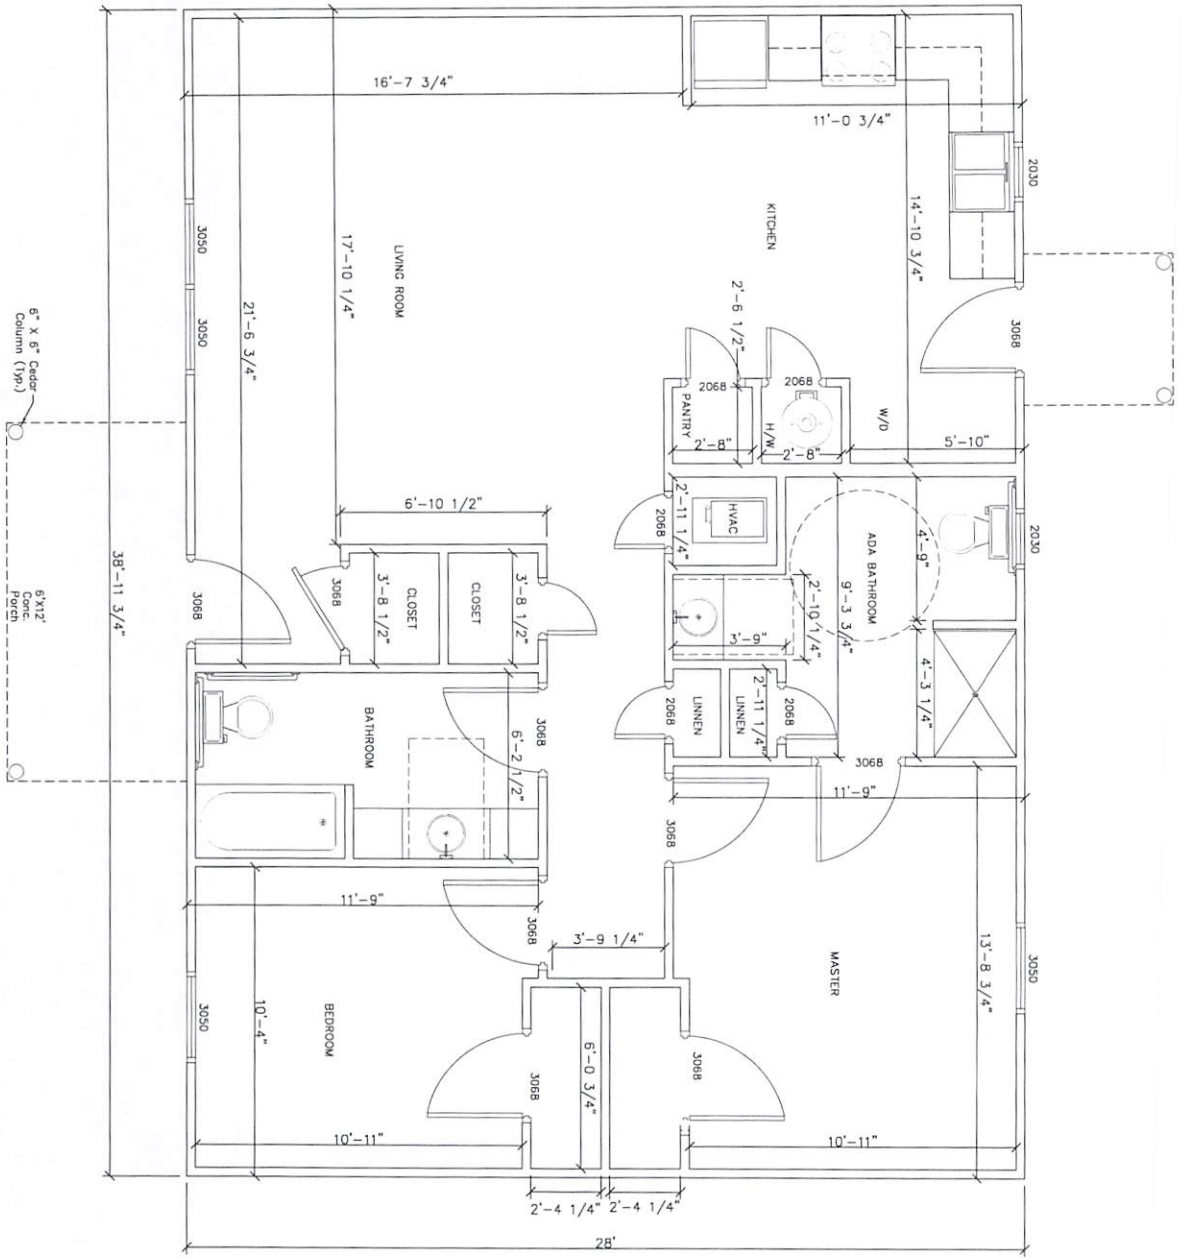


SCALE
1/2" = 1'

<p>A102 SHEET NO.</p>		<p>Cherokee Nation 2 Bedroom Floor Plan 1091 Square Feet</p>		<p>ENGINEER KAS Gales Company Consulting Engineers 18772 Harmon Road Fayetteville, AR 72704 Wk. 479.361.9977 Cell 479.422.0763 Email: carl.d.gales@gmail.com</p>	
<p>CLIENT: Cherokee Nation Housing Authority</p>		<p>DESIGNED BY</p>	<p>APPROVED BY</p>	<p>DATE PREPARED</p>	
<p>NO.</p>	<p>REVISION</p>	<p>DATE</p>	<p>BY</p>	<p>DRAWN BY:</p>	<p>Mo. 2022</p>

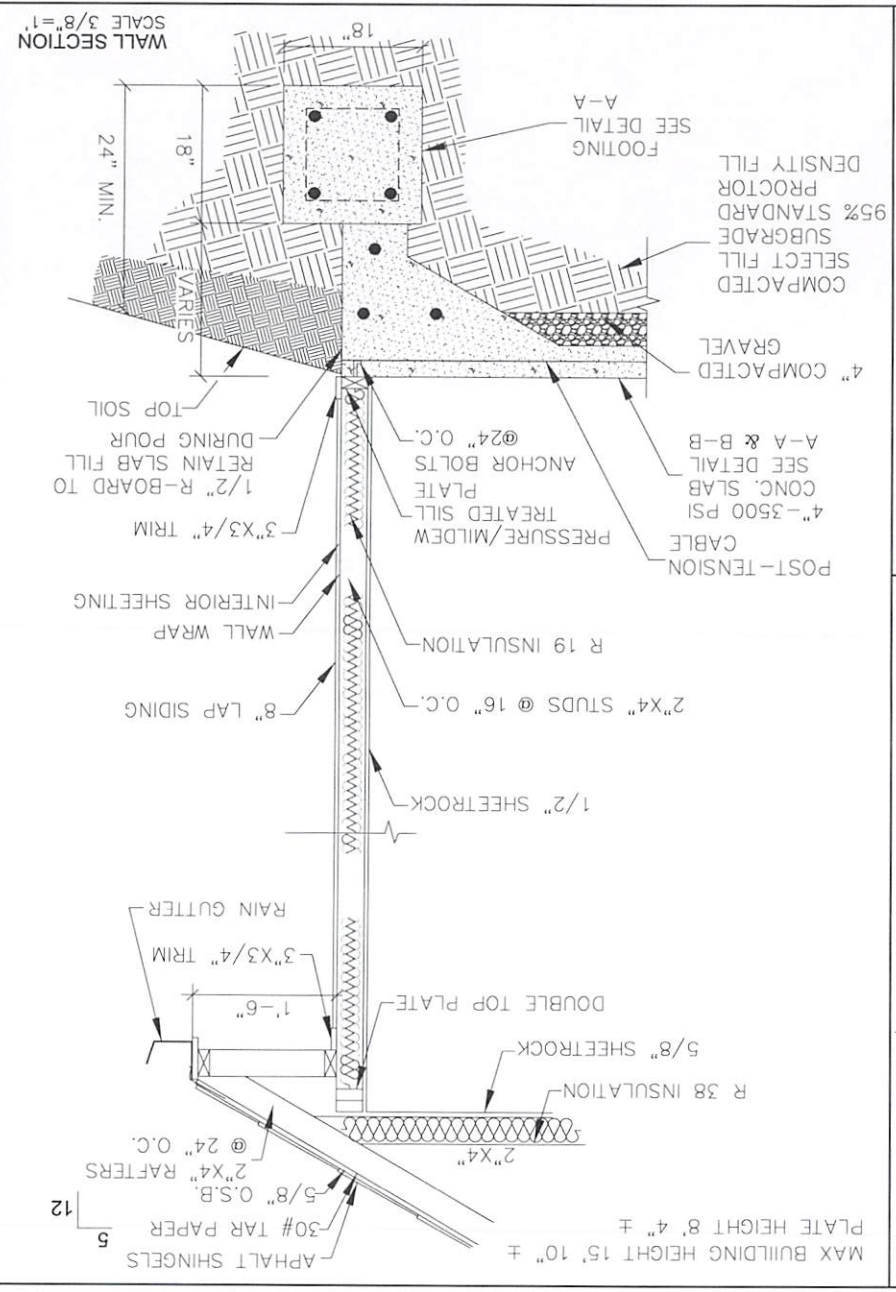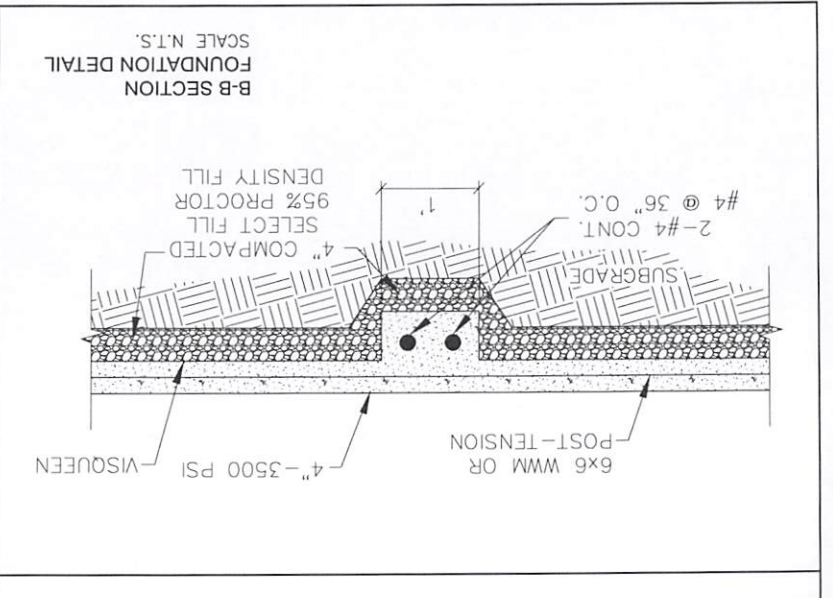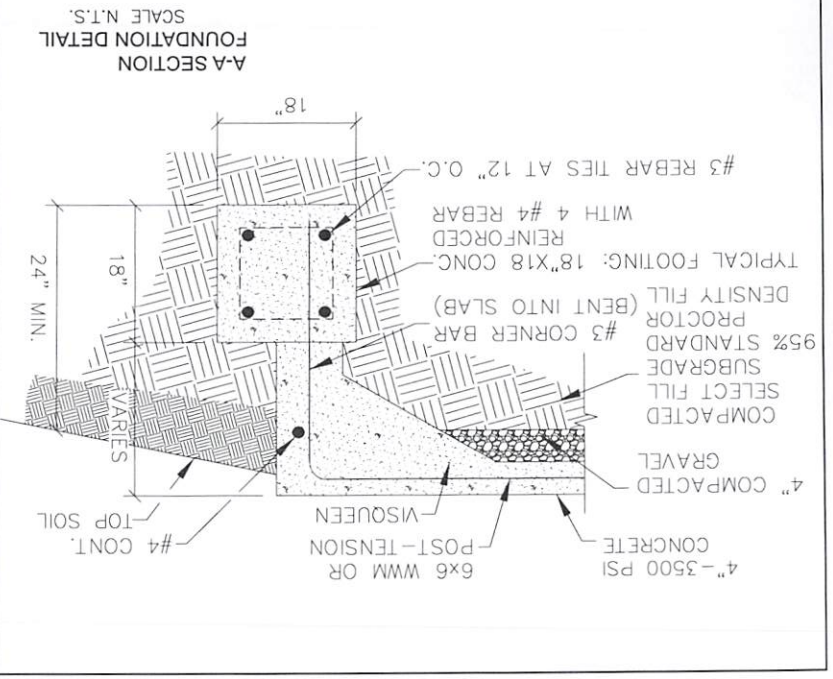

SHEET NO. A105		DATE		BY		DRAWN BY		CHECKED		APPROVED	
NO.	REVISION	DATE	BY	DATE	BY	DATE	BY	DATE	BY	DATE	BY
Cherokee Nation 2 Bedroom Foundation Details 1091 Square Feet		CLIENT: Cherokee Nation Housing Authority									
ENGINEER KAS Gales Company Consulting Engineers 10722 Hammer Road Suite 200 NW, 479 361 9977 Cell 419 422 0763 Email: cam.d.gales@gmail.com											

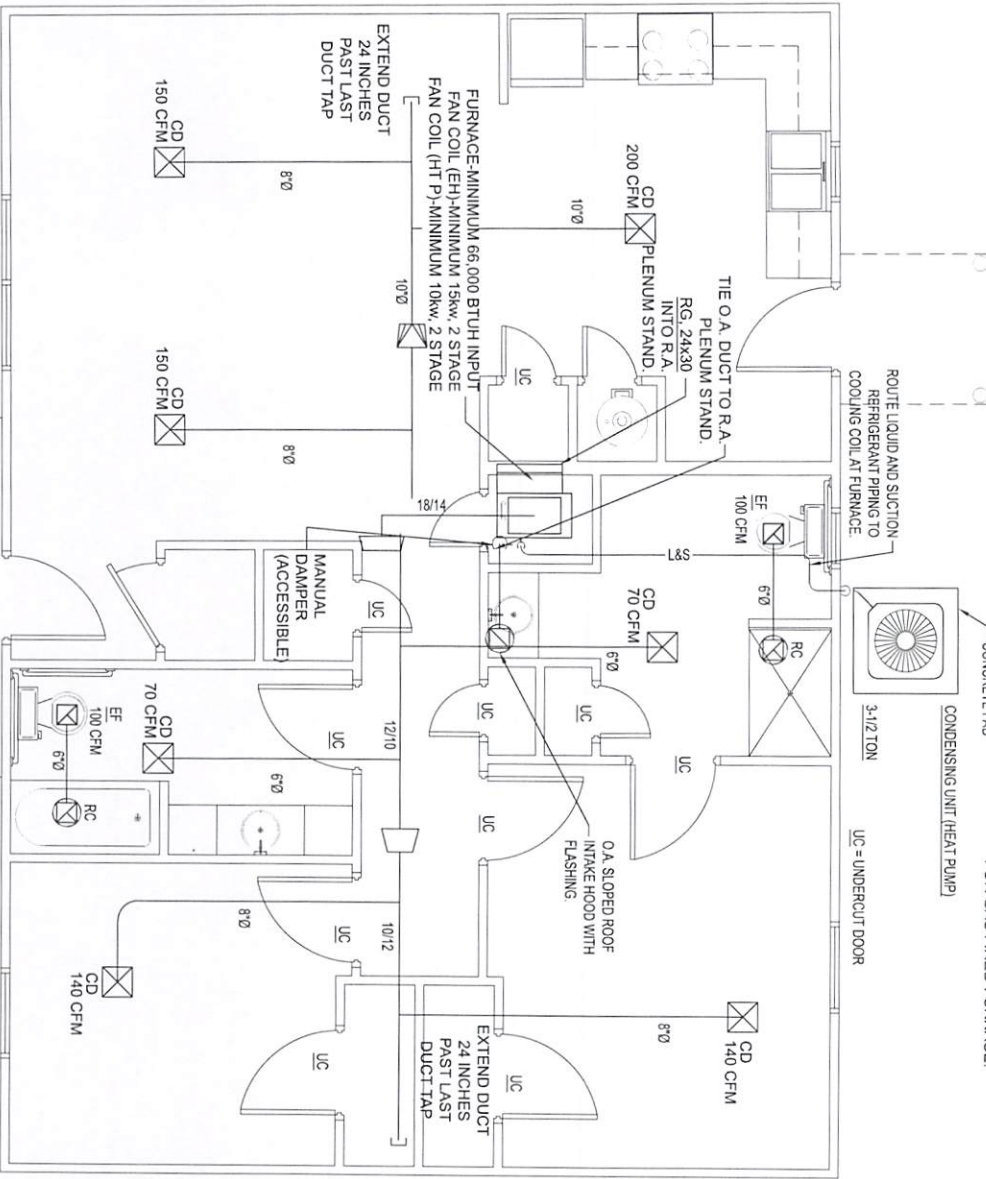

- AIR DEVICES - HART & COOLEY OR EQUAL**
- CEILING DIFFUSERS TYPE 500**
- 6x6 75 CFM OR LESS
 - 8x8 75-120 CFM
 - 10x10 120-175 CFM
 - 12x12 175-300 CFM
- SIDEWALL FURNACE (FAN COIL) RETURN GRILLE**
- TYPE 672
- 30x12 800 CFM (2T)
 - 30x18 1200 CFM (3T)
 - 30x24 1600 CFM (4T)

- NOTE:**
1. VERIFY HEAT SOURCE WITH CONSTRUCTOR (GAS, ELECTRIC RESISTANCE, OR AIR TO AIR HEAT PUMP)
 2. HEAT PUMP FAN COIL UNITS TO BE PROVIDED WITH SUPPLEMENTAL ELECTRIC HEATER, (SIZED TO PROVIDE SUPPLY AIR TEMPERATURE ABOVE 95°F WITH HEAT PUMP OPERATION AT 0°F OUTSIDE AIR TEMPERATURE.)
 3. PROVIDE FLUE AND COMBUSTION AIR DUCTING FOR GAS FIRED FURNACE.

SCALE
1/2" = 1'

Cherokee Nation
2 Bedroom HVAC Plans
1091 Square Feet


CLIENT: Cherokee Nation
Housing Authority



ENGINEER
KAS Gales Company
Consulting Engineers
18772 Harmon Road
Fayetteville, AR 72204
Wk. 479.351.9977 Cell 479.422.0763
Email: carl.d.gales@gmail.com

DESIGNED BY:	APPROVED BY:
DRAWN BY:	DATE PREPARED:
DATE	BY
NO	REVISION

M101
SHEET NO.

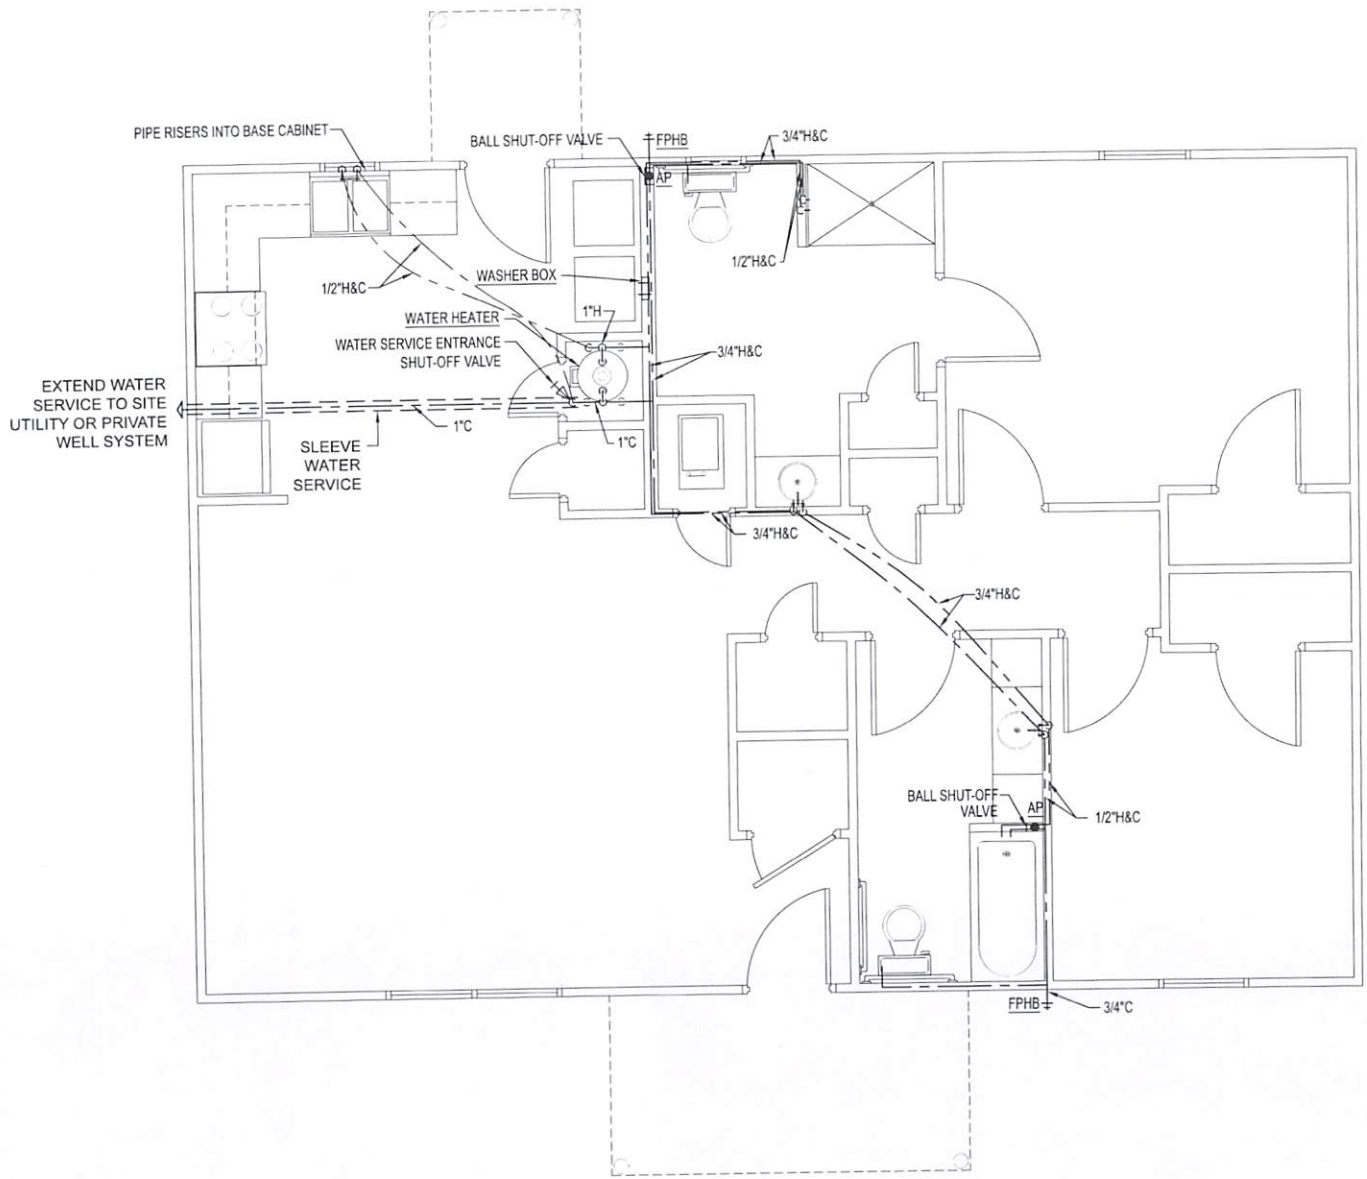

EXTEND WATER SERVICE TO SITE UTILITY OR PRIVATE WELL SYSTEM

SCALE
1/2" = 1'

ENGINEER
KAS Gales Company
Consulting Engineers
18727 Hummer Road
Fayetteville, AR 72704
Wk. 479.361.9977 Cell 479.422.0763
Email: carl.gales@gmail.com



Cherokee Nation
2 Bedroom Domestic Water
Plan
1091 Square Feet

CLIENT: Cherokee Nation
Housing Authority

NO.	REVISION	DATE	BY	DESIGNED BY	APPROVED BY:
					CSG
					DATE PREPARED
					NOV. 2022

P102
SHEET NO

