




4 ELEVATION

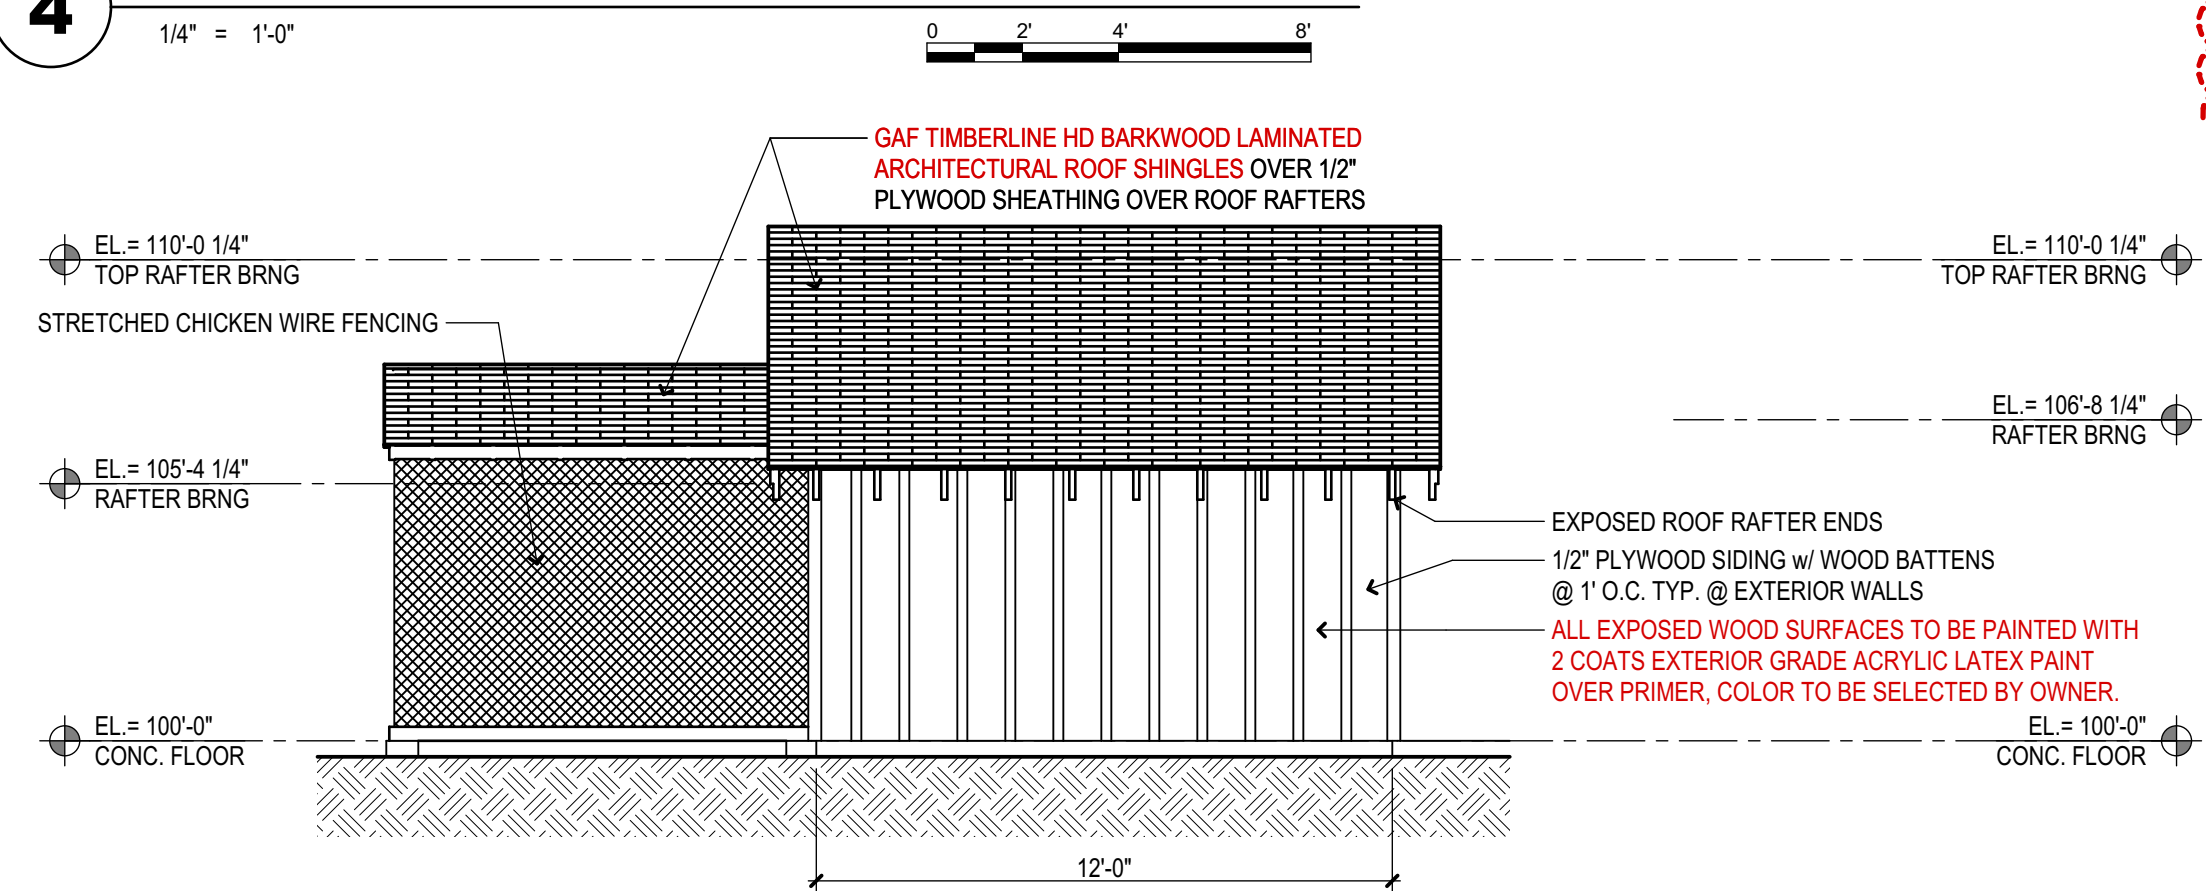


3 ELEVATION

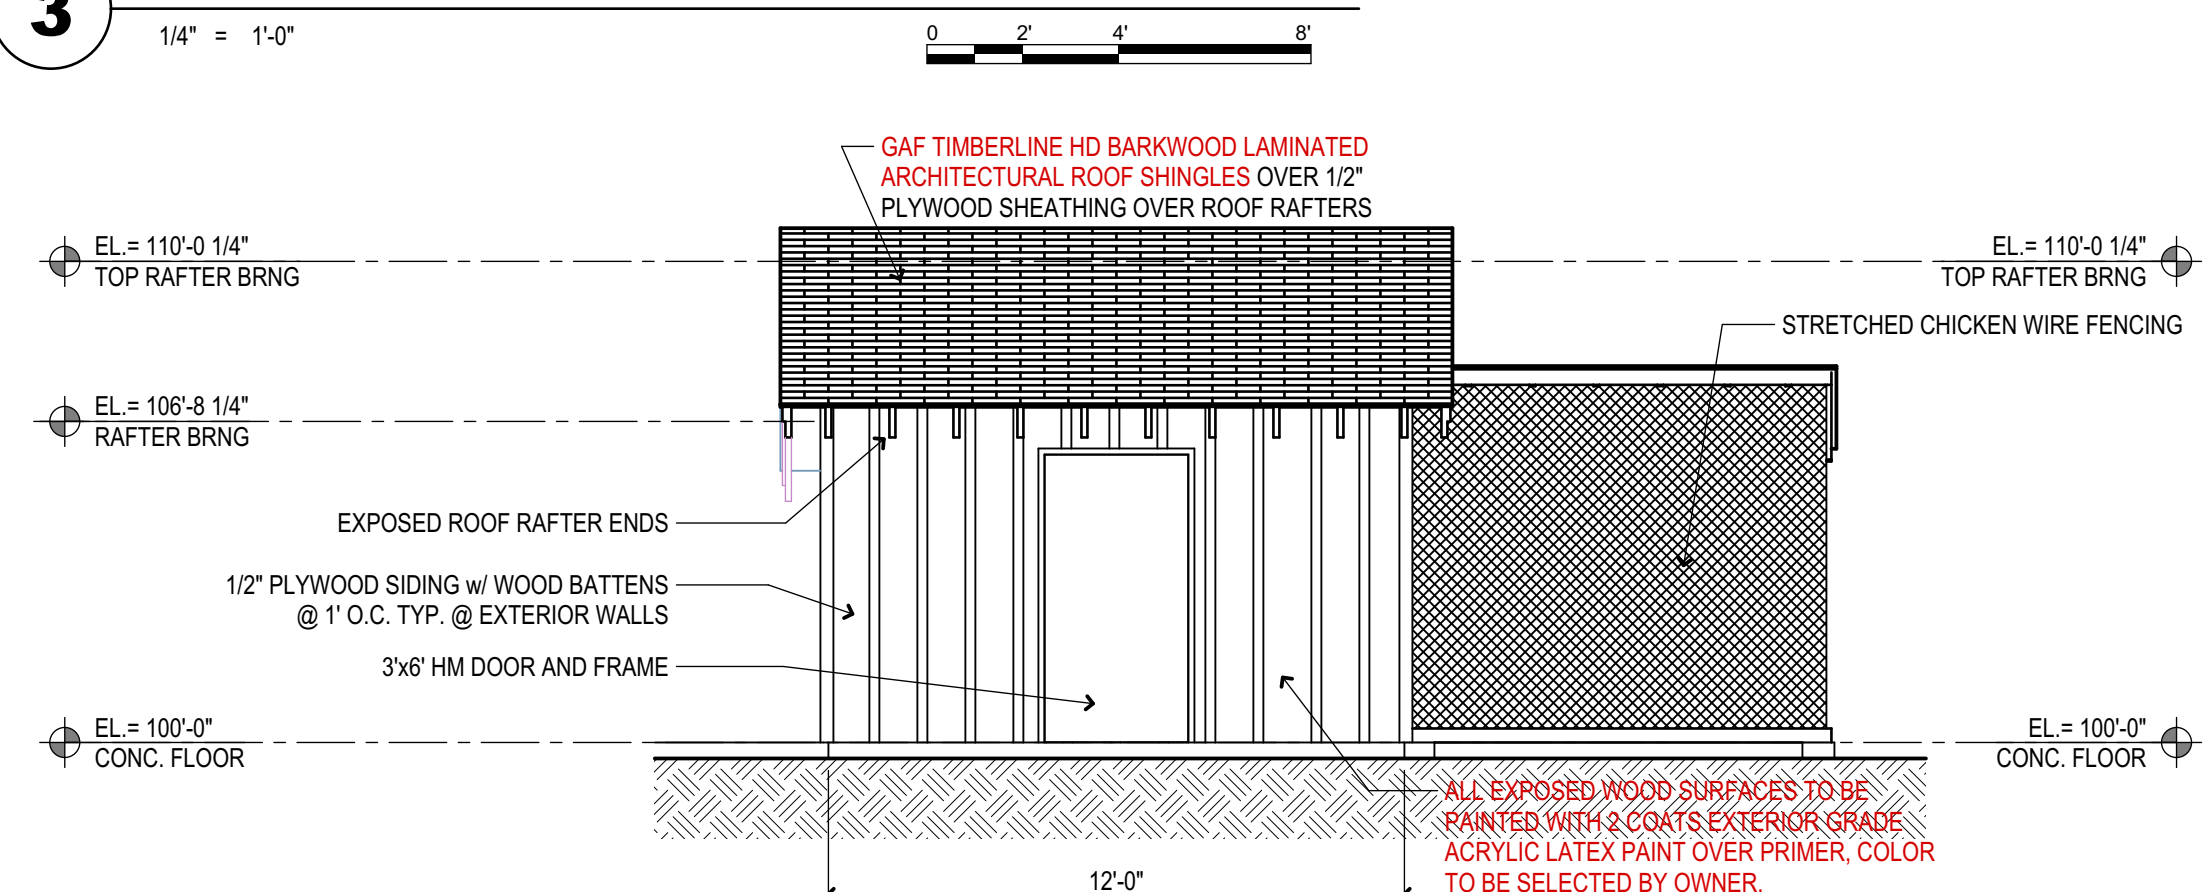

2 ELEVATION

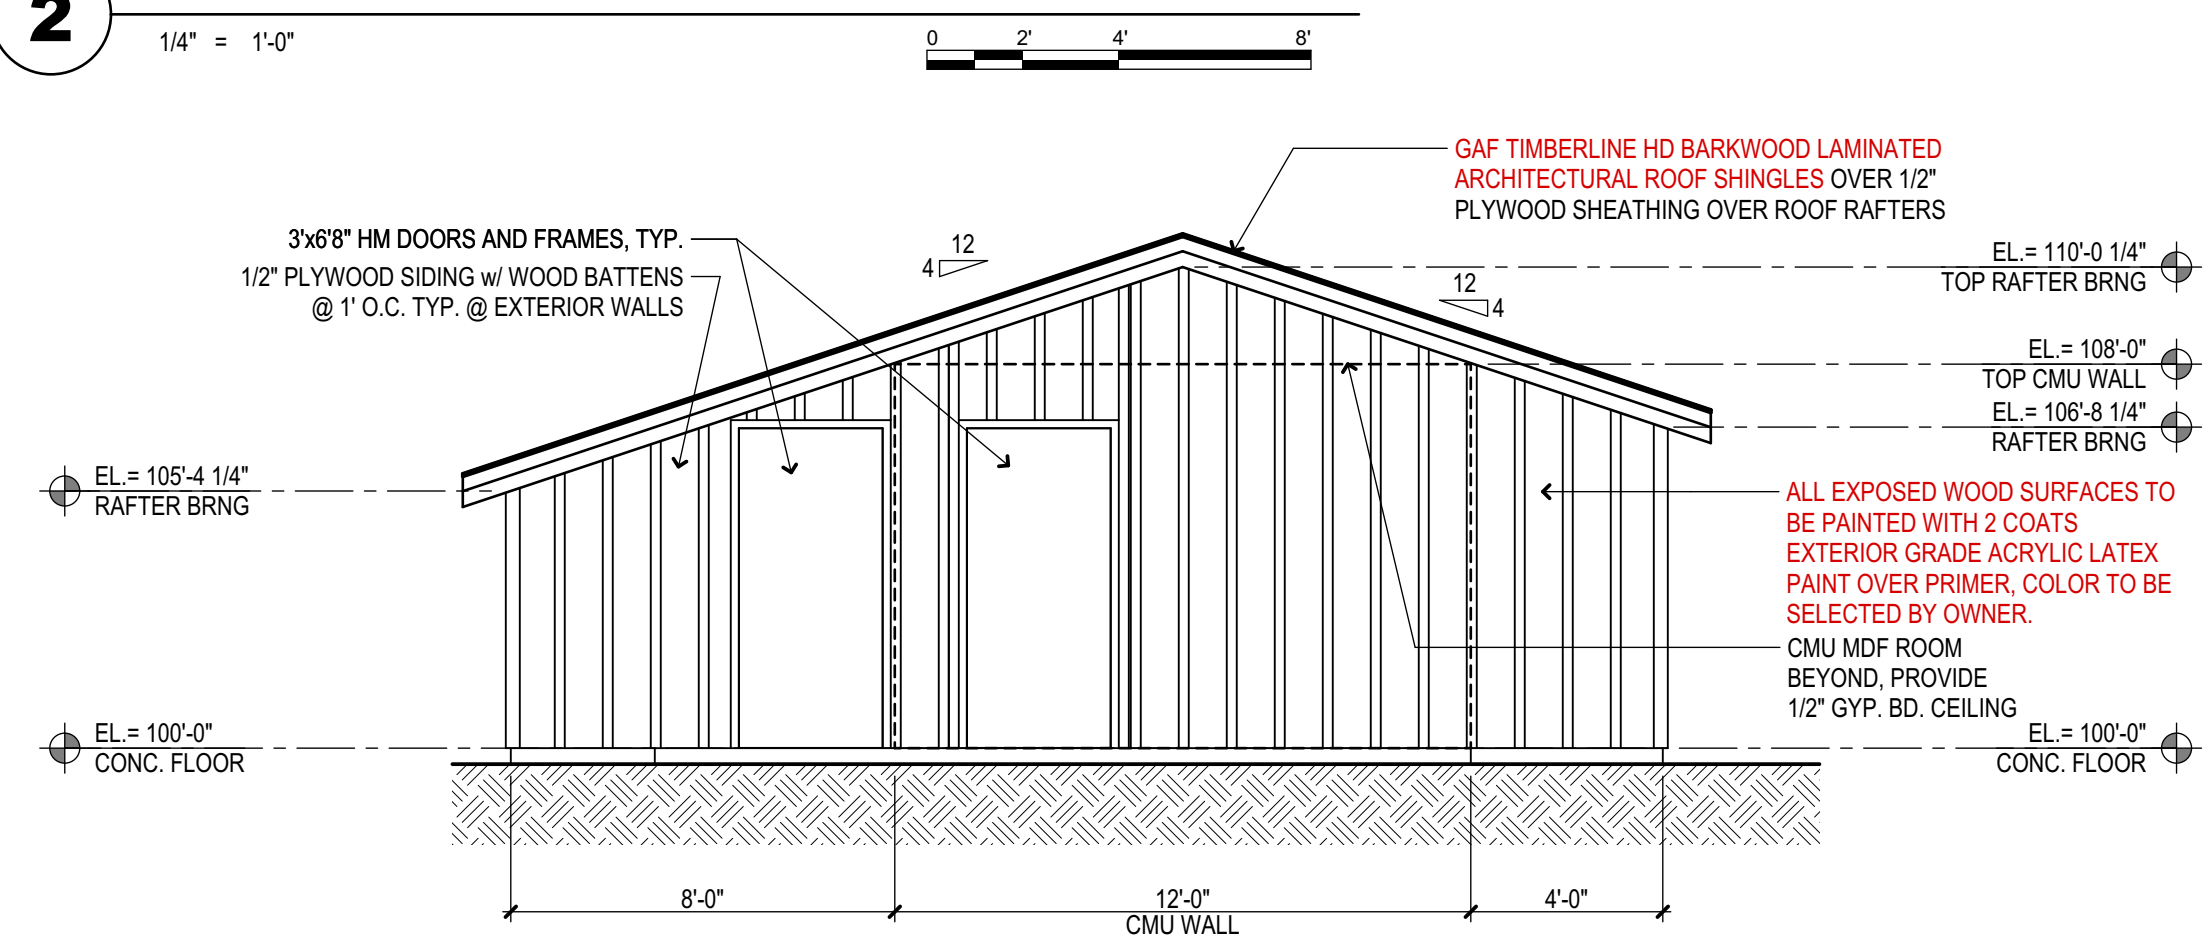

1 ELEVATION

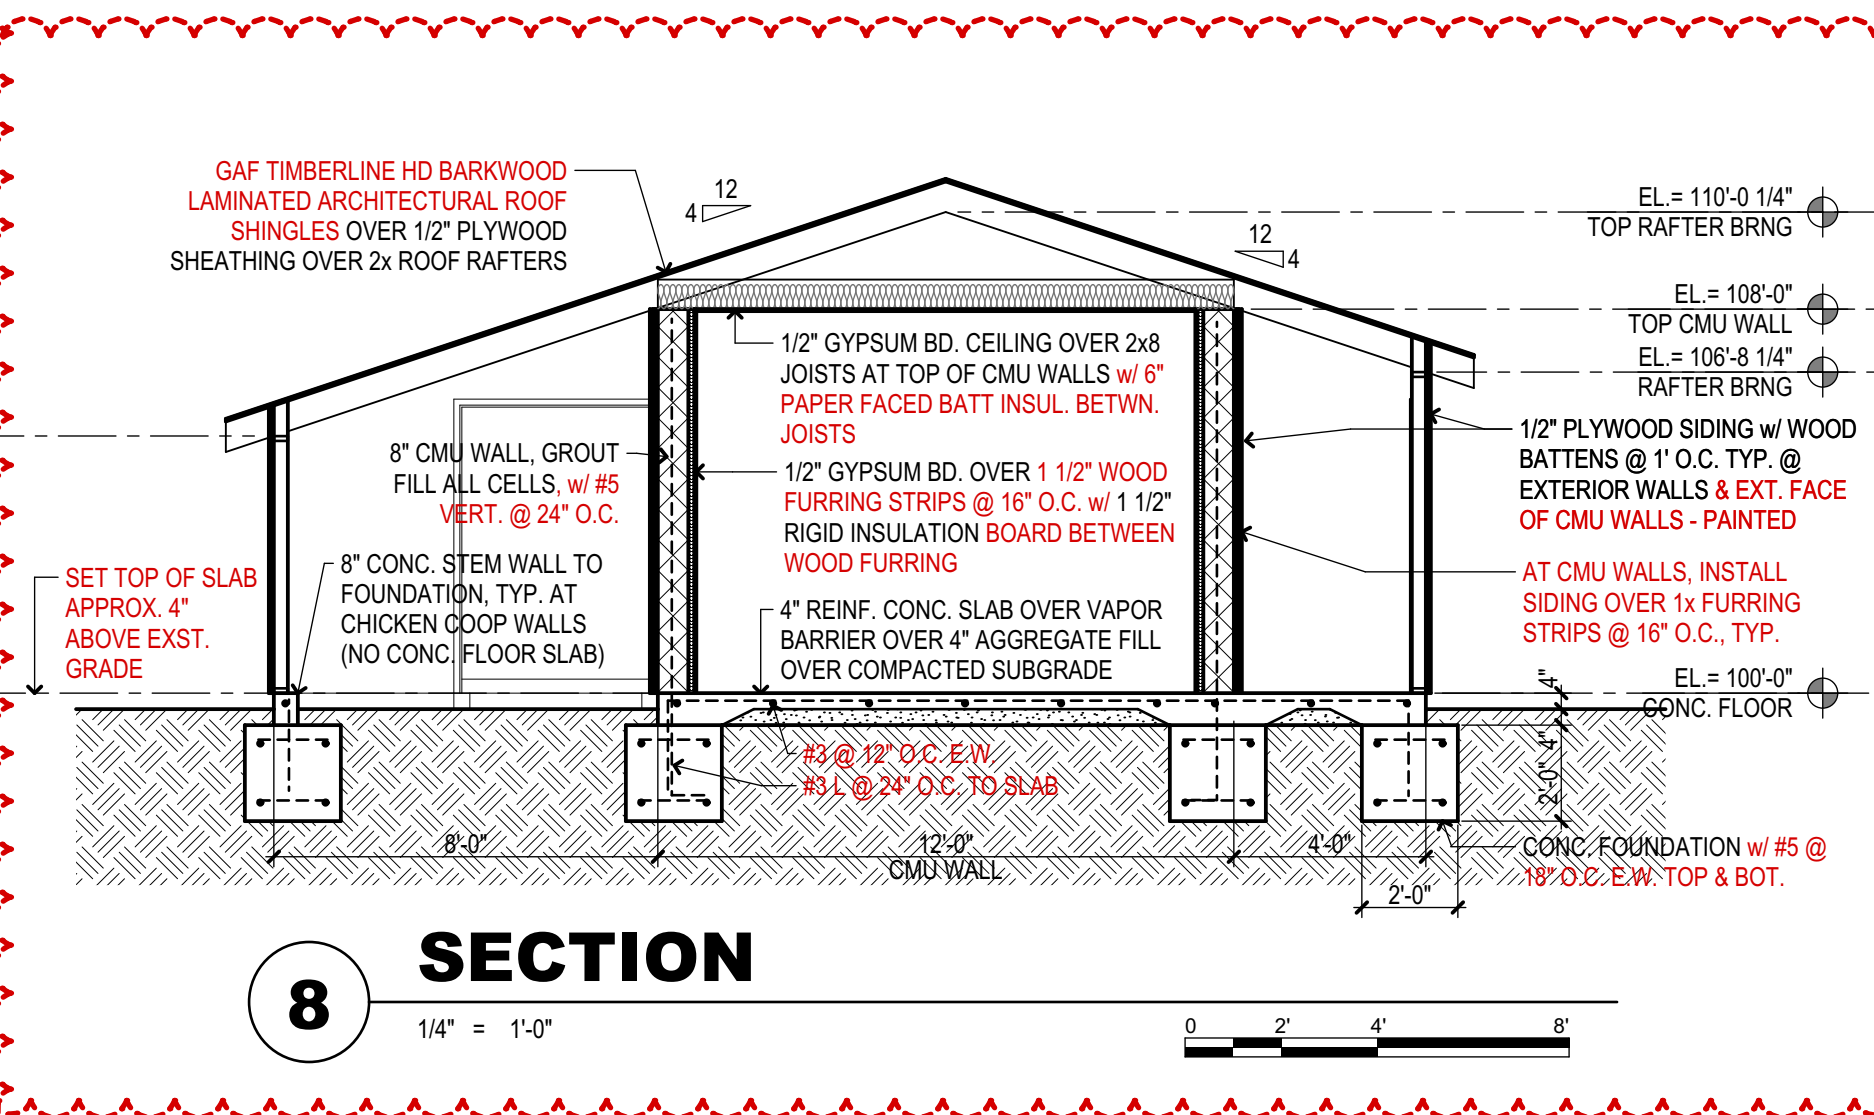

8 SECTION

ELECTRICAL SPECIFICATIONS:


RACEWAYS:
BUILDING: MC CABLE AND EMT WITH COPPER CONDUCTORS
EXTERIOR: LFMC WITH COPPER CONDUCTORS
UNDERGROUND: PVC SCHEDULE 40, DEPTH PER UTILITY CO. REQUIREMENTS

LIGHT FIXTURES:
'A' METALUX: 4ST2L4040R LED STRIP LIGHT, SURFACE MOUNT
'B' LUMARK: XTOR2B-W-PC1 LED EXTERIOR FLOOD WITH PHOTOCELL, +7'-6" AFG
'EM' SURE LITES: SEL2SR16SD, 90-MINUTE BATTERY BACKUP

PANELBOARD:
SQUARE-D TYPE '00' LOAD CENTER, 24 SPACES, 125A MCB, 120/240V WITH (1) 20A/2P AND (16) 20A/1P BREAKERS.

WIRING DEVICES:
DUPLICATION OUTLET: HUBBELL HEAVY-DUTY 20A GFCI DUPLICATION OUTLET. PROVIDE WHILE-IN-USE WEATHERPROOF COVER FOR EXTERIOR
SPECIAL OUTLET: COORDINATE WITH OWNER 20A OR 30A HEAVY-DUTY SIMPLEX OUTLETS FOR DATA RACKS
J-BOXES: 4" x 4" x 2-1/8" STEEL BOX WITH MUDPLATE FOR OUTLET TYPE
QUAZITE BOX: 3" x 2" WITH LOCKABLE COVER. DEPTH AS REQUIRED FOR INCOMING SERVICE


ENCLOSED SWITCH:
DISCONNECT: HEAVY-DUTY, NEMA 3R FUSED PER UNIT MANUFACTURER SPECIFICATIONS

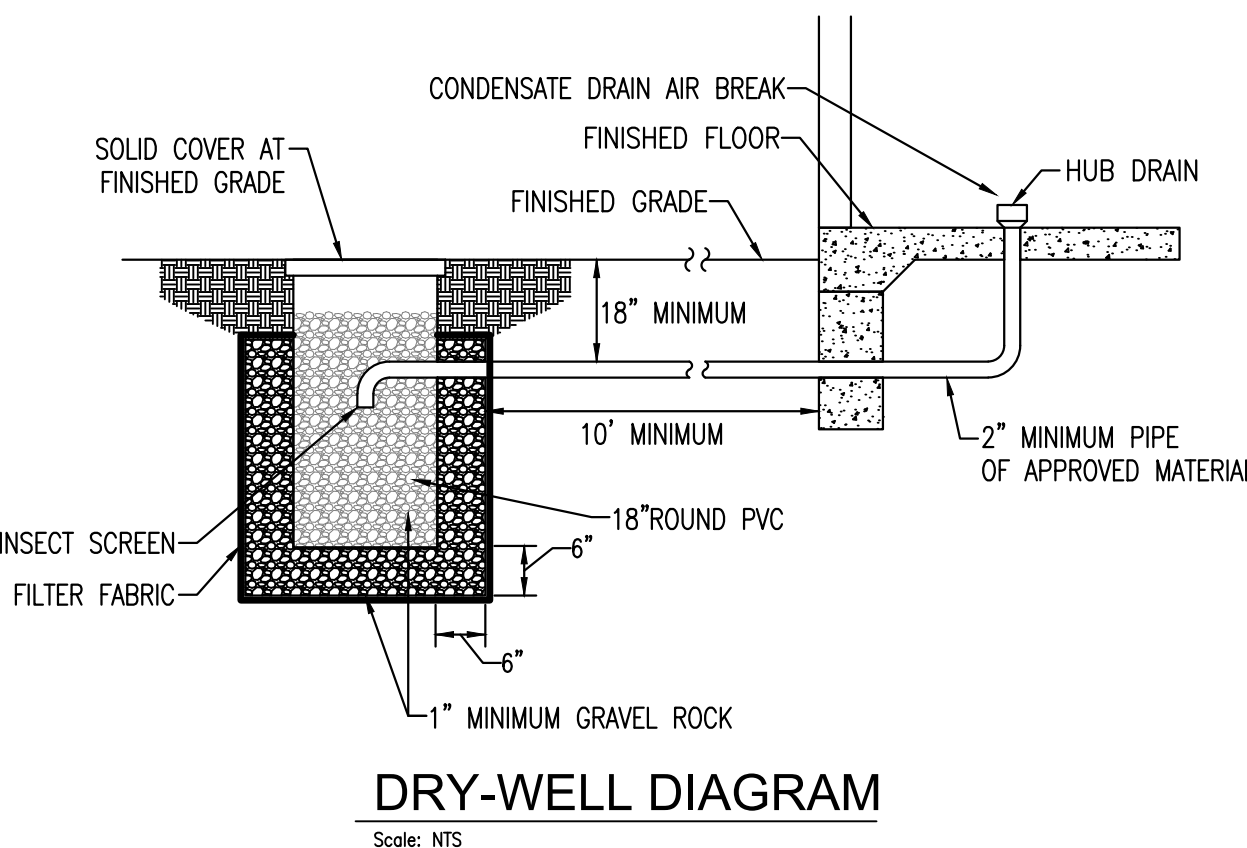


7 MEP SCHEDULES

KEYNOTES: (X)

- COORDINATE RACK TYPE WITH OWNER AND PROVIDE OUTLETS AND TERMINATION PER OWNER STANDARDS.
- INSTALL DRY WELL FOR CONDENSATE DRAIN FROM FC-1. REFER TO MEP SCHEDULES SHEET.
- INSTALL FAN COIL ON WALL WITH HARD WIRED THERMOSTAT. THERMOSTAT SHALL BE INSTALLED AT 48" AFF. FAN COIL POWERED FROM HPU-1. HPU-1 SHALL BE INSTALLED ON REINFORCED CONCRETE PAD A MINIMUM OF 4" ABOVE FINISHED GRADE. HPU-1 SHALL BE EQUAL TO LENNOX MLB009S4S, 208/1/60 WITH MCA OF 15 AMPS. FC-1 SHALL BE EQUAL TO LENNOX MMW00954 WITH HARD WIRED THERMOSTAT. SET CFM'S AT MEDIUM SPEED. INSTALL CONDENSATE PIPE FROM UNIT TO HUB DRAIN, SCHEDULE 40 PVC. INSULATE ALL CONDENSATE PIPE WITH VAPOR BARRIER INSULATION. TERMINATE AT HUB DRAIN WITH A MINIMUM 2" AIR GAP. SECURE TO WALL WITH PIPE CLAMPS.

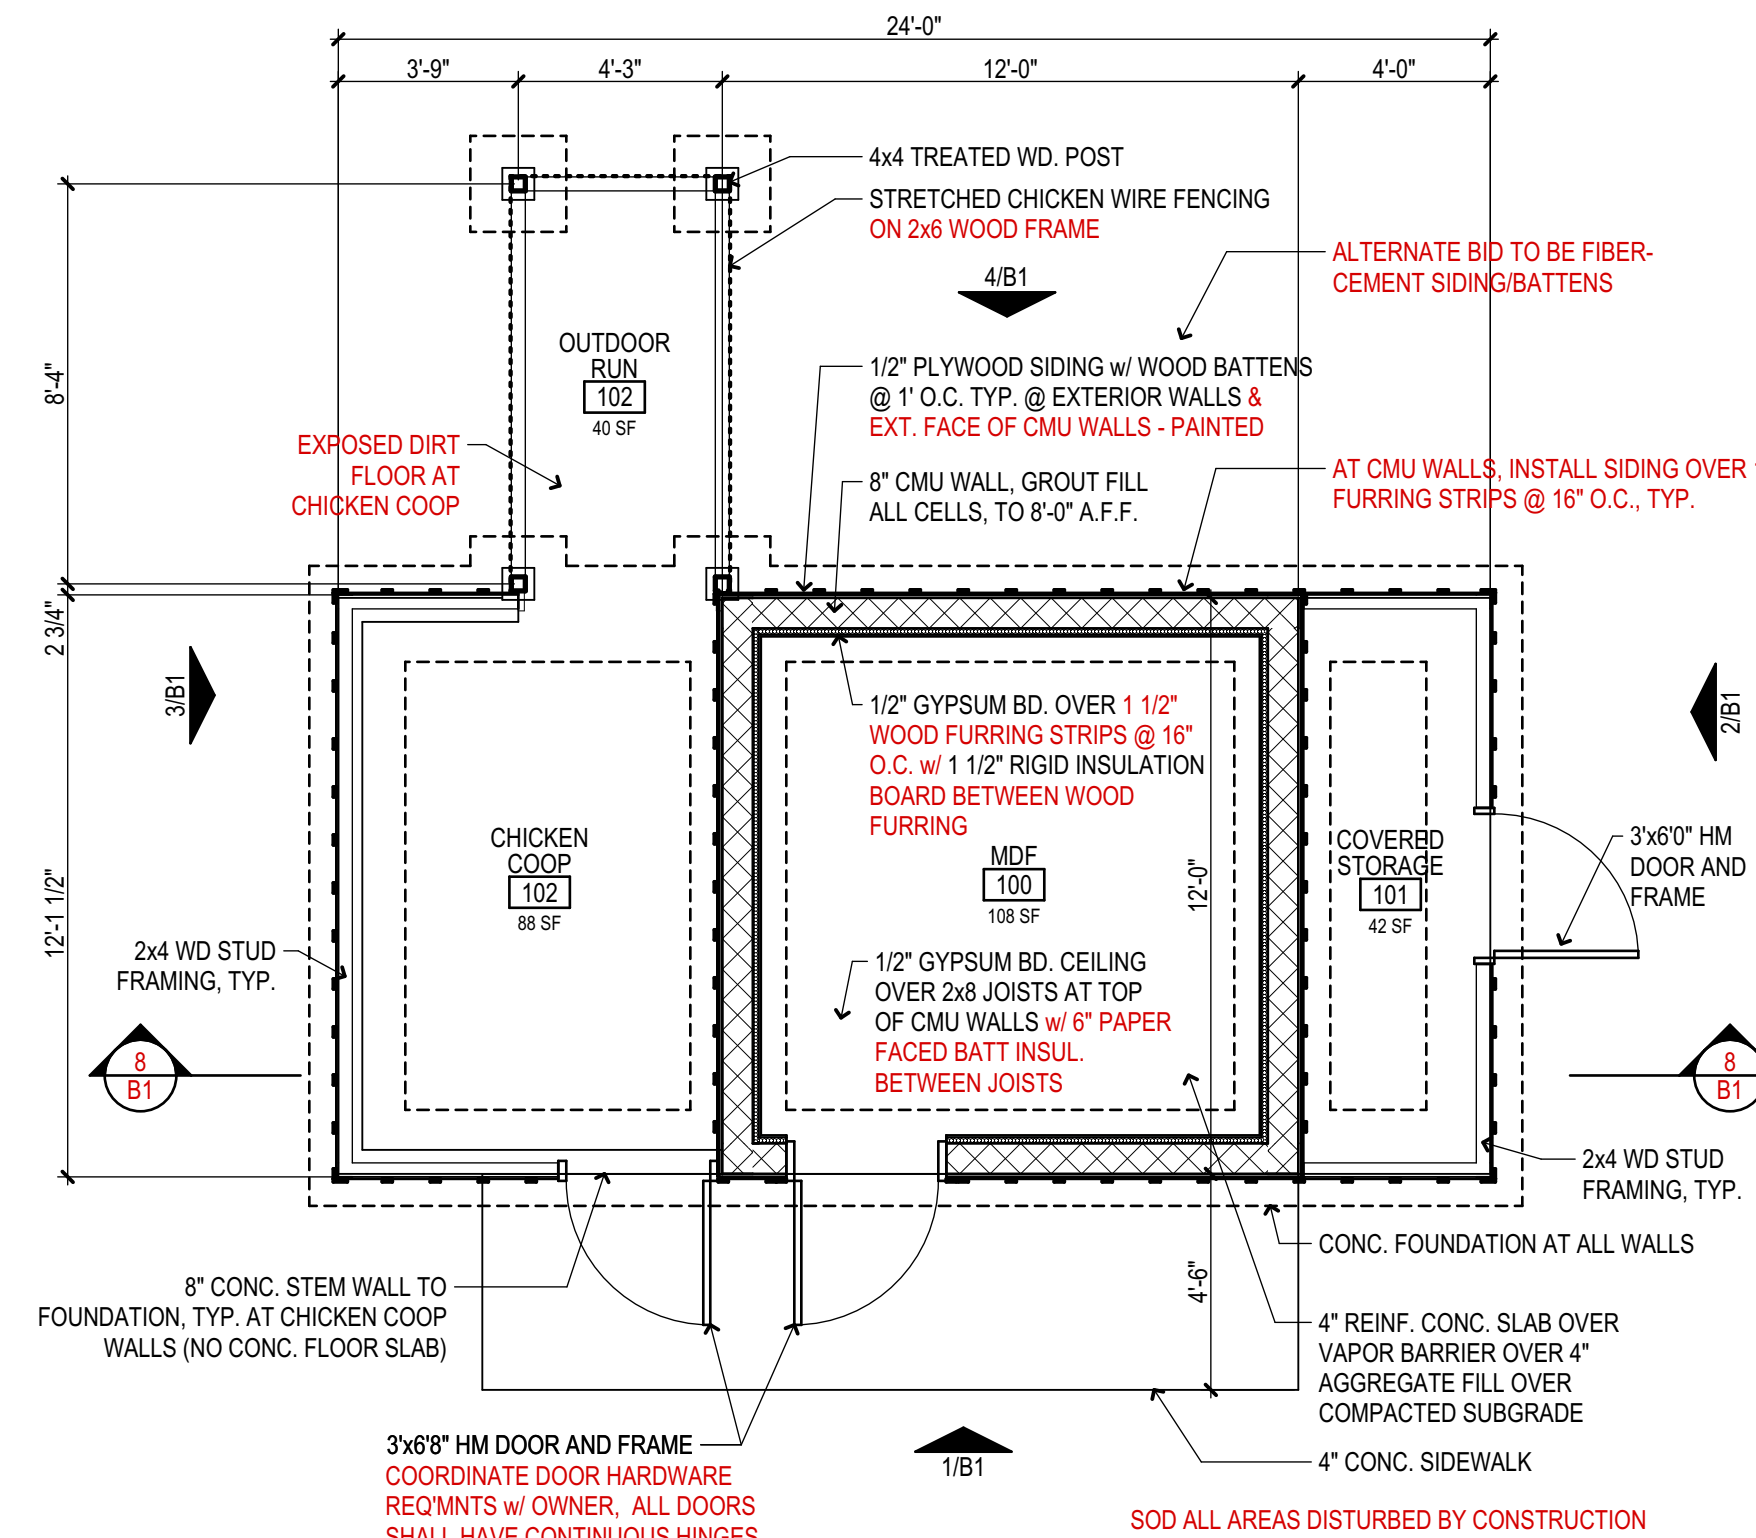

5 FLOOR PLAN

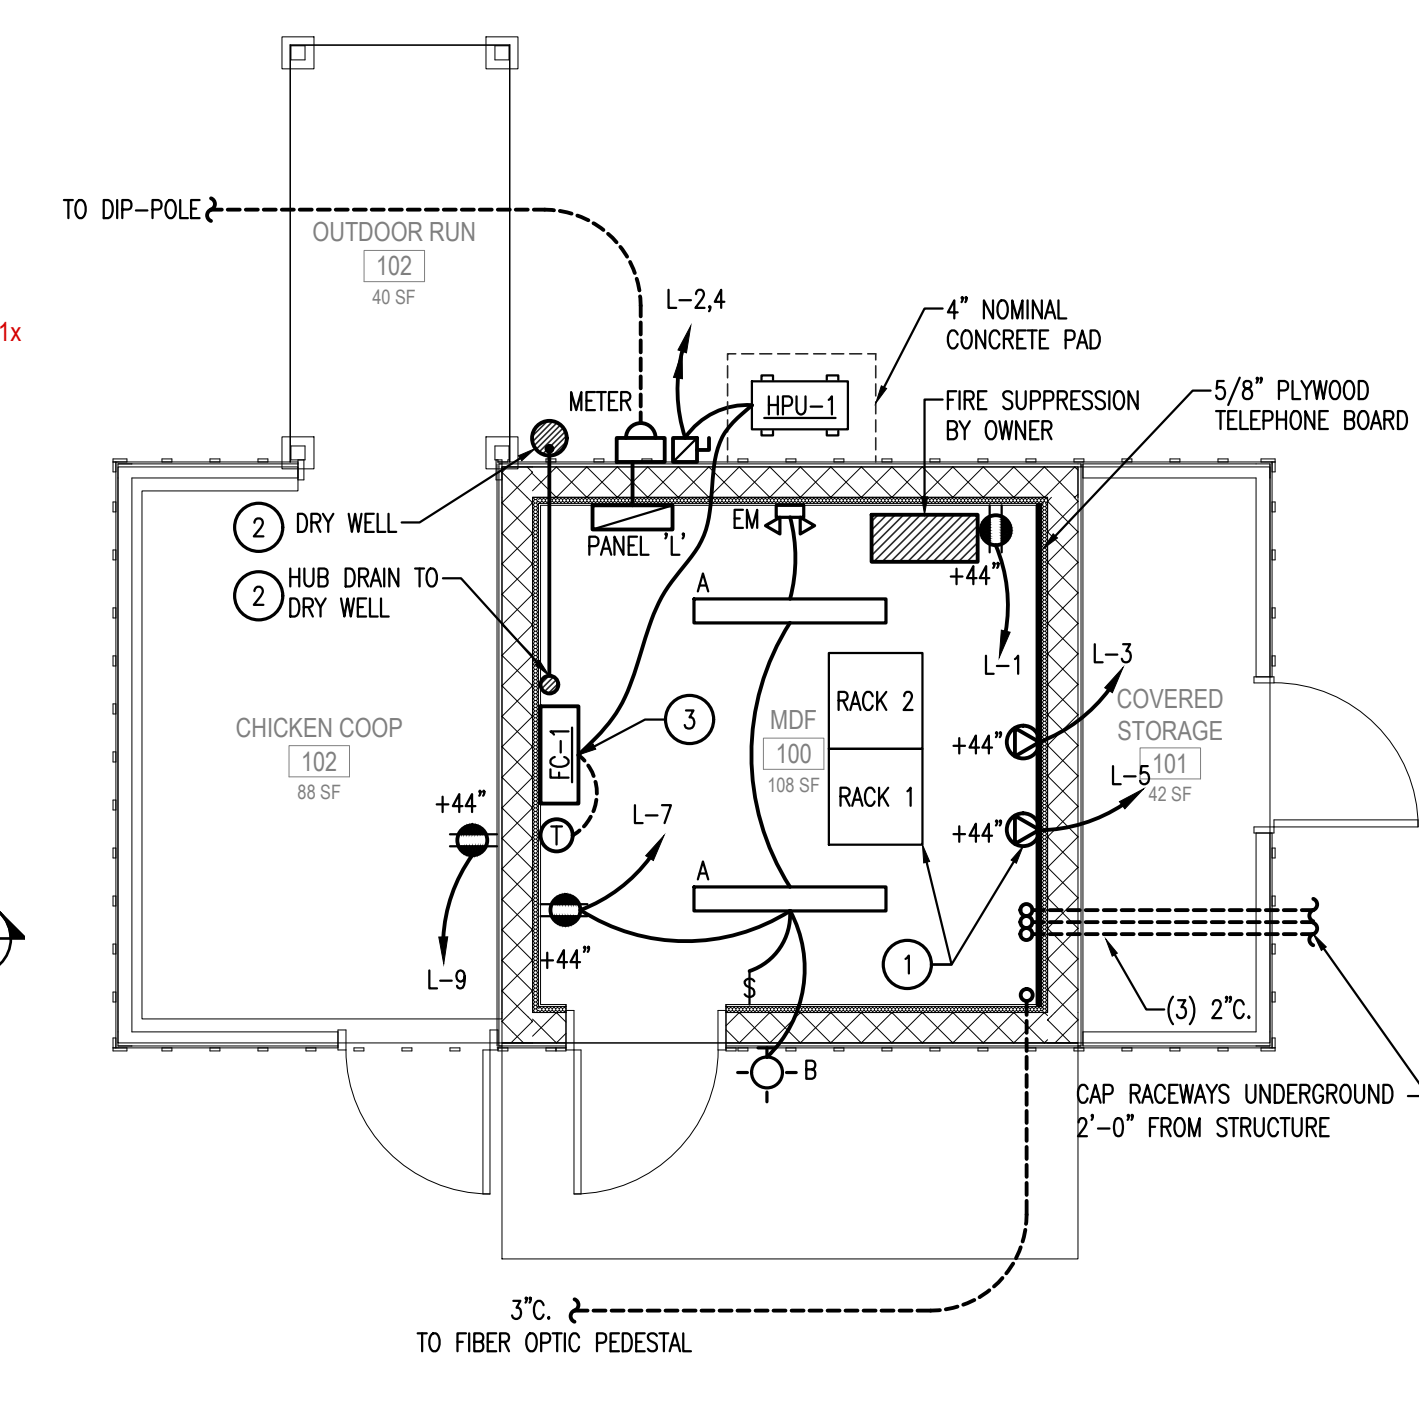

6 MEP PLAN

Revision Date	Revision
5-17-2023	ADDENDUM #1

Will Rogers Birth Place Home MDF BUILDING

Cherokee Nation Cultural Tourism LLC

PLANS AND ELEVATIONS

Drawn _____ Project Number _____

Checked _____

Scale _____ Issue Date _____

5/17/2023

Sheet Number

B1